

by _____ date _____

drawn _____



checked _____

revised _____

revised _____


project no. _____

sheet _____ set no. _____

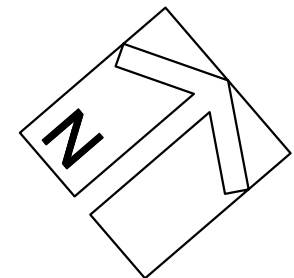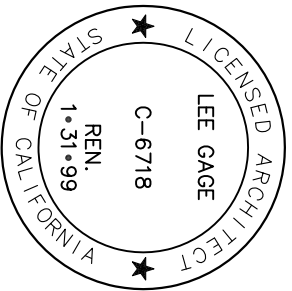

3rd & 4th FLOORS PLUMBING WATER PIPING FLOOR PLAN

SCALE: 1/8"=1'-0"

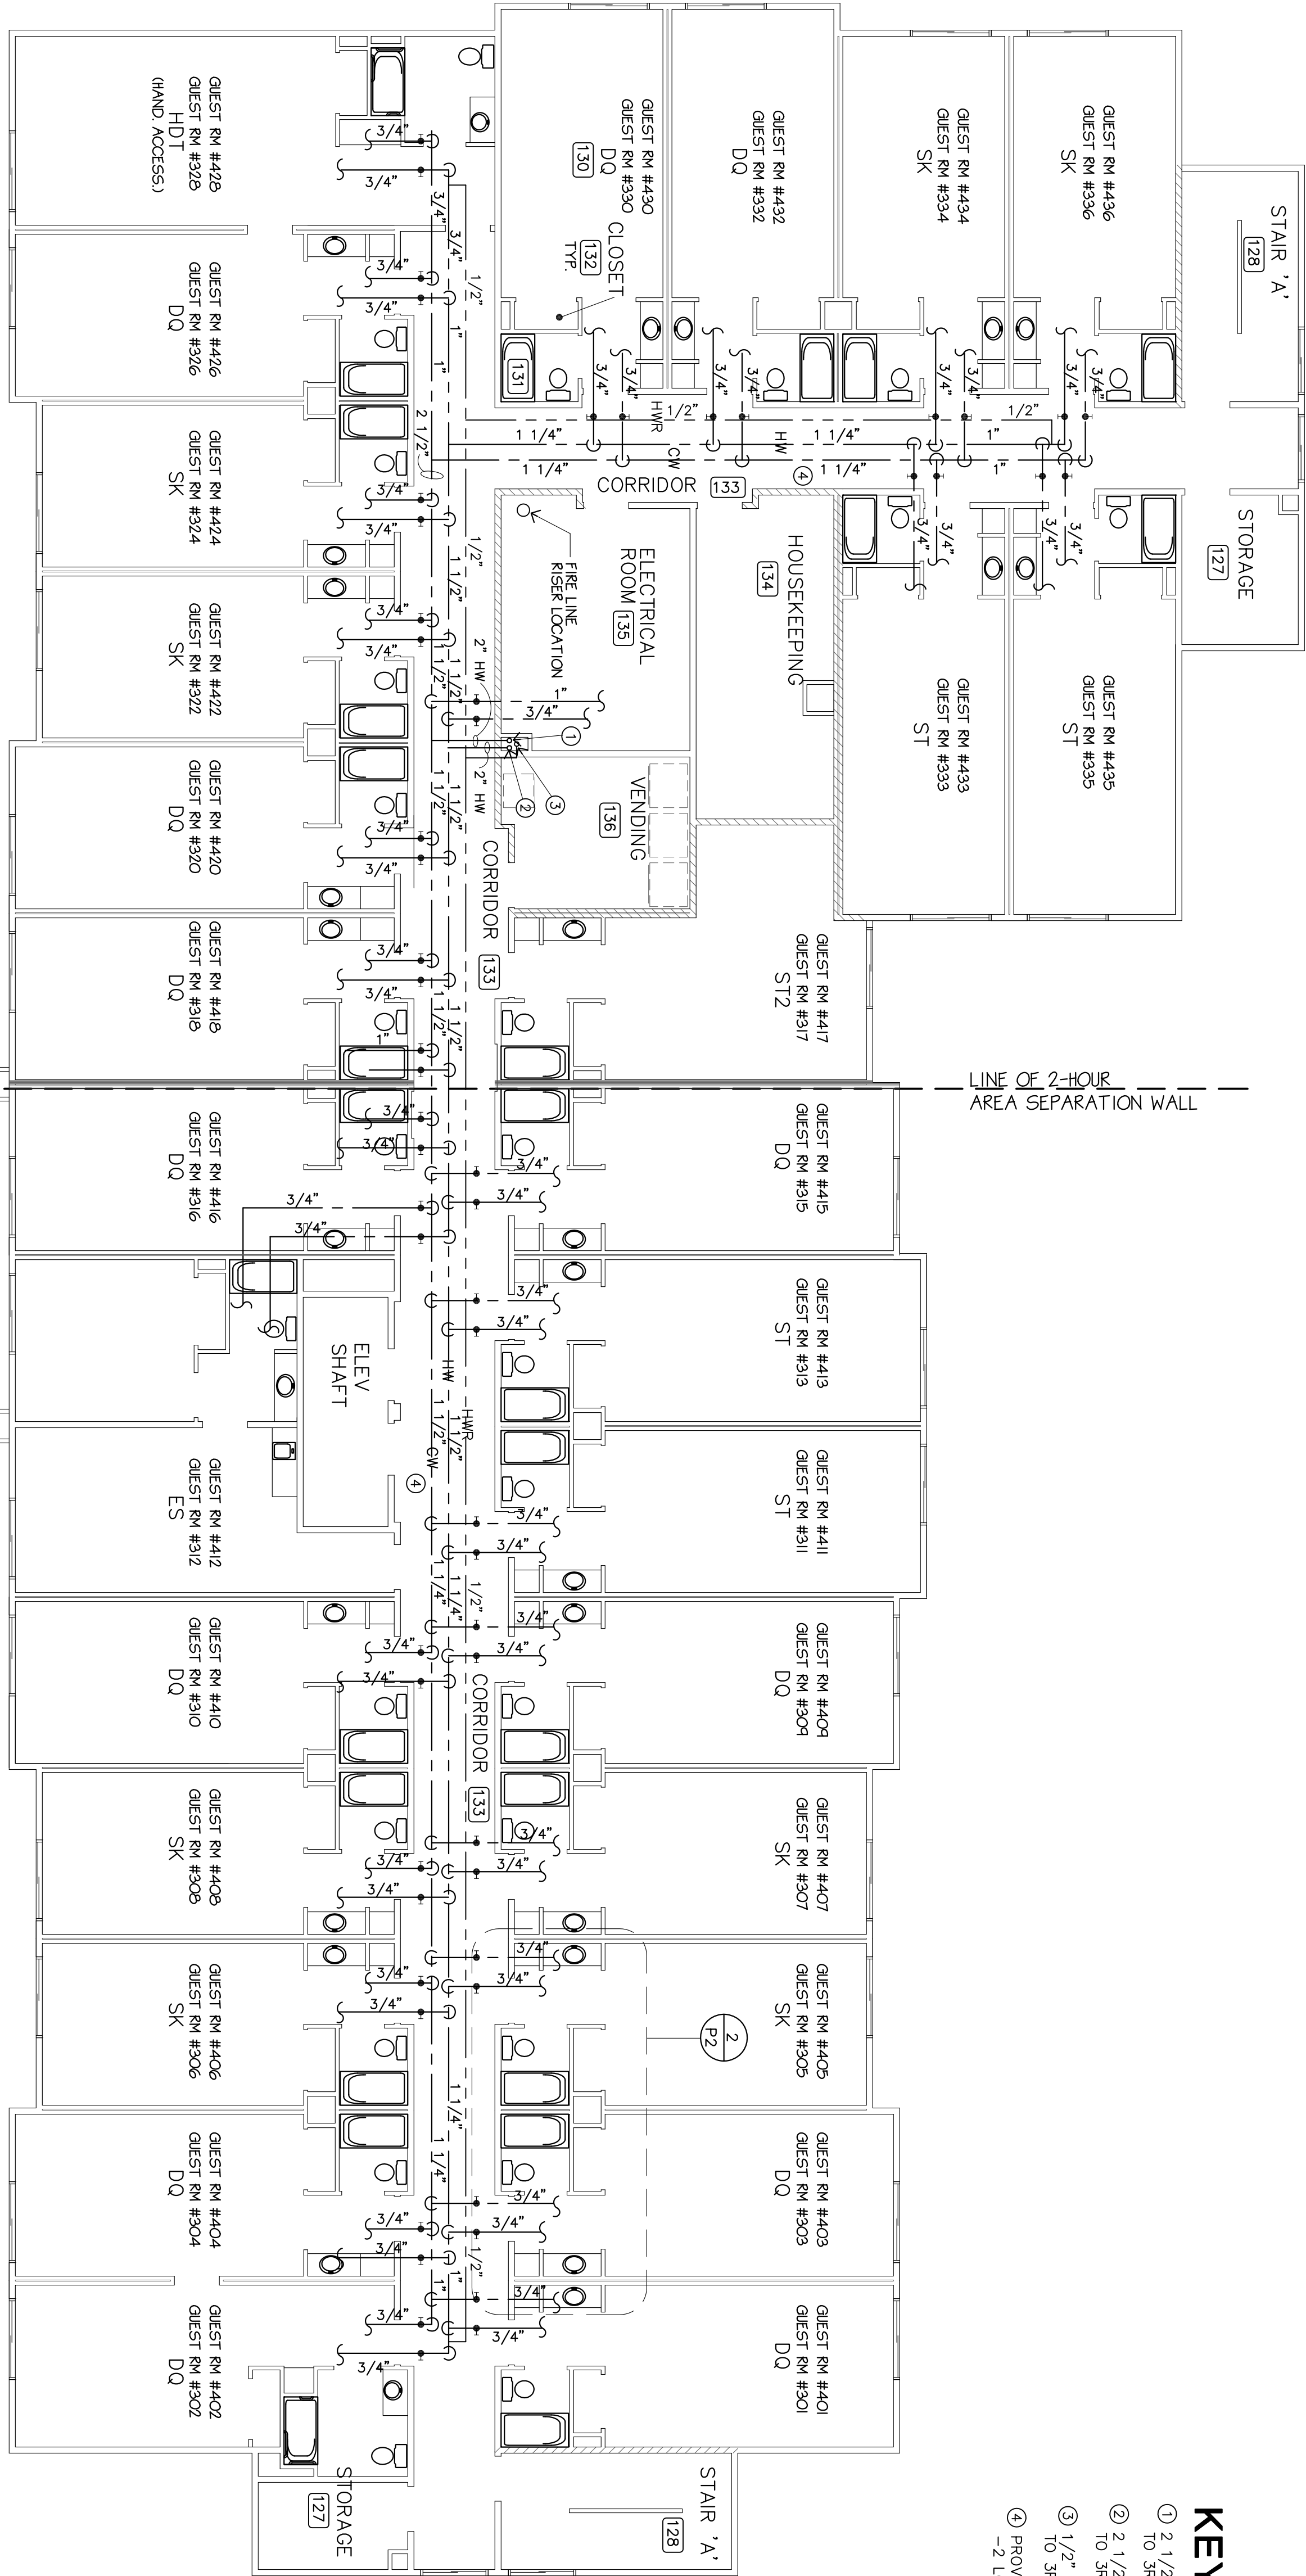

KEY NOTES:

- ① 2 1/2" CW RISER UP TO 3RD FLR
- ② 2 1/2" HW RISER UP TO 3RD FLR
- ③ 1/2" HW RISER UP TO 3RD FLR
- ④ PROVIDE HOSEBIBB ON ROOF -2 LOCATIONS REQ'D. / 3/4" CW LINE

INDICATES OCCUPANCY SEPARATION WALL
INDICATES 2-HR AREA SEPARATION WALL

NOTE:
FOR TYPICAL GUEST ROOM LAYOUTS SEE DETAILS 1/P2 & 2/P2
REFER TO SHEET P6 FOR GAS PIPING SCHEMATIC
COORDINATE PLUMBING LINES WITH STRUCTURAL REQTS. (REFER TO STRUCTURAL DRAWINGS)
REFER TO ARCHITECTURAL DRAWINGS FOR DESIGNATION AND LISTING OF FIRE RATED ASSEMBLY DESIGN NUMBERS. COORDINATE MECHANICAL REQUIREMENTS WITH FIRE RESISTANCE OF MATERIALS AND CONSTRUCTION
CROSS-HATCHED WALLS AND ENTIRE FLOOR/CEILING ASSEMBLIES OF LAUNDRY ROOM, STOR. ROOMS, AND 2ND, 3RD & 4TH FLOOR HOUSEKEEPING, VENDING & ELECTRICAL AREAS SHALL BE OF 1-HR FIRE RESISTIVE CONSTRUCTION FOR OCCUPANCY SEPARATION SEPARATION PAROCHES (2-HR @ ELEVATOR SHAFT & STAIRWAY ENCLOSURES)
[ET] INDICATES PLUMBING FUTURE DESIGNATION -REFER TO SCHEDULE ON SHEET P6