


# 3rd & 4th FLOORS PLUMBING SANITARY SEWER PIPING FLOOR PLAN

SCALE: 1/8"=1'-0"

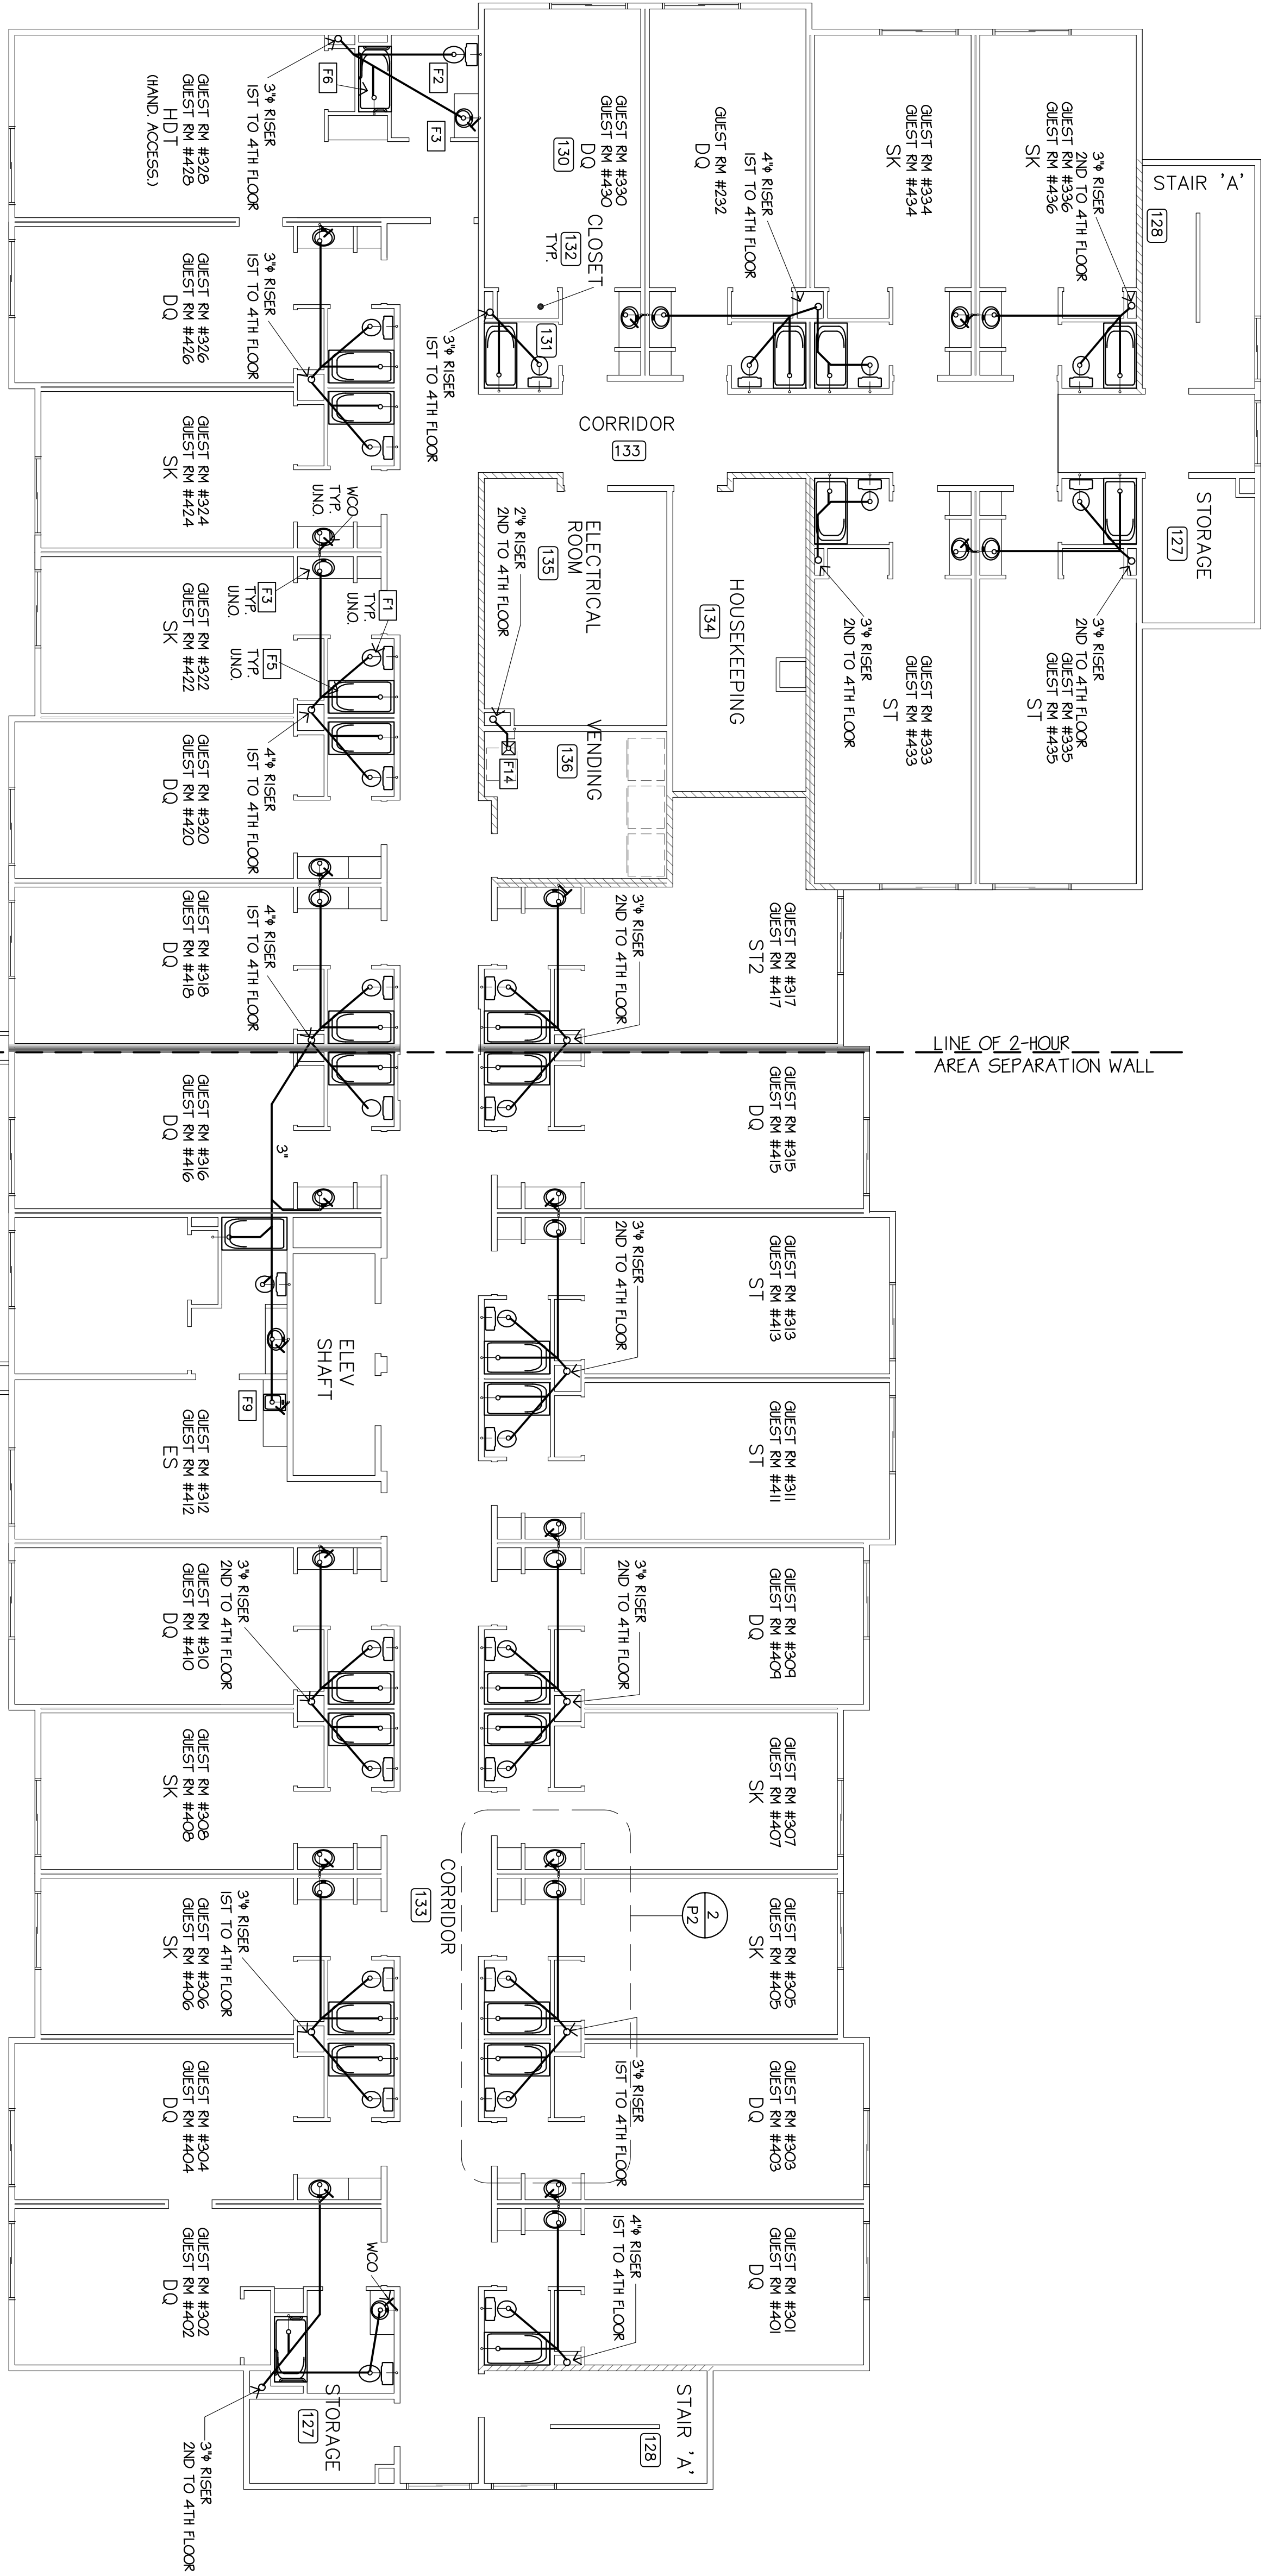

NOTE:  
FOR TYPICAL GUEST ROOM  
LAYOUTS SEE DETAILS P/P2 & 2/P2  
REFER TO SHEET P6 FOR  
GAS PIPING SCHEDULE  
COORDINATE PLUMBING LINES WITH  
STRUCTURAL REQTS. (REFER TO STRUCTURAL DRAWINGS)  
REFER TO ARCHITECTURAL DRAWINGS FOR  
DESIGNATION AND LISTING OF FIRE RATED  
MECHANICAL REQUIREMENTS WITH FIRE  
RESISTANCE OF MATERIALS AND CONSTRUCTION.  
CROSS-HATCHED WALLS AND ENTIRE  
FLOOR/CEILING ASSEMBLIES OF LAUNDRY ROOM, STOR. ROOMS,  
AND 2ND, 3RD & 4TH FLOOR HOUSEKEEPING, VENDING & ELECTRICAL AREAS  
SHALL BE OF 1-HR. FIRE RESISTIVE CONSTRUCTION FOR OCCUPANCY SEPARATION  
SEPARATION PURPOSES. (2-HR. @ ELEVATOR SHAFT & STAIRWAY ENCLOSURES)  
[F1] INDICATES PLUMBING FIXTURE DESIGNATION  
REFER TO SCHEDULE ON SHEET P6