

THESE DRAWINGS, DESIGNS, SKETCHES, IDEAS & ARRANGEMENTS ARE THE SOLE & EXCLUSIVE PROPERTY OF LEE GAGE & ASSOCIATES, AND WERE CREATED AND DEVELOPED BY AND FOR THE ARCHITECT'S EXCLUSIVE USE ON AND IN CONJUNCTION WITH THE ARCHITECT'S WORK. NOTHING CONTAINED OR REPRESENTED ON THESE DOCUMENTS SHALL BE USED BY OR DISCLOSED TO ANY PERSON, FIRM OR CORPORATION FOR ANY PURPOSE WITHOUT EXPRESSED WRITTEN CONSENT OF LEE GAGE & ASSOCIATES.

PROPOSED:
HAMPTON INN
CORPORATE DRIVE
SOUTH SAN FRANCISCO, CA.

by _____ date _____

drawn _____

checked _____


revised _____

revised _____

project no. _____

Sheet
SET NO.

P5

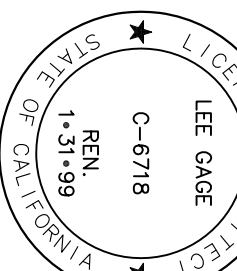


12/19/97

C:\SDSKPRO\1\SouthSF\DWG\SF0-P5.DWG

INDICATES OCCUPANCY SEPARATION WALL
INDICATES 2-HR AREA SEPARATION WALL

NOTE:
1. TYPICAL GUEST ROOM LAYOUTS SEE DETAIL U/72 & 2/72
2. REFER TO SHEET P6 FOR GAS PIPING SCHEMATIC
3. COORDINATE PLUMBING LINES WITH STRUCTURAL REQTS. (REFER TO STRUCTURAL DRAWINGS)
4. REFER TO ARCHITECTURAL DRAWINGS FOR DESIGNATION AND LISTING OF FIRE RATED MECHANICAL REQUIREMENTS WITH FIRE RESISTANCE OF MATERIALS AND CONSTRUCTION
5. CROSS-HATCHED WALLS AND ENTIRE ROOMS ARE PARTS OF LAUNDRY ROOM STOR. ROOMS AND ARE TO BE CONSTRUCTED WITH 2-HR FIRE RESISTIVE CONSTRUCTION FOR OCCUPANCY SEPARATION PURPOSES. (2-HR @ ELEVATOR SHUTT & STAIRWAY ENCLOSURES)
6. [F] INDICATES PLUMBING FIXTURE DESIGNATION
7. REFER TO SCHEDULE ON SHEET P6

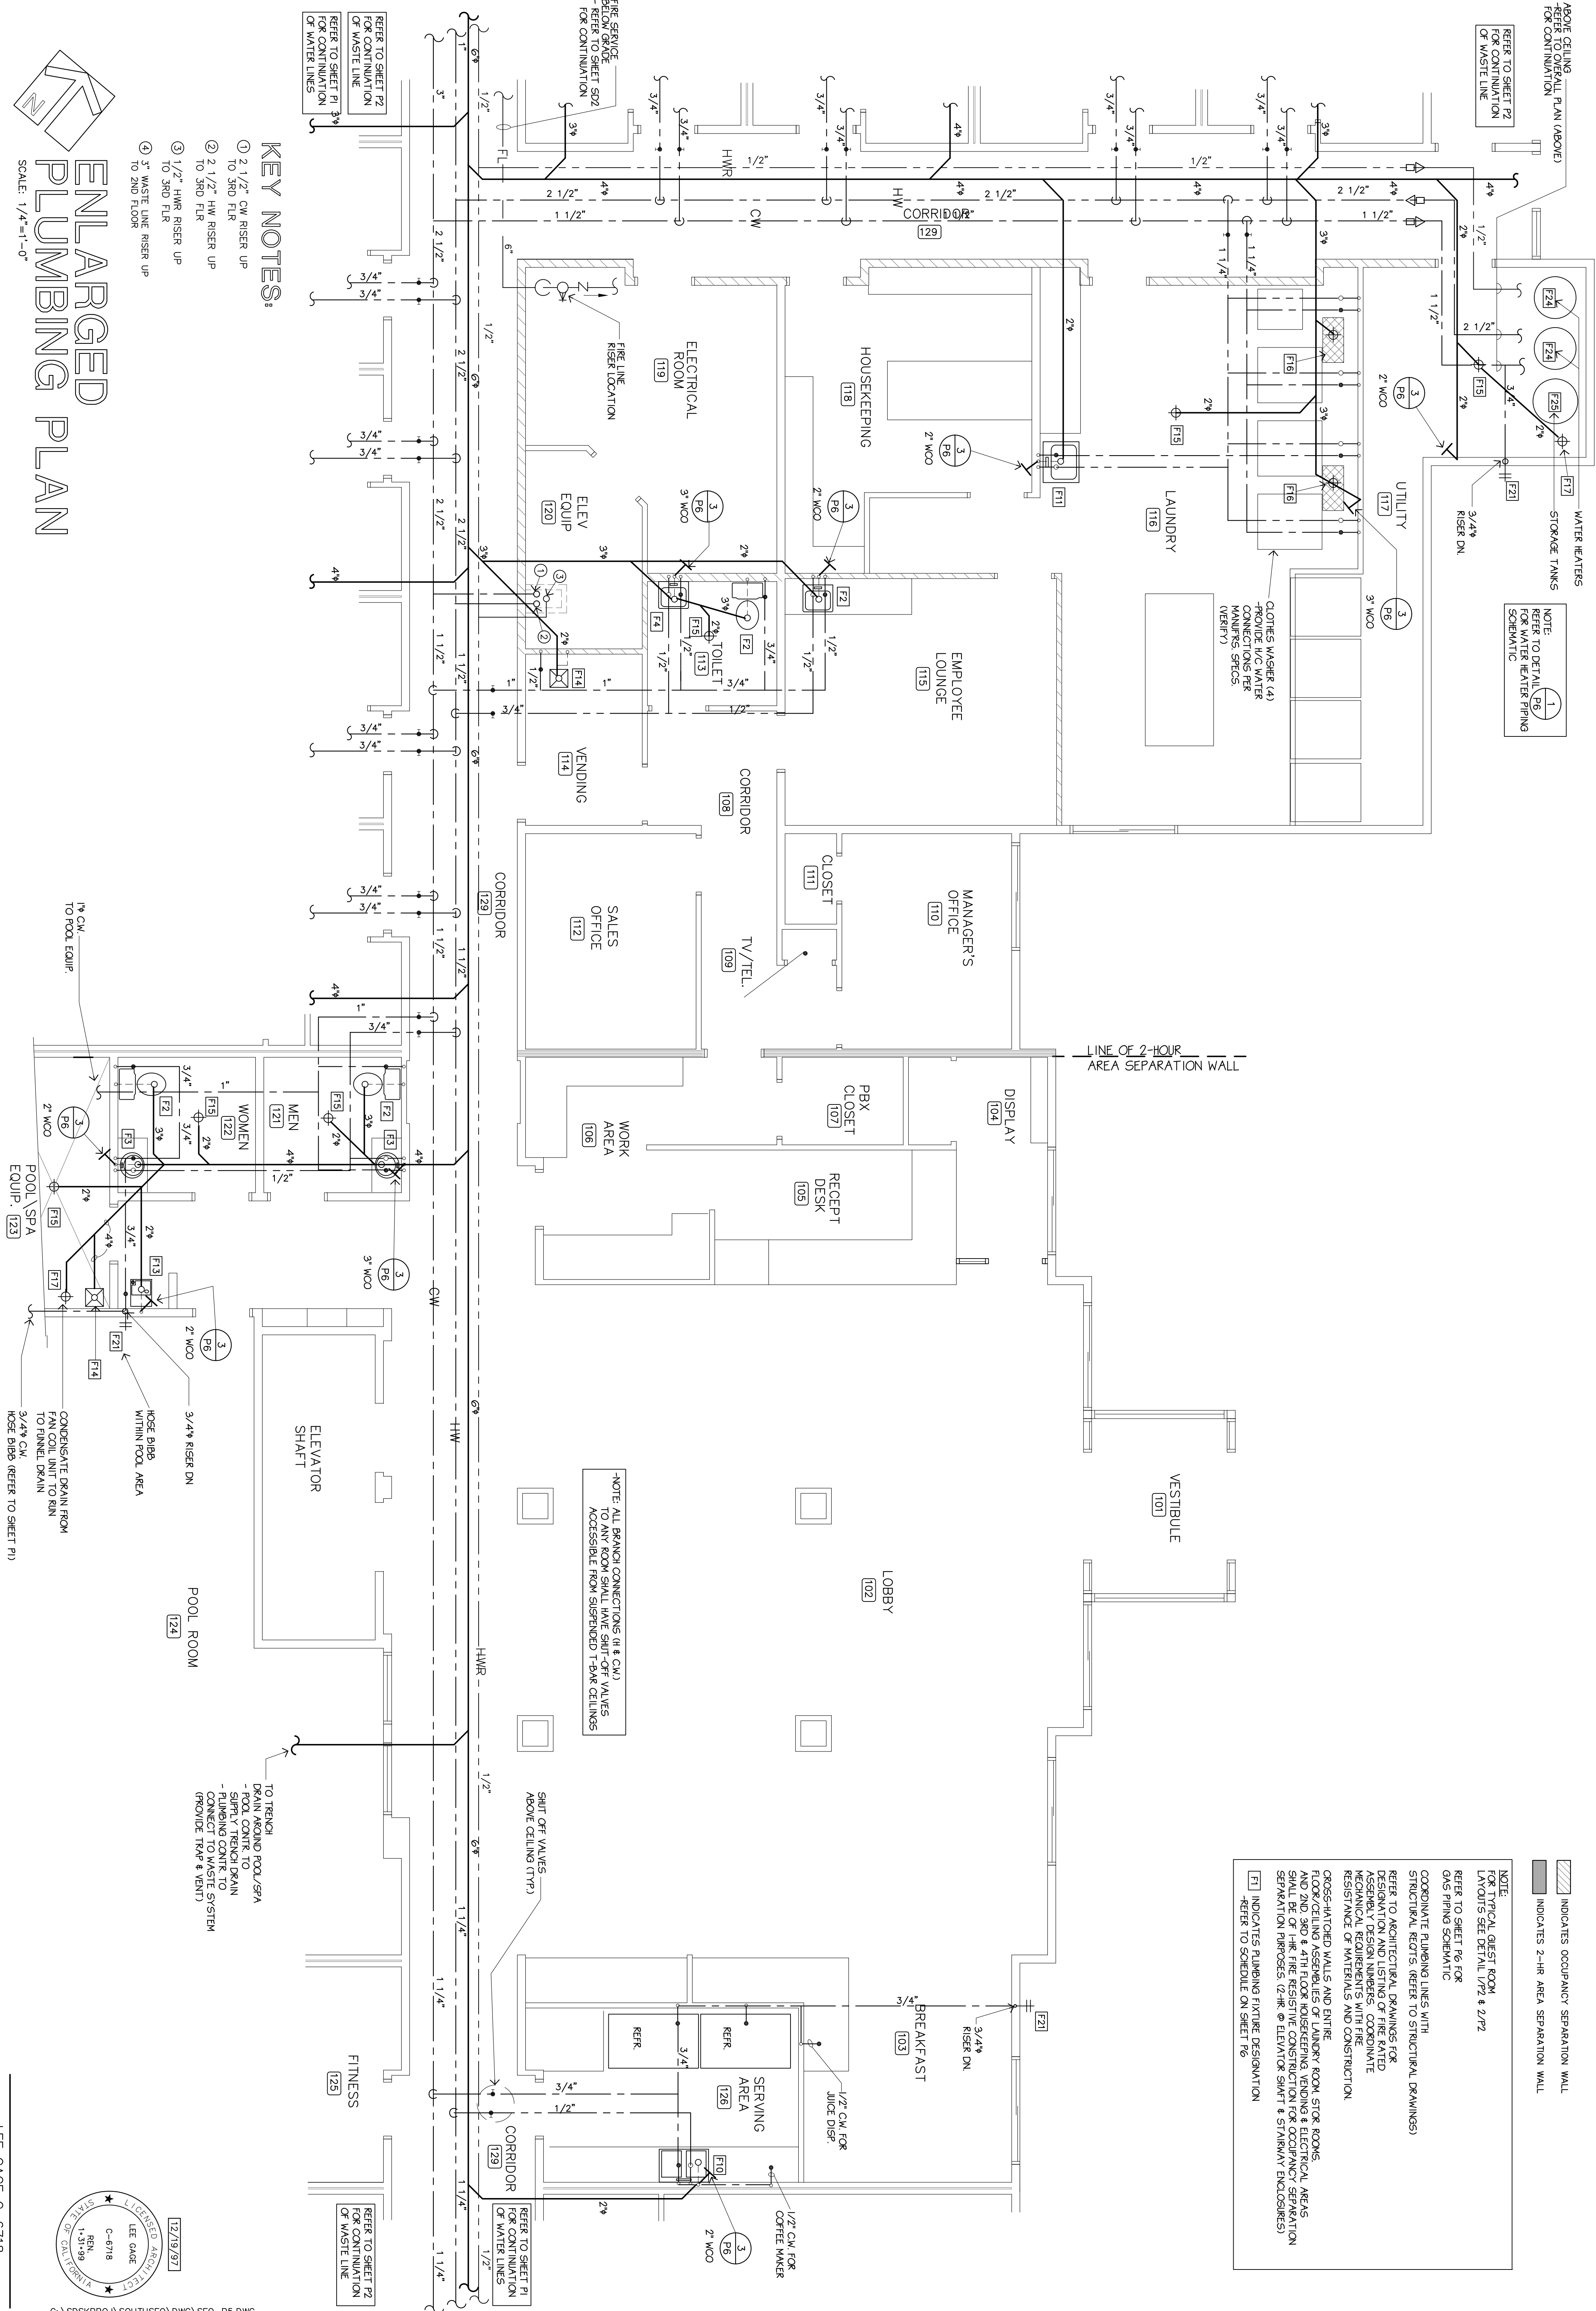

KEY NOTES:

- 1 2 1/2" CW RISER UP TO 3RD FLR
- 2 2 1/2" HW RISER UP TO 3RD FLR
- 3 1/2" HW RISER UP TO 3RD FLR
- 4 3" WASTE LINE RISER UP TO 2ND FLOOR

ENLARGED
PLUMBING PLAN

SCALE: 1/4"=1'-0"