
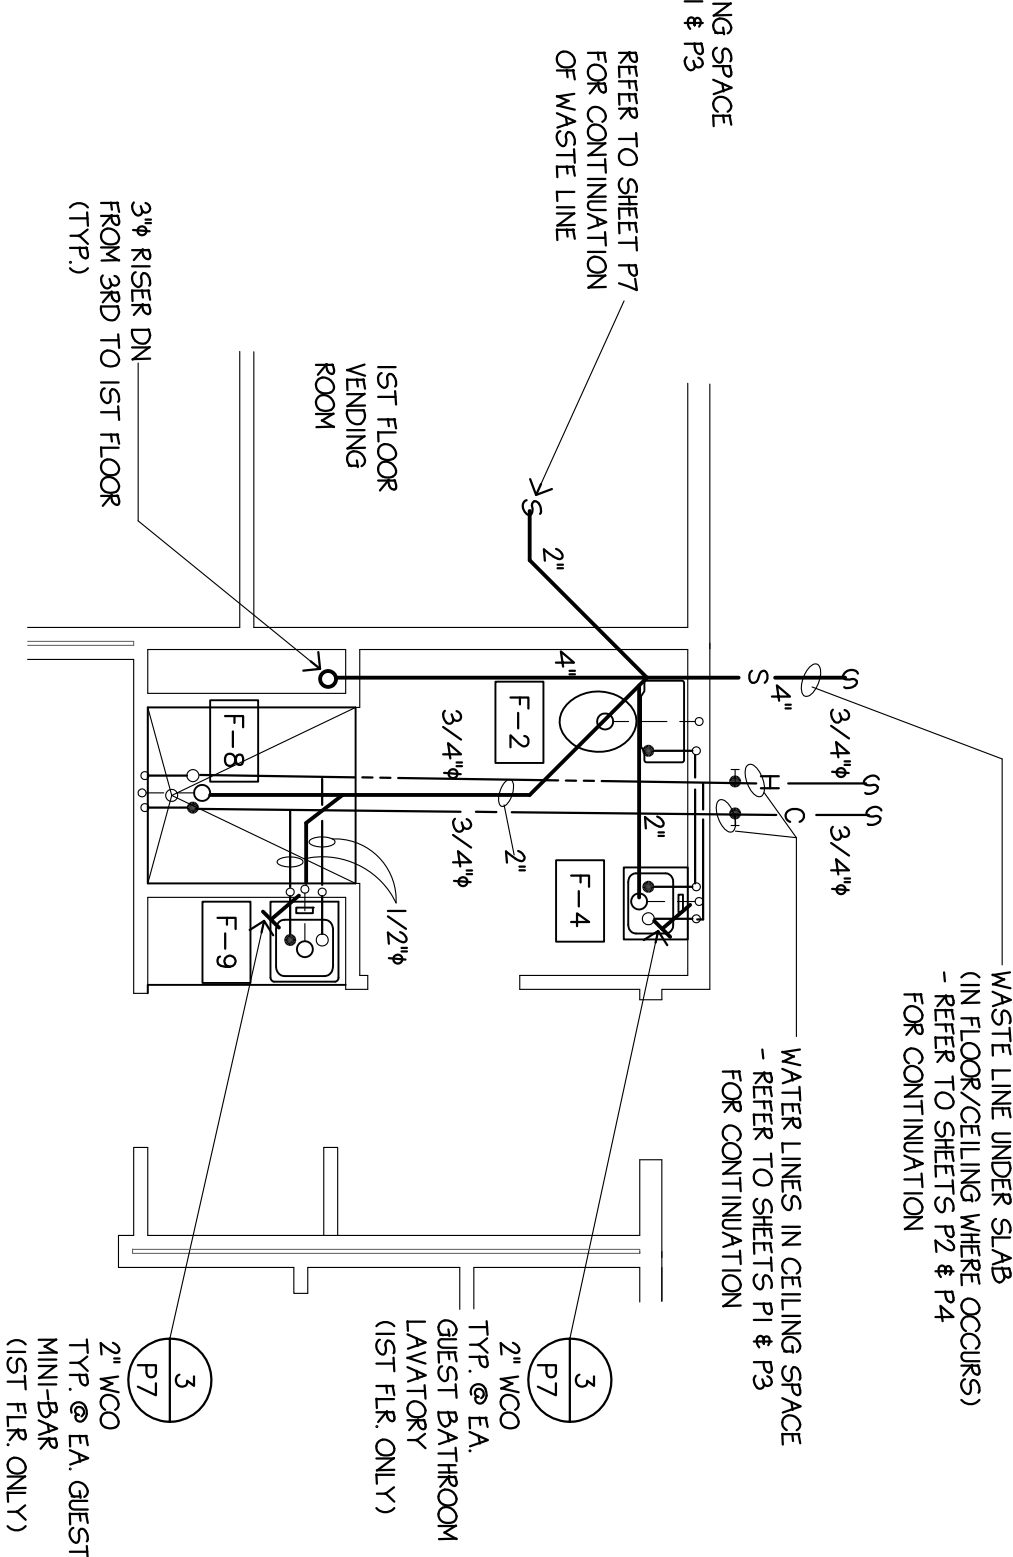
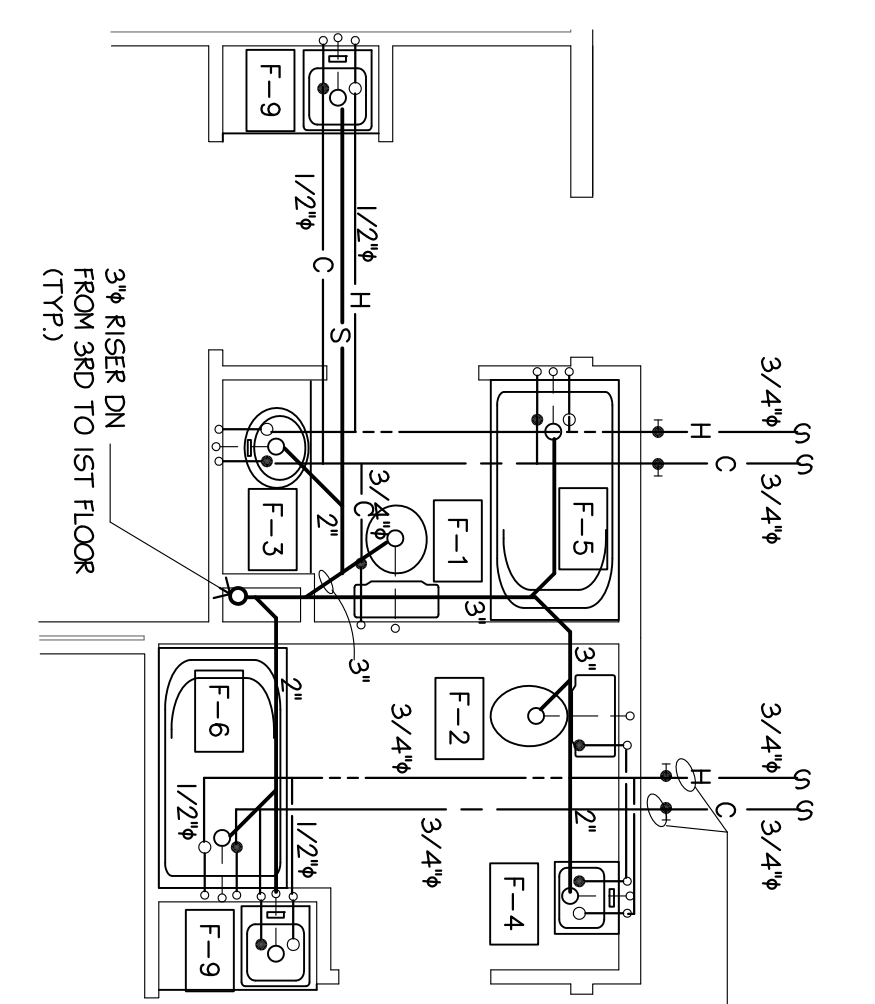
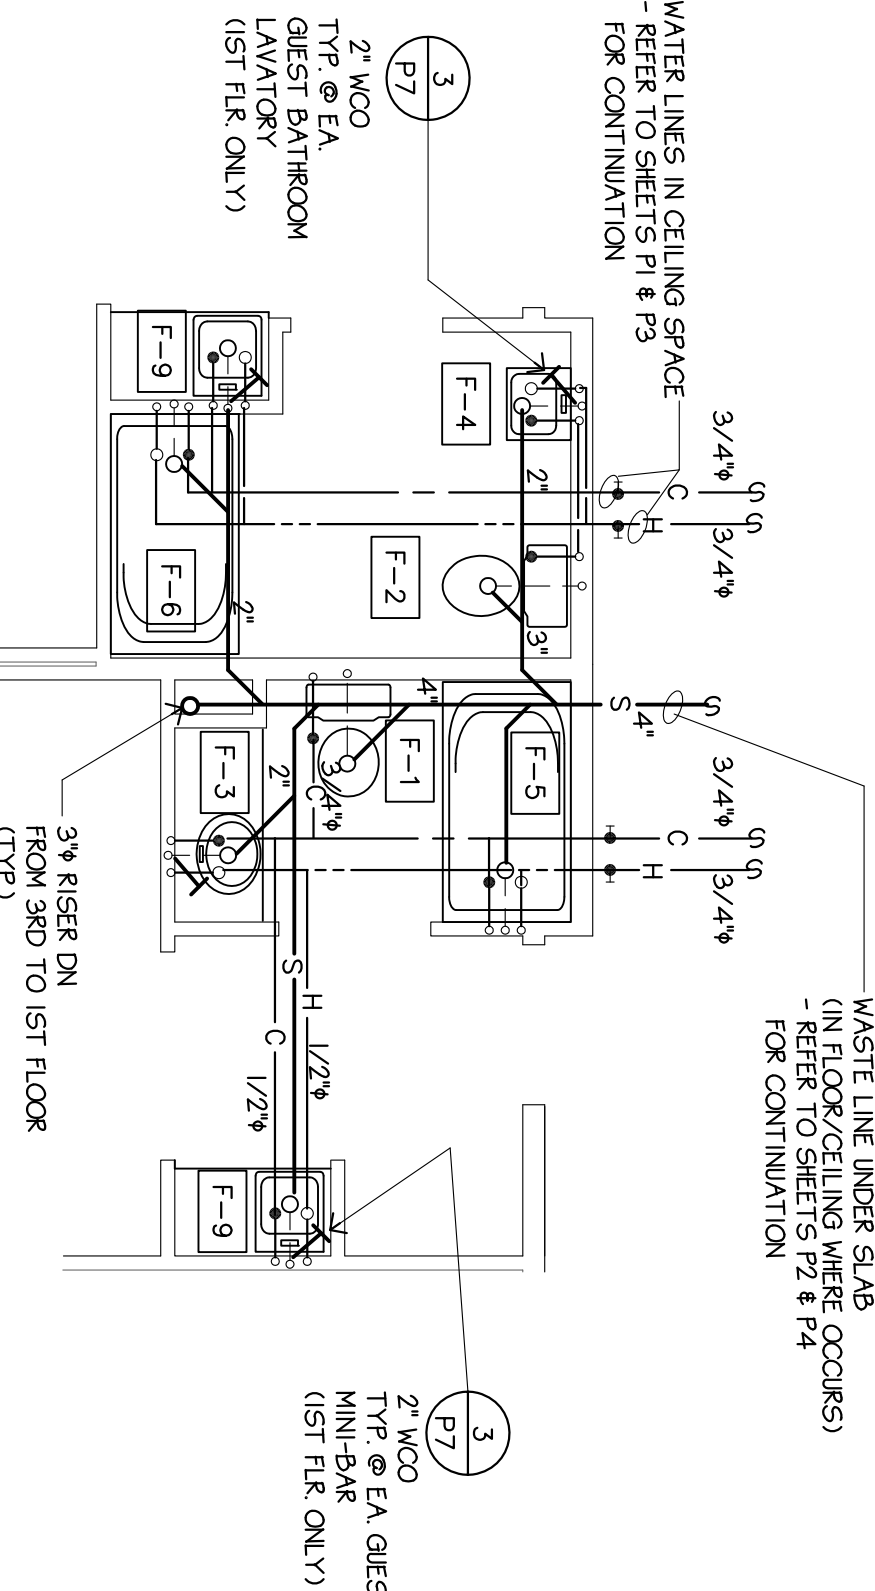


1st FLOOR
1 TYPICAL BACK TO BACK GUEST BATHROOMS
P5 SCALE: 1/4"=1'-0"

2nd, 3rd & 4th FLOORS
2 TYPICAL BACK TO BACK GUEST BATHROOMS
P5 SCALE: 1/4"=1'-0"

2nd FLOOR (ROOM #'S 245, 247, 248 & 250)
3 TYPICAL BACK TO BACK GUEST BATHROOMS
P5 SCALE: 1/4"=1'-0"


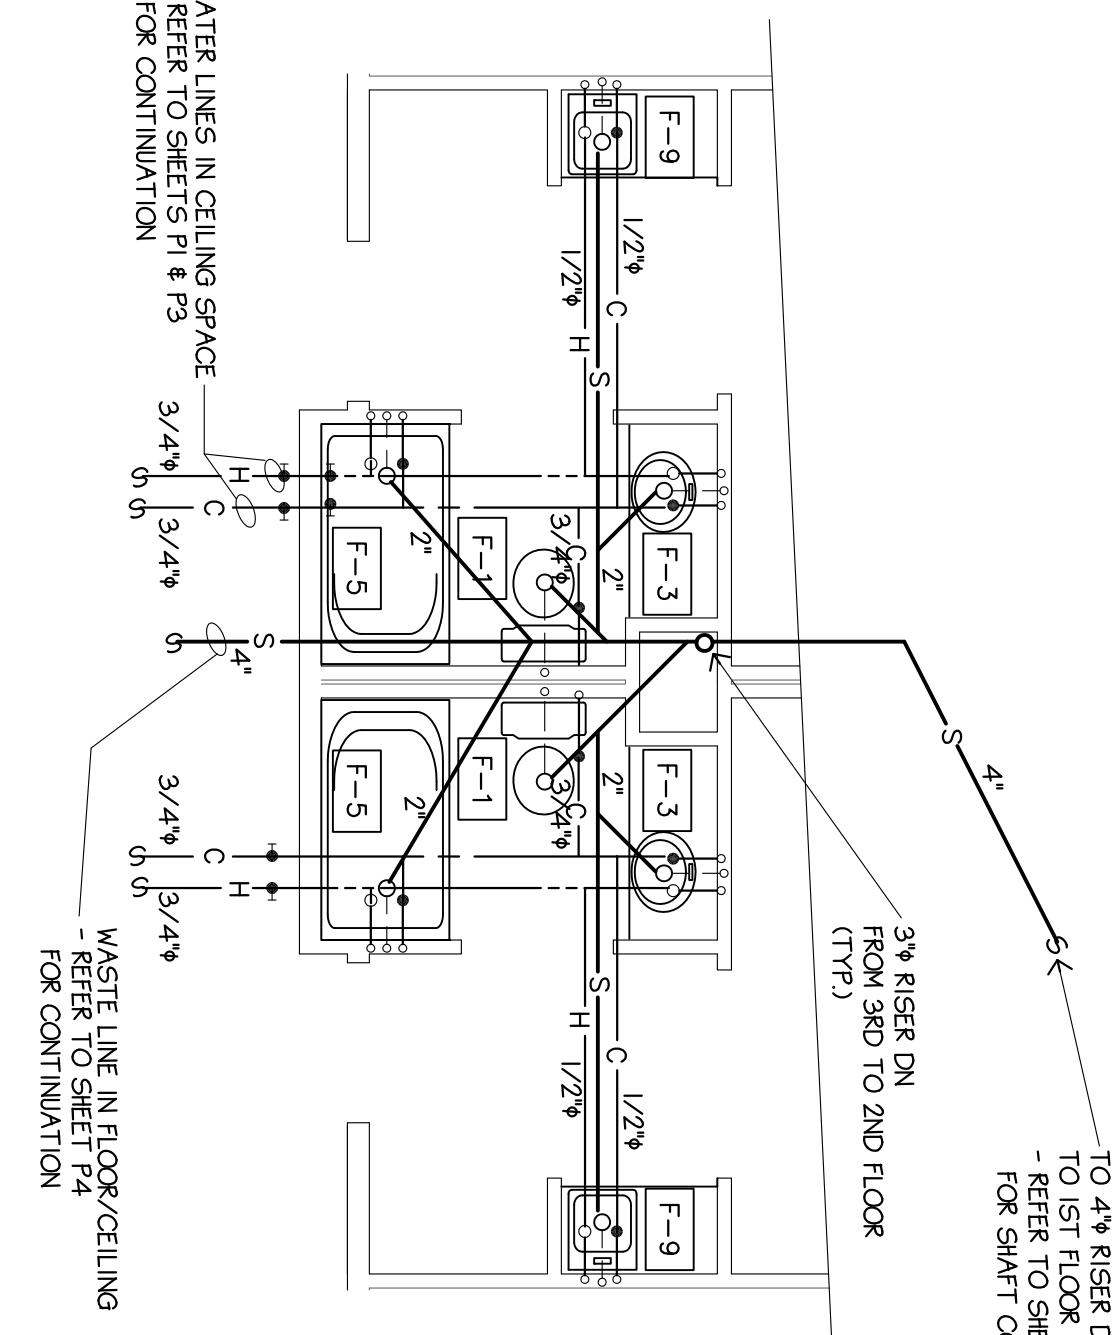


2ND FLOOR (ROOM #'S 241 & 242)
4 BACK TO BACK GUEST BATHROOMS
P5 SCALE: 1/4"=1'-0"

1st FLOOR
5 ACCESSIBLE GUEST BATHROOM
P5 SCALE: 1/4"=1'-0"


2nd & 3rd FLOORS
6 ACCESSIBLE GUEST BATHROOM
P5 SCALE: 1/4"=1'-0"

1st FLOOR W/ROLL-IN SHOWER (ROOM #151)
7 ACCESSIBLE GUEST BATHROOM
P5 SCALE: 1/4"=1'-0"

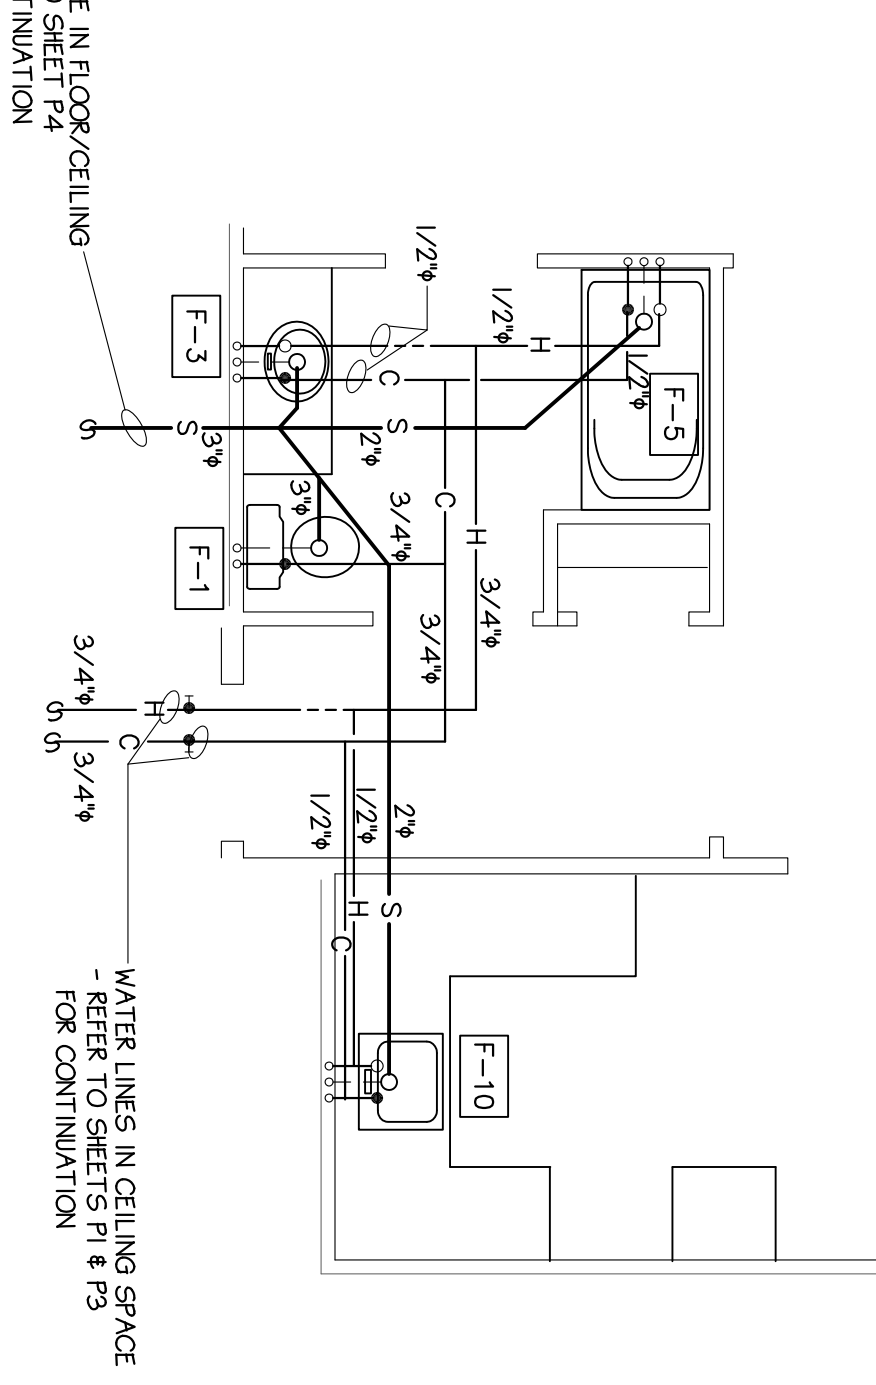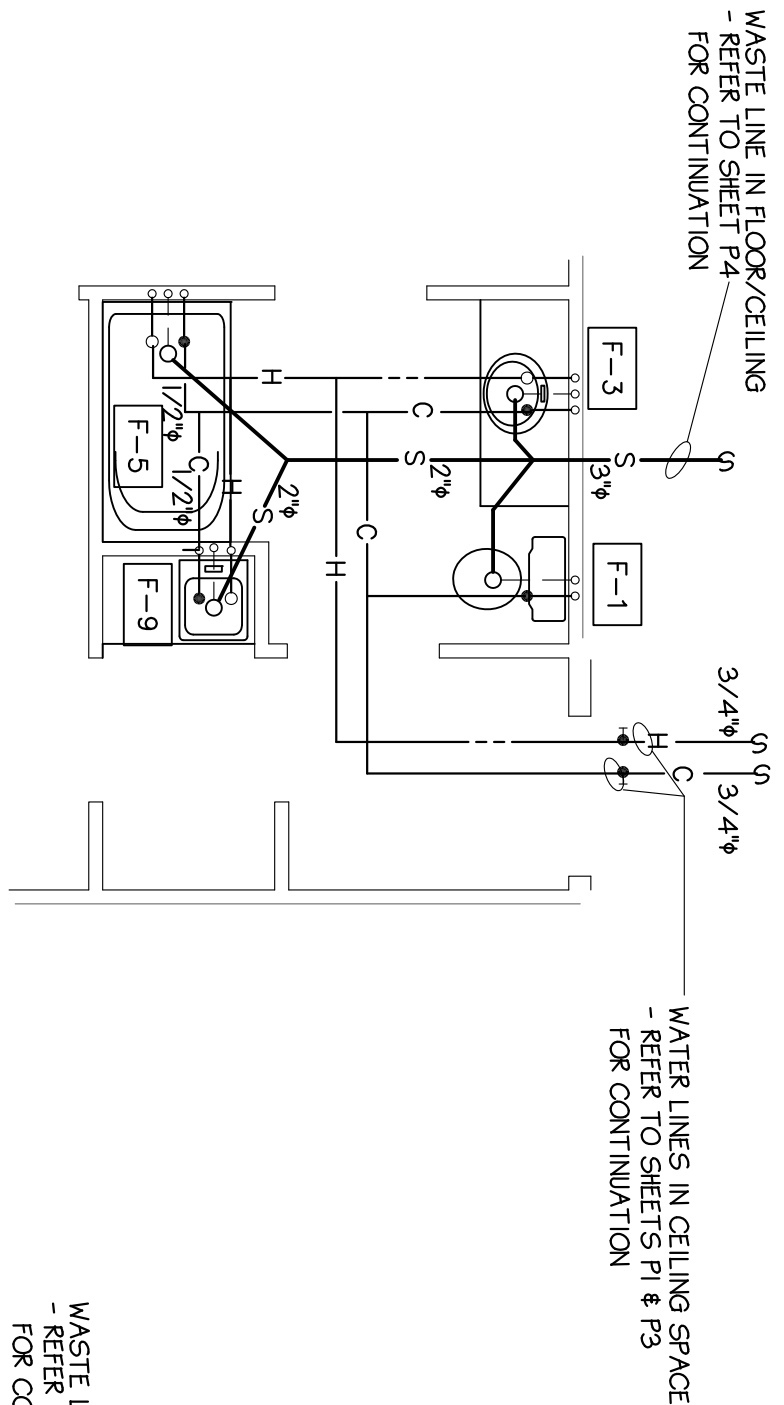


ROOM #'S 243, 244, & 343
8 BRIDAL SUITE BATHROOMS
P5 SCALE: 1/4"=1'-0"

ROOM #344
9 EXECUTIVE SUITE PLUMBING PLAN
P5 SCALE: 1/4"=1'-0"

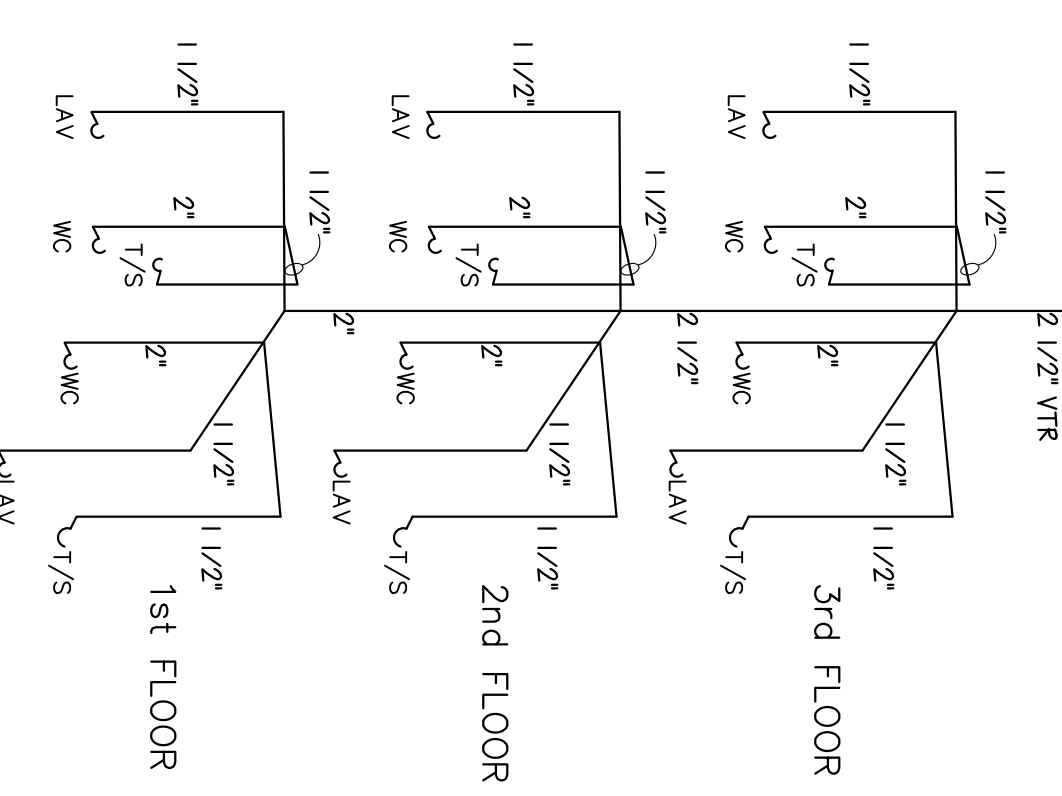

TYPICAL VENT STACK
NO SCALE

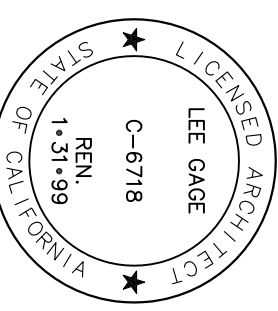

LEE GAGE C-6718

THESE DRAWINGS, DESIGNS, SKETCHES, IDEAS & ARRANGEMENTS ARE THE SOLE & EXCLUSIVE PROPERTY OF LEE GAGE & ASSOCIATES, AND WERE CREATED AND DEVELOPED BY AND FOR THE ARCHITECT'S EXCLUSIVE USE ON AND IN CONJUNCTION WITH THE ARCHITECT'S WORK. NOTHING CONTAINED OR REPRESENTED ON THESE DOCUMENTS SHALL BE USED BY OR DISCLOSED TO ANY PERSON, FIRM OR CORPORATION FOR ANY PURPOSE, WITHOUT EXPRESSED WRITTEN CONSENT OF LEE GAGE & ASSOCIATES.

lee gage & associates
architects • engineers • planners
7636 n. ingram suite 107 fresno, california 93711 phone (209) 439-2222

PROJECT NO. C-6718
DATE 1-13-99
BY
CHECKED
REVIEWED
NO SCALE

P5
SHEET SET NO.