

3rd & 4th FLOORS MECHANICAL FLOOR PLAN

SCALE: 1/8"=1'-0"

date

drawn

checked


revised

project no.

M2B

sheet

SET NO.

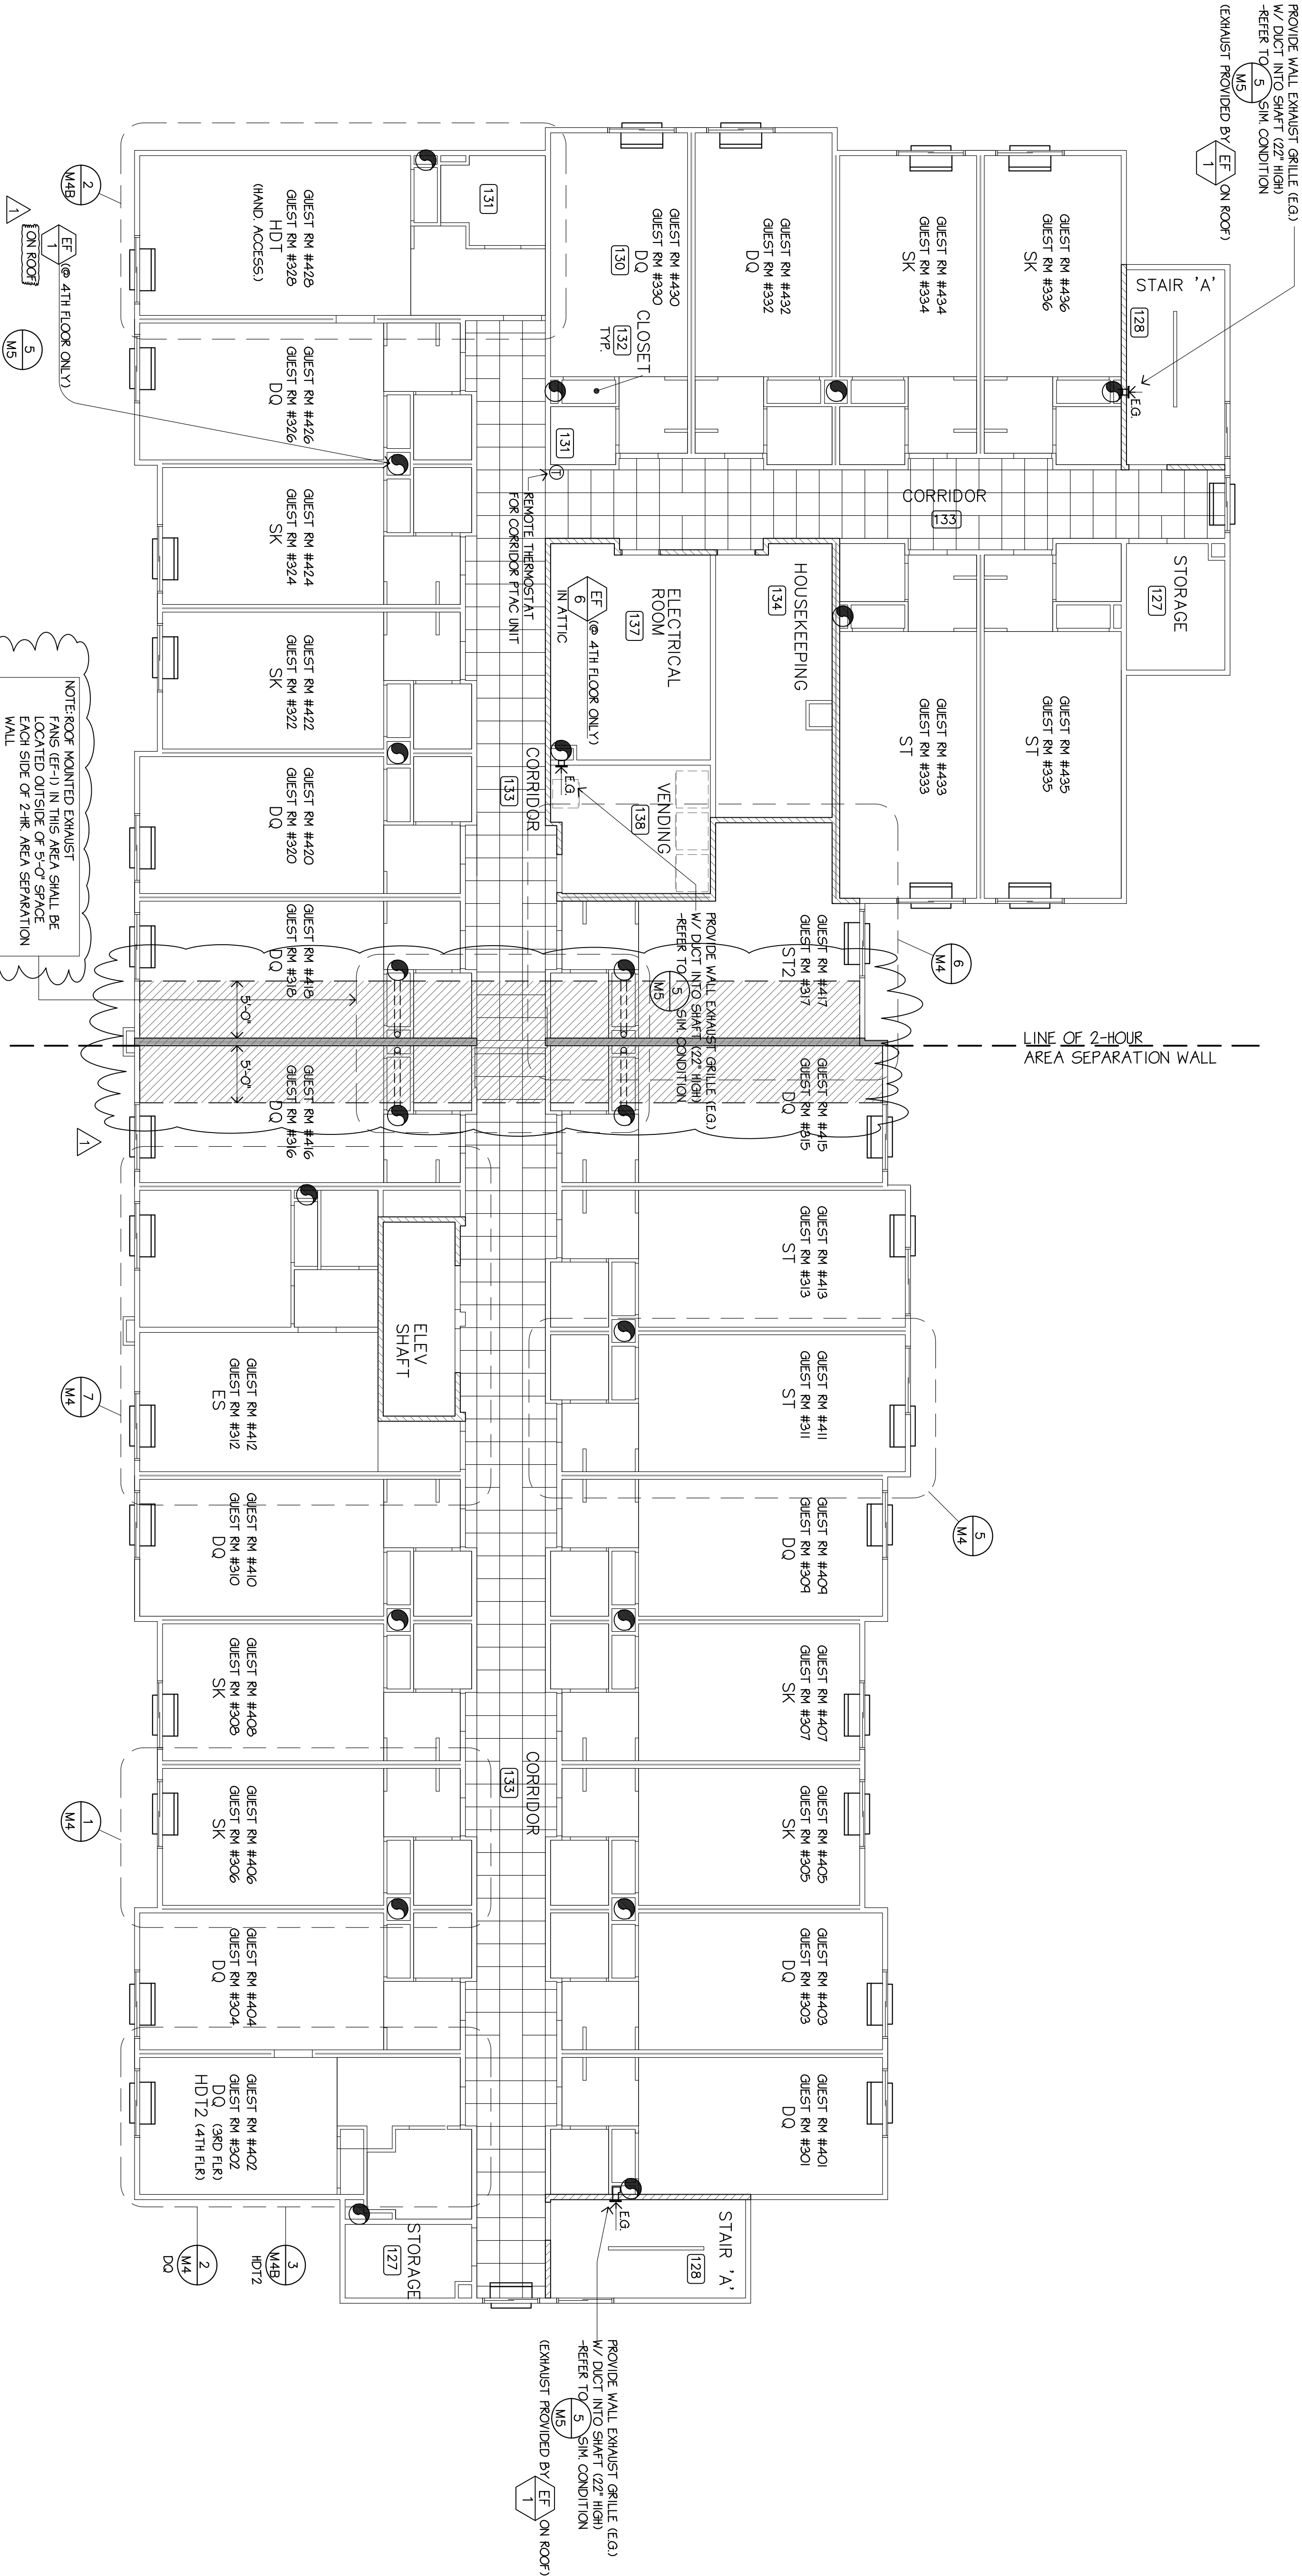

NOTE:
REFER TO SHEET M1 FOR TYPICAL
MECHANICAL PLAN NOTES
REFER TO SHEET M4 & M4B
FOR TYPICAL GUEST RM LAYOUTS
REFER TO SHEET M5 FOR TYPICAL DUCT SWIFT
DETAILS & MECHANICAL EQUIPMENT LIST
REFER TO ARCHITECTURAL DRAWINGS FOR
DESIGNATION AND LISTING OF FIRE RATED
ASSEMBLY DESIGN NUMBERS. COORDINATE
MECHANICAL REQUIREMENTS WITH FIRE
RESISTANCE OF MATERIALS AND CONSTRUCTION