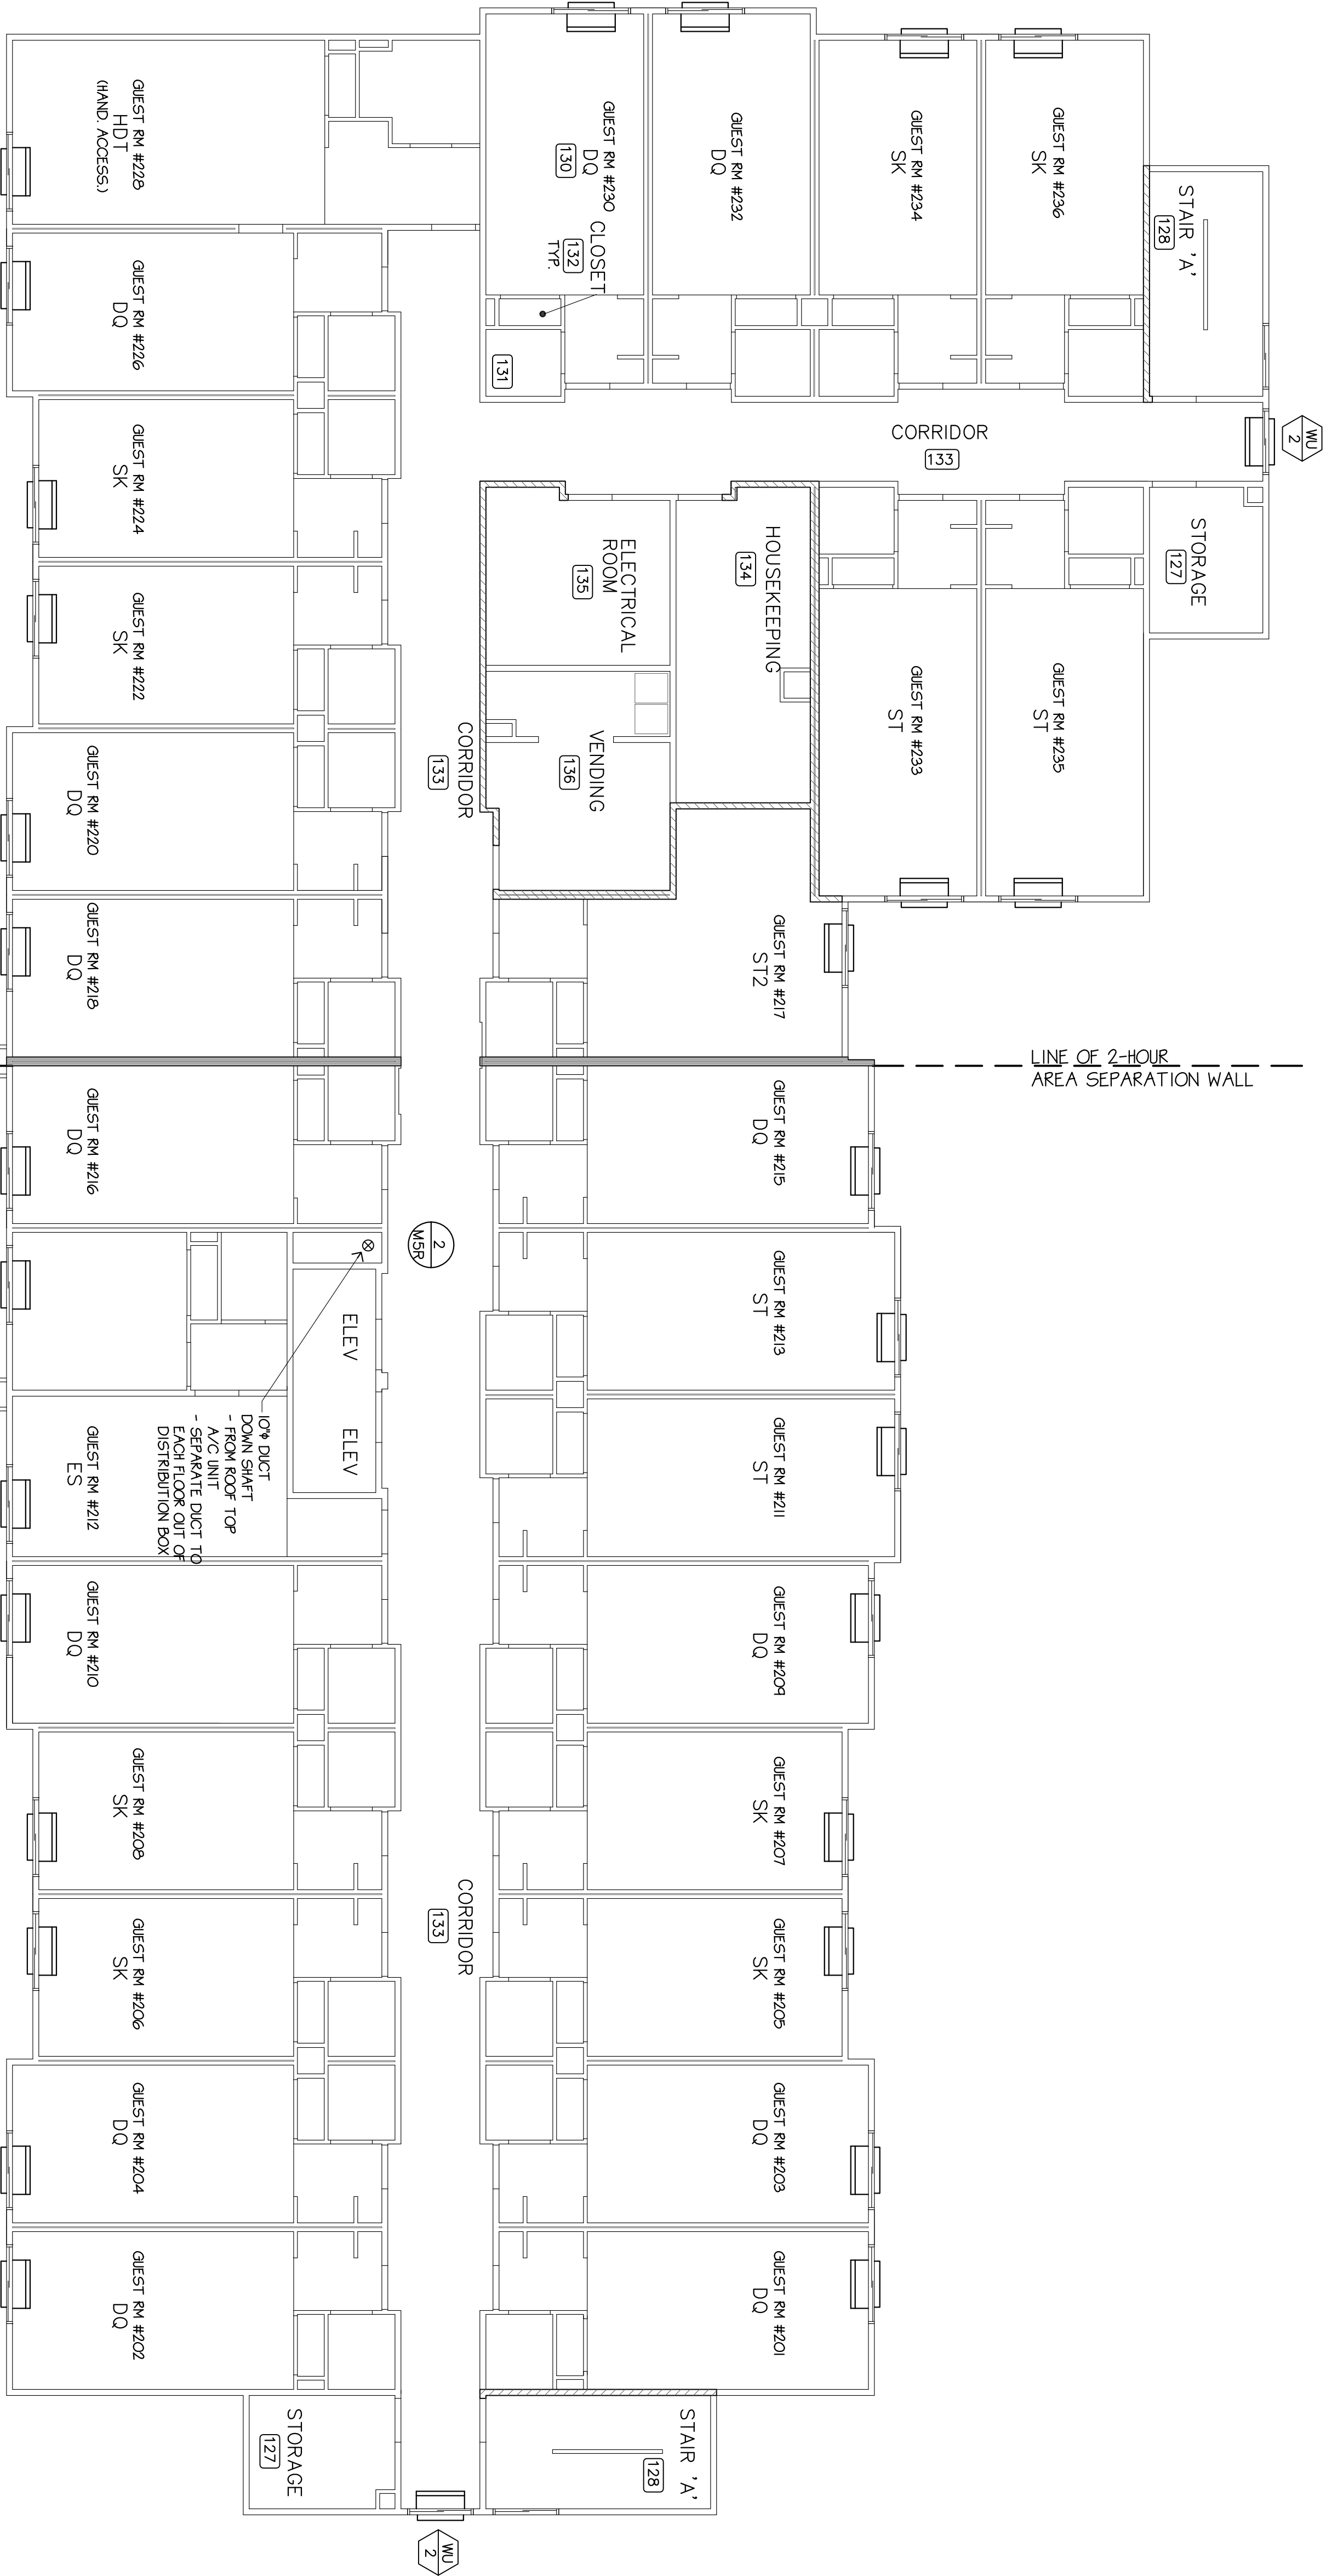


2nd FLOOR MECHANICAL FLOOR PLAN

SCALE: 1/8"=1'-0"

LEE GAGE C-6718

drawn	by	08/24/99	date
checked			
revised			
revised			
project no.			

PROPOSED:
HAMPTON INN
CORPORATE DRIVE
SOUTH SAN FRANCISCO, CALIFORNIA

THESE DRAWINGS, DESIGNS, SKETCHES, IDEAS & ARRANGEMENTS ARE THE SOLE & EXCLUSIVE PROPERTY OF LEE GAGE & ASSOCIATES, AND WERE CREATED AND DEVELOPED BY AND FOR THE ARCHITECT'S EXCLUSIVE USE ON AND IN CONJUNCTION WITH THE ARCHITECT'S WORK. NOTHING CONTAINED OR REPRESENTED ON THESE DOCUMENTS SHALL BE USED BY OR DISCLOSED TO ANY PERSON, FIRM OR CORPORATION FOR ANY PURPOSE WITHOUT EXPRESSED WRITTEN CONSENT OF LEE GAGE & ASSOCIATES.

lee gage & associates
architects • engineers • planners

7636 n. ingram suite 107 fresno, california 93711 phone (209) 439-2222

© LEE GAGE & ASSOC.