


2nd FLOOR ELECTRICAL FLOOR PLAN

SCALE: 1/8"=1'-0"

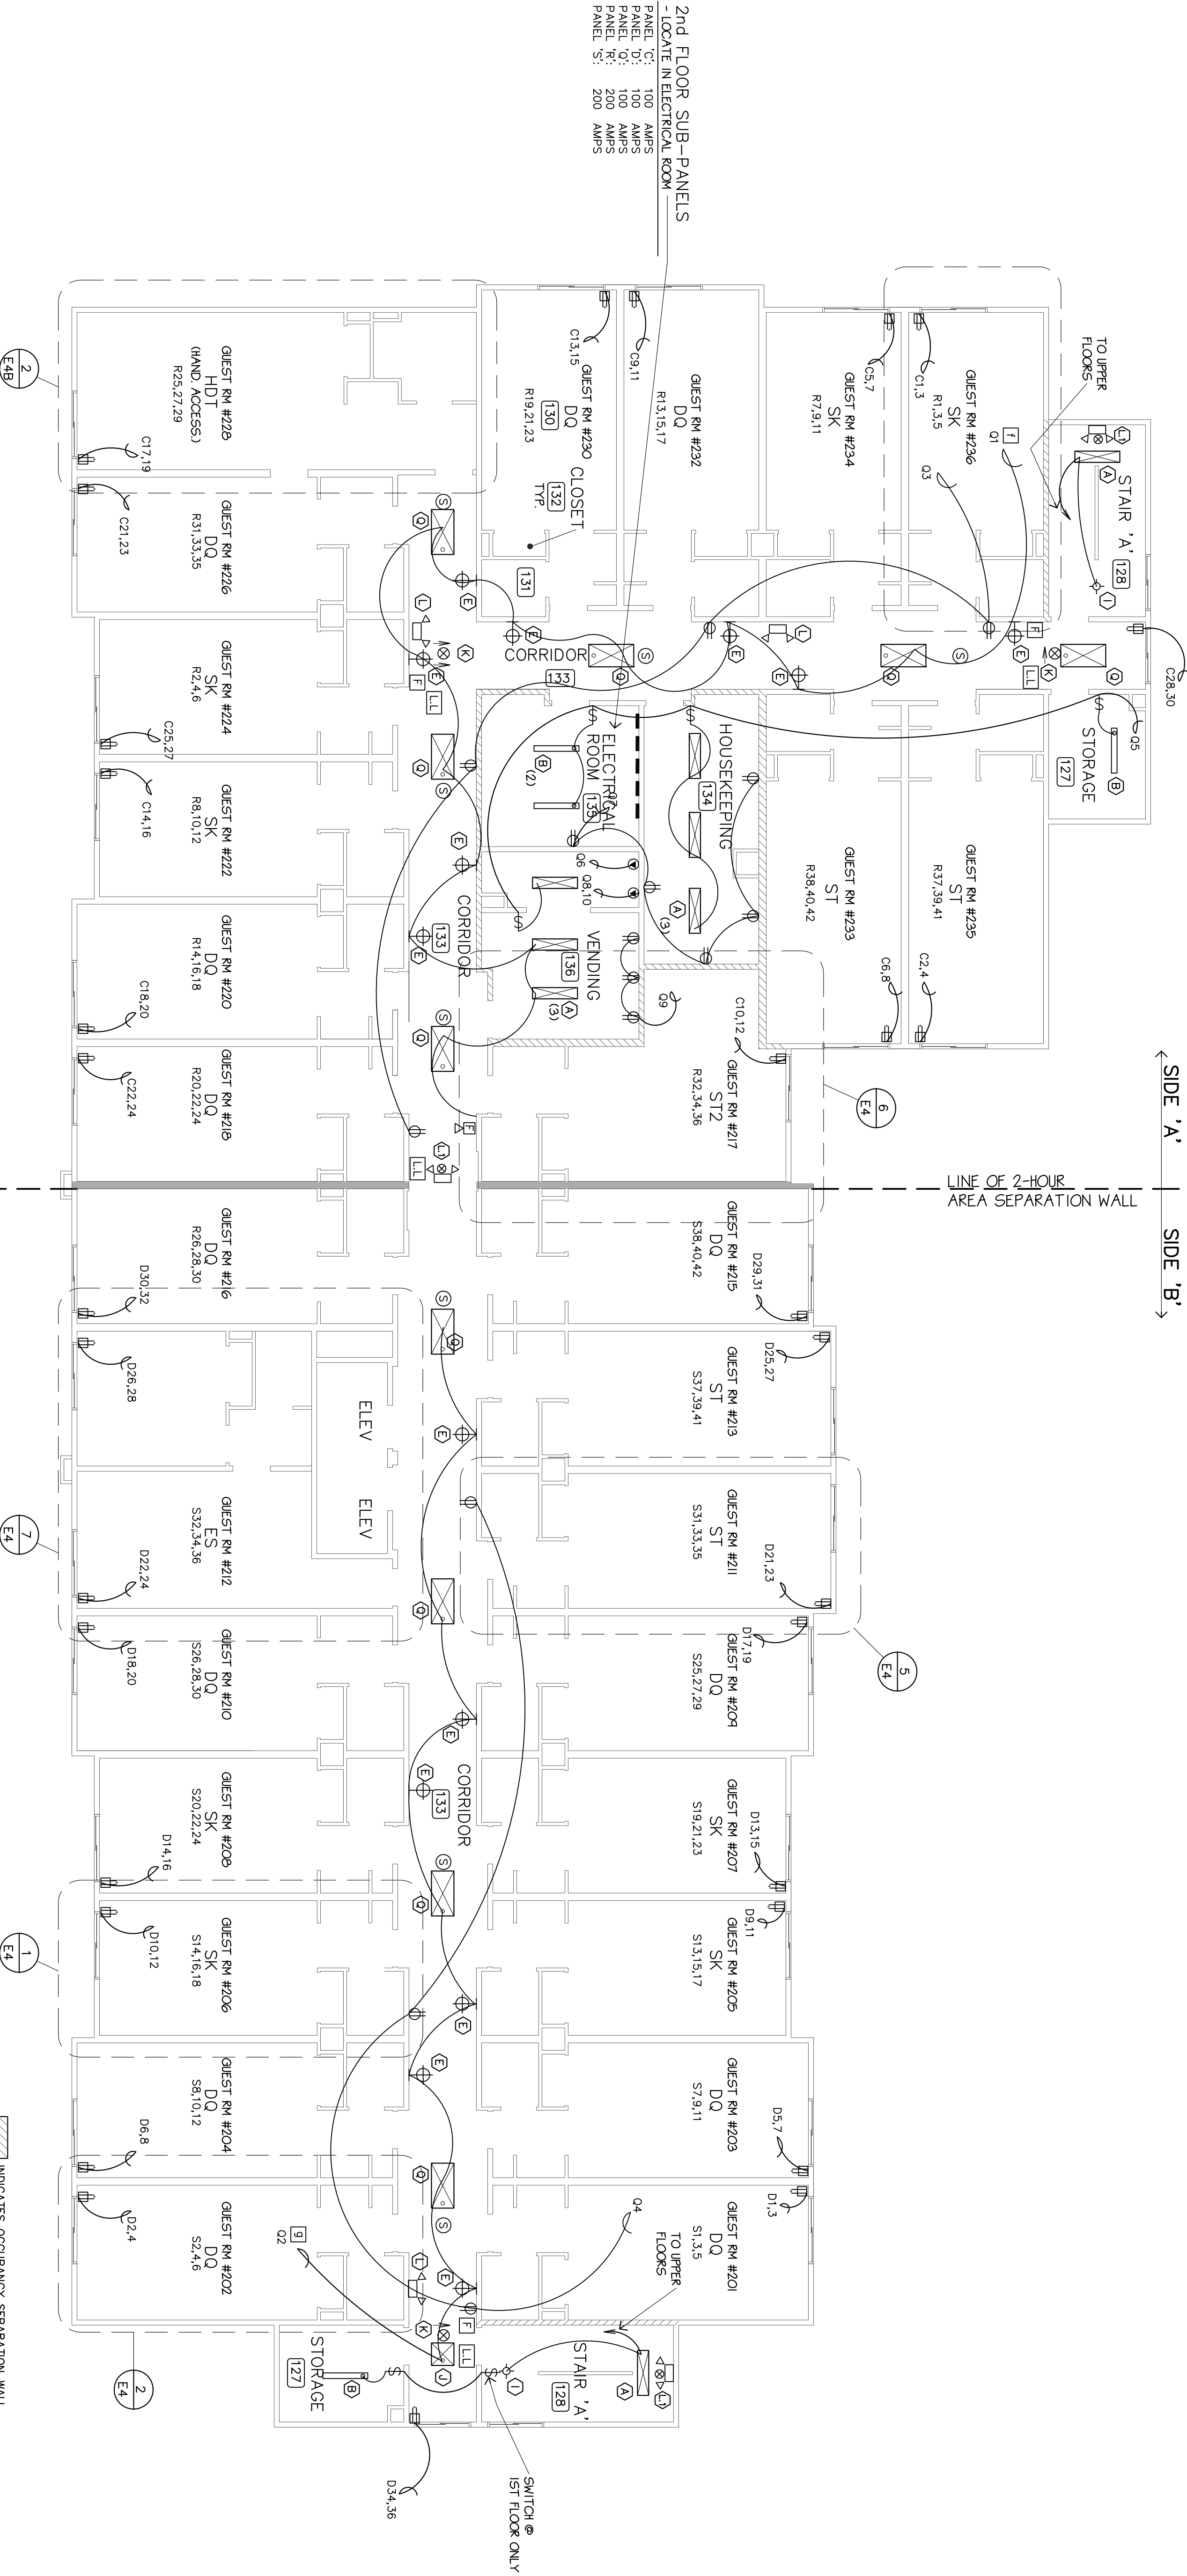

LINE OF 2-HOUR AREA SEPARATION WALL

INDICATES OCCUPANCY SEPARATION WALL
INDICATES 2-HR AREA SEPARATION WALL

SPA NOTE:
ROOMS SELECTED MANUAL SHUT OFF CONTROL MECHANISM
AND/OR OCCUPANCY SEPARATION WALLS FOR MANUFACTURERS
RECOMMENDATIONS & INSTRUCTIONS.

NOTE:
CROSS-HATCHED WALLS AND ENTIRE
FLOOR/CEILING ASSEMBLIES OF LAUNDRY ROOM, STOR. ROOMS,
AND 2ND AND 3RD & 4TH FLOOR HOUSEKEEPING, VENDING & ELECTRICAL AREAS
SHALL BE OF 1-HR FIRE RESISTIVE CONSTRUCTION FOR OCCUPANCY SEPARATION
SEPARATION PURPOSES (2-HR @ ELEVATOR SHAFT & STAIRWAY ENCLOSURES).
REFER TO ARCHITECTURAL DRAWINGS FOR DESIGNATION
& LISTING OF FIRE RATED ASSEMBLY DESIGN NUMBERS.
COORDINATE ELECTRICAL REQUIREMENTS WITH FIRE RESISTANCE
OF MATERIALS AND CONSTRUCTION.
REFER TO SHEET E4 FOR TYPICAL GUEST ROOM LAYOUTS
REFER TO SHEET E5 FOR LIGHTING SCHEDULE
REFER TO SHEET E6 & E7 FOR PANEL SCHEDULES
REFER TO SHEET E8 FOR SINGLE LINE DIAGRAMS & DETAILS