

THESE DRAWINGS, DESIGNS, SKETCHES, IDEAS & ARRANGEMENTS ARE THE SOLE & EXCLUSIVE PROPERTY OF LEE GAGE & ASSOCIATES, AND WERE CREATED AND DEVELOPED BY AND FOR THE ARCHITECT'S EXCLUSIVE USE ON AND IN CONJUNCTION WITH THE ARCHITECT'S WORK. NOTHING CONTAINED OR REPRESENTED ON THESE DOCUMENTS SHALL BE USED BY OR DISCLOSED TO ANY PERSON, FIRM OR CORPORATION FOR ANY PURPOSE, WITHOUT EXPRESSED WRITTEN CONSENT OF LEE GAGE & ASSOCIATES.

PROPOSED:
HAMPTON INN
CORPORATE DRIVE
SOUTH SAN FRANCISCO, CALIFORNIA

by _____ date _____

drawn _____


checked _____

revised _____

project no. _____

E2B

sheet
SET NO.

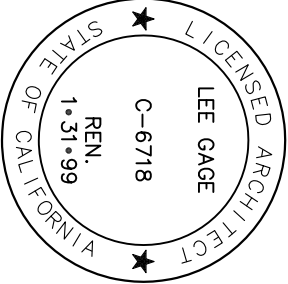


3rd & 4th FLOORS ELECTRICAL FLOOR PLAN

SCALE: 1/8"=1'-0"

INDICATES OCCUPANCY SEPARATION WALL.
INDICATES 2-HR AREA SEPARATION WALL.

SPA NOTE:
PROVIDE LABELED MANUAL SHUT-OFF CONTROL MECHANISM ACCESSIBLE TO OCCUPANTS, INSTALLED PER MANUFACTURERS RECOMMENDATIONS & INSTRUCTIONS.

NOTE:
CROSS-HATCHED WALLS AND ENTIRE FLOOR/CELLING ASSEMBLIES OF LAUNDRY ROOM, STOR. ROOMS, HALLS, AND STAIRS SHALL BE CONSIDERED AS 2-HR. FIRE RESISTIVE CONSTRUCTION FOR OCCUPANCY SEPARATION PURPOSES (2-HR. @ ELEVATOR SHAFT & STAIRWAY ENCLOSURES).
REFER TO ARCHITECTURAL DRAWINGS FOR DESIGNATION & LISTING OF FIRE RATED ASSEMBLY DESIGN NUMBERS.
COORDINATE ELECTRICAL REQUIREMENTS WITH FIRE RESISTANCE OF MATERIALS AND CONSTRUCTION.
REFER TO SHEET E1 FOR NOTES & DETAILS NOT LISTED HERE.
REFER TO SHEET E4 FOR TYPICAL GUEST ROOM LAYOUTS
REFER TO SHEET E5 FOR LIGHTING SCHEDULE
REFER TO SHEET E6 & E7 FOR PANEL SCHEDULES
REFER TO SHEET E8 FOR SINGLE LINE DIAGRAMS & DETAILS

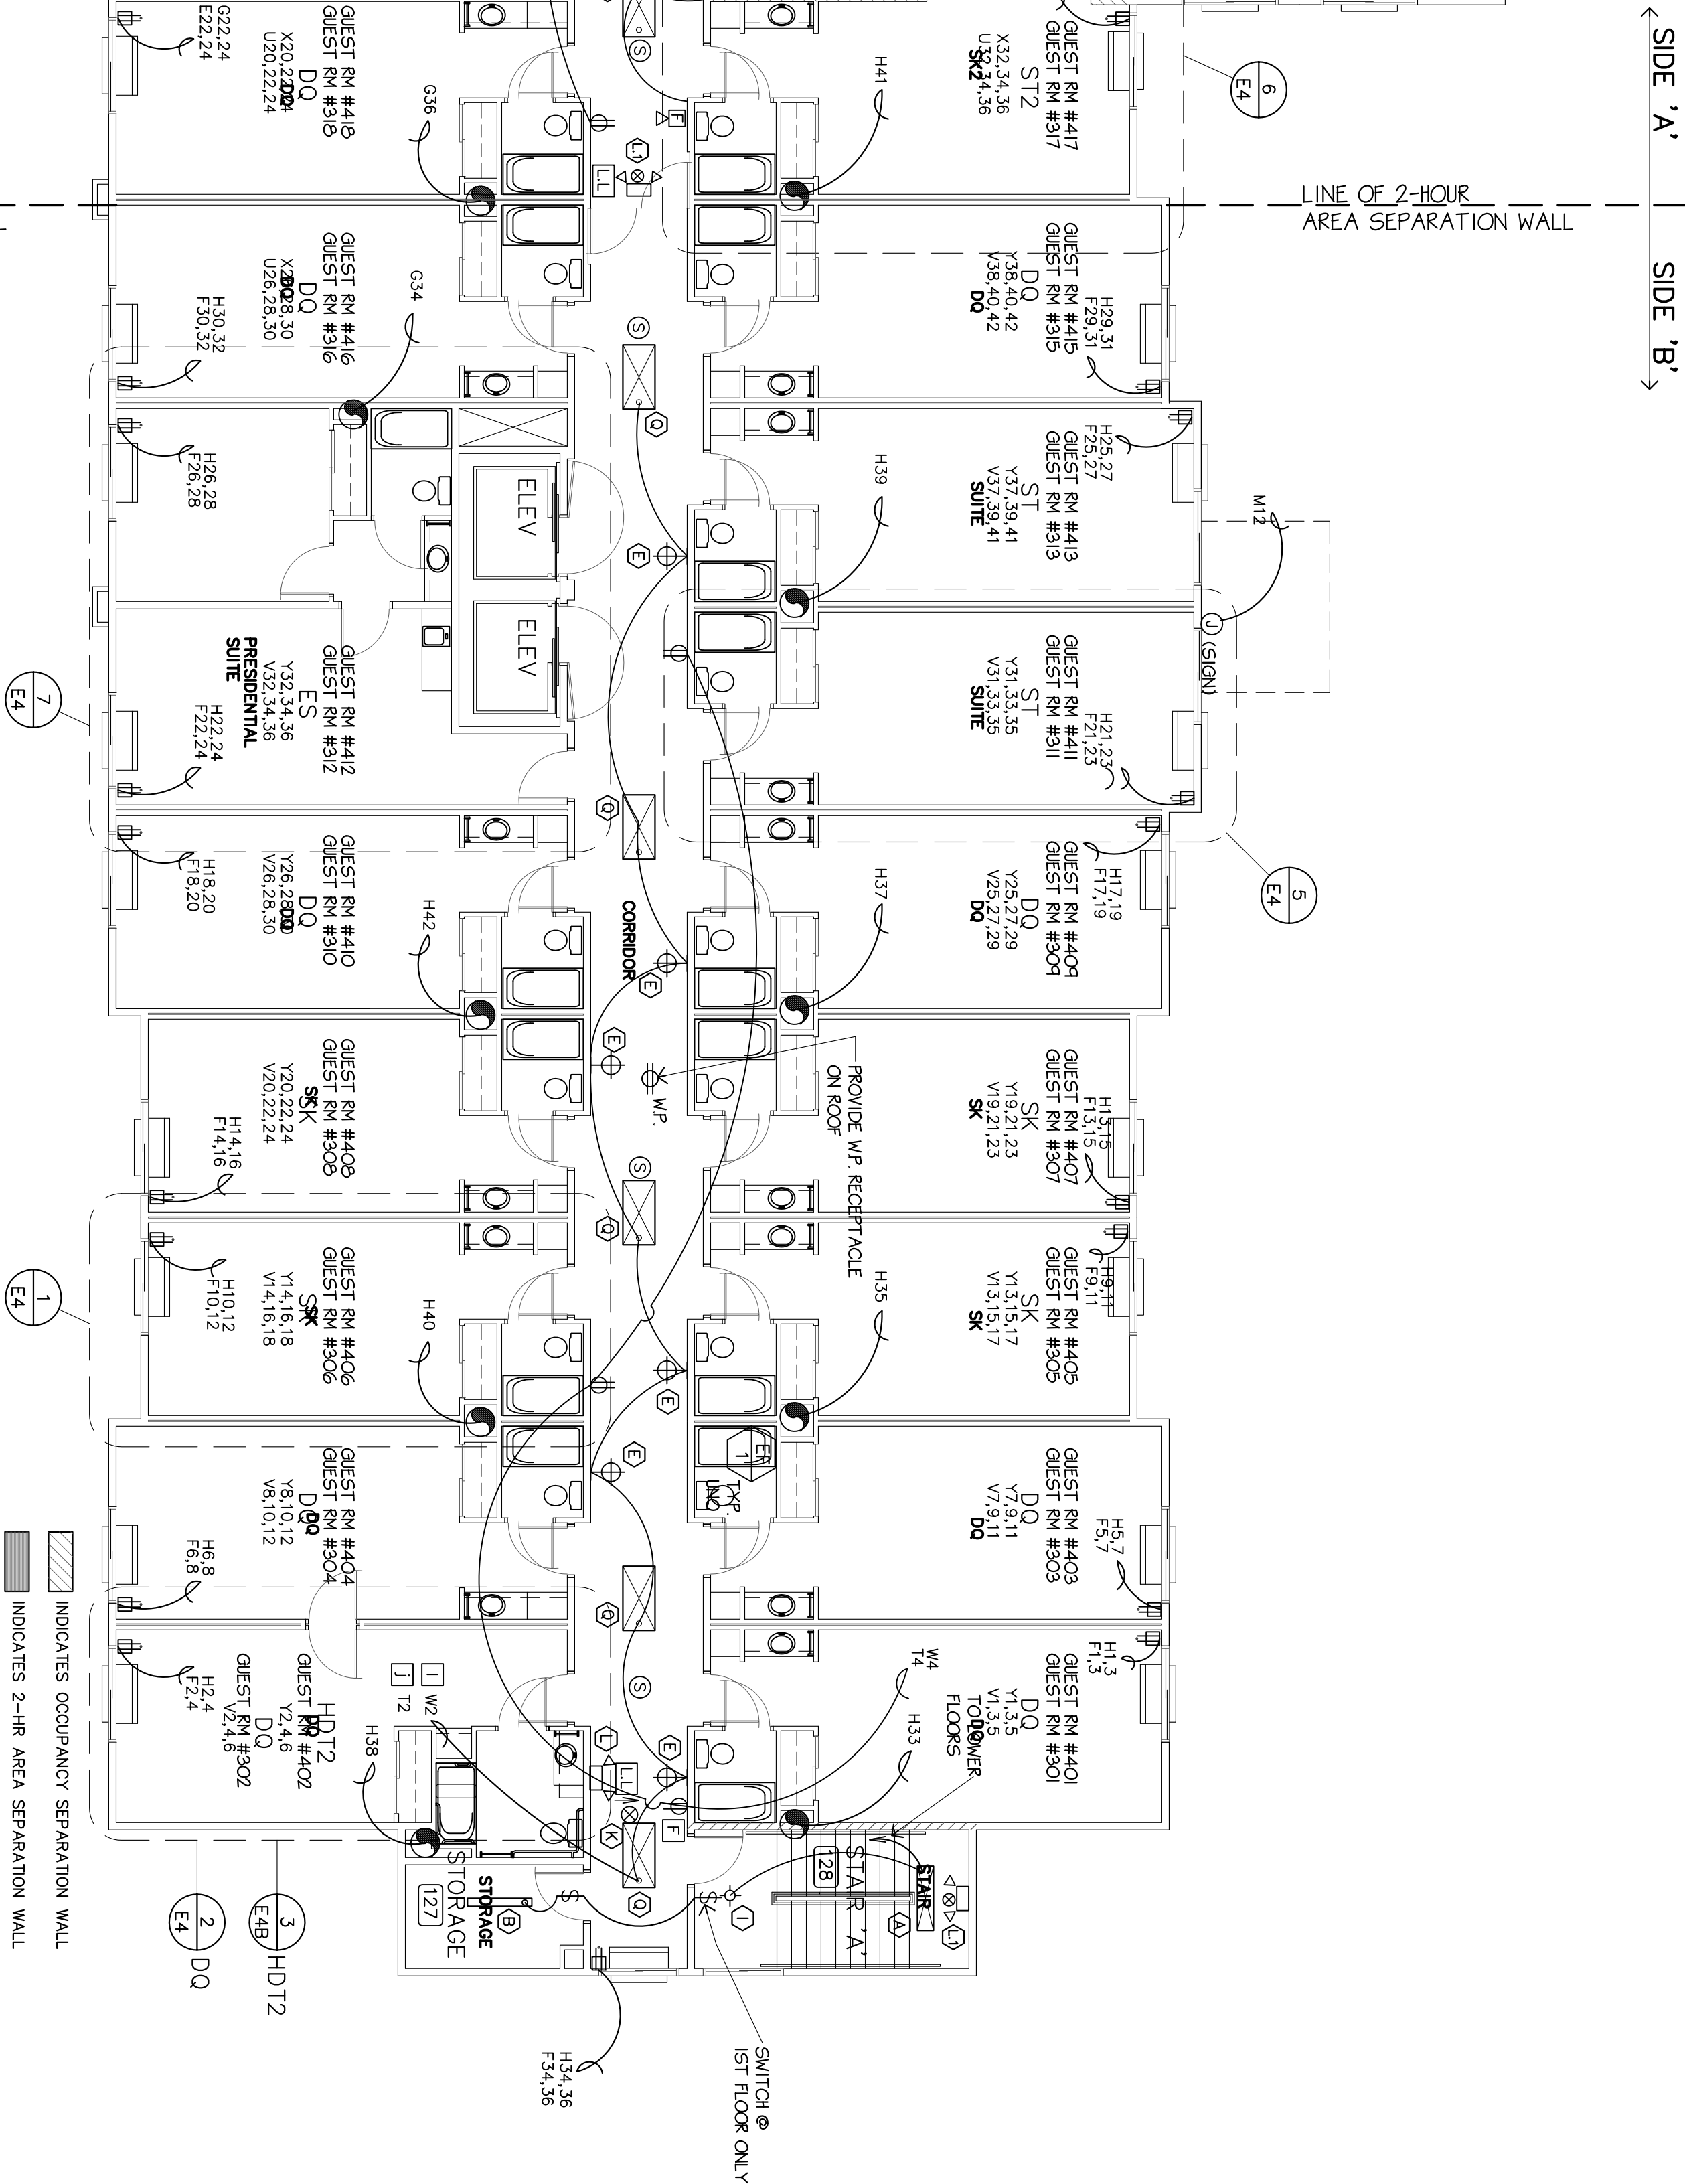

3rd FLOOR SUB-PANELS
- LOCATE IN ELECTRICAL ROOM
PANEL E: 100 AMP/5
PANEL F: 100 AMP/5
PANEL T: 100 AMP/5
PANEL U: 200 AMP/5
PANEL V: 200 AMP/5
PANEL W: 200 AMP/5
PANEL X: 200 AMP/5
PANEL Y: 200 AMP/5

4th FLOOR SUB-PANELS
- LOCATE IN ELECTRICAL ROOM
PANEL G: 100 AMP/5
PANEL H: 100 AMP/5
PANEL I: 100 AMP/5
PANEL J: 100 AMP/5
PANEL K: 200 AMP/5
PANEL L: 200 AMP/5
PANEL M: 200 AMP/5
PANEL N: 200 AMP/5
PANEL O: 200 AMP/5
PANEL P: 200 AMP/5
PANEL Q: 200 AMP/5
PANEL R: 200 AMP/5
PANEL S: 200 AMP/5
PANEL T: 200 AMP/5
PANEL U: 200 AMP/5
PANEL V: 200 AMP/5
PANEL W: 200 AMP/5
PANEL X: 200 AMP/5
PANEL Y: 200 AMP/5