



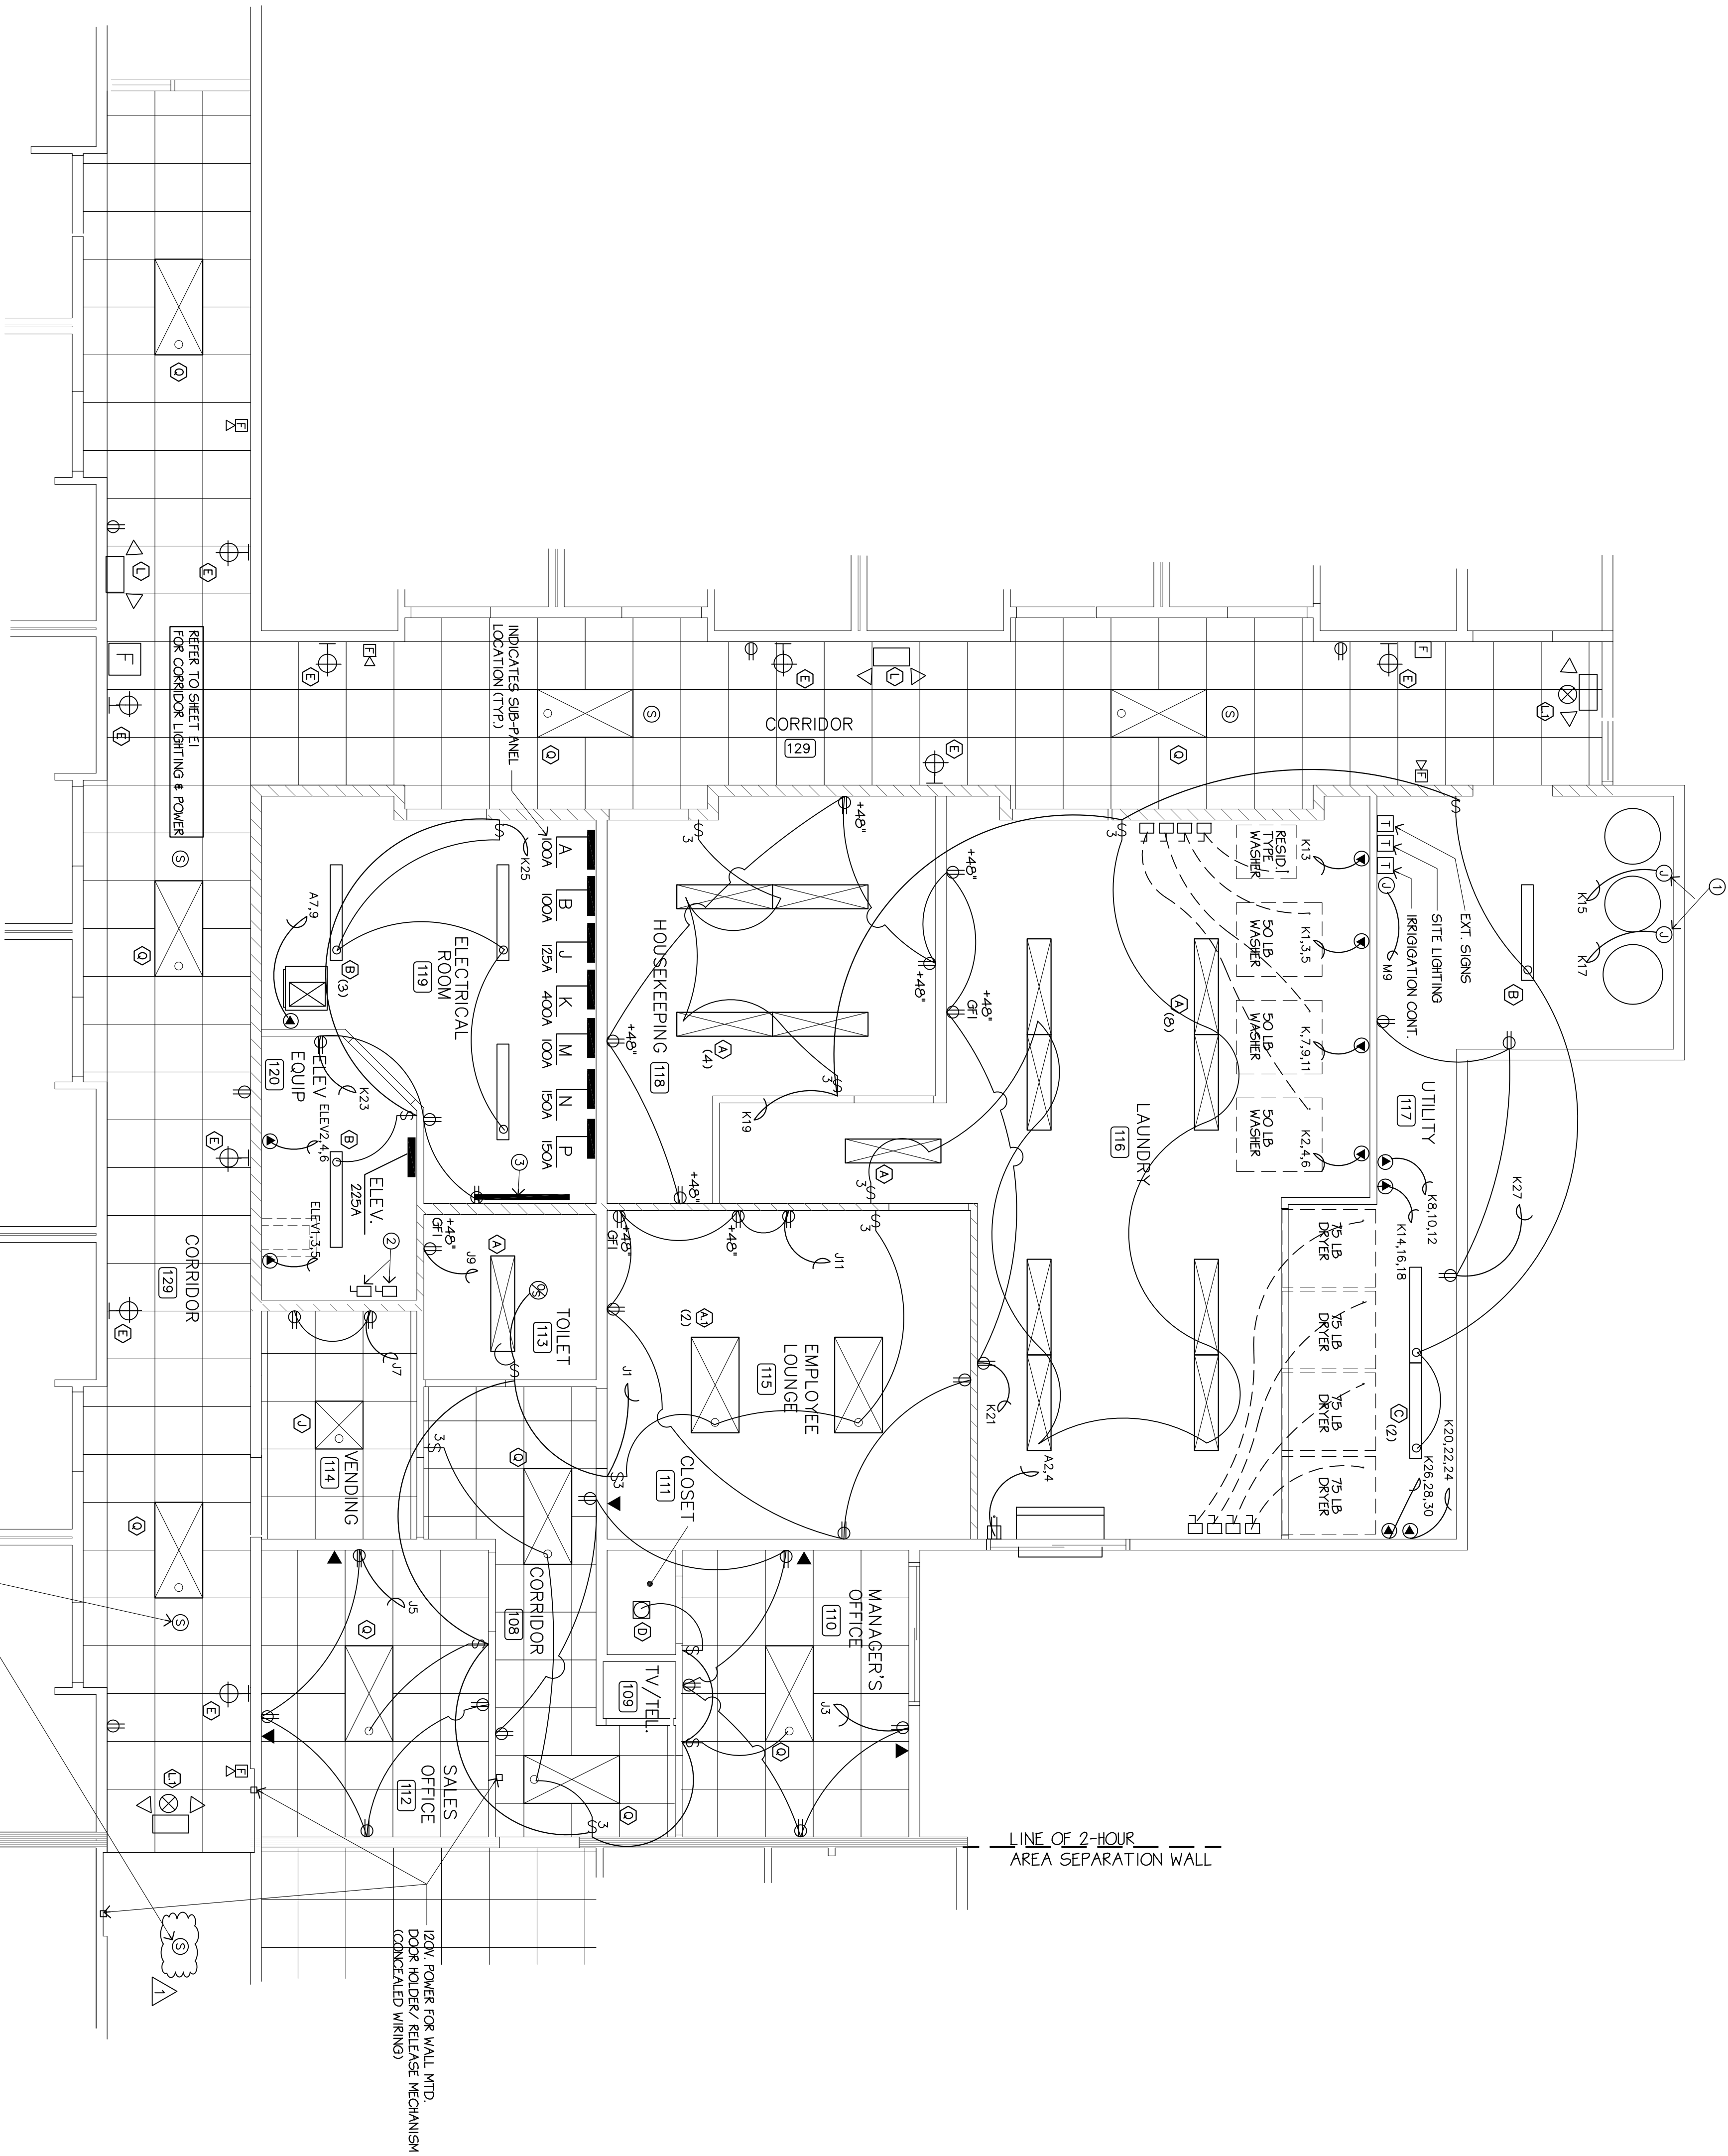

THESE SMOKE DETECTORS
ARE CONNECTED
TO A COMMON
DOOR HOLDER / RELEASE MECHANISM
TO ACTIVATE RELEASE IN CASE
OF SMOKE DETECTION

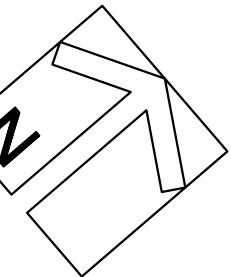


ENLARGED LAUNDRY AREA ELECTRICAL FLOOR PLAN

SCALE: 1/4"=1'-0"

- ### KEY NOTES:
- 1 PROVIDE 115V. POWER (WATER HEATERS) & PUMPS (1/4HP./2 RECD.).
- VERIFY REQUIREMENTS
 - 2 ELEVATOR DISCONNECT SWITCH
- PROVIDE 1 DISCONNECT FOR EA. ELEVATOR
FOR ELEVATOR EQUIP.
(VERIFY REQTS. W/ ELEVATOR COMPANY)
 - 3 TELEPHONE BACKBOARD LOCATION
- VERIFY POWER & GROUNDING REQTS. W/ SERVING UTILITY CO.
- NOTE:
CROSS-HATCHED WALLS AND ENTIRE FLOOR/CEILING ASSEMBLIES OF LAUNDRY ROOM, STOK. ROOMS, & 2ND FLOOR SERVICE ROOM SHALL BE OF 2-HR. FIRE-RATED CONSTRUCTION (CONC. OR CMU) WITH 1/2" Gypsum Board on both sides of separation. (2-HR. @ ELEVATOR SHAFT & STAIRWAY ENCLOSURES)
- ALL PENETRATIONS IN THESE AREAS TO BE FIRE-STOPPED WITH HILLTI #CS240 FIRE STOP SEALANT (ASTM E-814/ UL #1479)
REFER TO ARCHITECTURAL DRAWINGS FOR DESIGNATION & LISTING OF FIRE RATED ASSEMBLY DESIGN NUMBERS, COORDINATE ELECTRICAL REQUIREMENTS WITH FIRE RESISTANCE OF MATERIALS AND CONSTRUCTION.
REFER TO SHEET E1 FOR TYPICAL NOTES & REQTS. NOT LISTED HERE.
REFER TO SHEET E4 FOR TYPICAL GUEST ROOM LAYOUTS
REFER TO SHEET E5 FOR LIGHTING SCHEDULE
REFER TO SHEETS E6, E7 & E8 FOR PANEL SCHEDULES
REFER TO SHEET E9 FOR SINGLE LINE DIAGRAMS & DETAILS
- Ⓢ INDICATES OCCUPANCY SENSOR

REVISIONS PER
CITY OF SOUTH SAN FRANCISCO
2/5/98

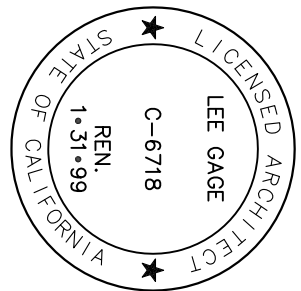

LEE GAGE C-6718

by	date
drawn	
checked	
revised	
revised	
project no.	
sheet	
E3B	

PROPOSED:
HAMPTON INN
CORPORATE DRIVE
SOUTH SAN FRANCISCO, CALIFORNIA

THESE DRAWINGS, DESIGNS, SKETCHES, IDEAS & ARRANGEMENTS ARE THE SOLE & EXCLUSIVE PROPERTY OF LEE GAGE & ASSOCIATES, AND WERE CREATED AND DEVELOPED BY AND FOR THE ARCHITECT'S EXCLUSIVE USE ON AND IN CONJUNCTION WITH THE ARCHITECT'S WORK. NOTHING CONTAINED OR REPRESENTED ON THESE DOCUMENTS SHALL BE USED BY OR DISCLOSED TO ANY PERSON, FIRM OR CORPORATION FOR ANY PURPOSE WITHOUT EXPRESSED WRITTEN CONSENT OF LEE GAGE & ASSOCIATES.

lee gage & associates

architects • engineers • planners

7636 n. ingram suite 107 fresno, california 93711 phone (209) 439-2222

© LEE GAGE & ASSOC.