



- NOTES:
1. PROVIDE ATIC DRAFT STOPS AS REQ'D.
 2. SPRINKLER SYSTEM IN ATIC BY FIRE PROTECTION CONTRACTOR
 3. CONTRACTOR TO PROVIDE SHOP DRAWINGS FOR APPROVAL PRIOR TO FABRICATION.

PROJECT NAME:

Hampton Inn
Airport
Monkhouse Drive
Shreveport, LA

SHEET TITLE:

PROJECT NO.
20008


DRAWN BY: CHECKED BY: S

DATE:
12/27/01

LATEST REVISION:

SHEET NUMBER:

55

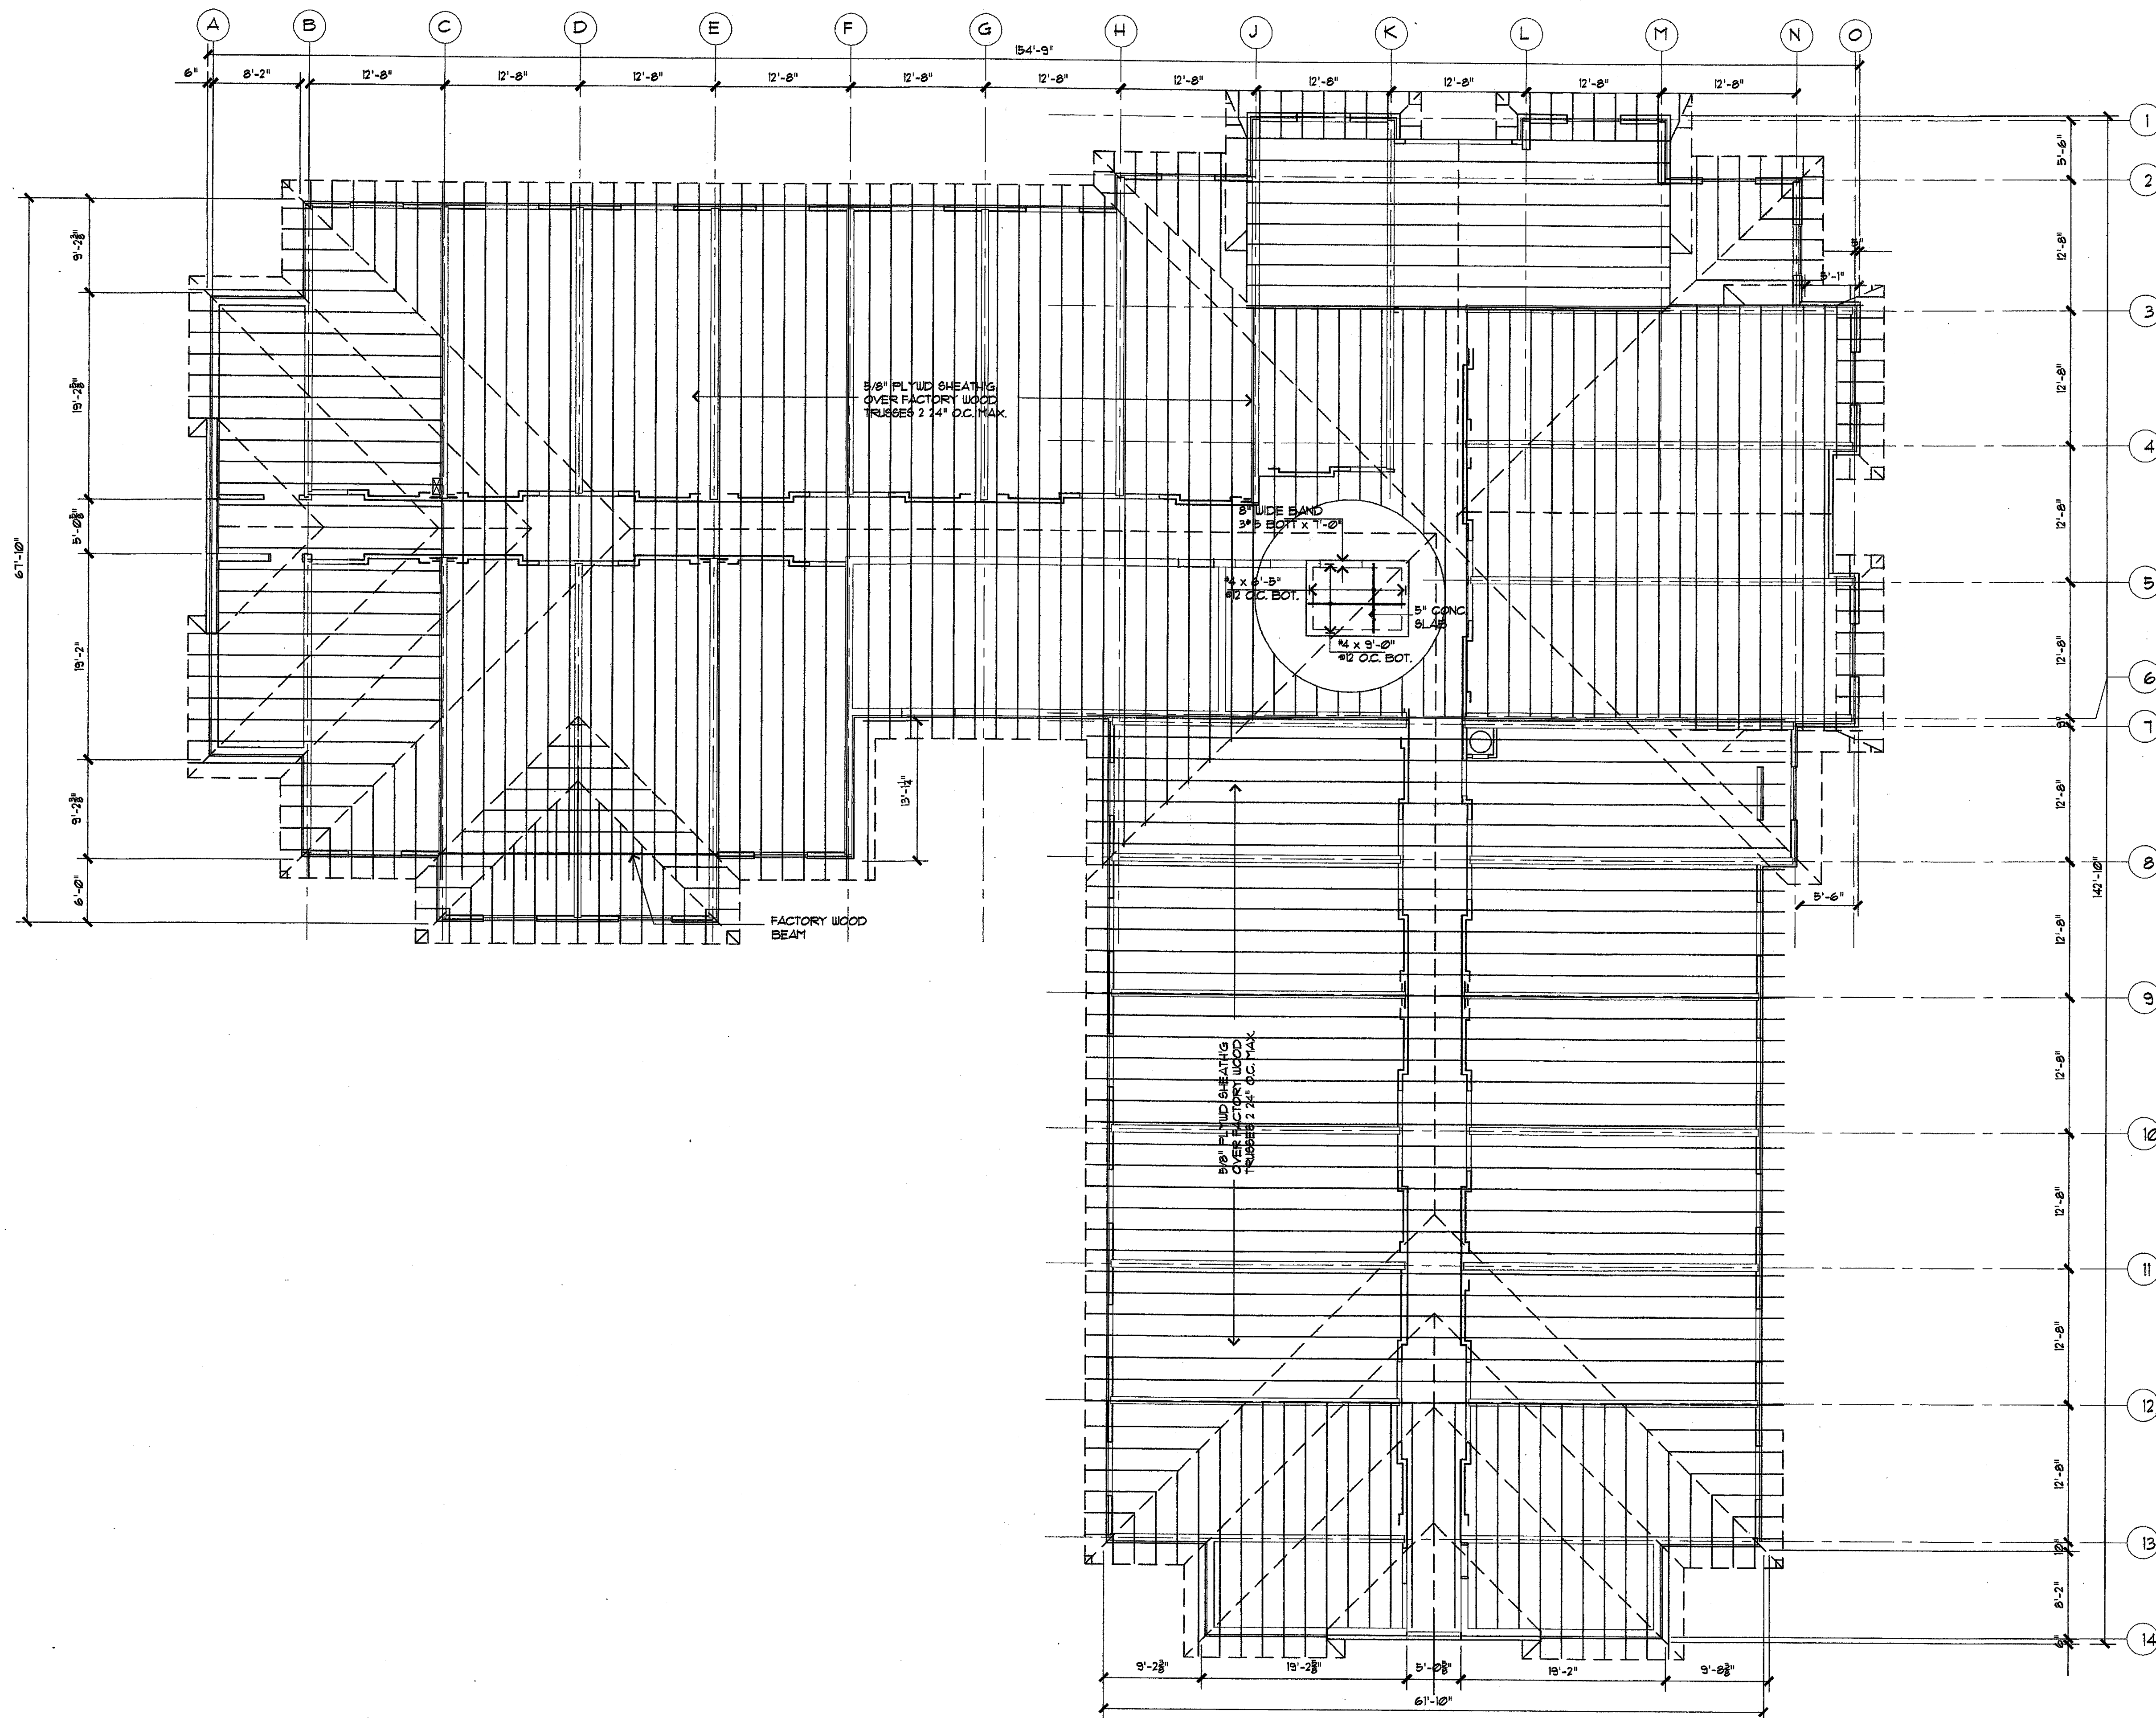

1 ROOF FRAMING PLAN

LINTEL SCHEDULE:
L1 8" U-BLOCK W/2 #5 BOT.
L2 8" U-BLOCK W/2 #6 BOT.
 BEAR LINTELS 8" MIN. EA. END