


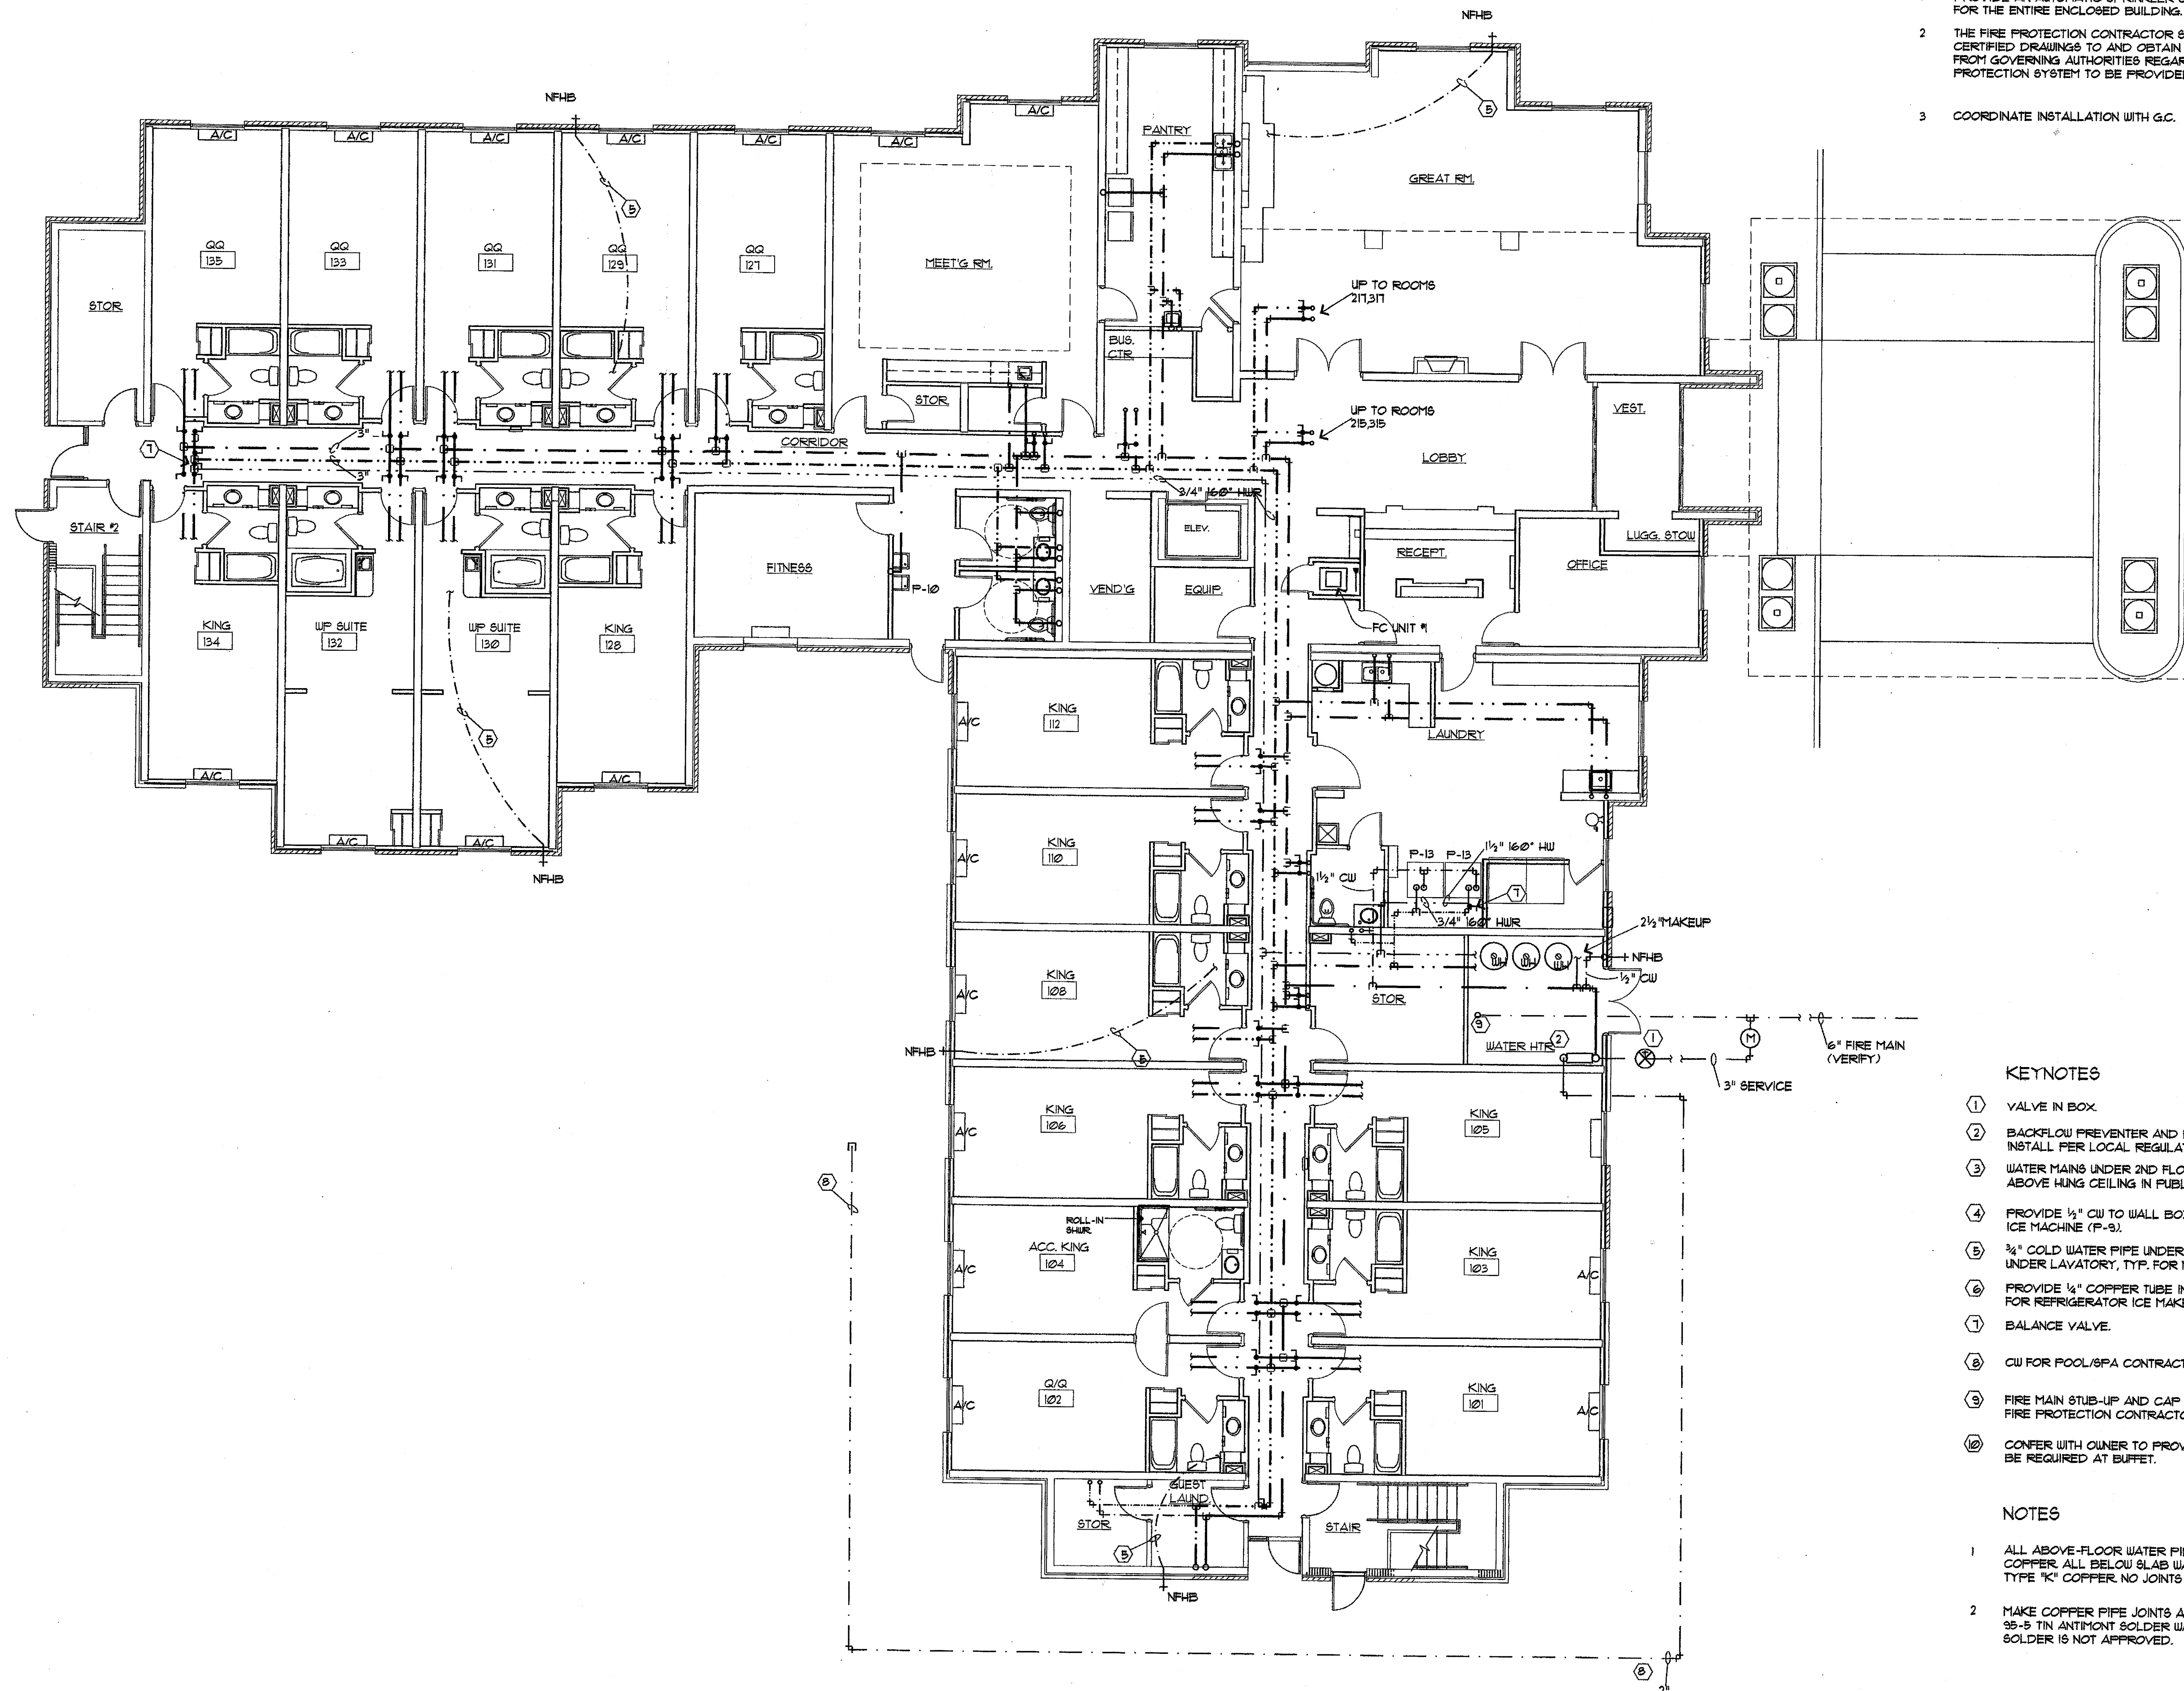

FIRE PROTECTION SYSTEM


1. PROVIDE AN AUTOMATIC SPRINKLER SYSTEM (NFPA 13) FOR THE ENTIRE ENCLOSED BUILDING.
2. THE FIRE PROTECTION CONTRACTOR SHALL SUBMIT CERTIFIED DRAWINGS TO AND OBTAIN APPROVALS FROM GOVERNING AUTHORITIES REGARDING THE FIRE PROTECTION SYSTEM TO BE PROVIDED.
3. COORDINATE INSTALLATION WITH G.C.

KEYNOTES

1. VALVE IN BOX.
2. BACKFLOW PREVENTER AND PREY BRACED ON WALL. INSTALL PER LOCAL REGULATIONS.
3. WATER MAINS UNDER 2ND FLOOR ASSEMBLY, AND ABOVE HUNG CEILING IN PUBLIC AREAS, TYP.
4. PROVIDE 1/2" CU TO WALL BOX WITH VALVE FOR ICE MACHINE (P-3).
5. 3/4" COLD WATER PIPE UNDER FLOOR FROM VALVE UNDER LAVATORY, TYP. FOR NFUB.
6. PROVIDE 1/4" COPPER TUBE IN BOX FROM SINK FOR REFRIGERATOR ICE MAKER.
7. BALANCE VALVE.
8. CU FOR POOL/SPA CONTRACTOR USE. VERIFY SIZE.
9. FIRE MAIN STUB-UP AND CAP EXTENSION BY FIRE PROTECTION CONTRACTOR.
10. CONFER WITH OWNER TO PROVIDE WATER AS MAY BE REQUIRED AT BUFFET.

NOTES

1. ALL ABOVE-FLOOR WATER PIPING SHALL BE TYPE "L" COPPER. ALL BELOW SLAB WATER PIPING SHALL BE TYPE "K" COPPER. NO JOINTS BELOW SLAB.
2. MAKE COPPER PIPE JOINTS ABOVE FLOOR USING 95-5 TIN ANTIMONY SOLDER W/FLUX. LEAD SOLDER IS NOT APPROVED.

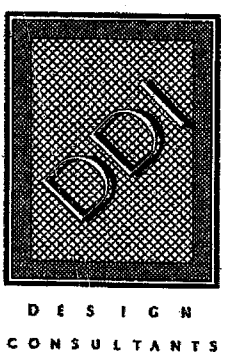

Richard Molenaar
ARCHITECT

PROJECT NAME:

Holiday Inn Express
HOTEL & SUITES
Underwood Road
Vicksburg, MS 38671

SHEET TITLE:

PROJECT NO.
01005

LATEST REVISION:

DRAWN BY: CHECKED BY: SHEET NUMBER:

DATE:
6/3/02

P2

1 GROUND FLOOR PLAN-WATER
1/8"=1'-0"

AX-X-X