


Richard Molenaar
ARCHITECT

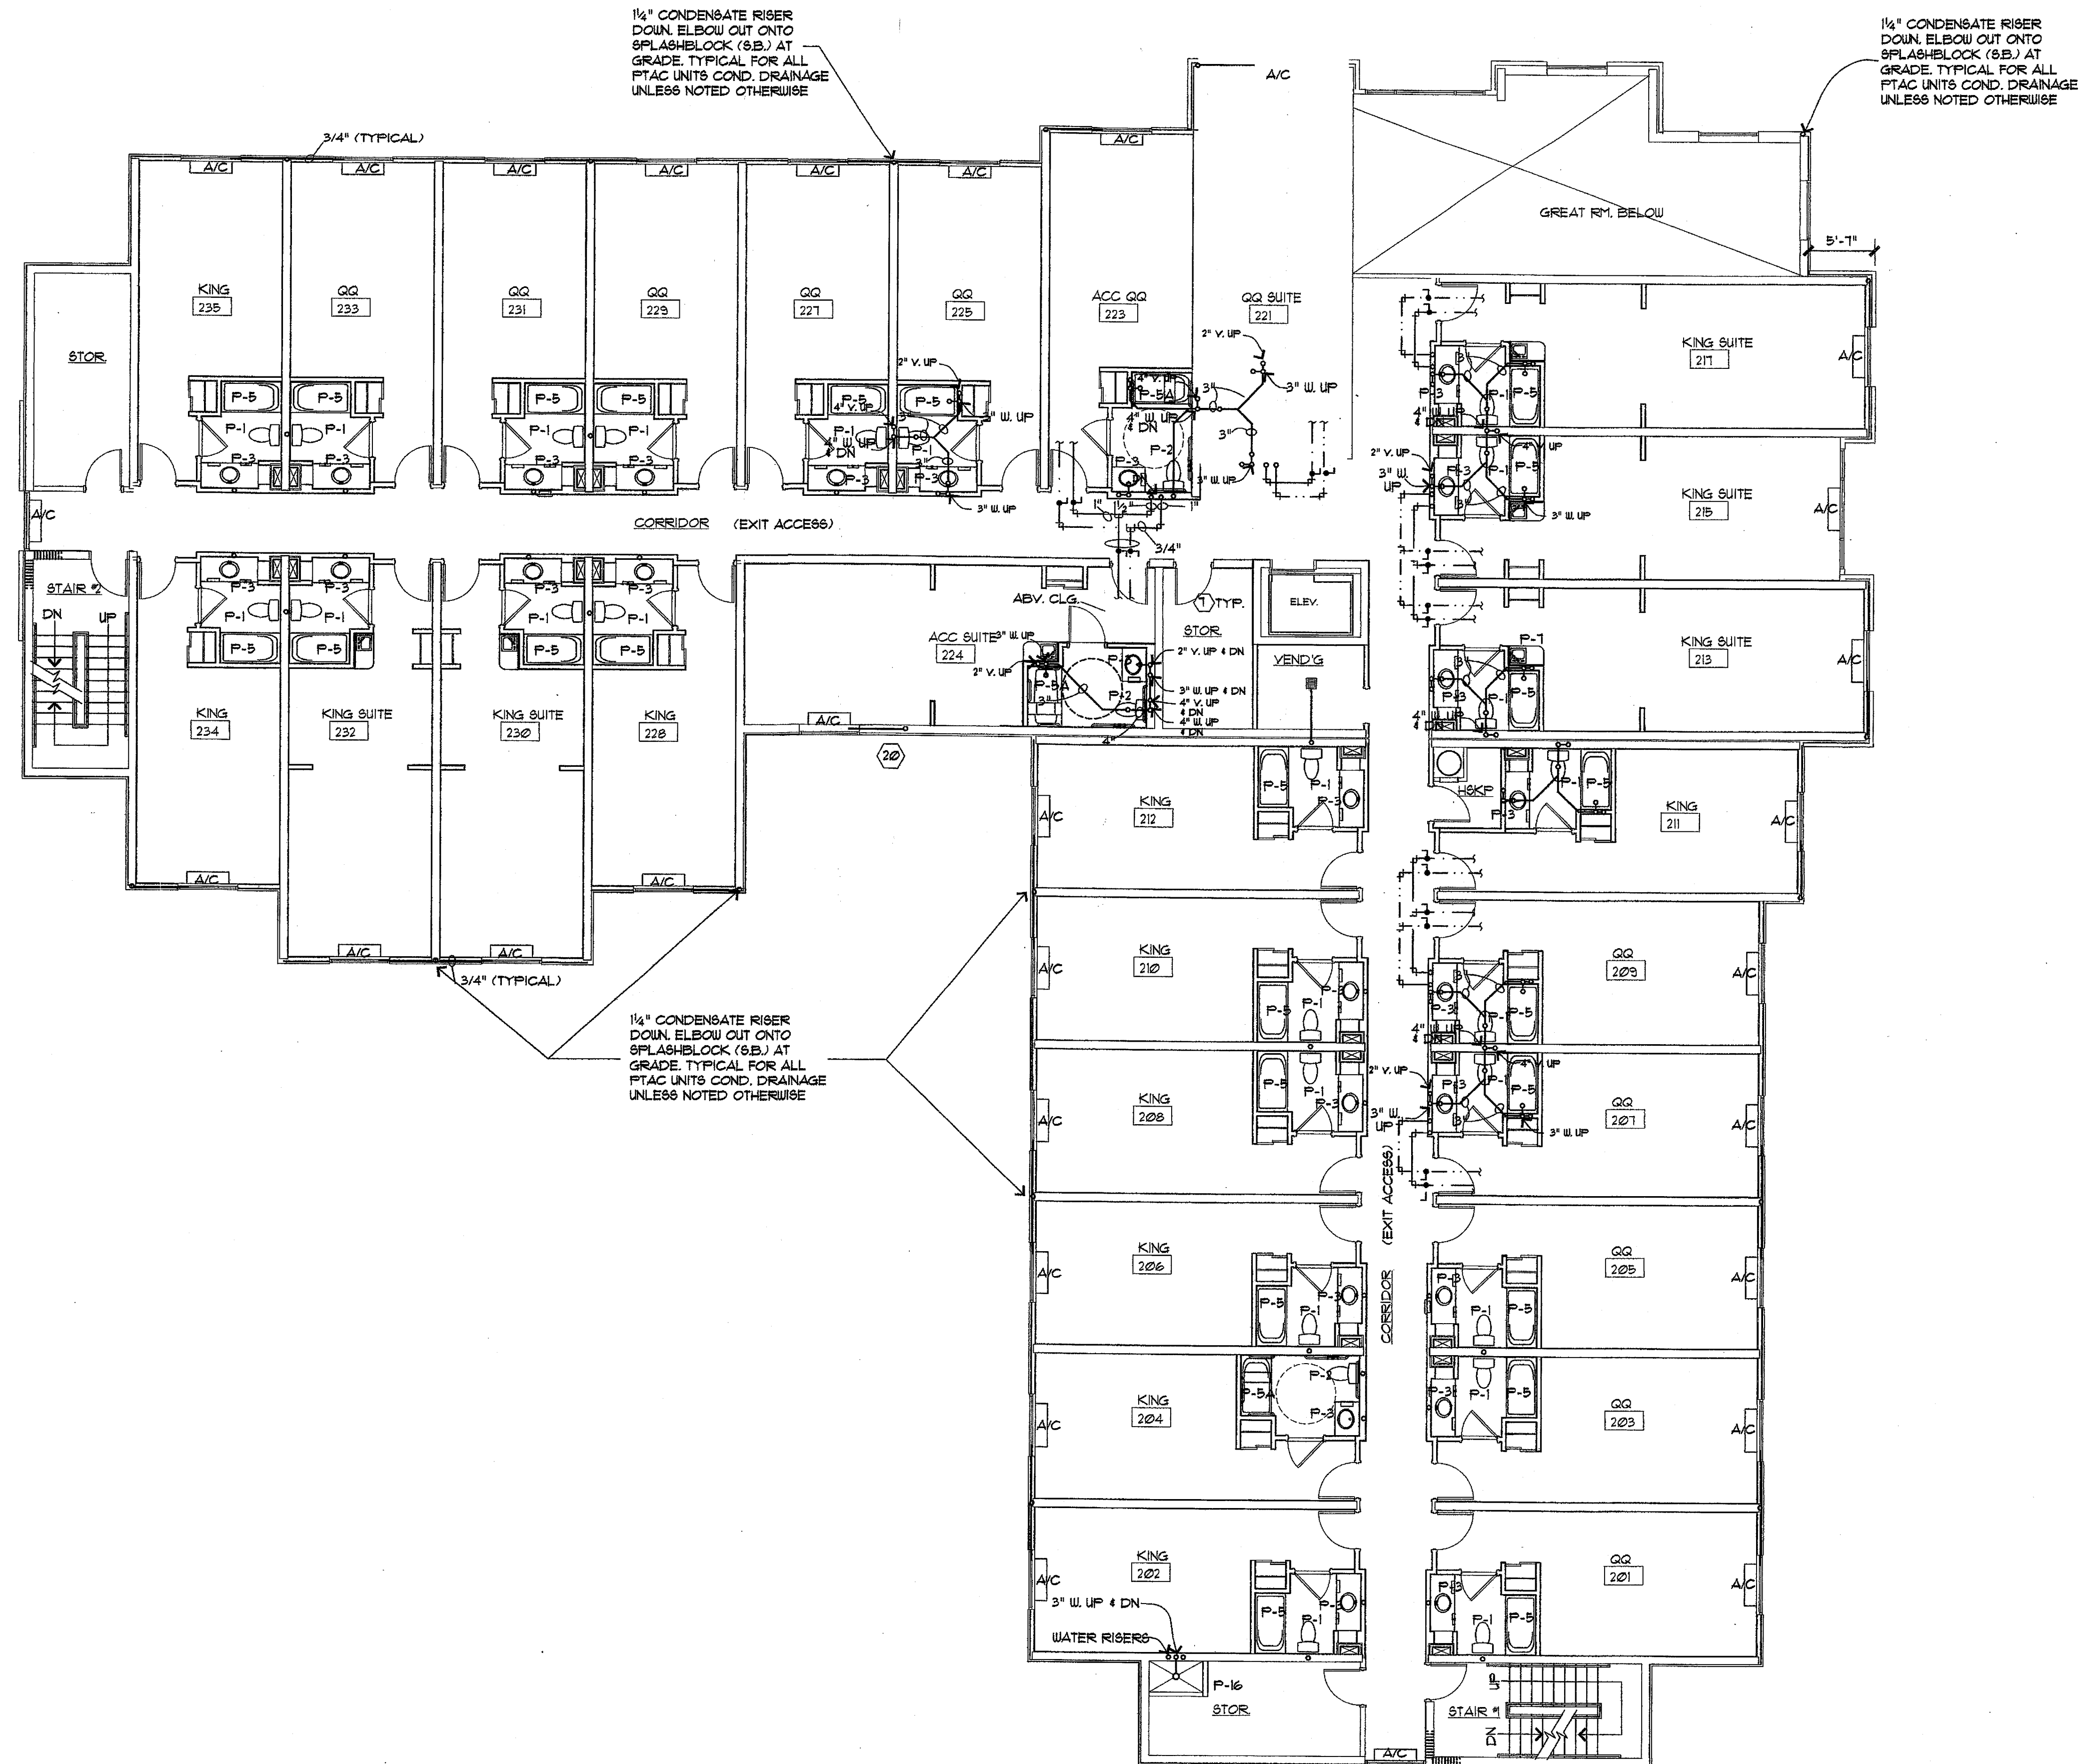

1 2nd FLOOR PLUMBING PLAN

1/8" = 1'-0"

KING RMS	DEL. QUEEN RMS	SUITES	TOTAL
9	12	1	28

PROJECT NAME:

Holiday Inn Express
HOTEL & SUITES
Underwood Road
Vicksburg, MS 38671

SHEET TITLE:

PROJECT NO.
01005

LATEST REVISION:

DRAWN BY: CHECKED BY: SHEET NUMBER:

DATE:
05/11/02

P3