



Richard Molenaar
ARCHITECT

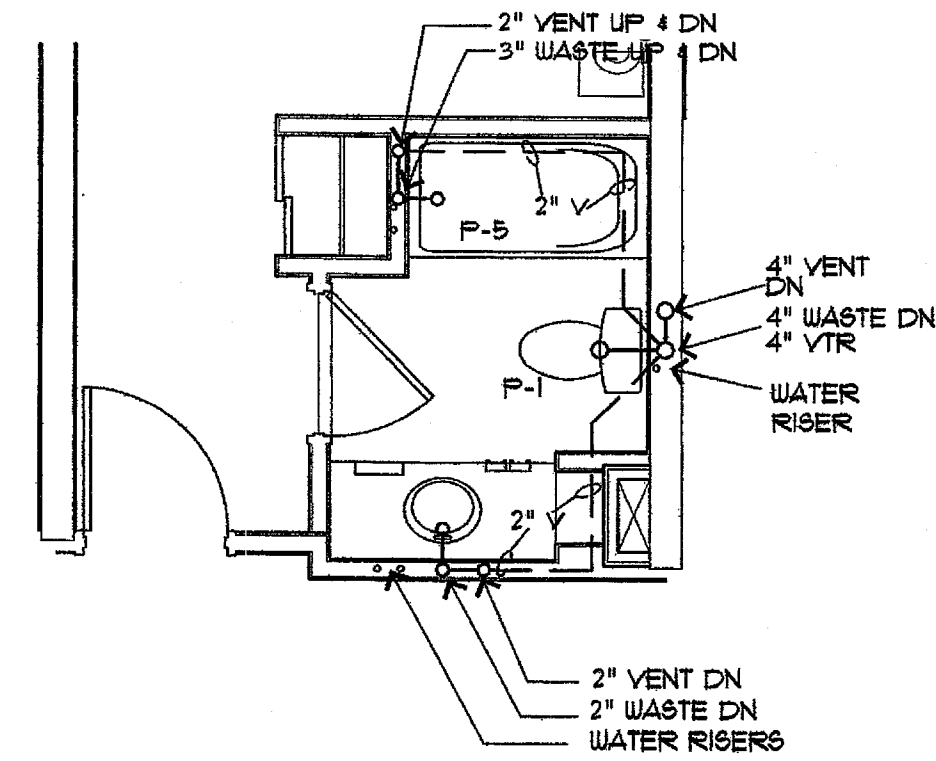


9 3rd FLR. SINGLE RM
1/4" = 1'-0" AX-X-X

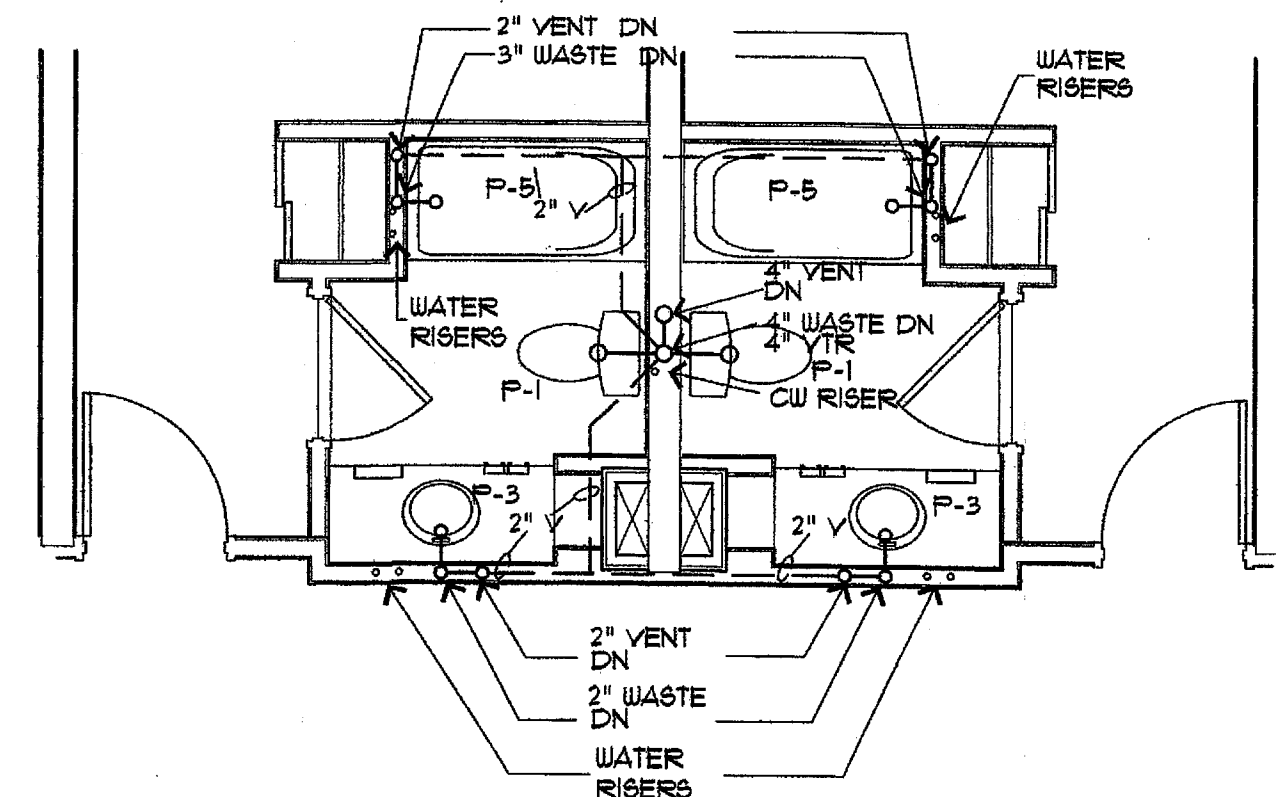


10 3rd FLR. BACK TO BACK RMS.
1/4" = 1'-0" AX-X-X


ALL WATER RISERS 1/2" (3rd FLR)

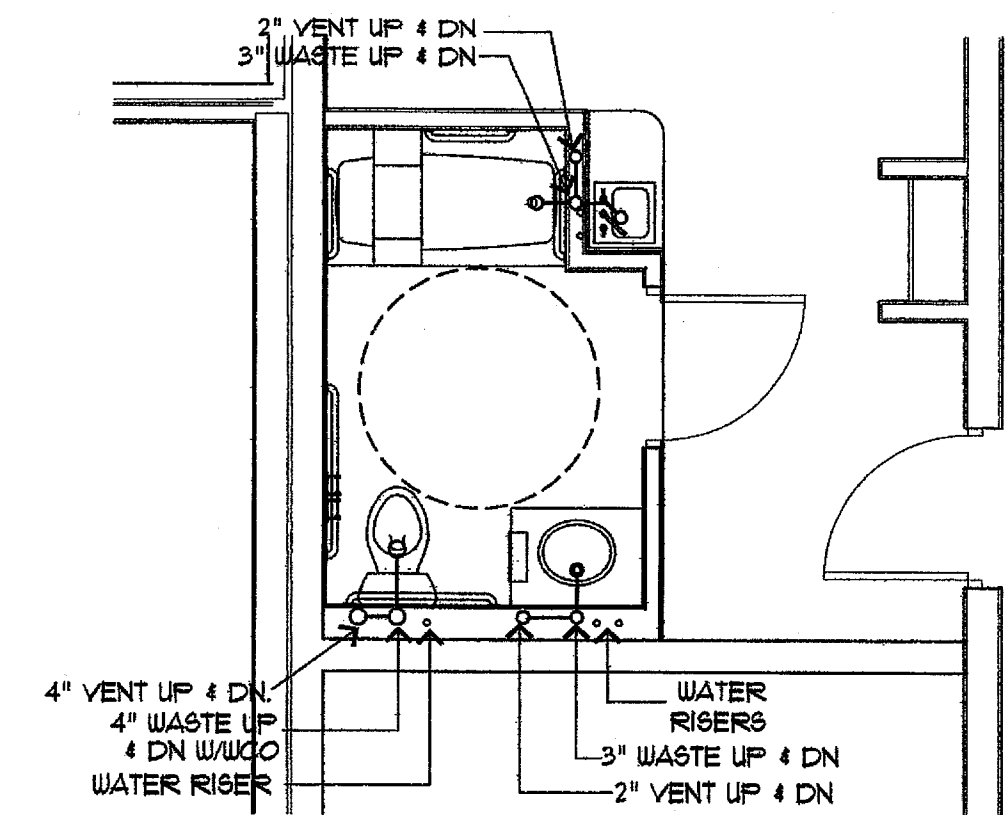


12 ACCESS. SUITE
1/4" = 1'-0" AX-X-X

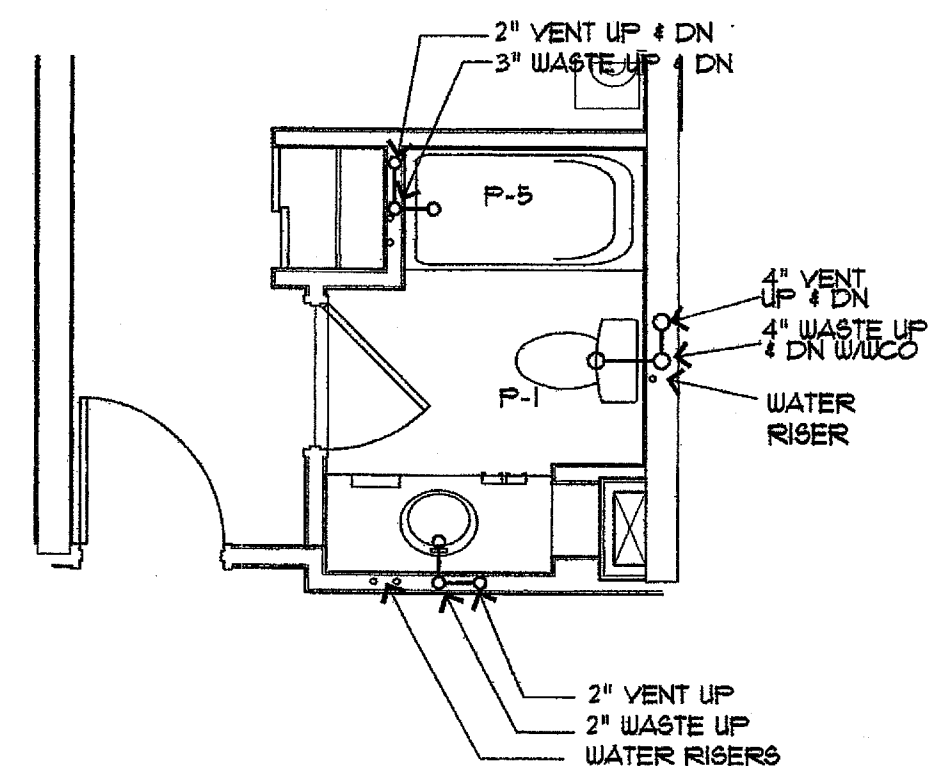

5 TYP. FLR. SINGLE RM
1/4" = 1'-0" AX-X-X

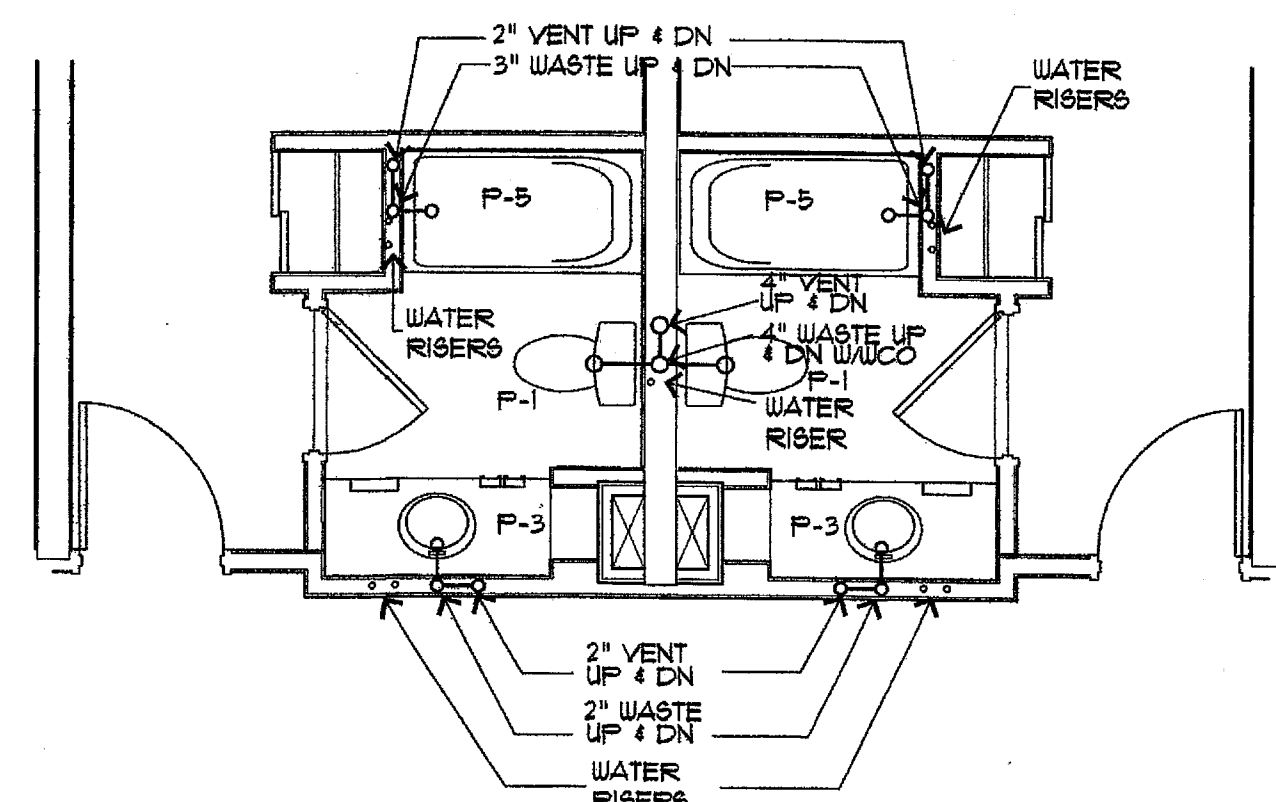


6 TYP. FLR. BACK TO BACK RMS.
1/4" = 1'-0" AX-X-X

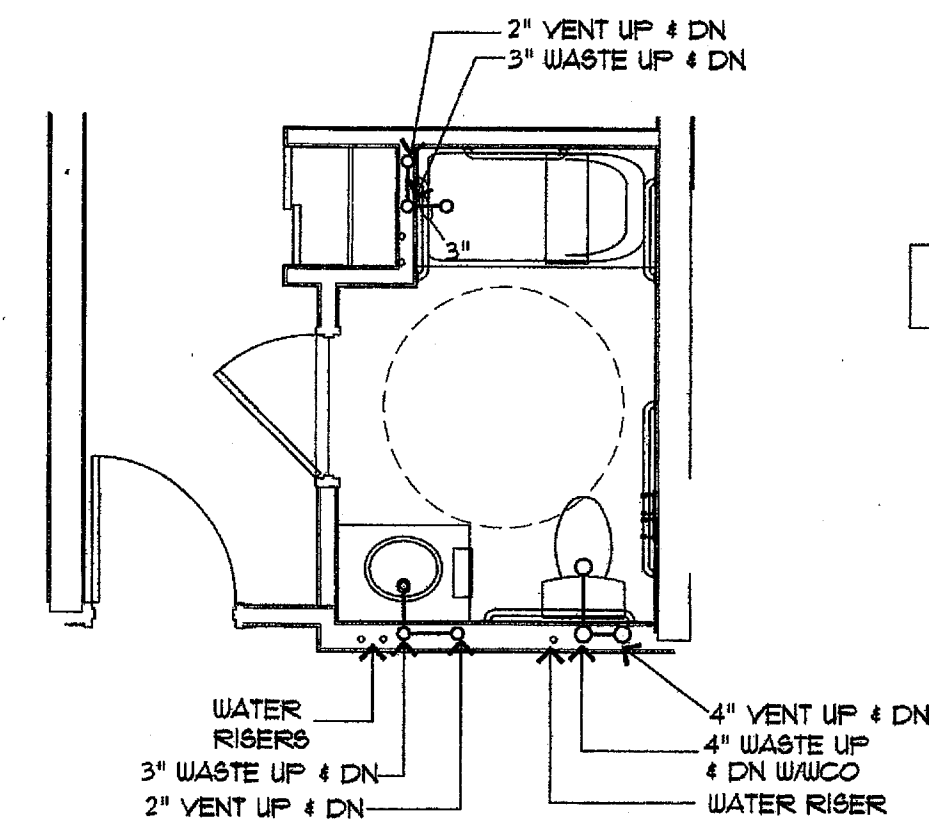


ALL WATER RISERS (2nd FLR)
3/4" DN, 1/2" UP TO 3rd

7 TYP. FLR. ACCESS. RM
1/4" = 1'-0" AX-X-X

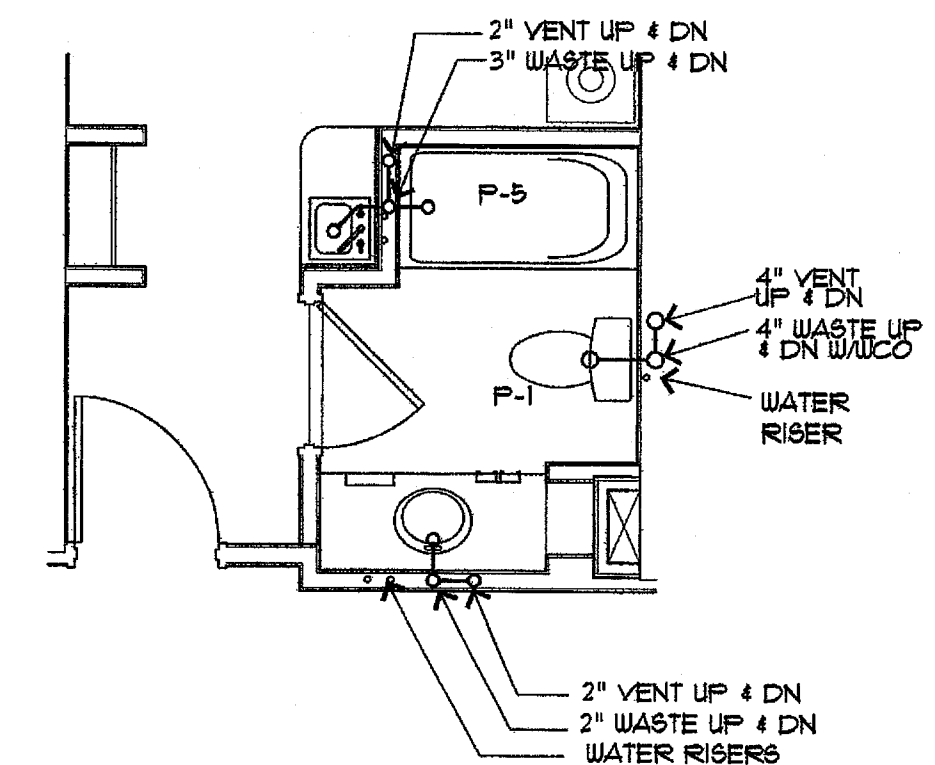


8 TYP. FLR. SUITE
1/4" = 1'-0" AX-X-X

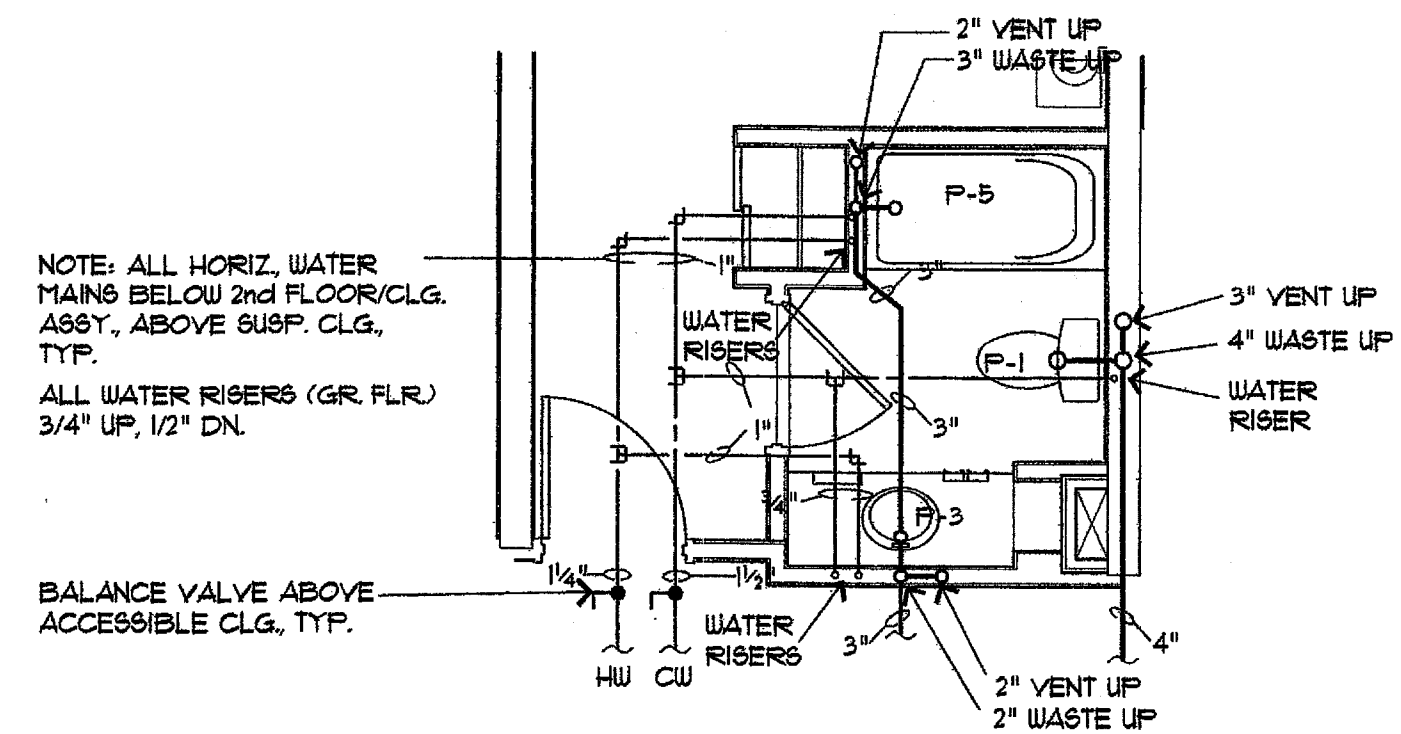


NOTE: ALL HORIZ. WATER
MAINS BELOW 2nd FLOOR/CLG.
ASST. ABOVE SUSP. CLG.
TYP.
ALL WATER RISERS (GR. FLR.)
3/4" UP, 1/2" DN.
BALANCE VALVE ABOVE
ACCESSIBLE CLG. TYP.


1 GR. FLR. SINGLE RM
1/4" = 1'-0" AX-X-X

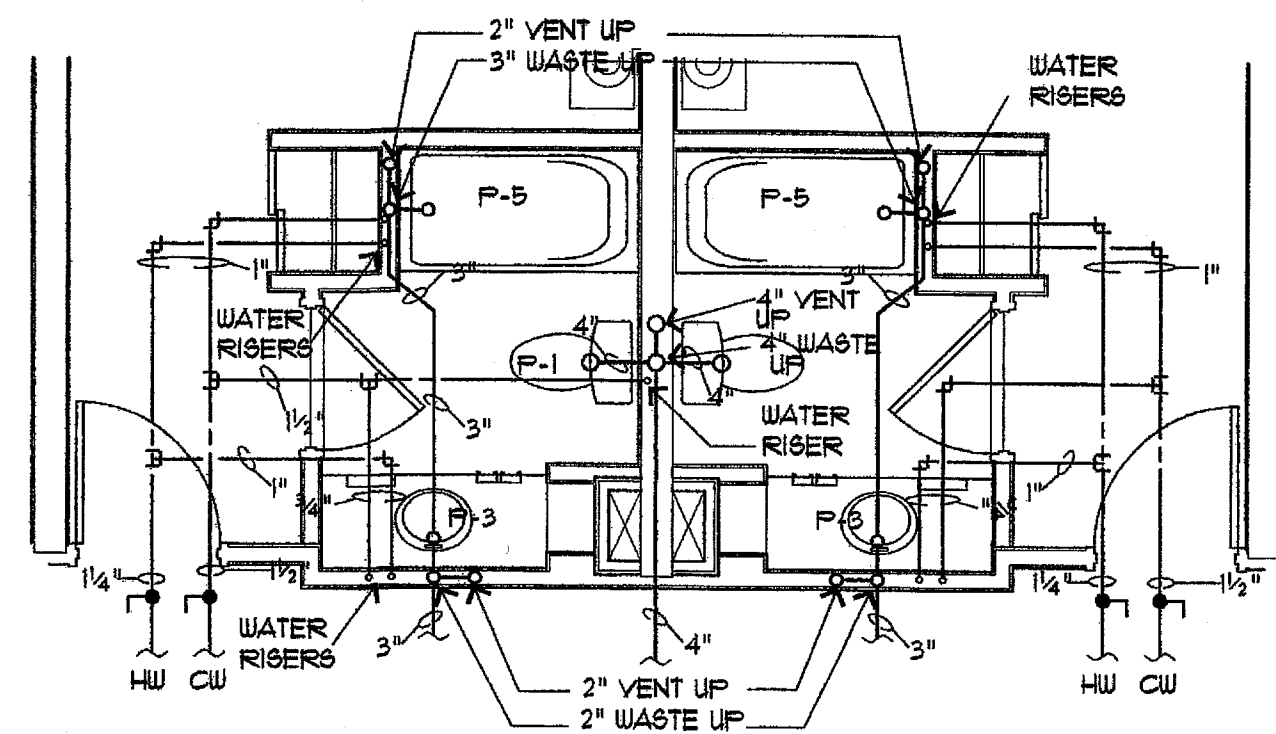

2 GR. FLR. BACK TO BACK RMS.
1/4" = 1'-0" AX-X-X

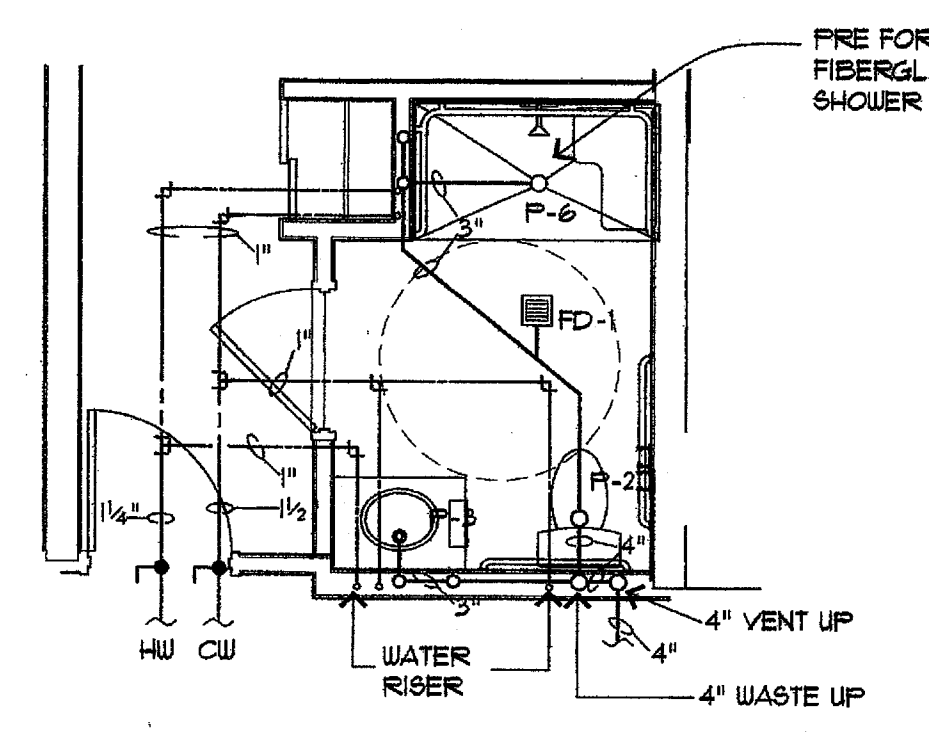

3 GR. FLR. ACCESS. RM
1/4" = 1'-0" AX-X-X

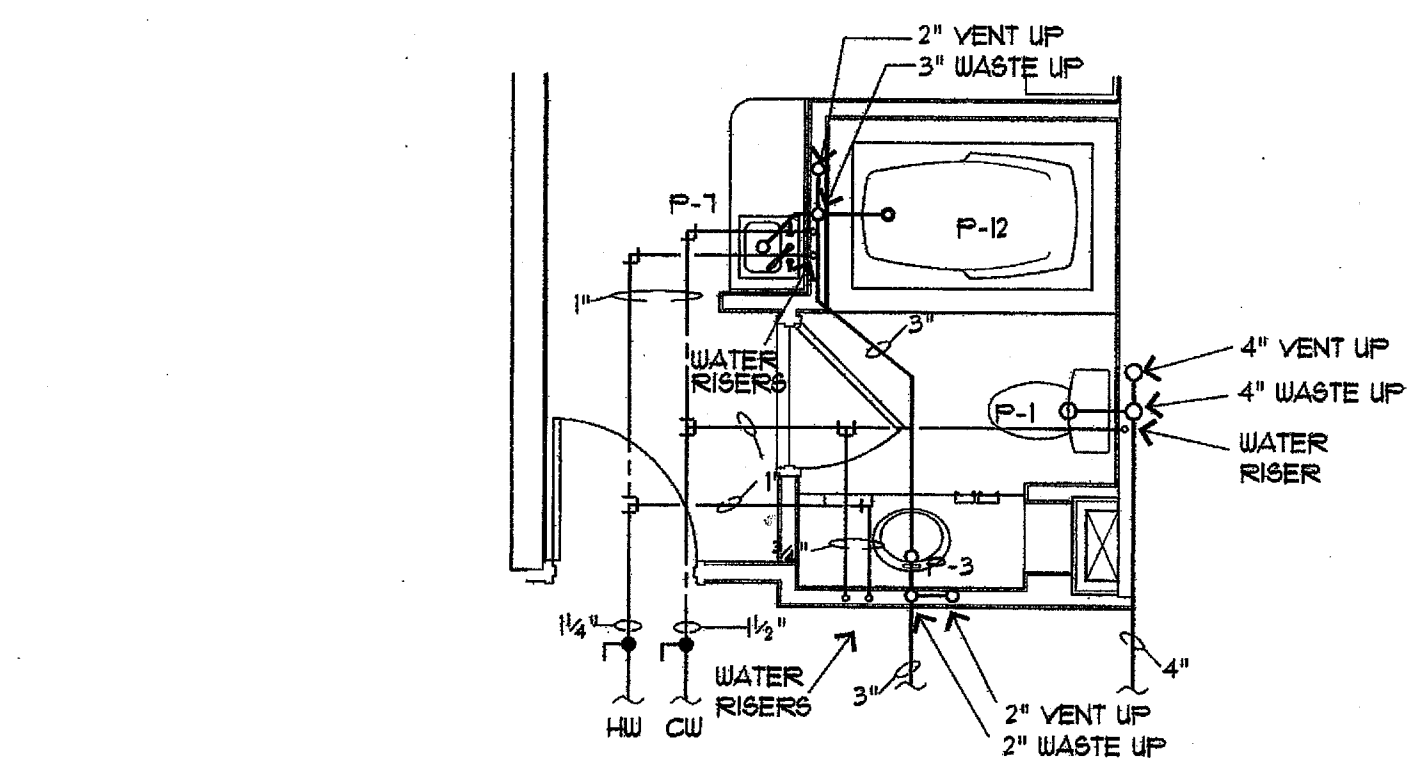

4 GR. FLR. WHIRLPOOL SUITE
1/4" = 1'-0" AX-X-X

PROJECT NAME:

Holiday Inn Express
HOTEL & SUITES
Underwood Road
Vicksburg, MS 38671

SHEET TITLE:

Typ. Guest Room Piping Plans

PROJECT NO. 01005 LATEST REVISION:

DRAWN BY: CHECKED BY: SHEET NUMBER:

DATE:

P5