


Richard Molenaar
ARCHITECT

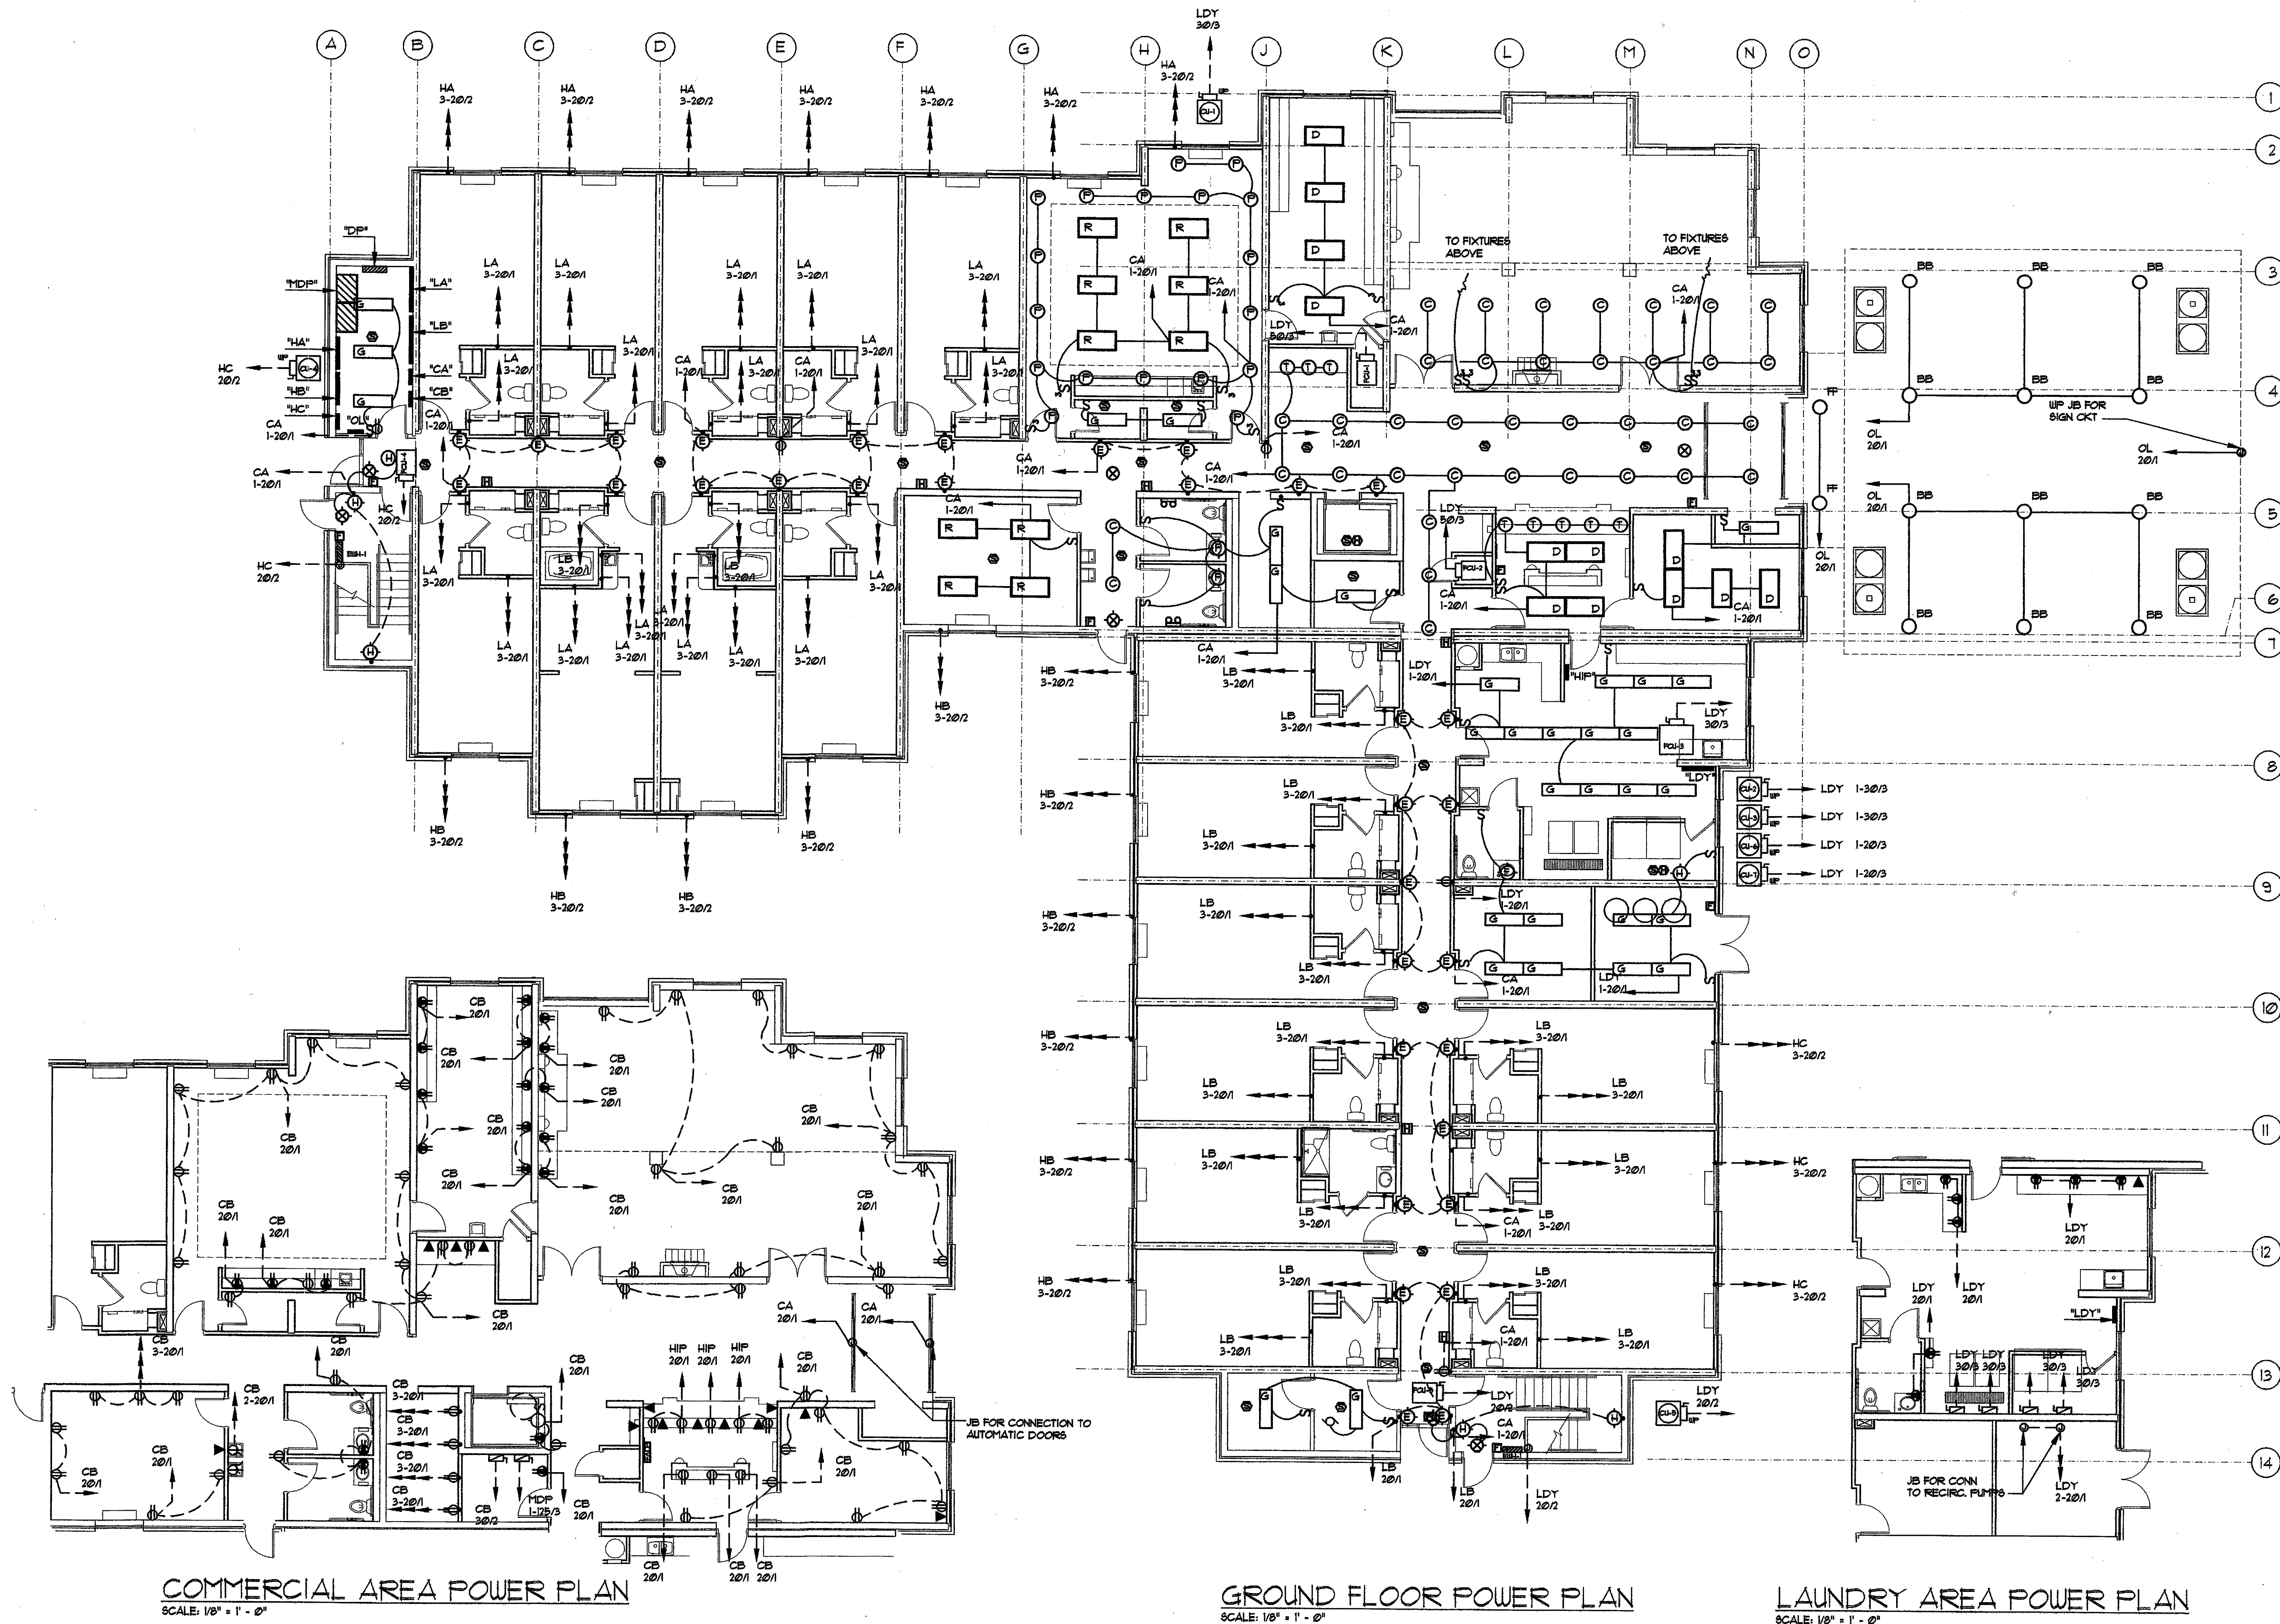

COMMERCIAL AREA POWER PLAN
SCALE: 1/8" = 1' - 0"

GROUND FLOOR POWER PLAN
SCALE: 1/8" = 1' - 0"

LAUNDRY AREA POWER PLAN
SCALE: 1/8" = 1' - 0"

PROJECT NAME:

Holiday Inn Express
HOTEL & SUITES
Underwood Road
Vicksburg, MS 38671

SHEET TITLE:

Ground Floor Electrical Plan

PROJECT NO.

01005

LATEST REVISION:



DRAWN BY: CHECKED BY:

SHEET NUMBER:

DATE:

E201