


DESIGN
CONSULTANTS

Richard Molenaar
ARCHITECT

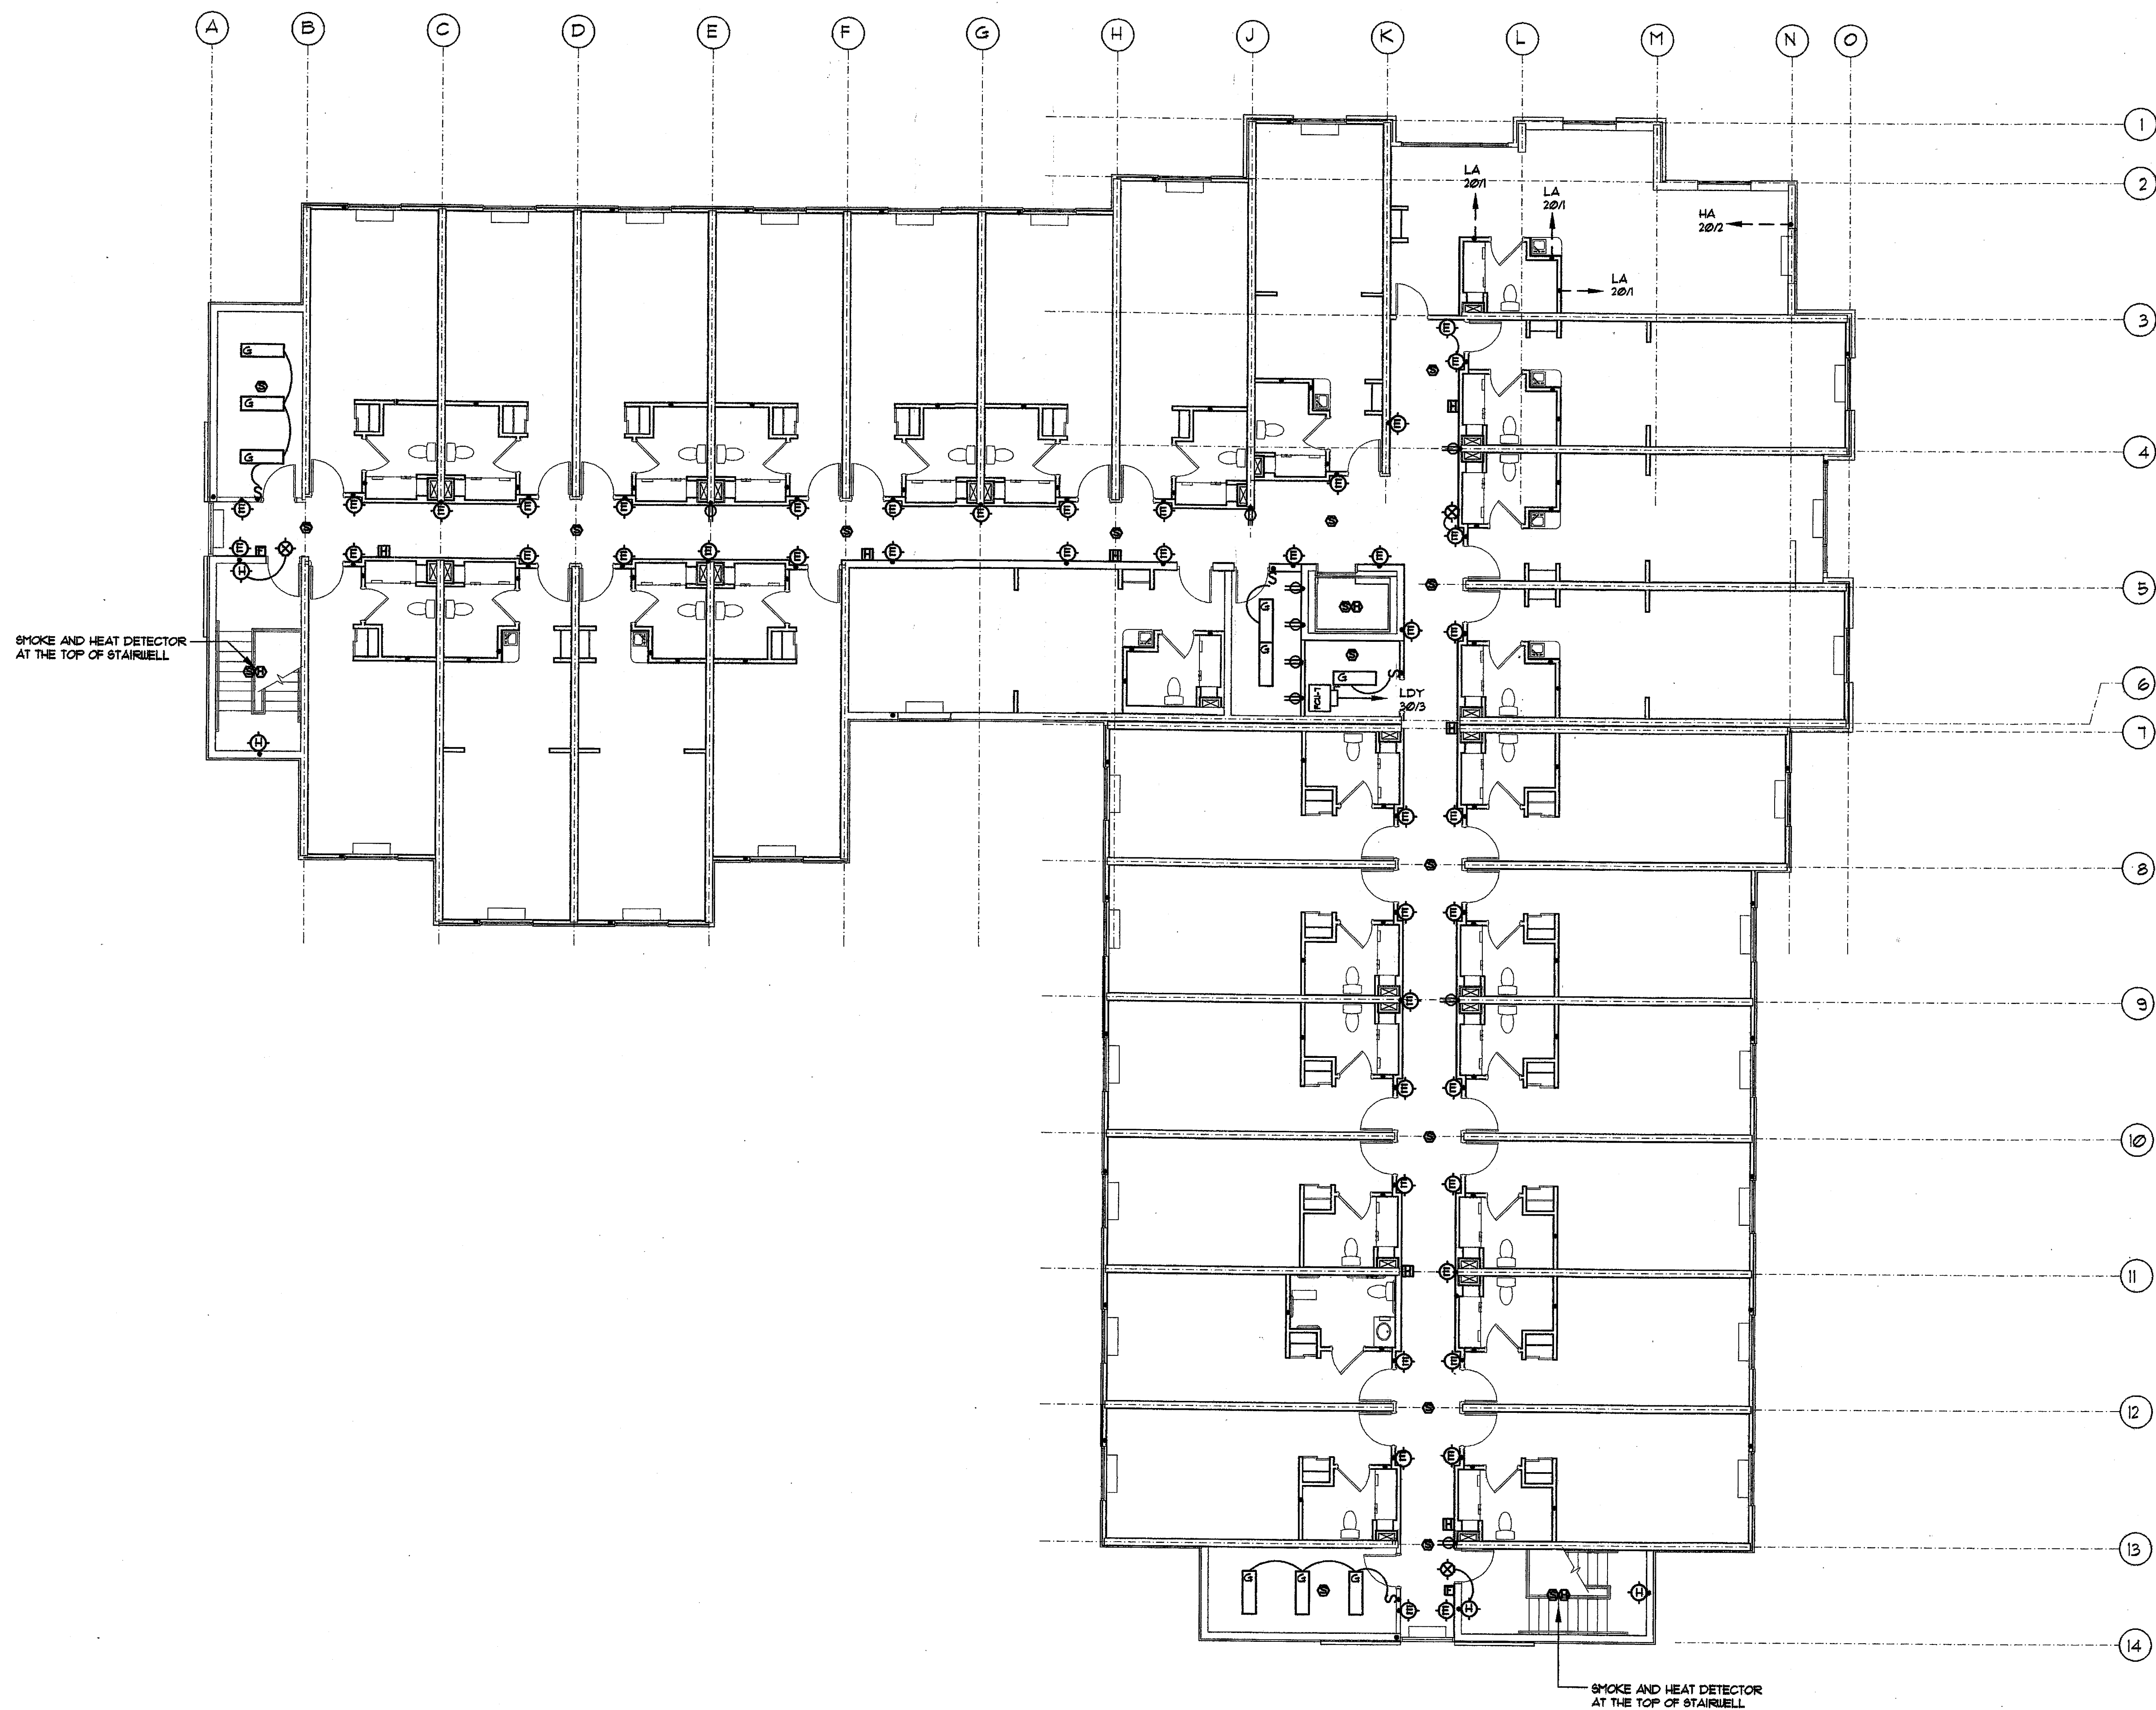

PROJECT NAME:

Holiday Inn Express
HOTEL & SUITES
Underwood Road
Vicksburg, MS 38671

SHEET TITLE:

Third Floor Electrical Plan

PROJECT NO.
01005

LATEST REVISION:



DRAWN BY: CHECKED BY: SHEET NUMBER:

DATE:

E203