

LIGHTING FIXTURE SCHEDULE


MARK	MFR	CATALOG NUMBER	WATTAGE	MTG.	REMARKS
A	LITHONIA	C232 120E8	2-F32, CU	SURF/WALL	4FT. FLUORESCENT STRIP
B	LITHONIA	LP6F 18DTT 120 603A	1-18W, DTT	RECES	FLUORESCENT DOWNLIGHT IN GUESTROOM ENTRY
C	LITHONIA	LP6F 18DTT 120 602	1-18W, DTT	RECES	FLUORESCENT DOWNLIGHT IN GUESTROOM BATH & GRF FLOOR COMM'L AREAS
D	LITHONIA	2GT432A2A2120E8	4-32W, T8	RECES	2X4 FLUORESCENT TROFFER
E	LITHONIA	11901	2-CFT13W	WALL	2X4 FLUORESCENT WALL SCENCE MTD UP 18"
F	PROGRESS	PT114-60	1-22W 4 32W CIRC	SURF/WALL	FLUORESCENT DRUM IN GUESTROOM BATH
G	LITHONIA	6B232 120E8	2-32W, T8	SURFACE	FLUORESCENT WRAP AROUND
H	LITHONIA	10822	1-22W 4 32W CIRC	SURF/WALL	FLUORESCENT DRUM
K	STONCO	V10K11GC	1-100W, AIS	WALL	INCANDESCENT VAPORITITE IN ELEVATOR PIT
L	LITHONIA	LP6F 26DTT 120 602	1-26W, DTT	RECES	FLUORESCENT DOWNLIGHT UPPER LEVEL OF BREAKFAST AREA
P	LITHONIA	LP6F18DTT 120 HFF 6C3A	1-18WDTT	RECES	FLUORESCENT CAN - CORRIDOR CEILING
R	PROGRESS	FB436-60	1-150W, A-21	COL. TOP	W/P8148.91 SURFACE MTD. ADAPTER
T	LITHONIA	LP6F18DTT 120 HFF 6B1W	1-18WDTT	RECES	RECES FLUORESCENT CAN
AA	LITHONIA	K9F2 400M R3 TB 8F12	1-400W, MH	POLE	SINGLE HEAD HID PARKING AREA LIGHT - POLE #88A 3066GDM18
BB	LITHONIA	LAH 118M 18W T13 120	1-18W, MH	RECES	HID DOWNLIGHT IN CANOPY
CC	LITHONIA	TFS 100M TB	1-100W, MH	GROUND	HID FLOOD - FLAG POLE
DD	LITHONIA	K9F2 118M R3 TB 8F12	1-118W, MH	POLE	POOL AREA LIGHT POLE WITH SINGE HEAD
FF	LITHONIA	COFZ11 226GTT 84A 120 GEB10	2-26W, DTT	SURFACE	SURFACE FLUORESCENT DOWNLIGHT

ELECTRICAL PANELBOARD SCHEDULE


PANEL	BKR SIZE	BKR QUANT	CIRCUIT DESCRIPTION	PANEL	BKR SIZE	BKR QUANT	CIRCUIT DESCRIPTION	PANEL	BKR SIZE	BKR QUANT	CIRCUIT DESCRIPTION	
"CA"	20/1	34	LIGHTING CIRCUIT	"LDY"	30/3	2	WASHER	"OL"	20/1	1	SIGN CKT	
120/208V	20/1	2	AUTOMATIC DOORS	120/208V	30/3	2	DRYER	120/208V	20/1	3	CANOPY LIGHTS	
3-PH, 4-W	20/1	3	CORRIDOR RECEPT. CKTS.	3-PH, 4-W	20/1	4	RECEPTACLE CKTS.	3-PH, 4-W	20/1	2	POOL AREA LIGHTS	
225A MLO	20/1	1	SPARE	400A MLO	20/1	2	LIGHTING CIRCUIT	100A MLO	20/1	1	FLAG POLE LIGHTS	
	20/1	1	SPARE	2-SECTION	30/3	1	FCU-1		20/1	GFI	POOL LIGHTS	
	20/1	1	SPARE		30/3	1	FCU-6		20/1	GFI	1	PARKING AREA LIGHTS
					20/2	1	FCU-5		20/1	1	SPARE	
"CB"	20/1	26	RECEPTACLE CIRCUITS		30/3	1	FCU-3		20/1	1	SPARE	
120/208V	20/1	12	VENDING MACHINE RECEPTABLES		50/3	1	FCU-2		20/1	1	SPARE	
3-PH, 4-W	30/2	1	ELEVATOR CAB FAN AND LIGHTS		50/3	1	FCU-1		20/1	1	SPARE	
225A MLO	20/1	1	SPARE		20/3	1	CU-1		20/1	1	SPARE	
	20/1	1	SPARE		20/3	1	CU-6		20/1	1	SPARE	
					20/2	1	CU-5					
					30/3	1	CU-3					
"HA"	20/2	30	THRU-WALL-UNIT CKT.		30/3	1	CU-2	"DP"	200A FU	1	PANEL "LA"	
120/208V	20/2	5	THRU-WALL-UNIT CKT.		30/3	1	CU-1	120/208V	200A FU	1	PANEL "LB"	
3-PH, 4-W	20/2	1	THRU-WALL-UNIT CKT.		20/2	1	ELH	3-PH, 4-W	100A FU	1	PANEL "OL"	
400A MLO	30/2	1	THRU-WALL-UNIT CKT.		30/3	2	RECIRCULATING PUMPS	200A MLO	200A FU	1	PANEL "CA"	
2 SECTION	30/2	3	THRU-WALL-UNIT CKT.		30/3	1	SPARE	200A FU	200A FU	1	PANEL "CB"	
					20/1	1	SPARE	60A FU	1	PANEL "HIP"		
"HB"	20/2	26	THRU-WALL-UNIT CKT.		20/1	1	SPARE	200A FU	1	SPACE		
120/208V	20/2	1	THRU-WALL-UNIT CKT.		20/1	1	SPARE					
3-PH, 4-W	20/2	5	SPARE		20/1	1	SPARE					
400A MLO	20/2	1	SPARE		20/1	1	SPARE					
2 SECTION	20/2	1	SPARE		20/1	1	SPARE					
					20/1	1	SPARE					
"HC"	20/2	9	THRU-WALL-UNIT CKT.	"LA"	20/1	120	GUESTROOM CKT.	"MDP"	125A FU	1	ELEVATOR MOTOR	
120/208V	20/2	1	FCU-4	120/208V	20/1	1	SPARE	120/208V	400A FU	1	PANEL "HA"	
3-PH, 4-W	20/2	1	CU-4	3-PH, 4-W	20/1	1	SPARE	3-PH, 4-W	400A FU	1	PANEL "HB"	
225A MLO	20/2	1	ELH	225A MLO	20/1	1	SPARE	2500A MLO	300A FU	1	PANEL "HC"	
	20/2	1	SPARE	3-SECTION	20/1	1	SPARE		400A FU	1	PANEL "LDY"	
	20/2	1	SPARE		20/1	1	SPARE		800A FU	1	PANEL "DP"	
					20/1	1	SPARE					
"HIP"	20/1	8	DEDICATED FRONT DESK AREA CKTS	"LB"	20/1	63	GUESTROOM CKT.					
120/208V	20/1	1	SPARE	120/208V	20/1	1	SPARE					
3-PH, 4-W	20/1	1	SPARE	3-PH, 4-W	20/1	1	SPARE					
100A MLO	20/1	1	SPARE	225A MLO	20/1	1	SPARE					
	20/1	1	SPARE	2-SECTION	20/1	1	SPARE					
					20/1	17	SPARE					

ELECTRICAL SYMBOLS LEGEND

SYMBOL	DESCRIPTION
S	3P.S.T. SWITCH -- MTD. UP 48" UNLESS NOTED OTHERWISE
SS	THREE-WAY SWITCH
SSS	DIMMER SWITCH
○	DUPLEX RECEPTACLE MTD UP 10" - 18" IN HANDICAPPED ROOMS
○	DUPLEX RECEPTACLE -- VERIFY MTG HEIGHT
○	GFI RECEPTACLE
○	GFI RECEPTACLE - VERIFY MTG HEIGHT
○	ISOLATED GRD. DUPLEX RECEPTACLE - ORANGE IN COLOR
○	SPECIAL PURPOSE RECEPTACLE
○	FLOOR OUTLET W/DUPLEX RECEPTACLE
○	FLOOR OUTLET -- SPECIAL PURPOSE
○	JUNCTION BOX
UP	WEATHERPROOF
EH	CLOCK OUTLET
⊗	EXIT LIGHT -- CONNECT TO NEAREST UNSWITCHED LIGHTING CKT. -- MTD ON CLG OR WALL ABOVE DOOR -- LITHONIA "LQ1 S W 3 R/G 120/271 EL N LED EXIT LIGHT
○	WALL MOUNTED FIXTURE
—	FLUORESCENT STRIP FIXTURE
—	FLUORESCENT FIXTURE
BB	EMER BATTERY BACK-UP FIXT. - CONNECT TO NEAREST UNSWITCHED LIGHT CKT -- MT ON WALL UP 84" -- LITHONIA "6ELM2 TN N "QUANTUM" SERIES
○	INCANDESCENT FIXTURE -- SURFACE OR RECESSED, SEE FIXTURE SCHEDULE
—	HOME-RUN TO PANEL
—	WIRING CONCEALED IN WALL OR FLOOR
—	WIRING CONCEALED IN WALL OR CEILING
—	WIRE IN CONDUIT - HASH MARKS DENOTE NUMBER OF WIRES - V DENOTES GRD WIRE - NO HASH MARKS DENOTE 2# 1/2 1/2 GRD, UNLESS NOTED OTHERWISE
—	LOW VOLTAGE WIRING
—	EMERGENCY LIGHTING CIRCUIT -- PROVIDE LOCKOUT ON CIRCUIT BREAKER
—	NON-FUSED DISCONNECT
—	FUSED DISCONNECT
—	DISTRIBUTION PANEL
—	LIGHTING AND APPLIANCE BRANCH CIRCUIT PANEL
○	MOTOR
—	BUZZER WITH LOW VOLTAGE TRANSFORMER
—	PUSHBUTTON
—	INTERCOM OUTLET -- 3/4"C. STUBBE-UP ABOVE CEILING
—	TELEVISION SYSTEM OUTLET -- MTD. UP 12" WITH 3/4" C TO TV EQUIP.
—	TELEPHONE SYSTEM OUTLET -- MTD UP 12" WITH 3/4" C TO TEL EQUIP.
—	TELEPHONE SYSTEM OUTLET IN FLOOR BOX WITH 3/4"C TO TEL EQUIP.
—	EDWARDS NO. 1004 HOTEL HC GUESTROOM ANNUNCIATOR
—	DATA SYSTEM OUTLET -- MTD UP 12" WITH 3/4" CONDUIT TO COMPUTER BACKBOARD
—	DATA SYSTEM OUTLET IN FLOOR BOX WITH 3/4" C. TO COMPUTER BACK BOARD
—	FIRE ALARM SYSTEM BREAKGLASS STATION -- MTD UP 48" AFF
—	FIRE ALARM SYSTEM AUDIO/VISUAL DEVICE -- MTD UP 84" AFF.
—	FIRE ALARM SYSTEM CONTROL PANEL
—	FIRE ALARM SYSTEM ANNUNCIATOR
—	FIRE ALARM SYSTEM HEAT DETECTOR
—	FIRE ALARM SYSTEM SMOKE DETECTOR
—	FIRE ALARM SYSTEM DUCT SMOKE DETECTOR
—	FIRE ALARM SYSTEM MAGNETIC DOOR HOLDER
—	FIRE ALARM SYSTEM STROBE LIGHT -- MTD UP 80" AFF.
—	FIRE ALARM SYSTEM SYSTEM MINI-HORN/STROBE - WALL MTD 12" DOWN FROM CLG
—	F. A. SYSTEM SMOKE DETECTOR WITH SOUNDER BASE - CLG OR WALL MTD. 12" DOWN FROM CLG. -- DETECTOR SHALL BE ANNUNCIATED AT FRONT DESK UPON ACTIVATION

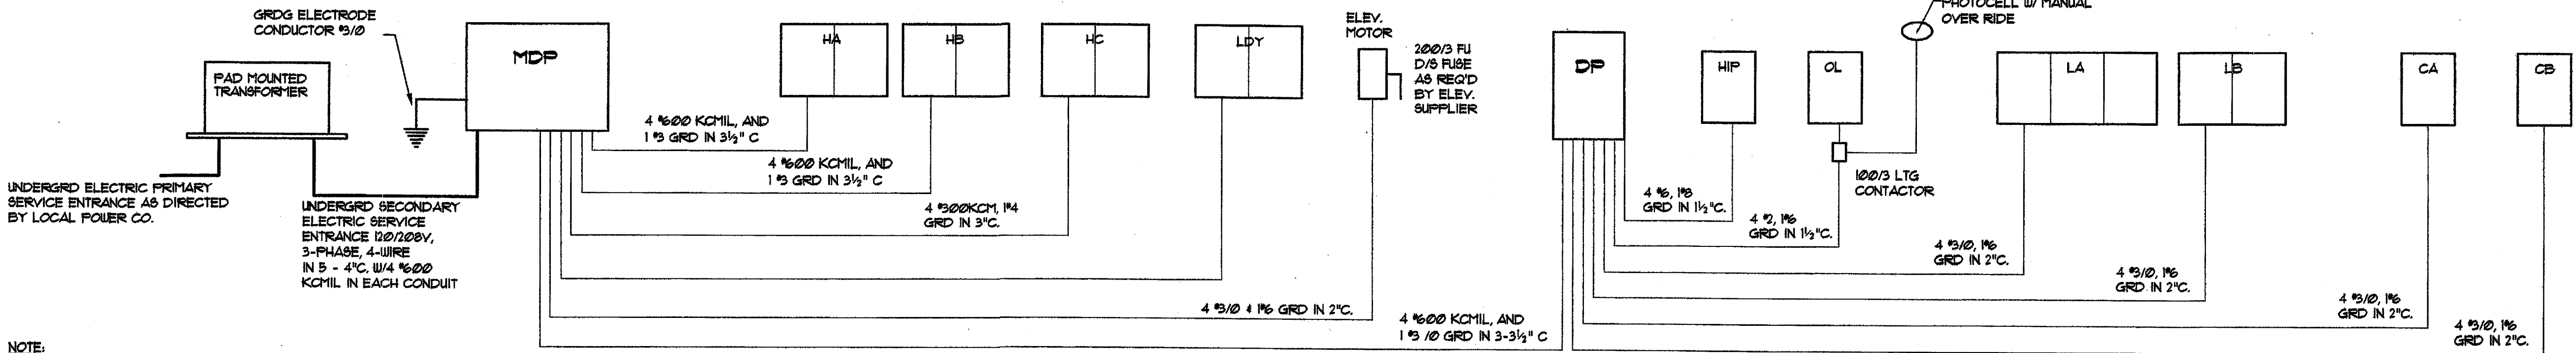

ELECTRICAL PANELBOARD ONE-LINE DIAGRAM
SCHEMATIC --- NO SCALE

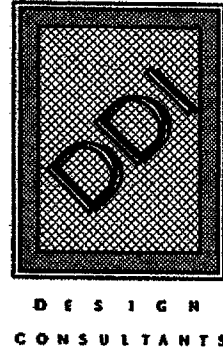

Richard Molenaar
ARCHITECT

PROJECT NAME:

Holiday Inn Express
HOTEL & SUITES
Underwood Road
Vicksburg, MS 38671

SHEET TITLE:

PANEL SCHEDULES &
ONE-LINE DIAGRAM

PROJECT NO.

01005

LATEST REVISION:

DRAWN BY:

CHECKED BY:

SHEET NUMBER:

DATE:

E401