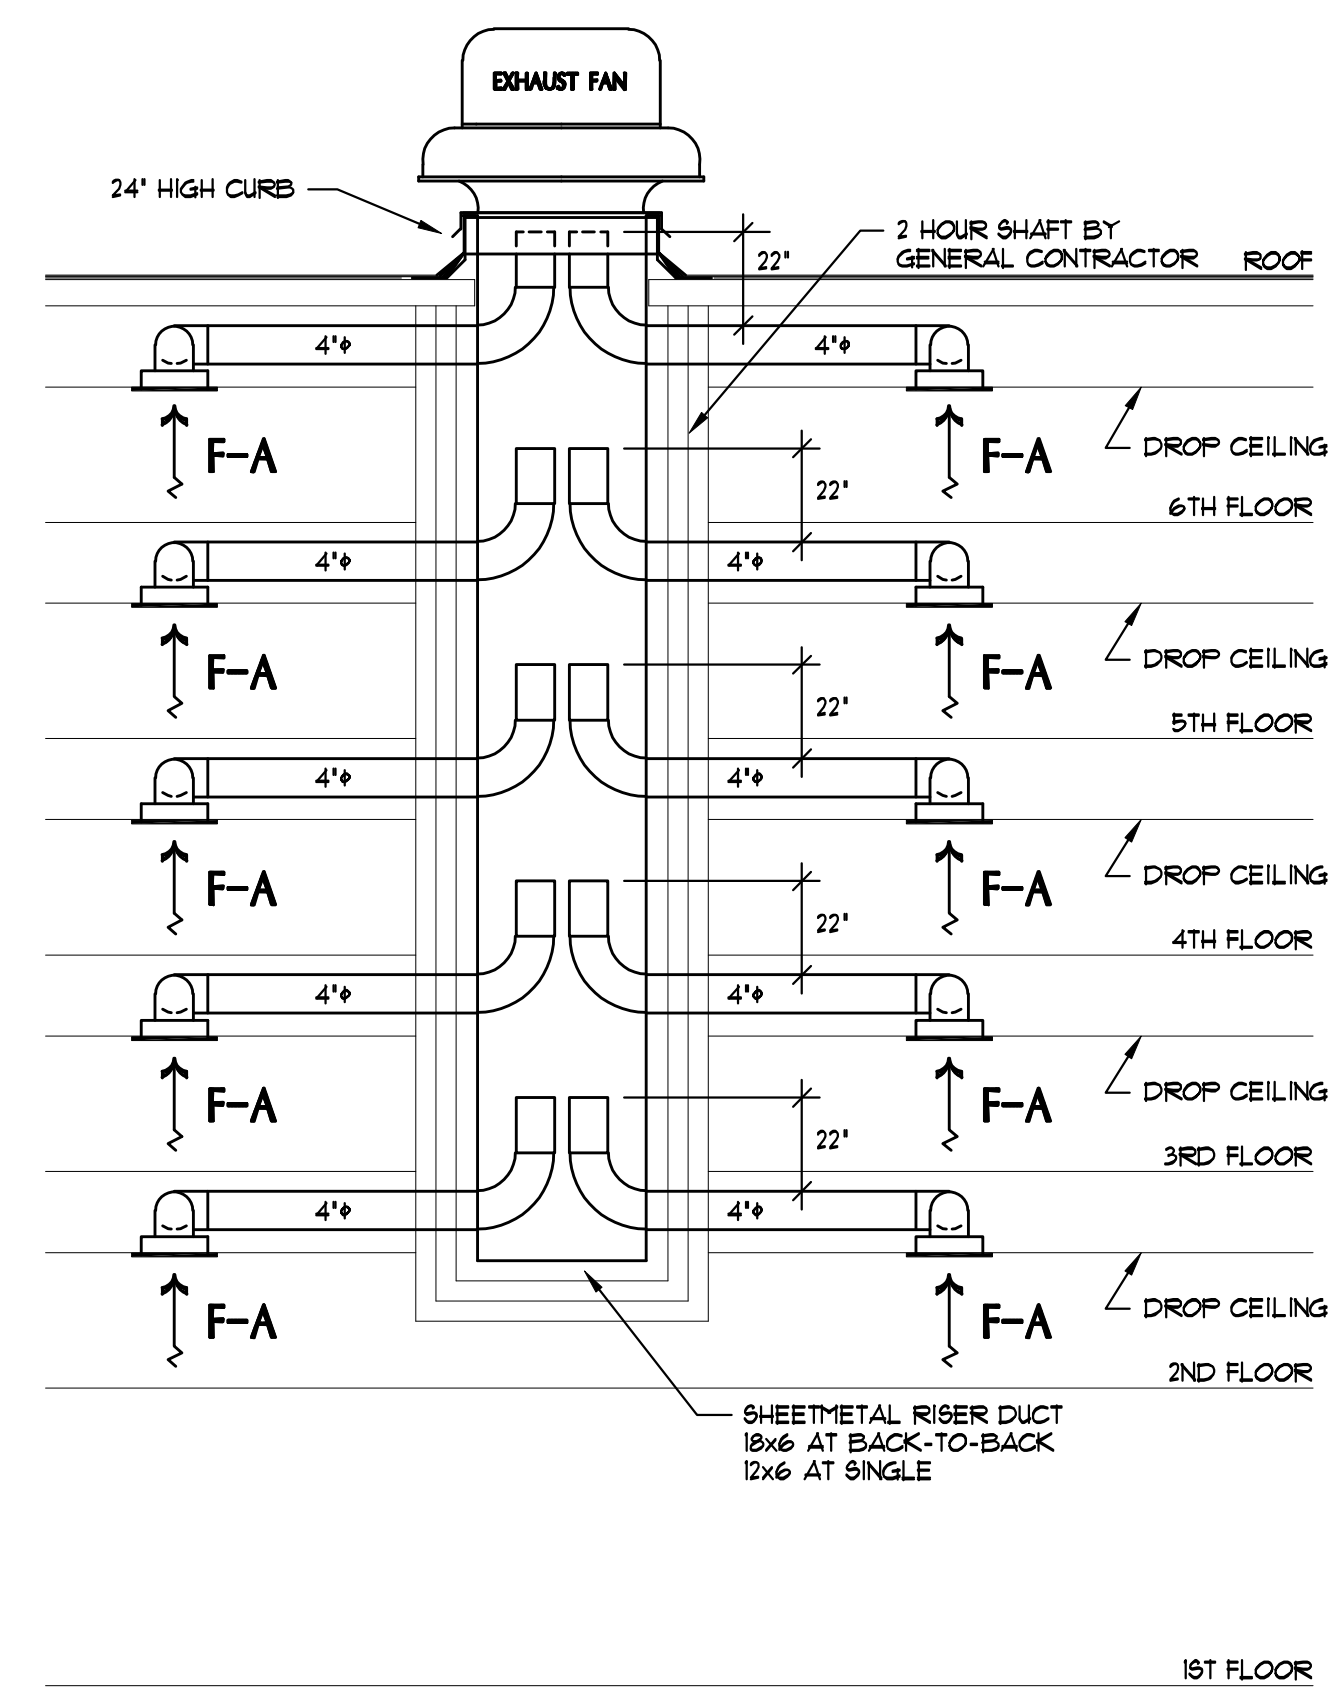
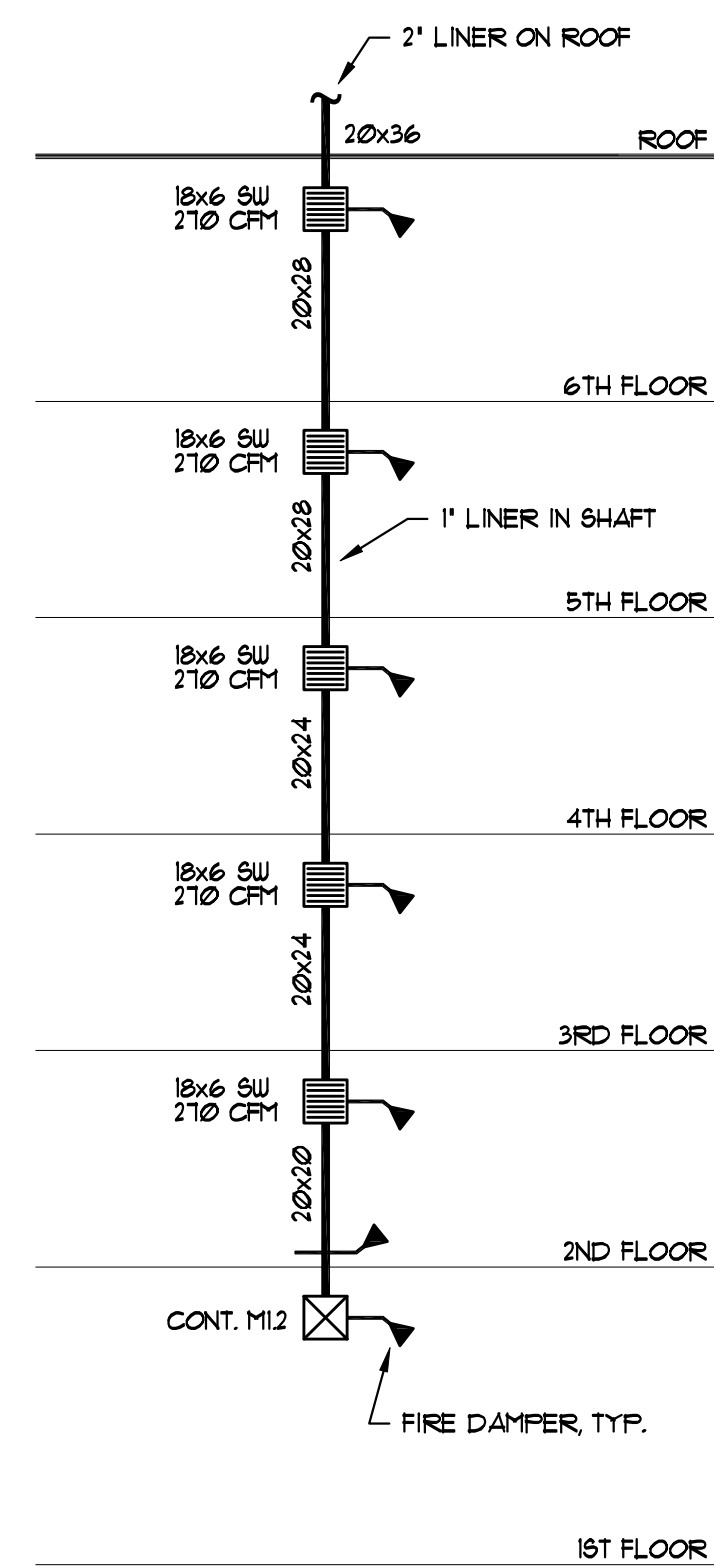
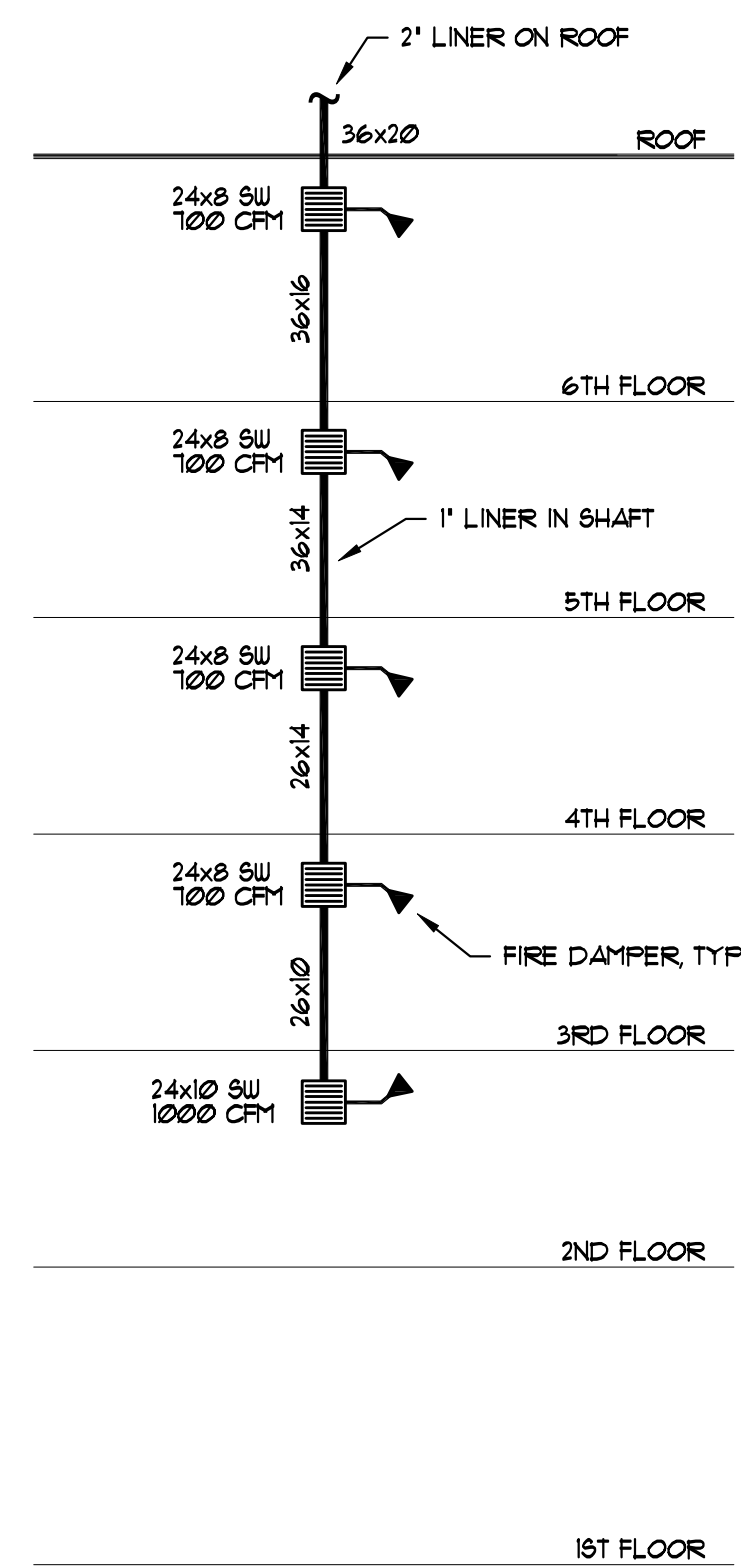
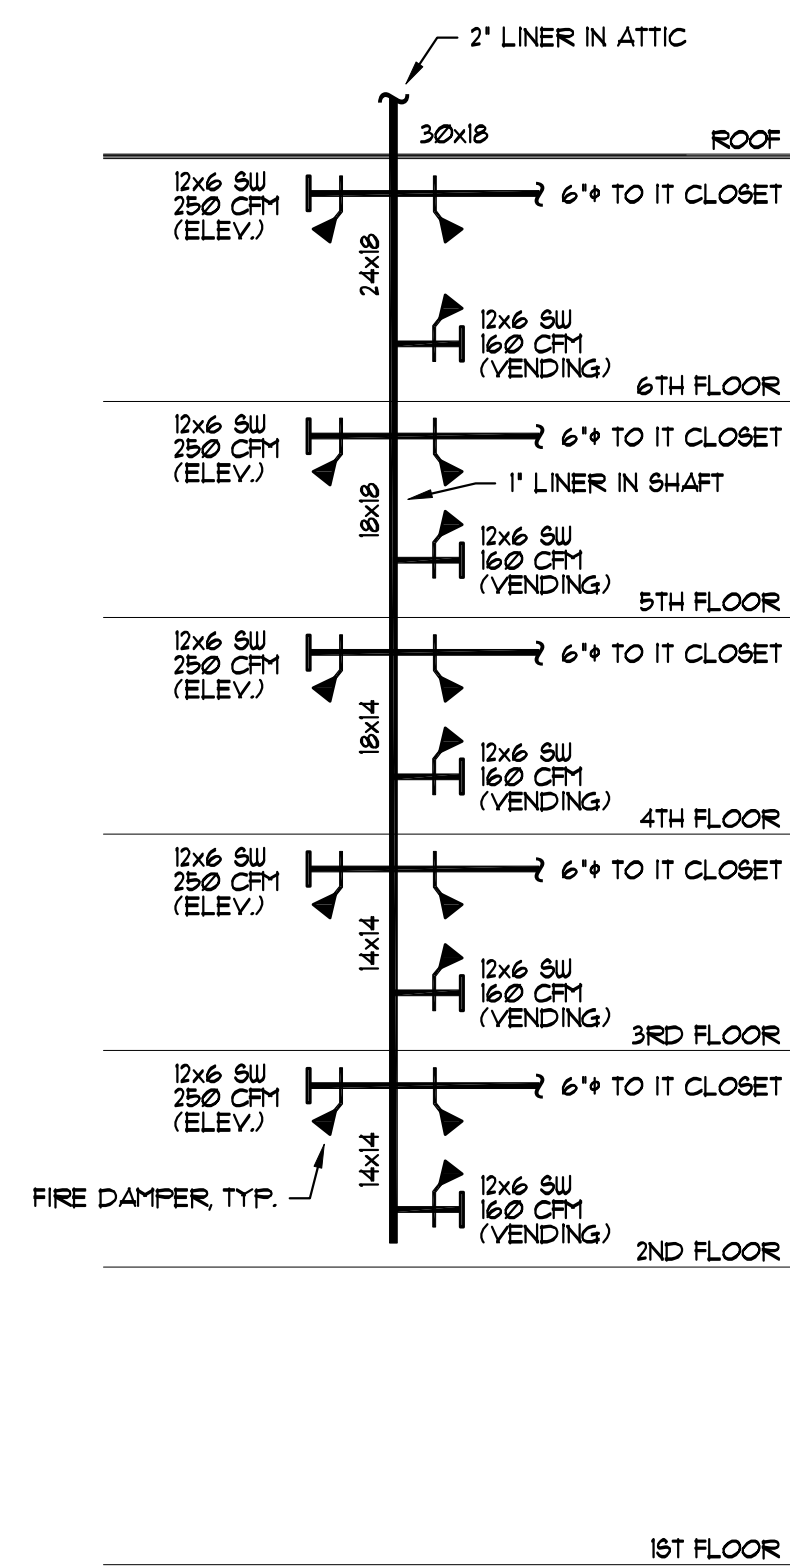
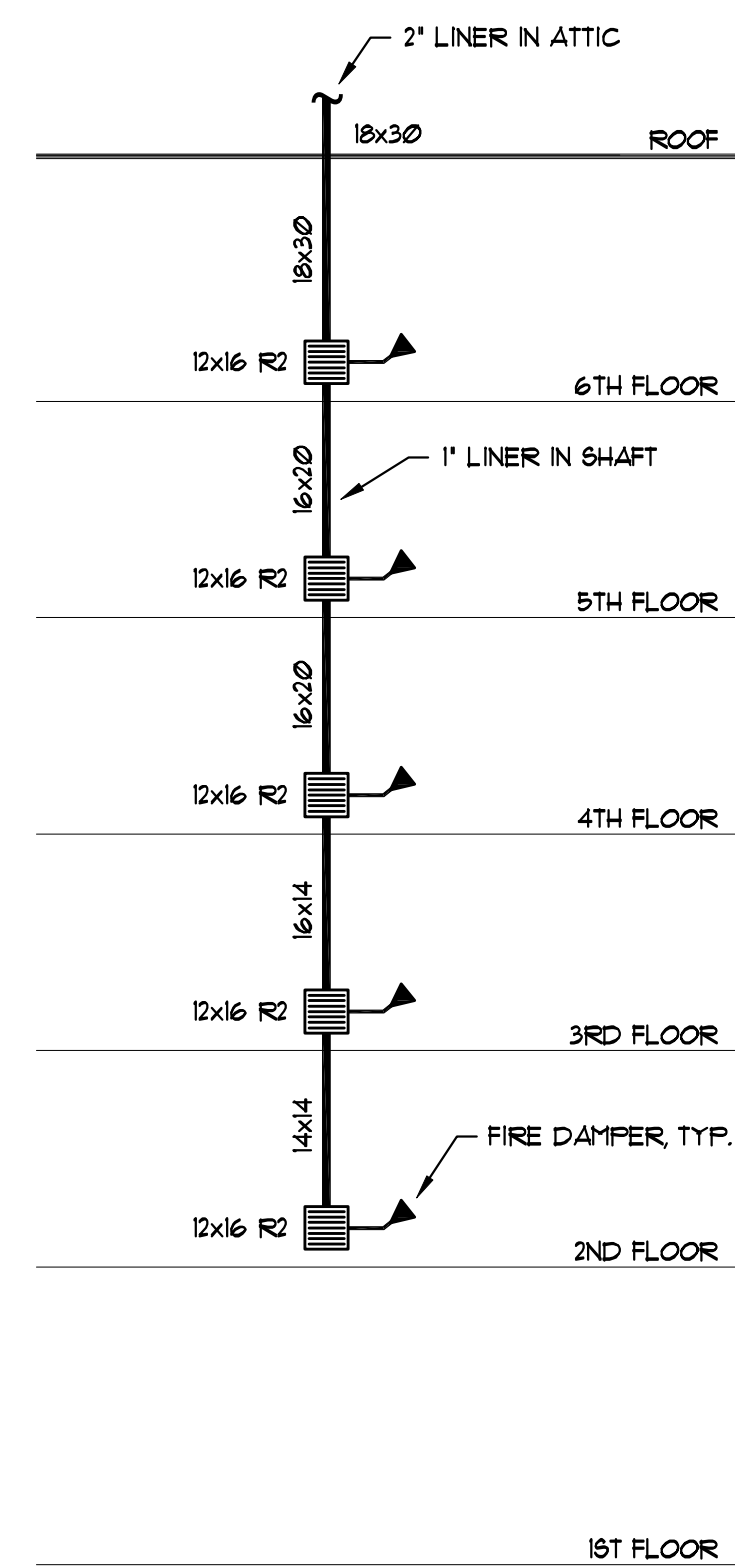


**803 S. MOUNT MORIAH
SUITE 100B
MEMPHIS, TN 38117
(901) 683-7175 p.
(901) 683-2385 f.
llw@llwarchitects.com**

[illegible]

NO. REVISIONS DATE
COPYRIGHT BY LLW ARCHITECTS, INC
WARNING: UNAUTHORIZED COPYING VIOLATE
U.S. COPYRIGHT LAWS AND WILL SUBJECT TH
VIOLATOR TO LEGAL PROSECUTION.

CONSULTANTS
STRUCTURAL:

MECHANICAL:
 FRABTREE ENGINEERING
 26 S. MT. MORIAH
 MEMPHIS, TN 38117
 (901) 767-9898

LUMBING:
FRABTREE ENGINEERING
26 S. MT. MORIAH
MEMPHIS, TN 38117
(901) 277-1853

ELECTRICAL:
CHS ENGINEERING
26 S. MT. MORIAH
MEMPHIS, TN 38117
(901) 767-2557

SEAL 

*** Holiday Inn**
MILLENNIUM

BOSSIER CITY,
LOUISIANA

HEET NAME
TYPICAL (3rd thru 6th
FLOOR PLAN - HVAC

DATE 10/26/07

RAWN BY _____

HECKED BY _____

FILE NAME


SCALE

PROJECT NO. _____

1507

RAWING

M3.0

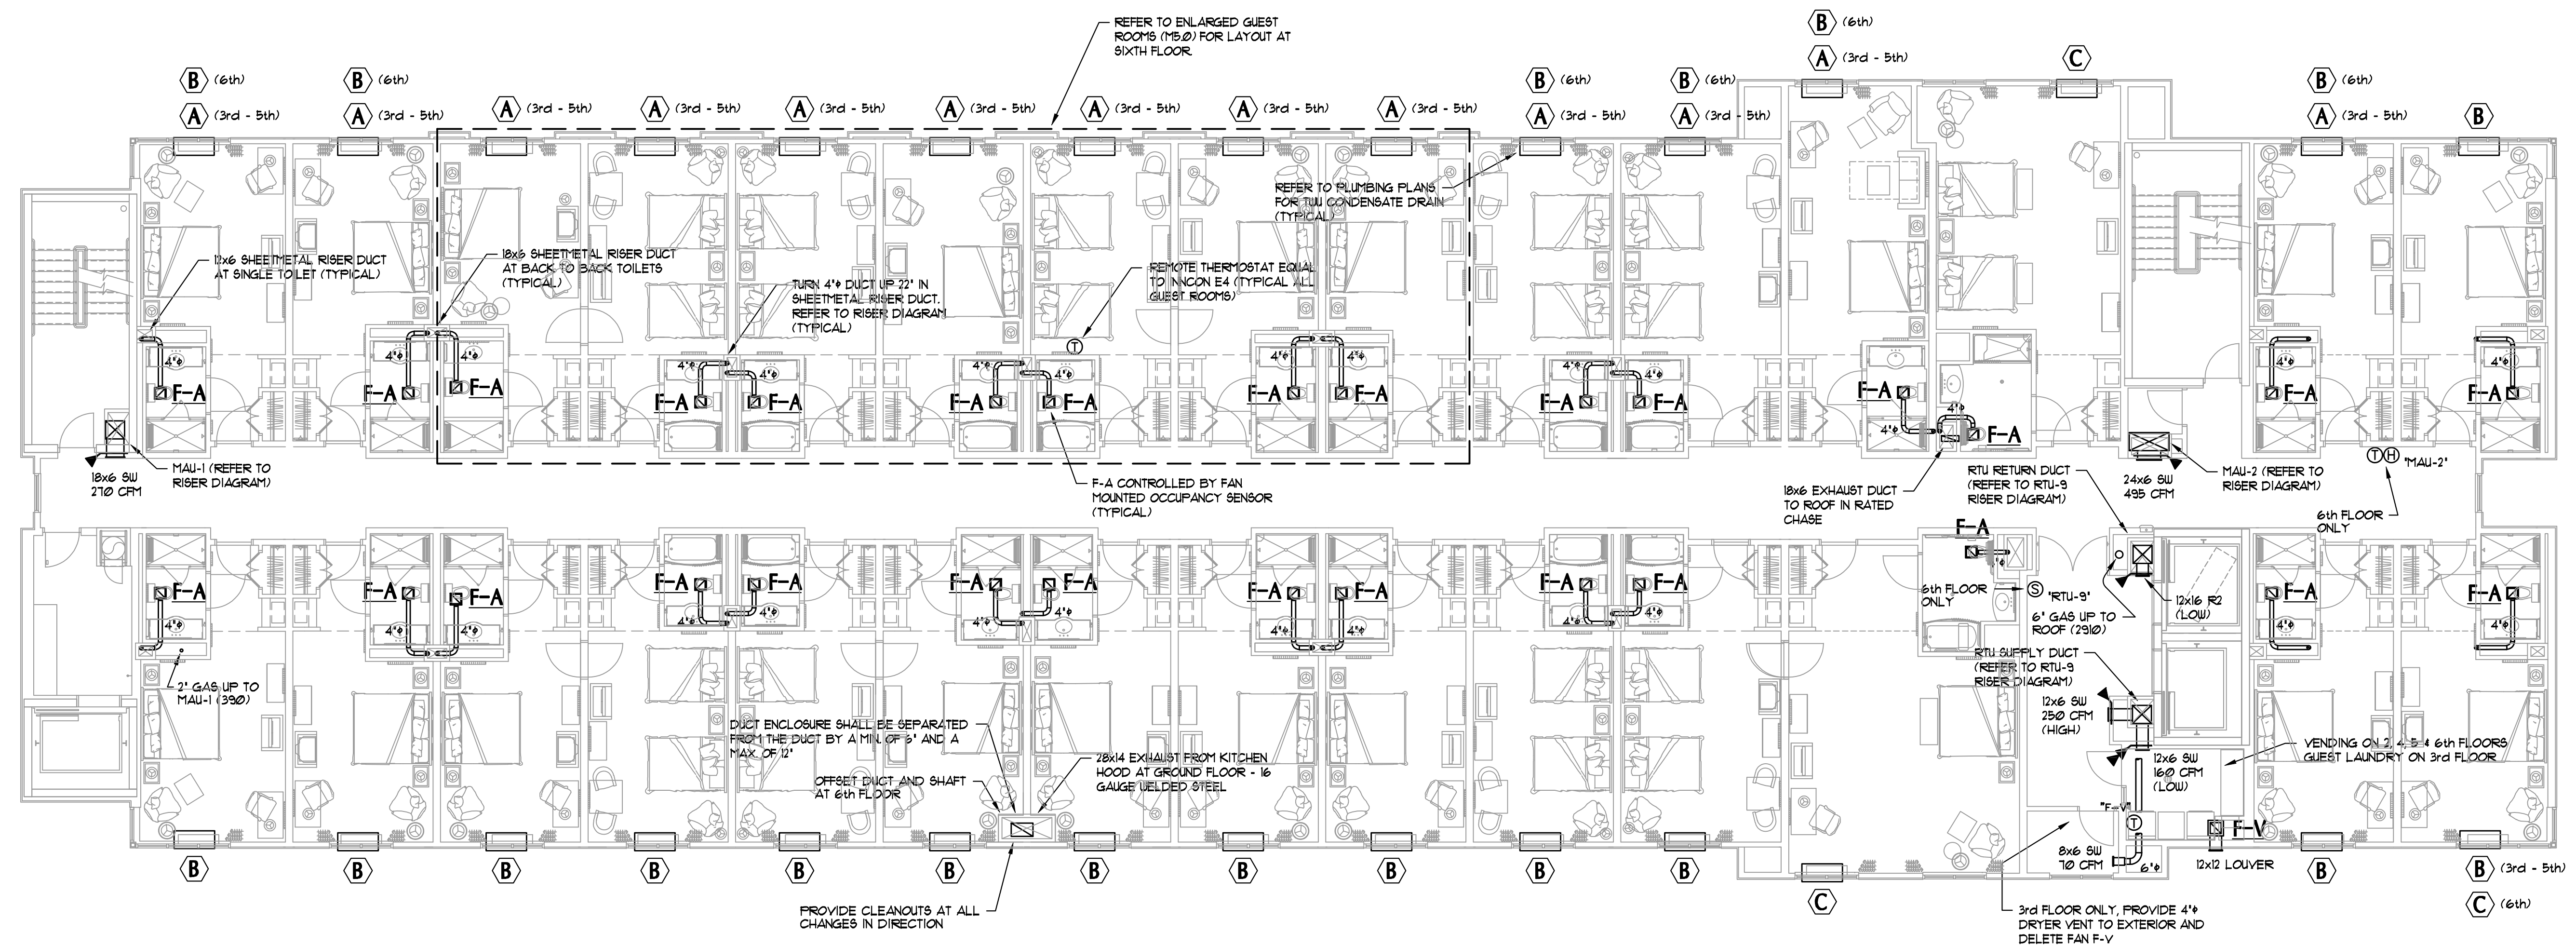

TYPICAL (3rd thru 6th) FLOOR PLAN - HVAC
SCALE: 1/8" = 1'-0"