



803 S. MOUNT MORIAH  
SUITE 100B  
MEMPHIS, TN 38117  
(901) 683-7175 p.  
(901) 683-2385 f.  
llw@llwarchitects.com

NO.	ISSUED	DATE
1	ISSUED	10/26/01

NO.	REVISIONS	DATE


COPYRIGHT BY LLW ARCHITECTS, INC.  
WARNING: UNAUTHORIZED COPYING VIOLATES  
U.S. COPYRIGHT LAWS AND WILL SUBJECT THE  
VIOLATOR TO LEGAL PROSECUTION.

CONSULTANTS  
STRUCTURAL:

MECHANICAL:  
CRABTREE ENGINEERING  
726 S. MT. MORIAH  
MEMPHIS, TN 38117  
(901) 767-9898

PLUMBING:  
CRABTREE ENGINEERING  
726 S. MT. MORIAH  
MEMPHIS, TN 38117  
(901) 277-1853

ELECTRICAL:  
CHS ENGINEERING  
726 S. MT. MORIAH  
MEMPHIS, TN 38117  
(901) 767-2557

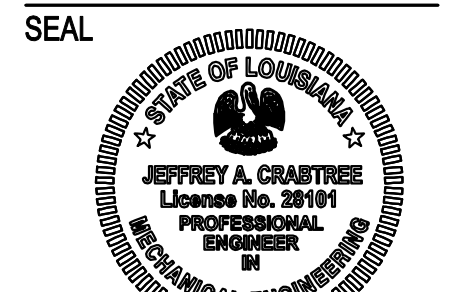

# **Holiday Inn**  
MILLENNIUM

BOSSIER CITY,  
LOUISIANA

SHEET NAME  
**LARGE SCALE GUEST  
ROOM PLANS - HVAC**

DATE  
10/26/01

DRAWN BY


CHECKED BY

FILE NAME


SCALE

PROJECT NO.


1501  
DRAWING

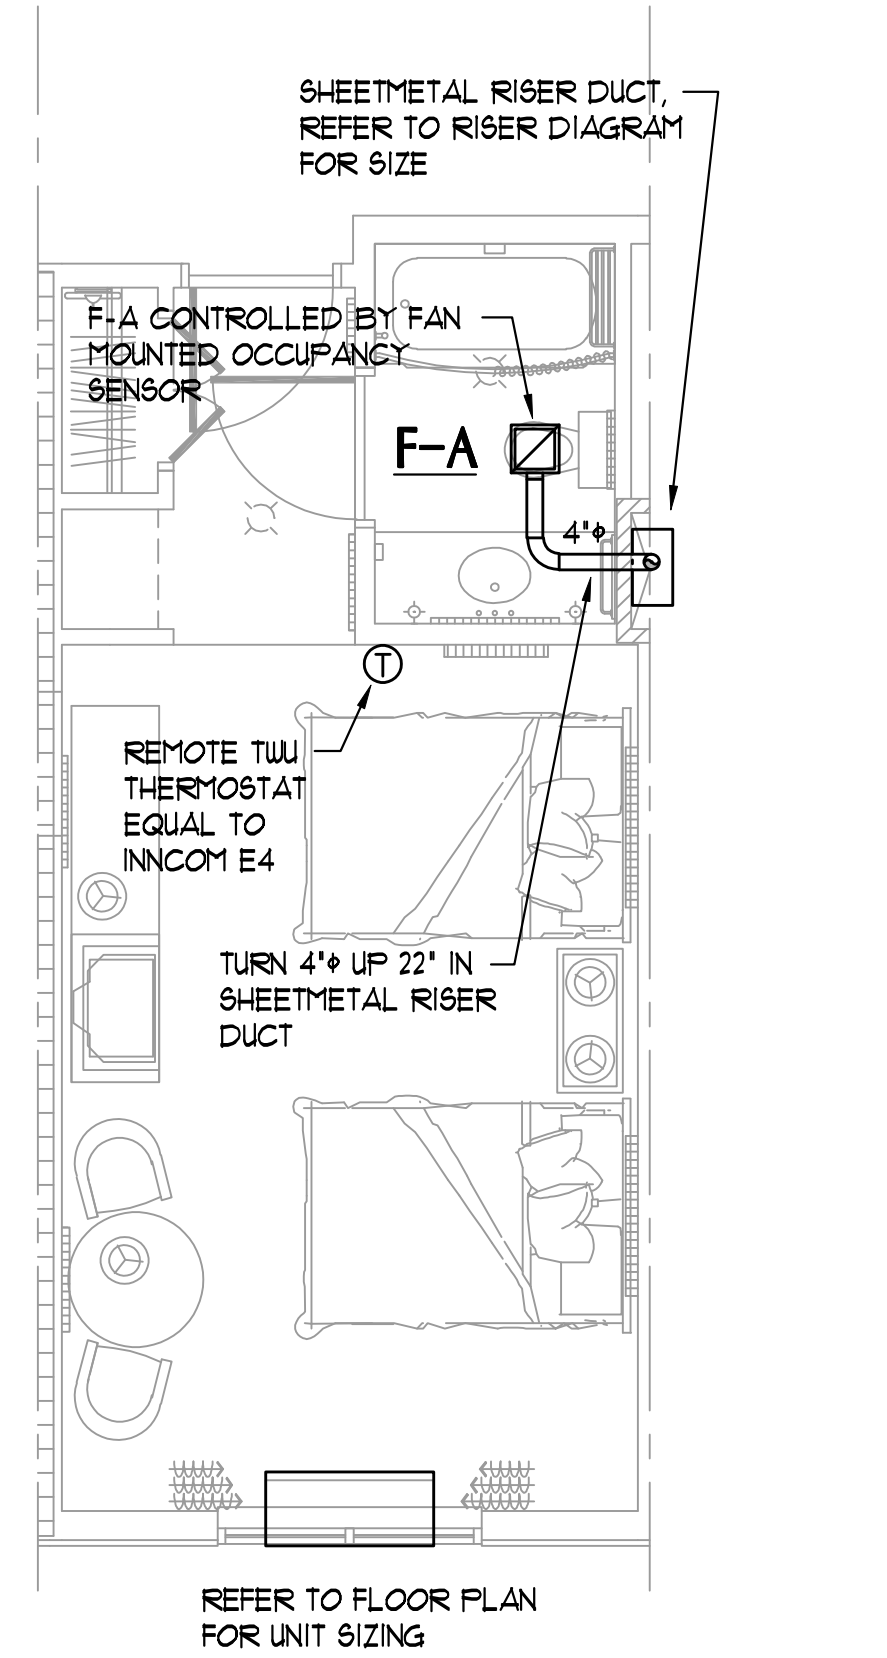


DOUBLE QUEEN

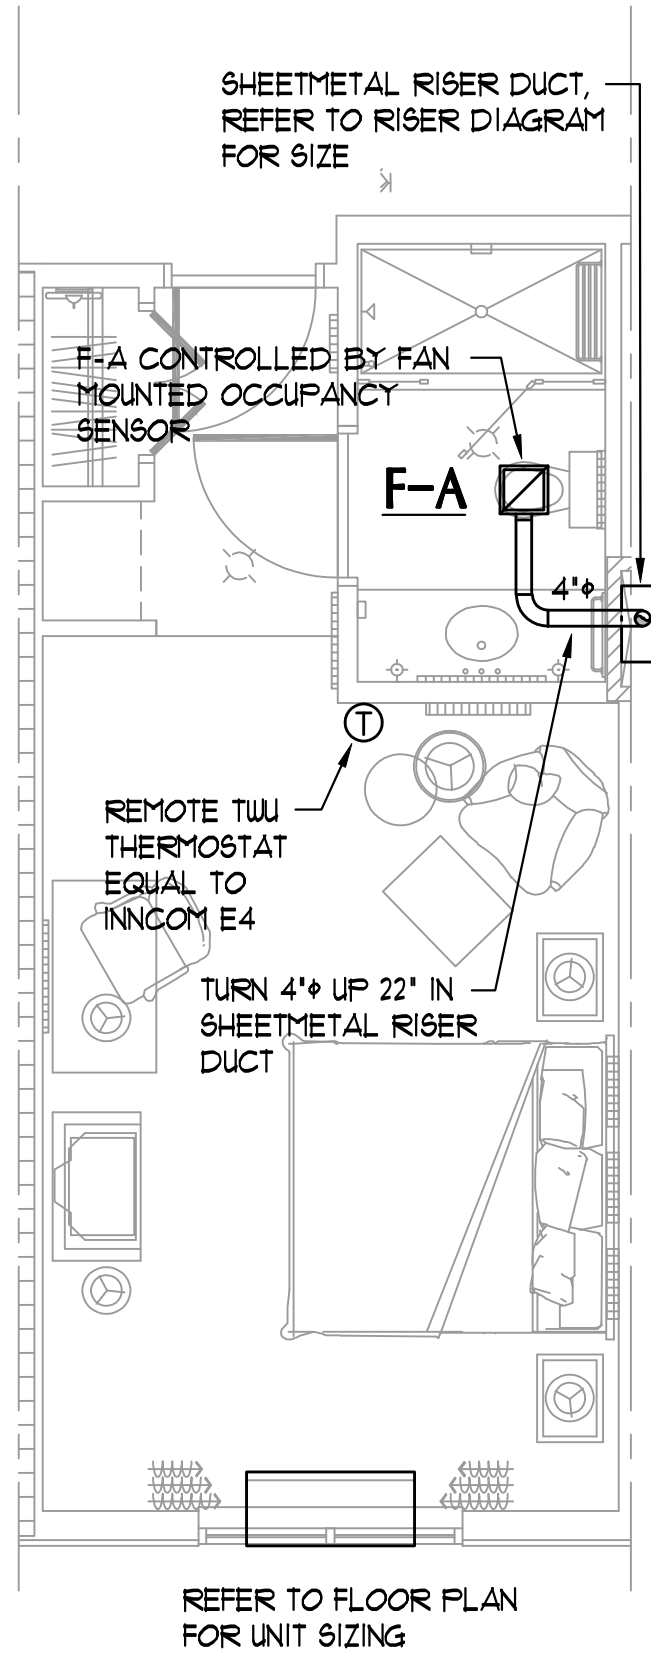


KING W/ SHOWER  
KING W/ TUB SIM  
-SEE FLOOR PLANS

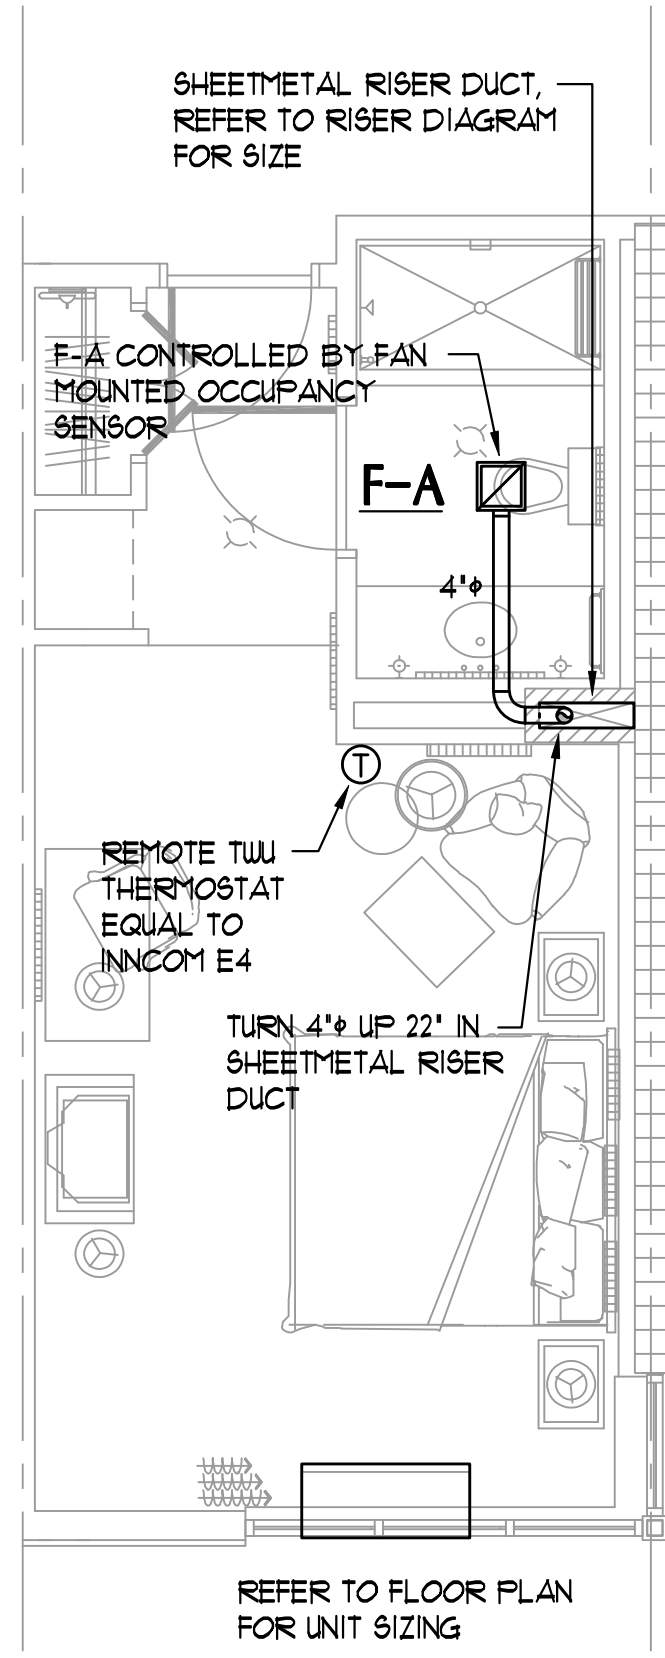


KING CORNER

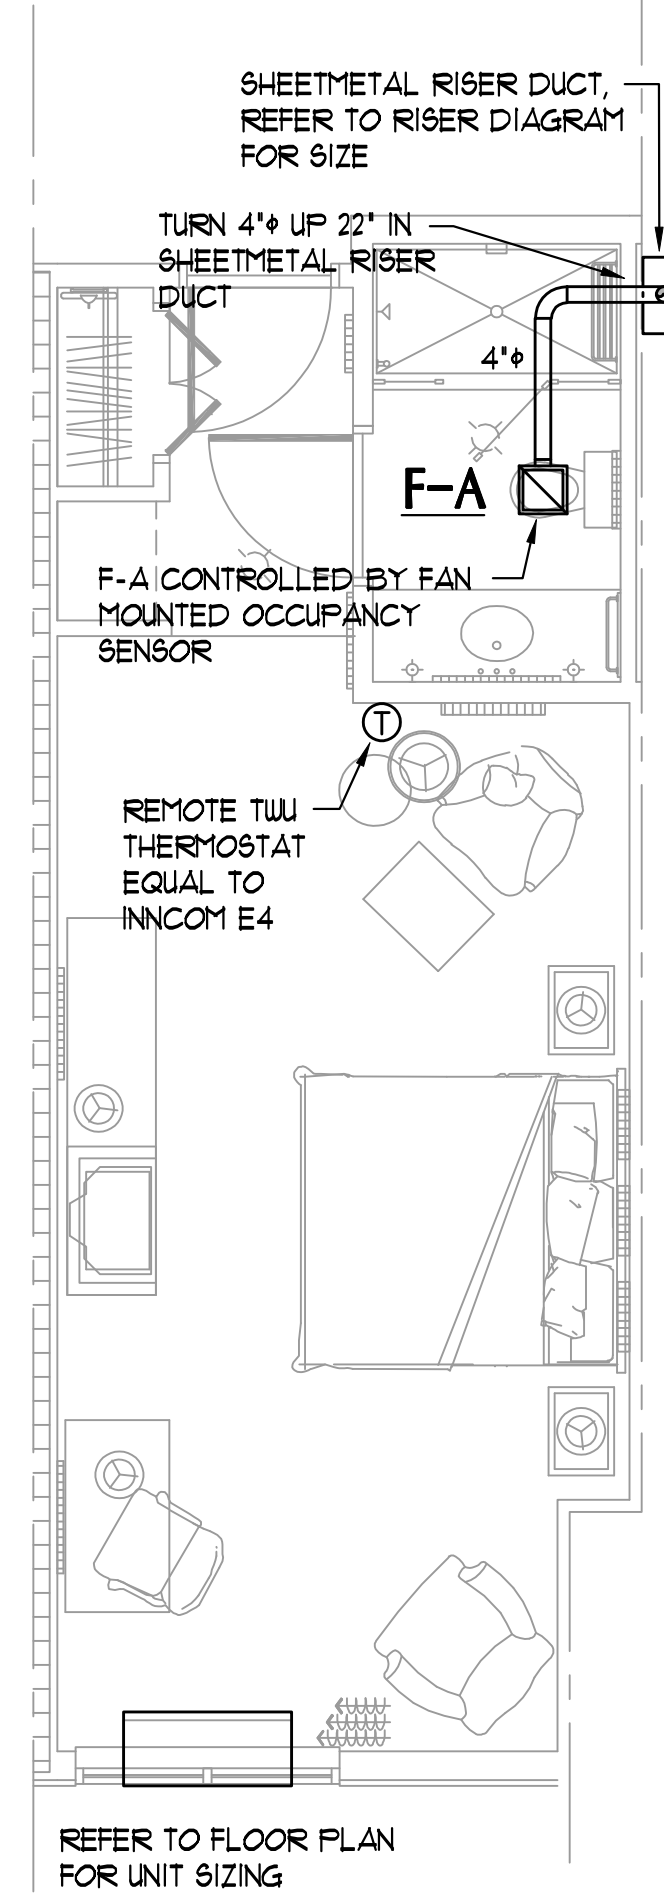


REFER TO FLOOR PLAN  
FOR UNIT SIZING

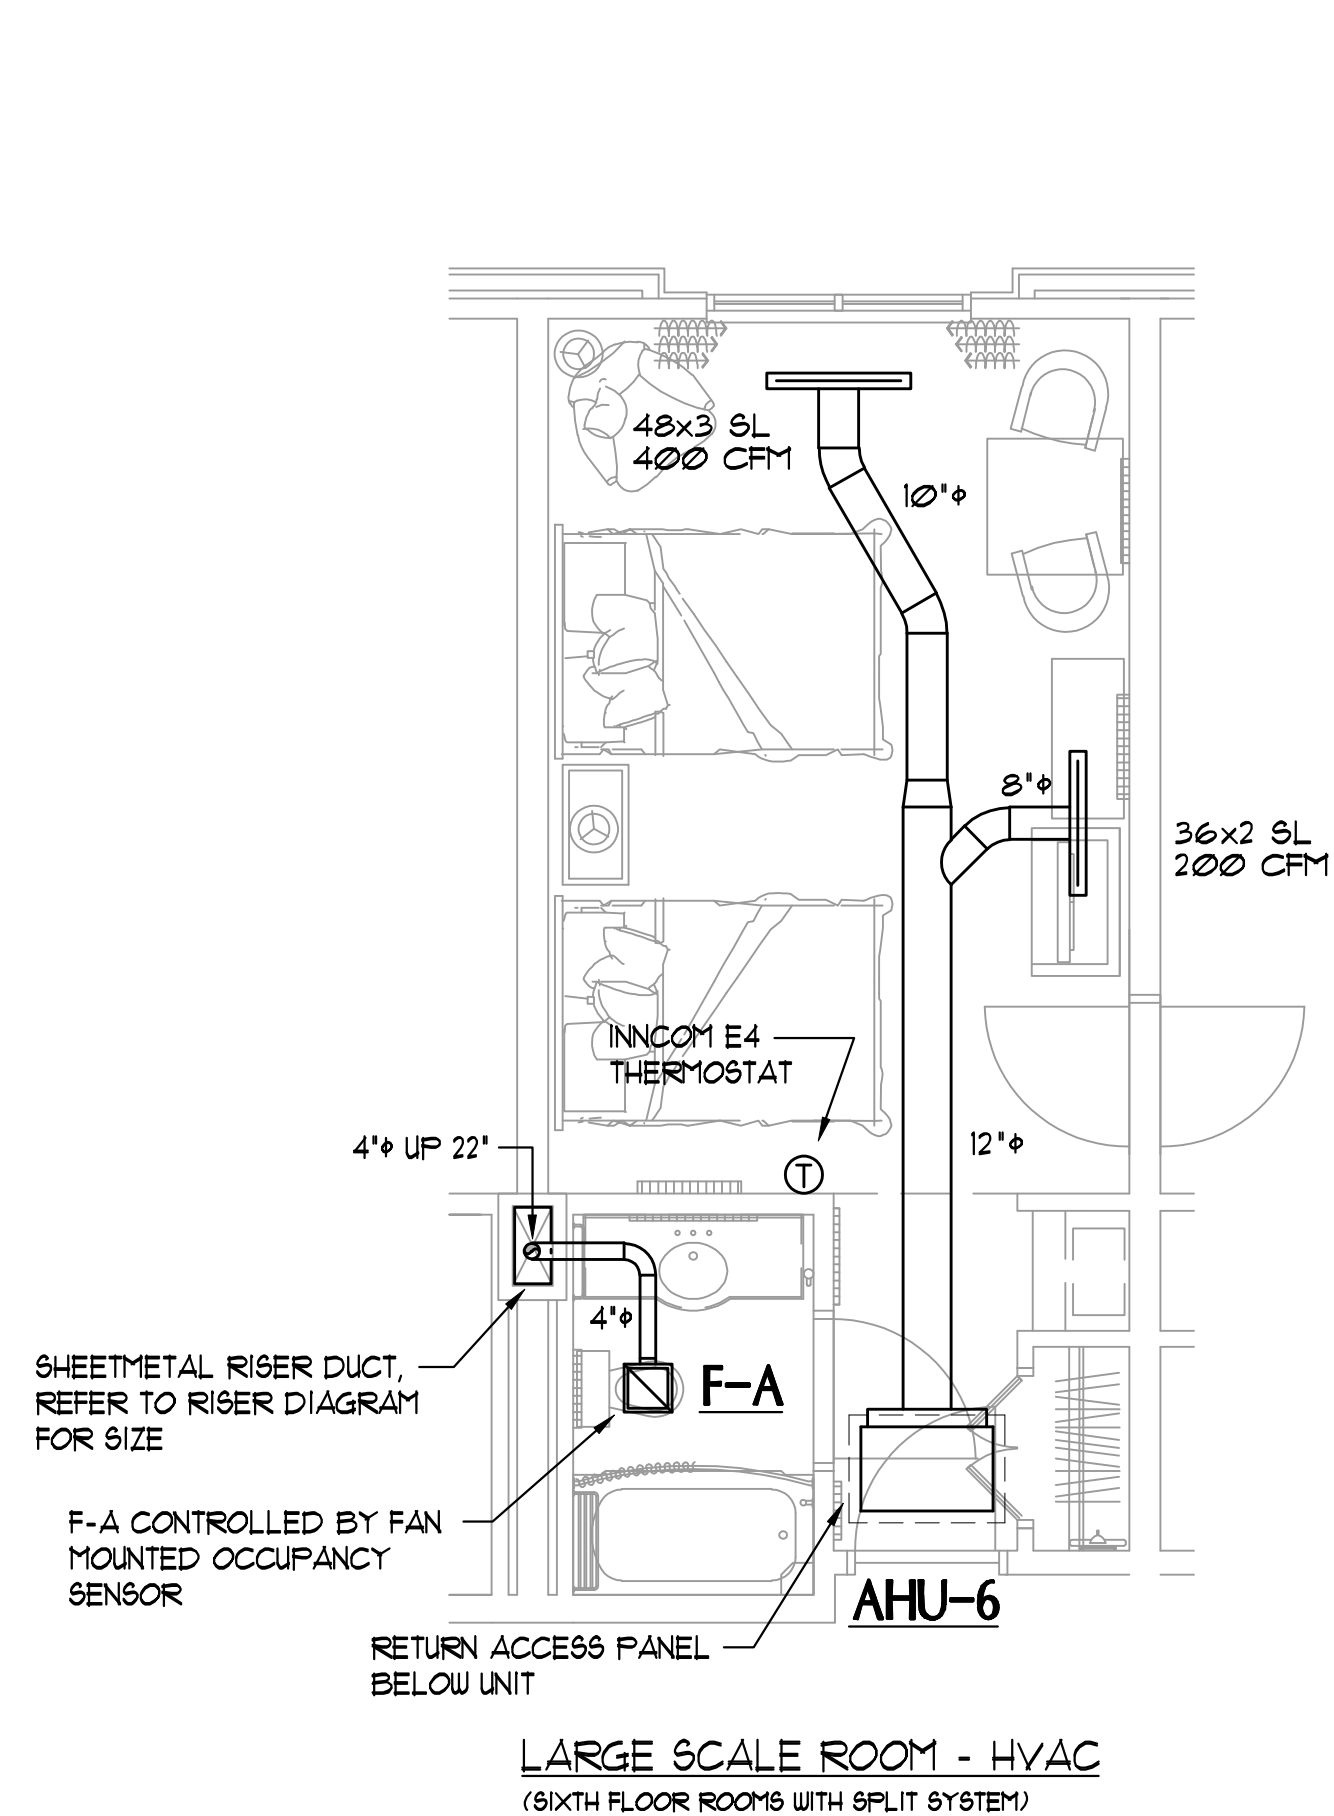


LARGE SCALE ROOM - HVAC  
(SIXTH FLOOR ROOMS WITH SPLIT SYSTEM)

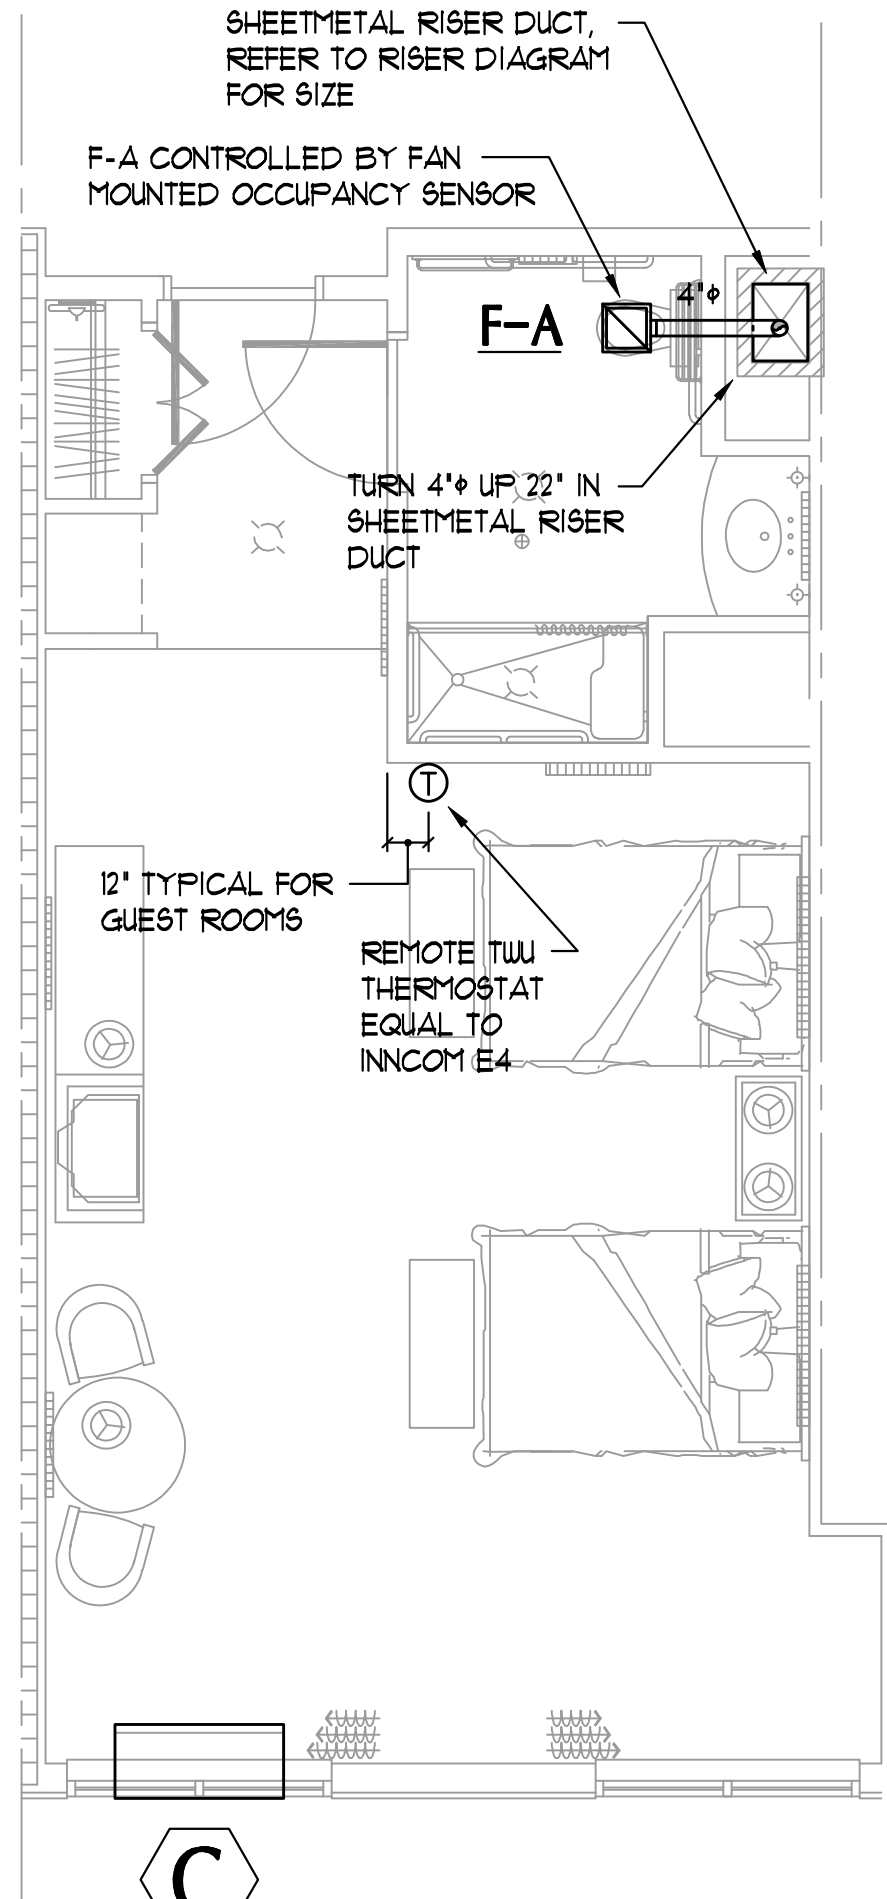


ACCESSIBLE DOUBLE QUEEN W/ RIS  
ACC DQ W/ TUB SIM  
-SEE FLOOR PLANS

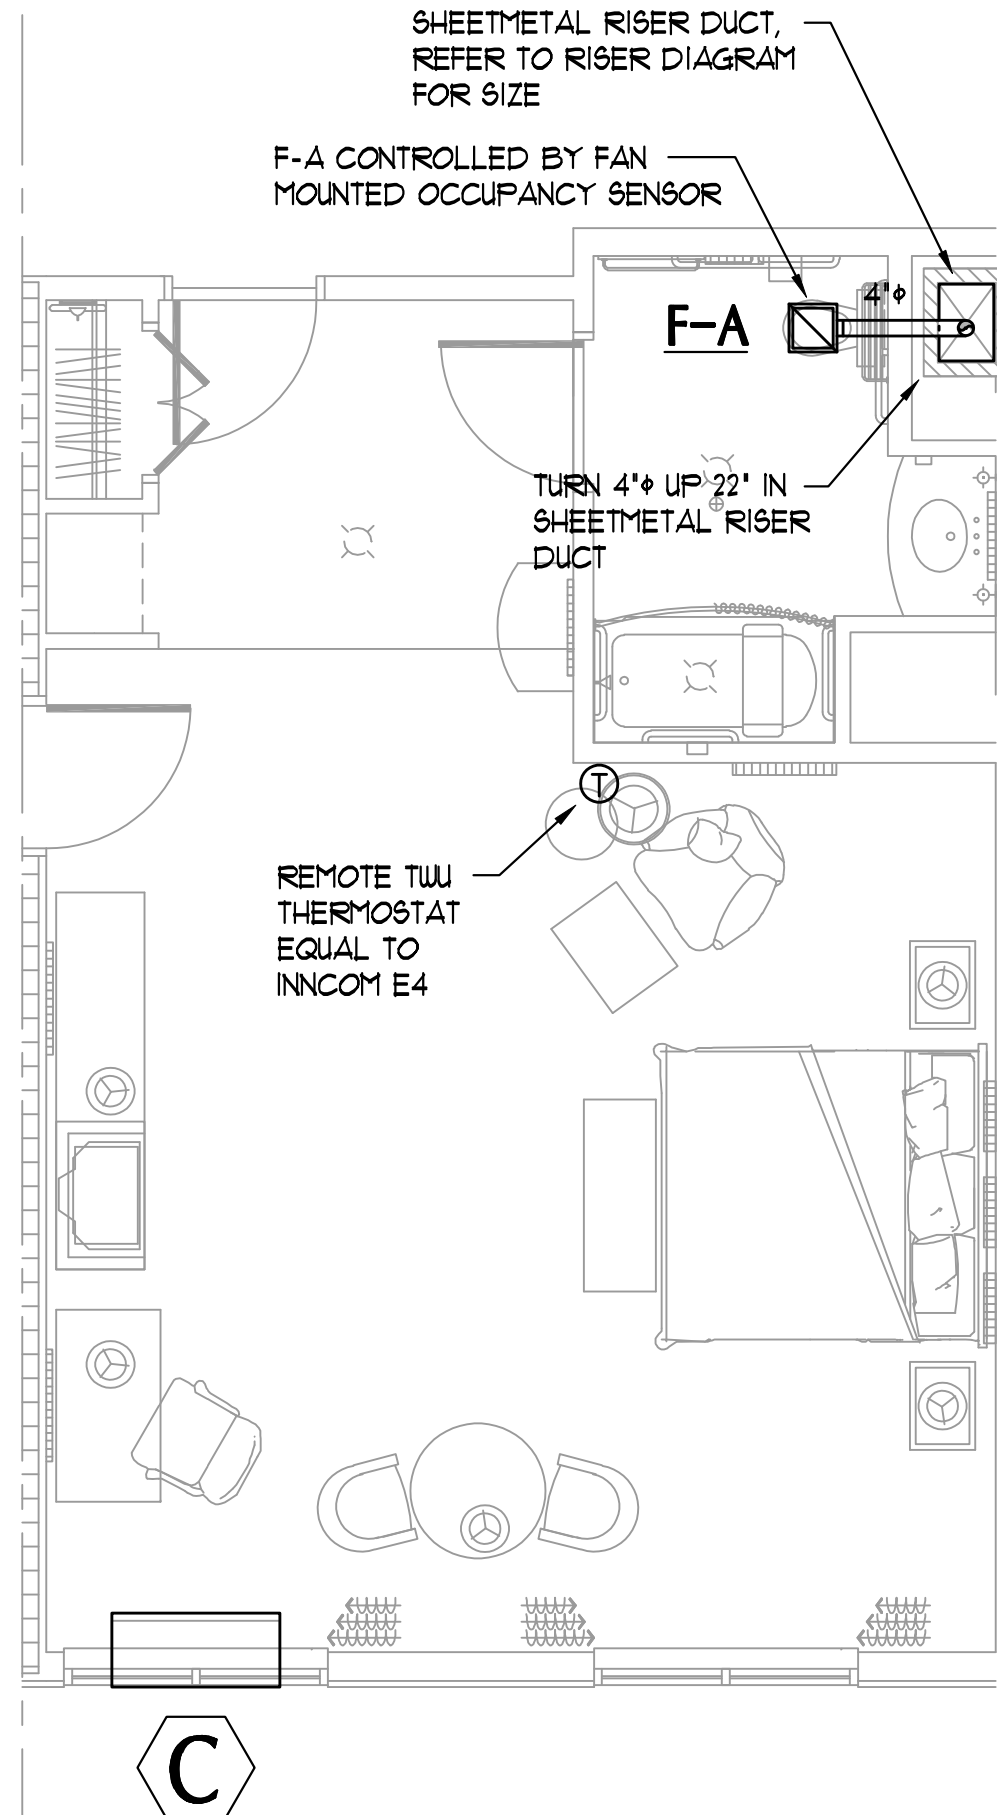

ACCESSIBLE KING W/ TUB  
ACC KING W/ RIS SIM  
-SEE FLOOR PLANS

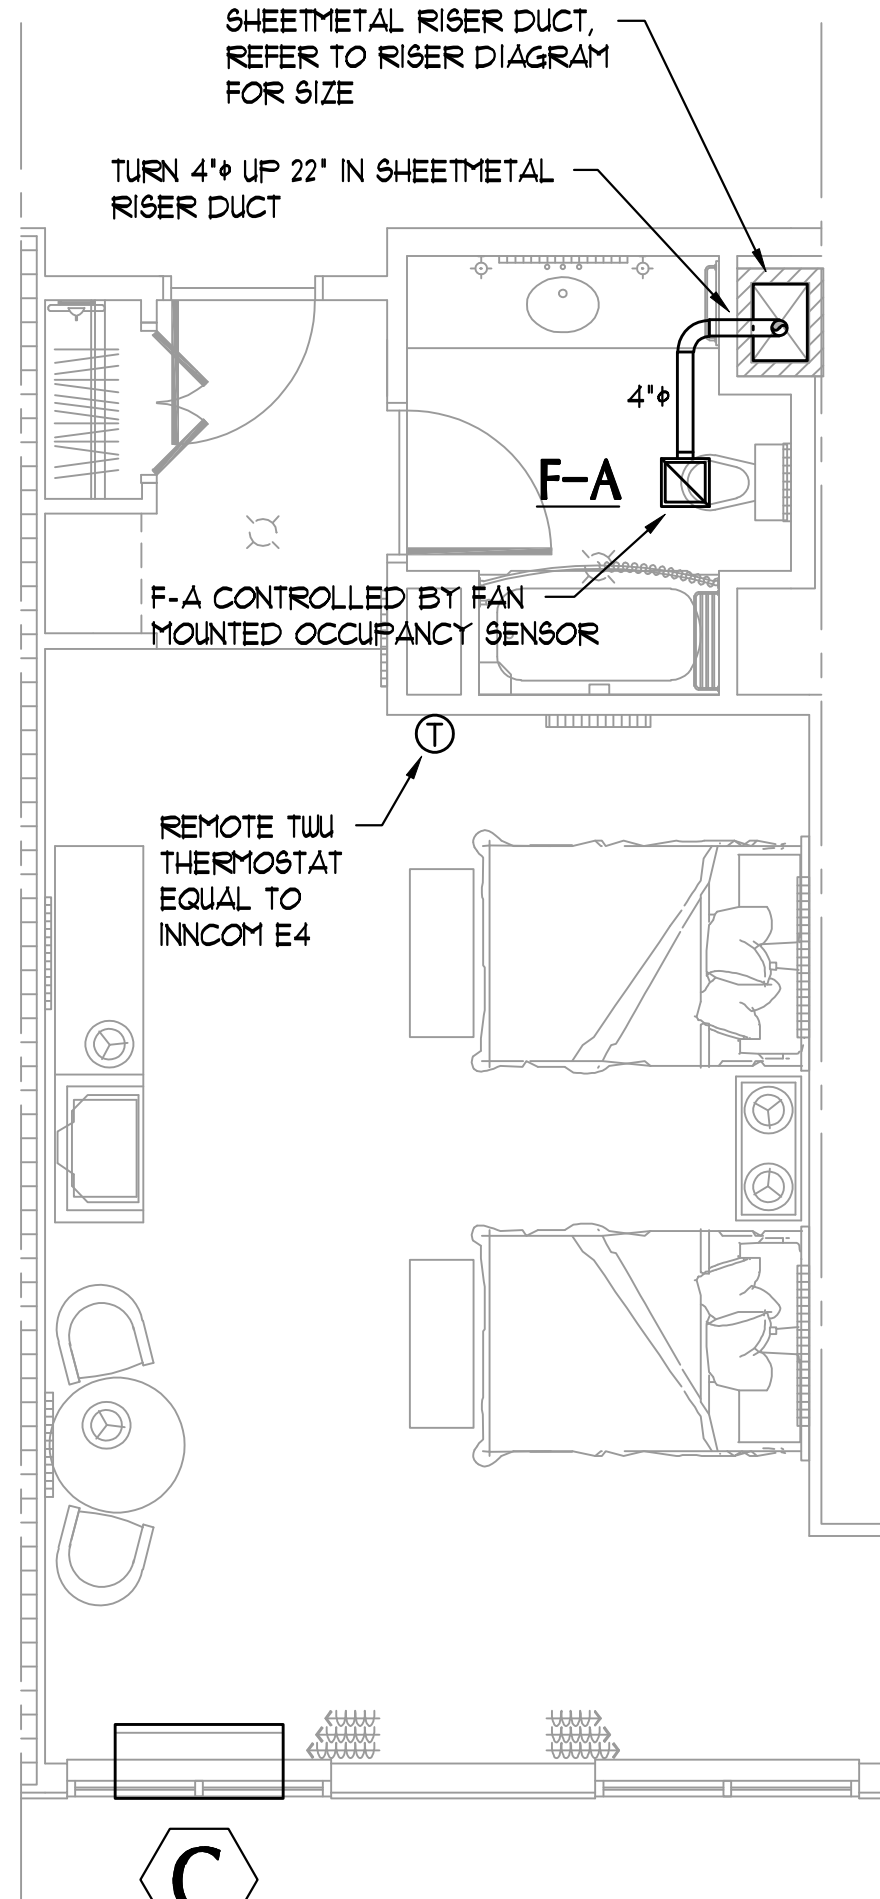

DOUBLE QUEEN PARLOR

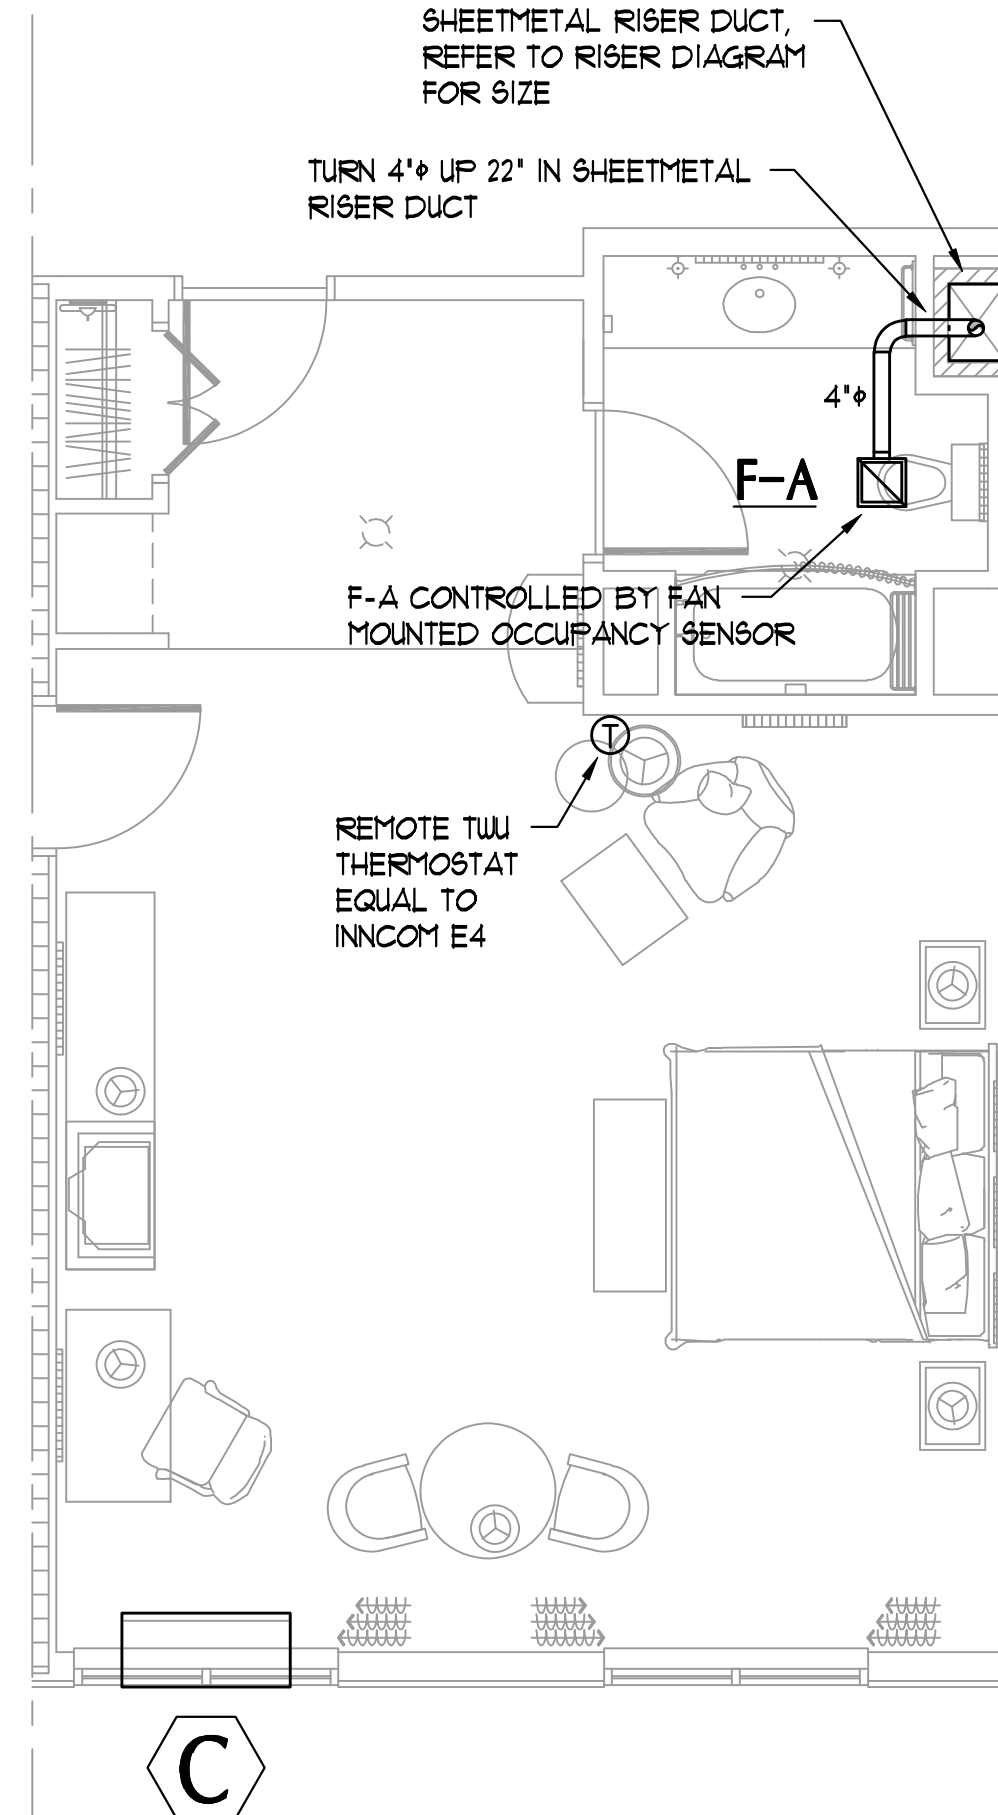

KING PARLOR

LARGE SCALE GUEST ROOM PLANS - HVAC  
SCALE: 1/4" = 1'-0"

CALL NORTH  
USED FOR ROOM  
FINISH SCHEDULE  
REFERENCE

M5.0