

NO.	ISSUED	DATE
1	ISSUED	10/26/07


NO.	REVISIONS	DATE

NO.	REVISIONS	DATE

CONSULTANTS
STRUCTURAL:
SK INTERNATIONAL, INC.
130 SOUTH MAIN STREET
HUNTSVILLE AL 35811
(256) 862-3098
MECHANICAL:
CRAFTREE ENGINEERING
726 S. MT. MORIAH
MEMPHIS, TN 38117
(901) 767-9898
PLUMBING:
CRAFTREE ENGINEERING
726 S. MT. MORIAH
MEMPHIS, TN 38117
(901) 767-9898
ELECTRICAL:
CHS ENGINEERING
726 S. MT. MORIAH
MEMPHIS, TN 38117
(901) 767-2557
SEAL

SHEET NAME
ROOF PLAN
Today's **new**
MILLENNIUM
BOSSIER CITY,
LOUISIANA

DATE
10/26/07
DRAWN BY
AP
CHECKED BY
PEL
FILE NAME
1507-A206
SCALE
AS NOTED
PROJECT NO.
1507

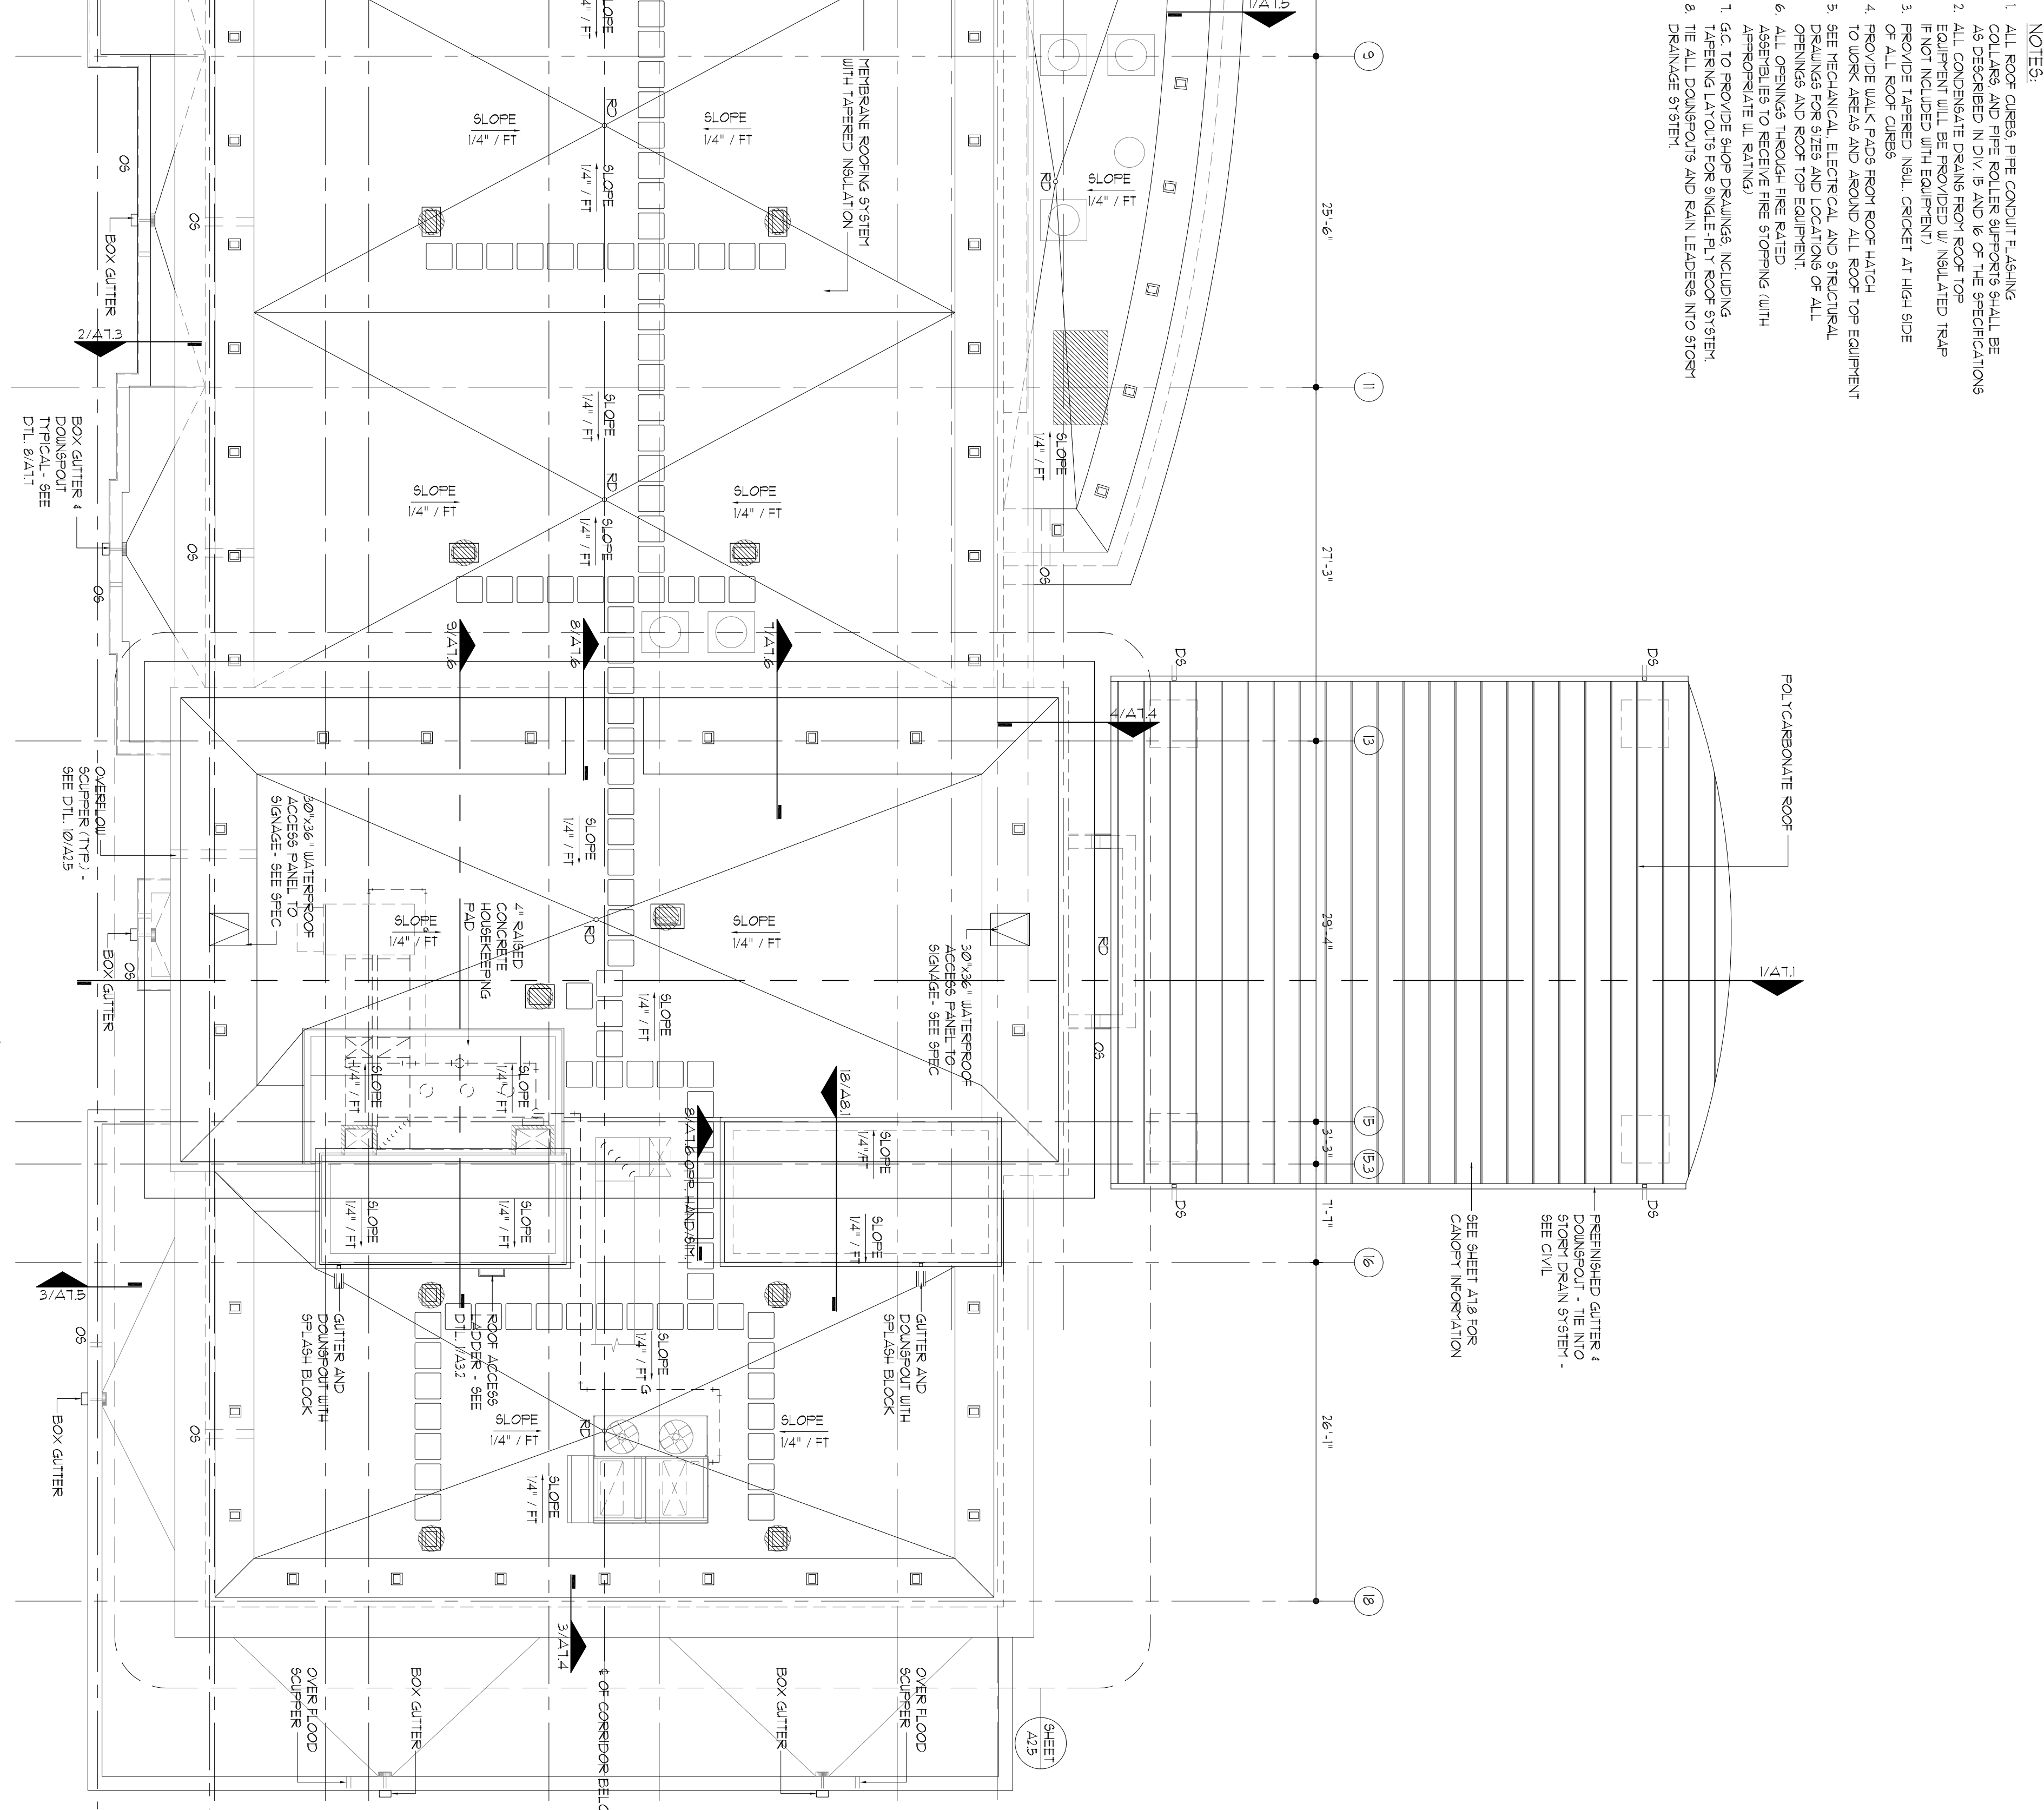

- NOTES:
1. ALL ROOF CURBS, PIPE CONDUIT FLASHING COLLARS, AND PIPE COLLAR SUPPORTS SHALL BE DESIGNED TO MEET ALL APPLICABLE REQUIREMENTS.
 2. ALL ROOF DRAINAGE SHALL BE TO THE EXTERIOR. EQUIPMENT WILL BE PROVIDED WITH INSULATED TRAP IF NOT INCLUDED WITH EQUIPMENT.
 3. PROVIDE TAPERED NAIL CRICKET AT HIGH SIDE OF ALL ROOF CURBS.
 4. PROVIDE WALK PADS FROM ROOF HATCH TO WORK AREAS AND AROUND ALL ROOF TOP EQUIPMENT.
 5. SEE MECHANICAL, ELECTRICAL AND STRUCTURAL DRAWINGS FOR SIZES AND LOCATION OF ALL OPENINGS THROUGH FIVE ELEVATION.
 6. ALL OPENINGS THROUGH FIVE ELEVATION SHALL BE PROVIDED WITH TAPERED NAIL CRICKET (WITH APPROPRIATE ILLUMINATION).
 7. GC TO PROVIDE SHOP DRAWINGS INCLUDING TAPERING LATIGUITS FOR SINGLE PLY ROOF SYSTEM.
 8. TIE ALL DOWNPOUTS AND RAIN LEADERS INTO STORY DRAINAGE SYSTEM.