



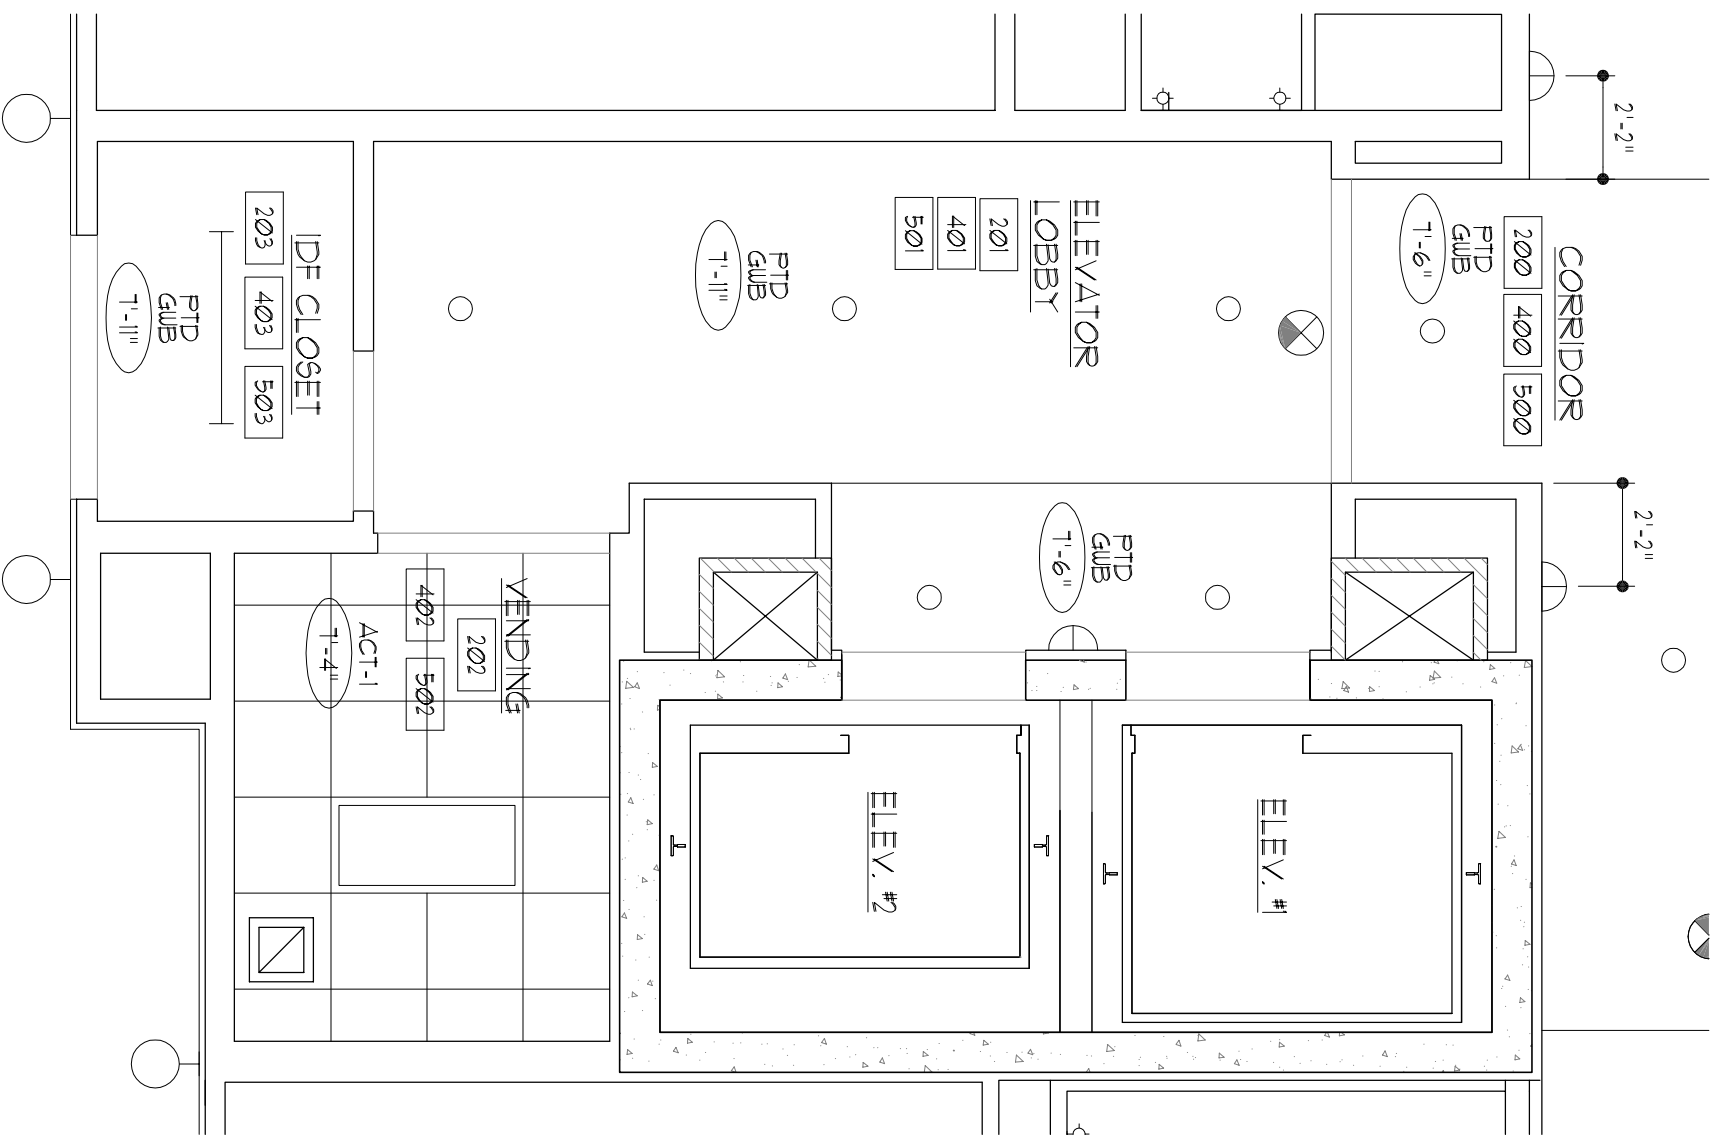


1 ELEVATOR LOBBY @ 2ND, 4TH, AND 5TH FLOORS
A4.10 SCALE: 1/4" = 1'-0"

SYMBOL LEGEND			
LAY-IN LIGHTING FIXTURES	SURFACE MOUNTED LIGHT FIXTURES	WALL MOUNTED LIGHT FIXTURE	MECHANICAL DIFFUSERS, GRILLES & OTHER MECHANICAL EQUIPMENT - SEE MECHANICAL
CHANDLIER LIGHT FIXTURES	WALL MOUNTED LIGHT FIXTURES	EXIT SIGN	

REFLECTED CEILING KEY LEGEND	
	ROOM FINISH KEY (SEE SHEET A3)
	FIRE-DOWN SOFFIT OR RATED SHAFT
	ACOUSTICAL CEILING TILE (ACT)
	ELEVATION KEY (SEE SHEET NUMBER INSIDE OF KEY)
	SECTION KEY
	CEILING FINISH MATERIAL CLEAR CEILING HEIGHT

- NOTES:
- ALL DIMENSIONS ARE TO CENTERLINE OR TO FACE OF FINISHED WALL UNLESS NOTED OTHERWISE.
 - IN ADDITION TO THE HANDICAP ACCESSIBLE ROOMS, ROOMS IDENTIFIED "HEARING IMPAIRED" SHALL HAVE IDENTICAL ELECTRICAL SYSTEMS AS ACCESSIBLE ROOMS IN BEDROOM AREA AND BATHROOM.
 - PROVIDE ACCESS PANELS AS REQUIRED.
 - PROVIDE RIGID INSULATION AT CEILING AT PERIMETER.
 - ELEVATOR EQUIPMENT, AND ANY OTHER DESIGNATED LOCATIONS, ARE TO PROVIDE BLOCKING FOR ALL ACCESSORIES AND BUILDING ITEMS THAT ARE WALL OR CEILING MOUNTED, INCLUDING WOOD TRIM AND MILLWORK.
 - COORDINATE MECHANICAL, ELECTRICAL AND SPRINKLER PLANS FOR CONFLICTS AND ACCESS PANELS.
 - CHECK WHETHER DESIGN RELATES TO WINDOW MULLIONS OR OTHER WALL PATTERN.
 - ALL SCHEDULED CEILING SYSTEMS TO BE DESIGNED AND INSTALLED PER LOCAL CODE REQUIREMENTS.
 - WHERE SPRINKLER HEADS AND SMOKE DETECTORS OCCUR, THEY ARE TO BE INSTALLED IN ACCORDANCE WITH THE MANUFACTURER'S INSTALLATION INSTRUCTIONS.
 - SEE FINISH SCHEDULE FOR FURTHER INFORMATION REGARDING FINISHES AND CEILING HEIGHTS.
 - SEE SHEET A4.5 FOR GUEST ROOM REFLECTED CEILING PLANS.
 - PAINT REGISTER GRILLES & ELECTRICAL PANELS TO MATCH ADJACENT SURFACE COLOR.

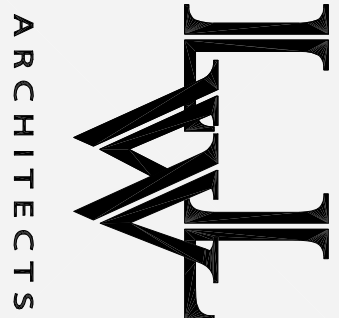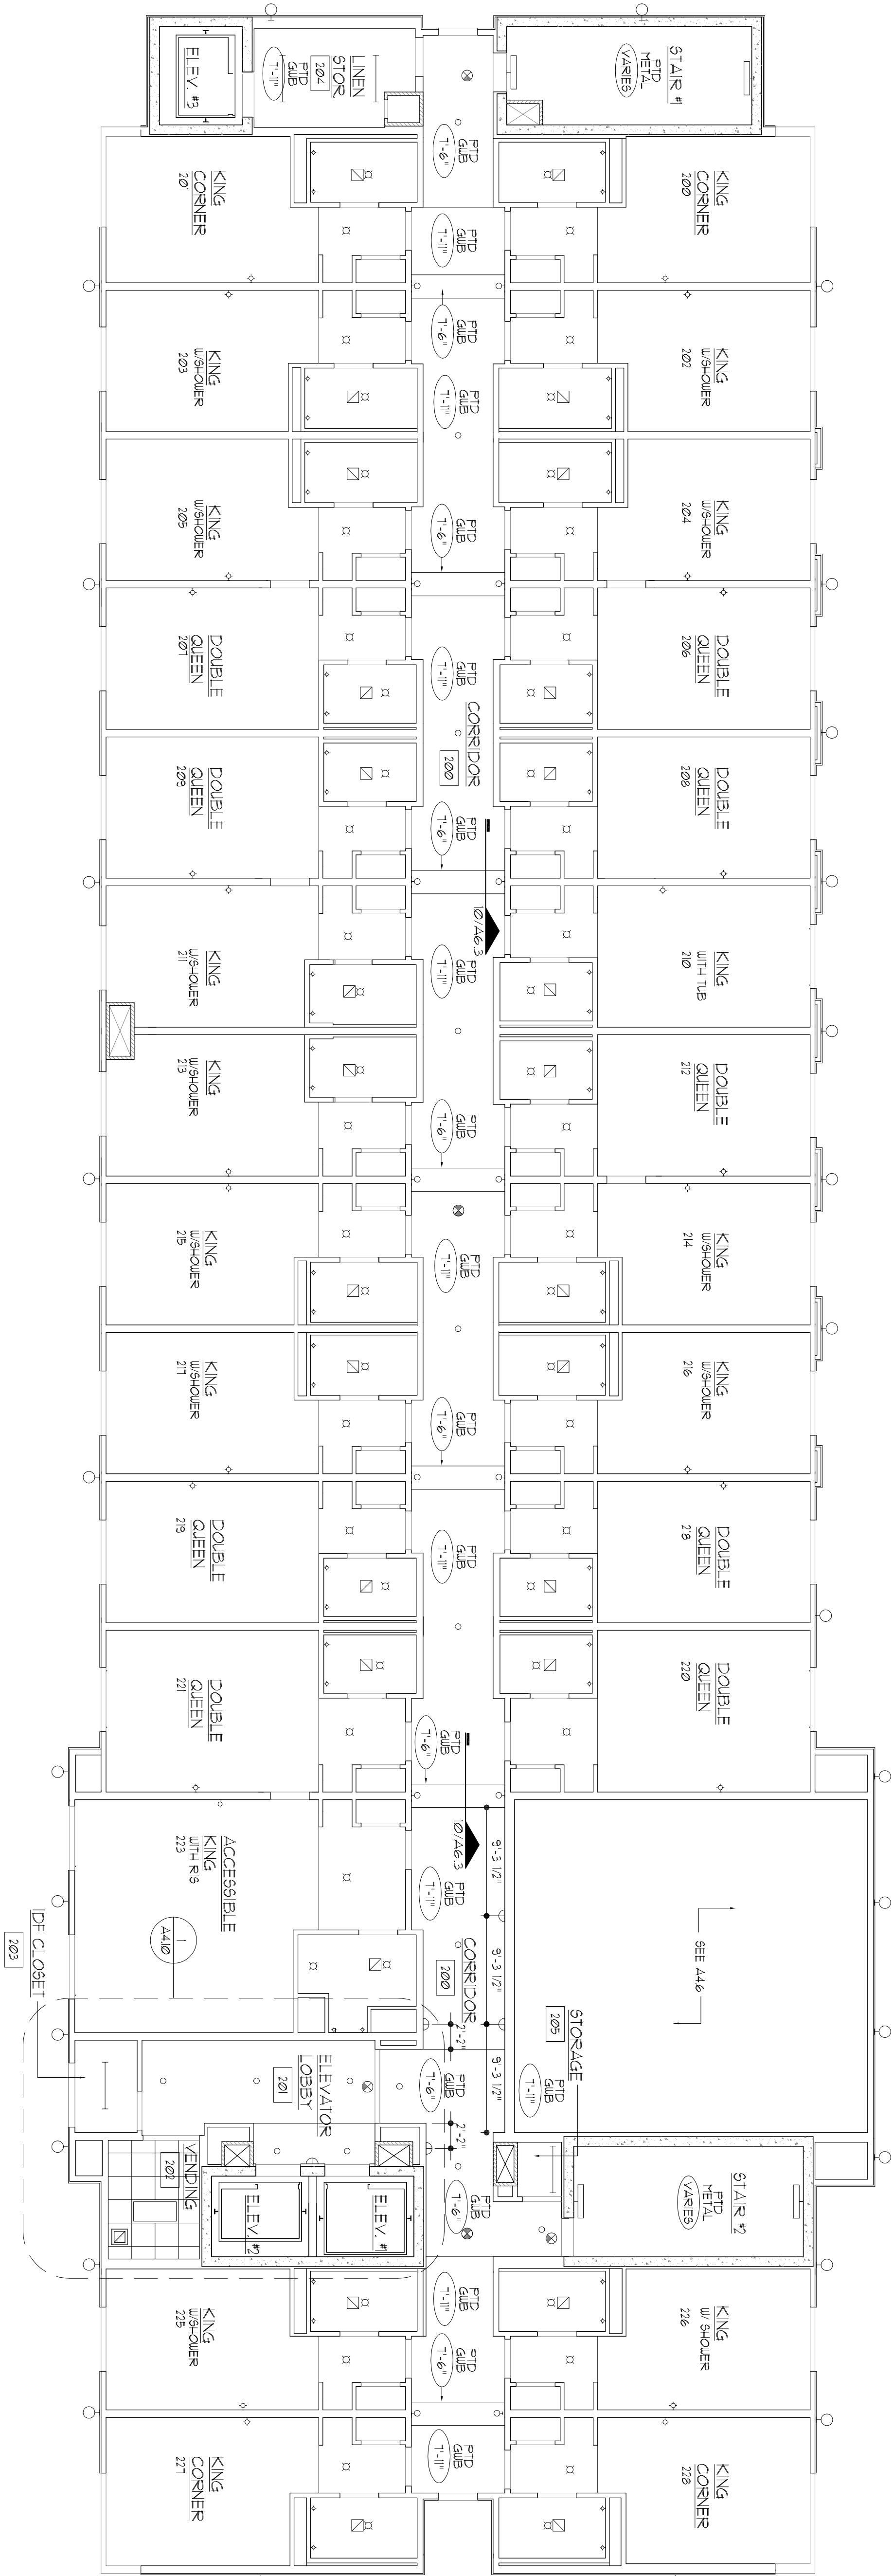

803 S. MOUNT MORIAH
SUITE 100B
MEMPHIS, TN 38117
(901) 863-7775 p.
(901) 863-2385 f.
lhw@lhwarchitects.com

NO.	ISSUED	DATE
1	ISSUED	10/26/07

NO.	REVISIONS	DATE

CONSULTANTS
STRUCTURAL:
SK INTERNATIONAL, INC.
130 SOUTH MAIN STREET
HUNTSVILLE, AL 35811
(256) 862-3098

MECHANICAL:
CRABTREE ENGINEERING
726 S. MT. MORIAH
MEMPHIS, TN 38117
(901) 767-9898

PLUMBING:
CRABTREE ENGINEERING
726 S. MT. MORIAH
MEMPHIS, TN 38117
(901) 767-9898

ELECTRICAL:
CHS ENGINEERING
726 S. MT. MORIAH
MEMPHIS, TN 38117
(901) 767-2557

SEAL

Holiday *gma*
MILLENNIUM

BOSSIER CITY,
LOUISIANA

SHEET NAME
SECOND FLOOR
REFLECTED
CEILING PLAN

DATE
10/26/07

DRAWN BY
JRS

CHECKED BY
PEL

FILE NAME
1507-AA10

SCALE
AS NOTED

PROJECT NO.
1507

SECOND FLOOR REFLECTED CEILING PLAN

SCALE:

1/8" = 1'-0"



CALL NORTH

A4.10