



803 S. MOUNT MORIAH

SUITE 100B

MEMPHIS, TN 38117

(901) 863-7775 p.

(901) 863-2385 f.

lhw@lwarchitects.com

NO.	ISSUED	DATE
1	ISSUED	10/26/07

NO.	REVISIONS	DATE

COPYRIGHT BY LW ARCHITECTS, INC.
WARNING: UNAUTHORIZED COPYING VIOLATES
U.S. COPYRIGHT LAWS AND WILL SUBJECT THE
VIOLATOR TO LEGAL PROSECUTION.

CONSULTANTS

STRUCTURAL:
SK INTERNATIONAL, INC.
130 SOUTH MAIN STREET
HUNTSVILLE, AL 35811
(256) 862-3098

MECHANICAL:
CRABTREE ENGINEERING
726 S. MT. MORIAH
MEMPHIS, TN 38117
(901) 767-9898

PLUMBING:
CRABTREE ENGINEERING
726 S. MT. MORIAH
MEMPHIS, TN 38117
(901) 767-9898

ELECTRICAL:
CHS ENGINEERING
726 S. MT. MORIAH
MEMPHIS, TN 38117
(901) 767-2557


SEAL

Welding Guy
MILLER/INVENTUM


BOSSIER CITY,
LOUISIANA

SHEET NAME
SIXTH FLOOR
AND ATTIC
CEILING PLAN


DATE	10/26/07
DRAWN BY	JRS
CHECKED BY	PEL
FILE NAME	1507-AA12
SCALE	AS NOTED
PROJECT NO.	1507
DRAWING	

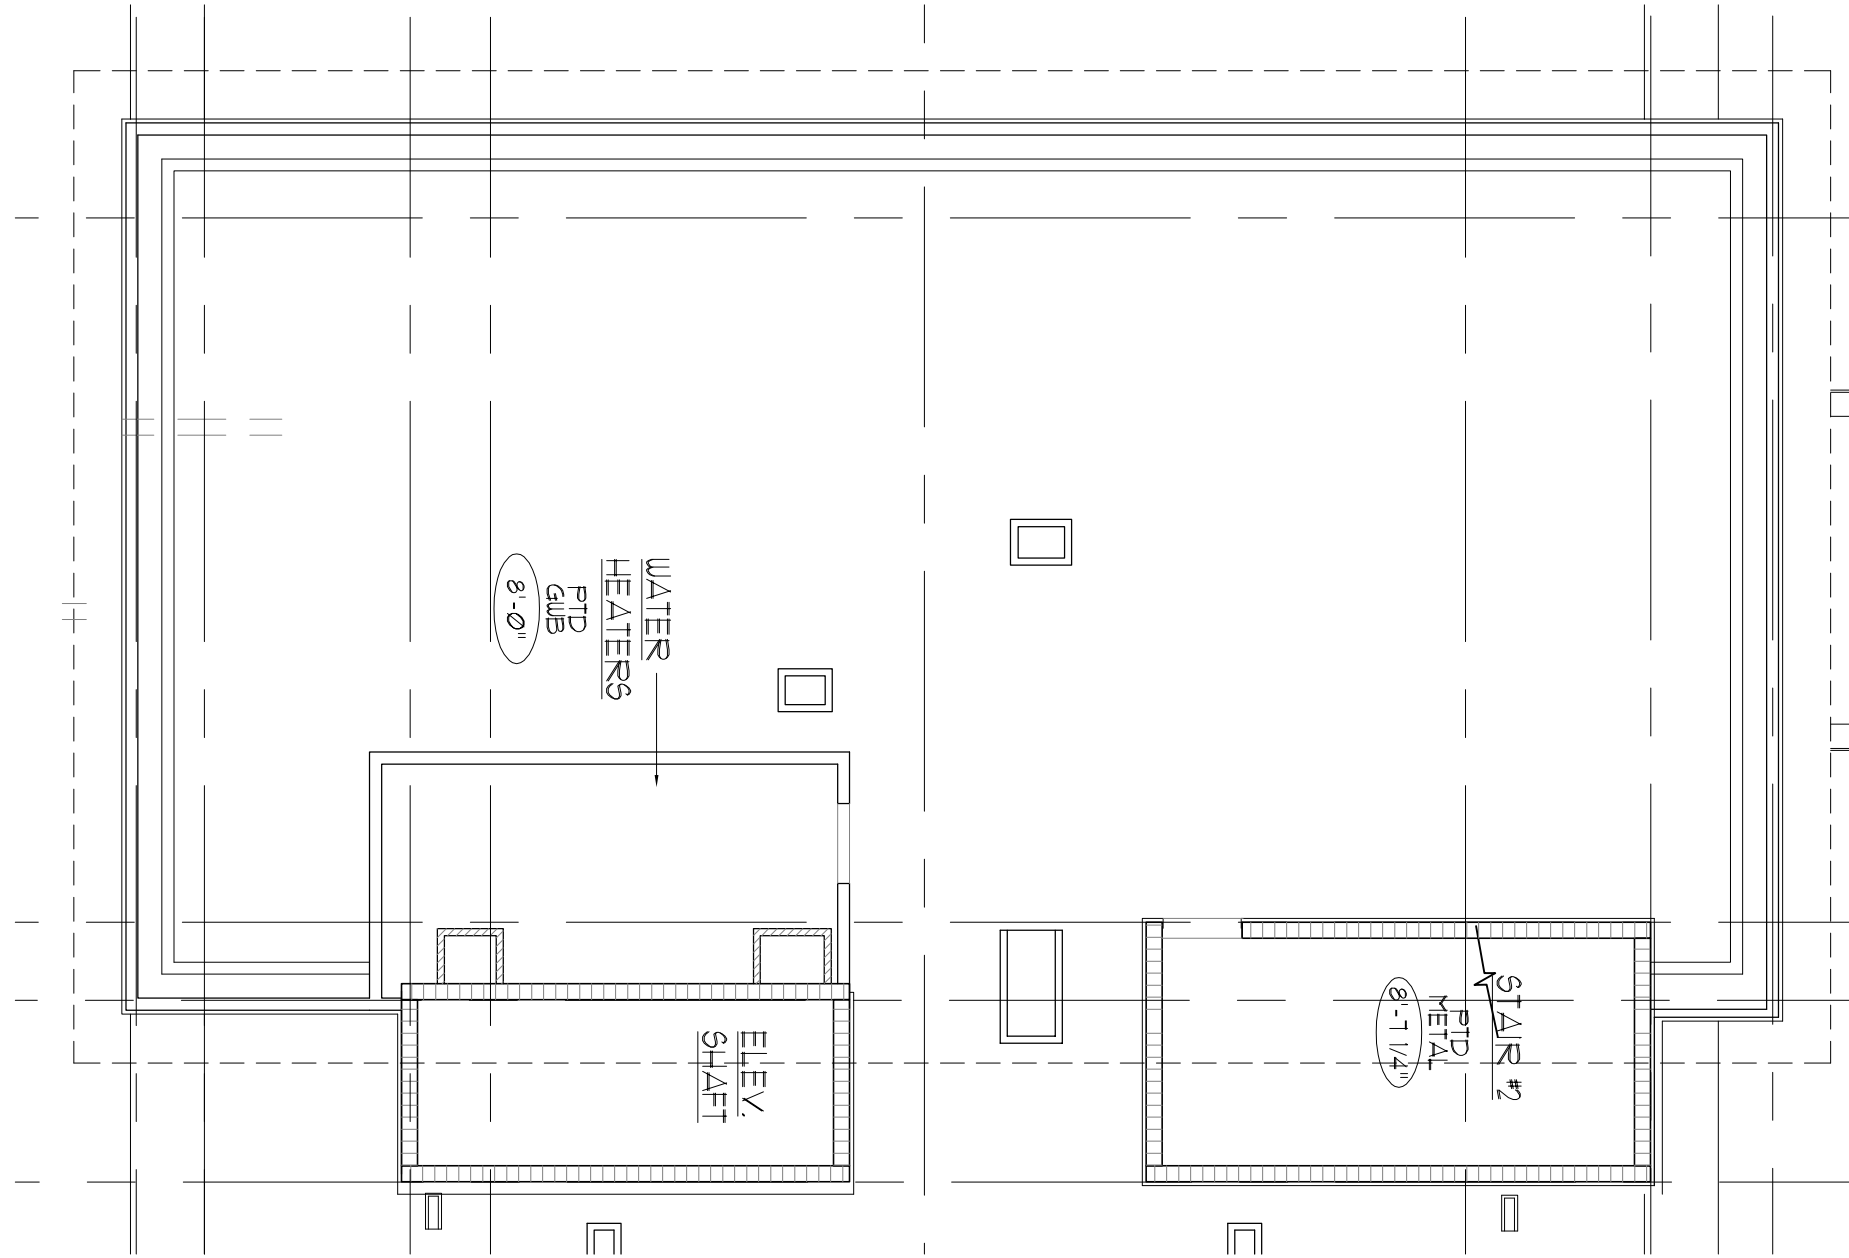

1 ATTIC REFLECTED CEILING PLAN
A412 SCALE: 1/32" = 1'-0"

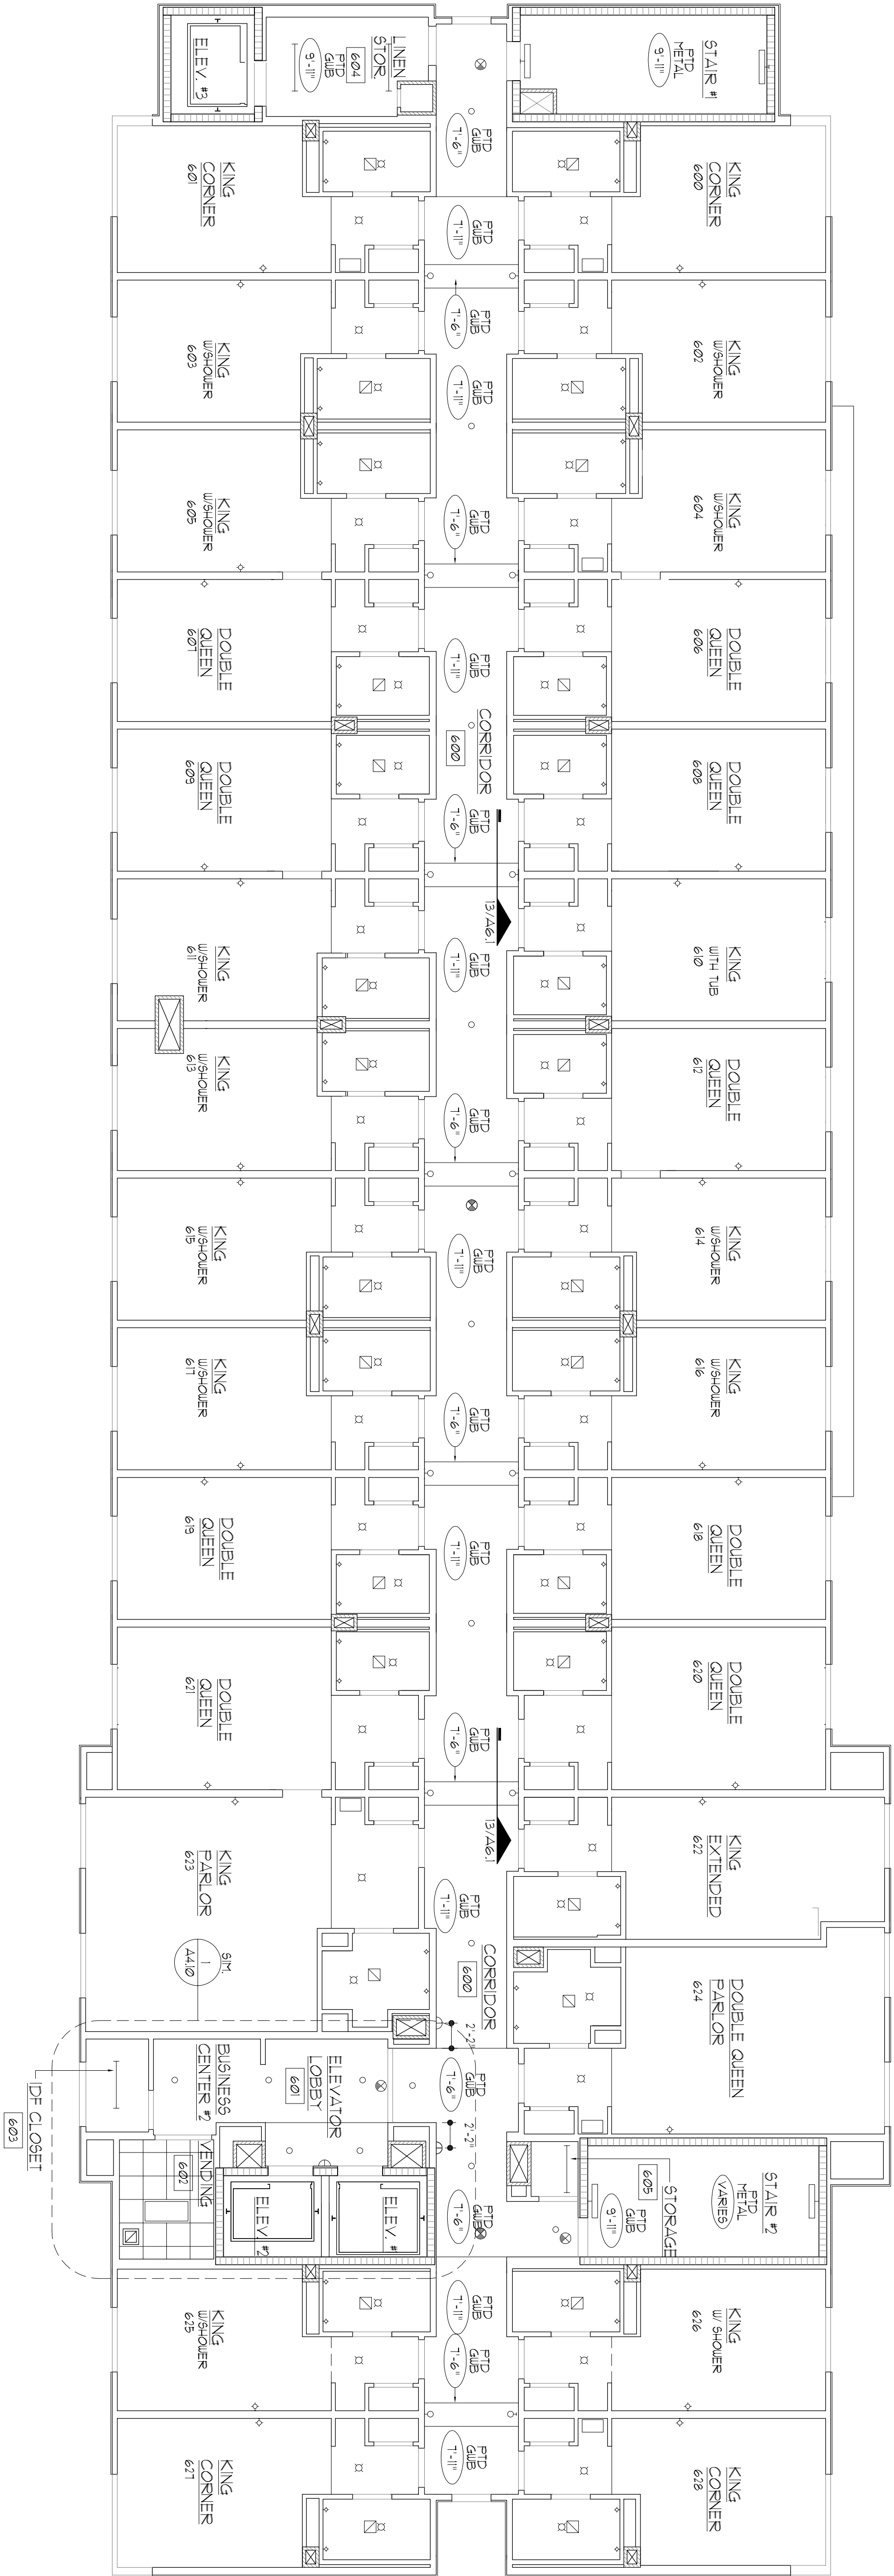

SIXTH FLOOR REFLECTED CEILING PLAN
SCALE 1/8" = 1'-0"

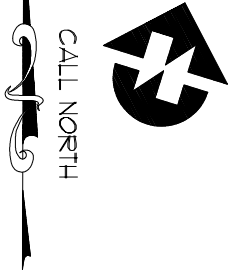

A4.12