



803 S. MOUNT MORIAH
SUITE 100B
MEMPHIS, TN 38117
(901) 683-7175 p.
(901) 683-2385 f.
llw@llwarchitects.com


[illegible]CONSULTANTS
STRUCTURAL:

INTERNATIONAL, INC.
SOUTH MAIN STREET
PITTSVILLE, AL 35811
(205) 852-3098

MECHANICAL:
BARTREE ENGINEERING
S. MT. MORIAH
MEMPHIS, TN 38117
(767-9898

MBING:
BRTREE ENGINEERING
S. MT. MORIAH
MPHIS, TN 38117
) 767-9898

CTRICAL:
ENGINEERING
S. MT. MORIAH
MPHIS, TN 38117
) 767-2557

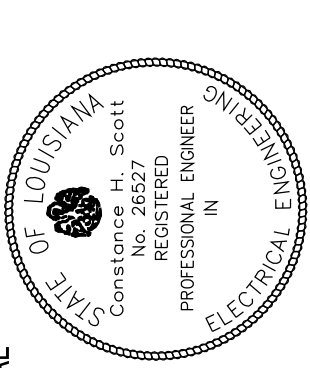


Holiday Inn
MILLENNIUM
BOSSIER CITY,
LOUISIANA

ET NAME
ROUND FLOOR
LAN - LIGHTING

E	10/26/07
OWN BY	JSH
BOOKED BY	CHS
NAME	
FILE	AS NOTED
SUBJECT NO.	

1507
WING

10E

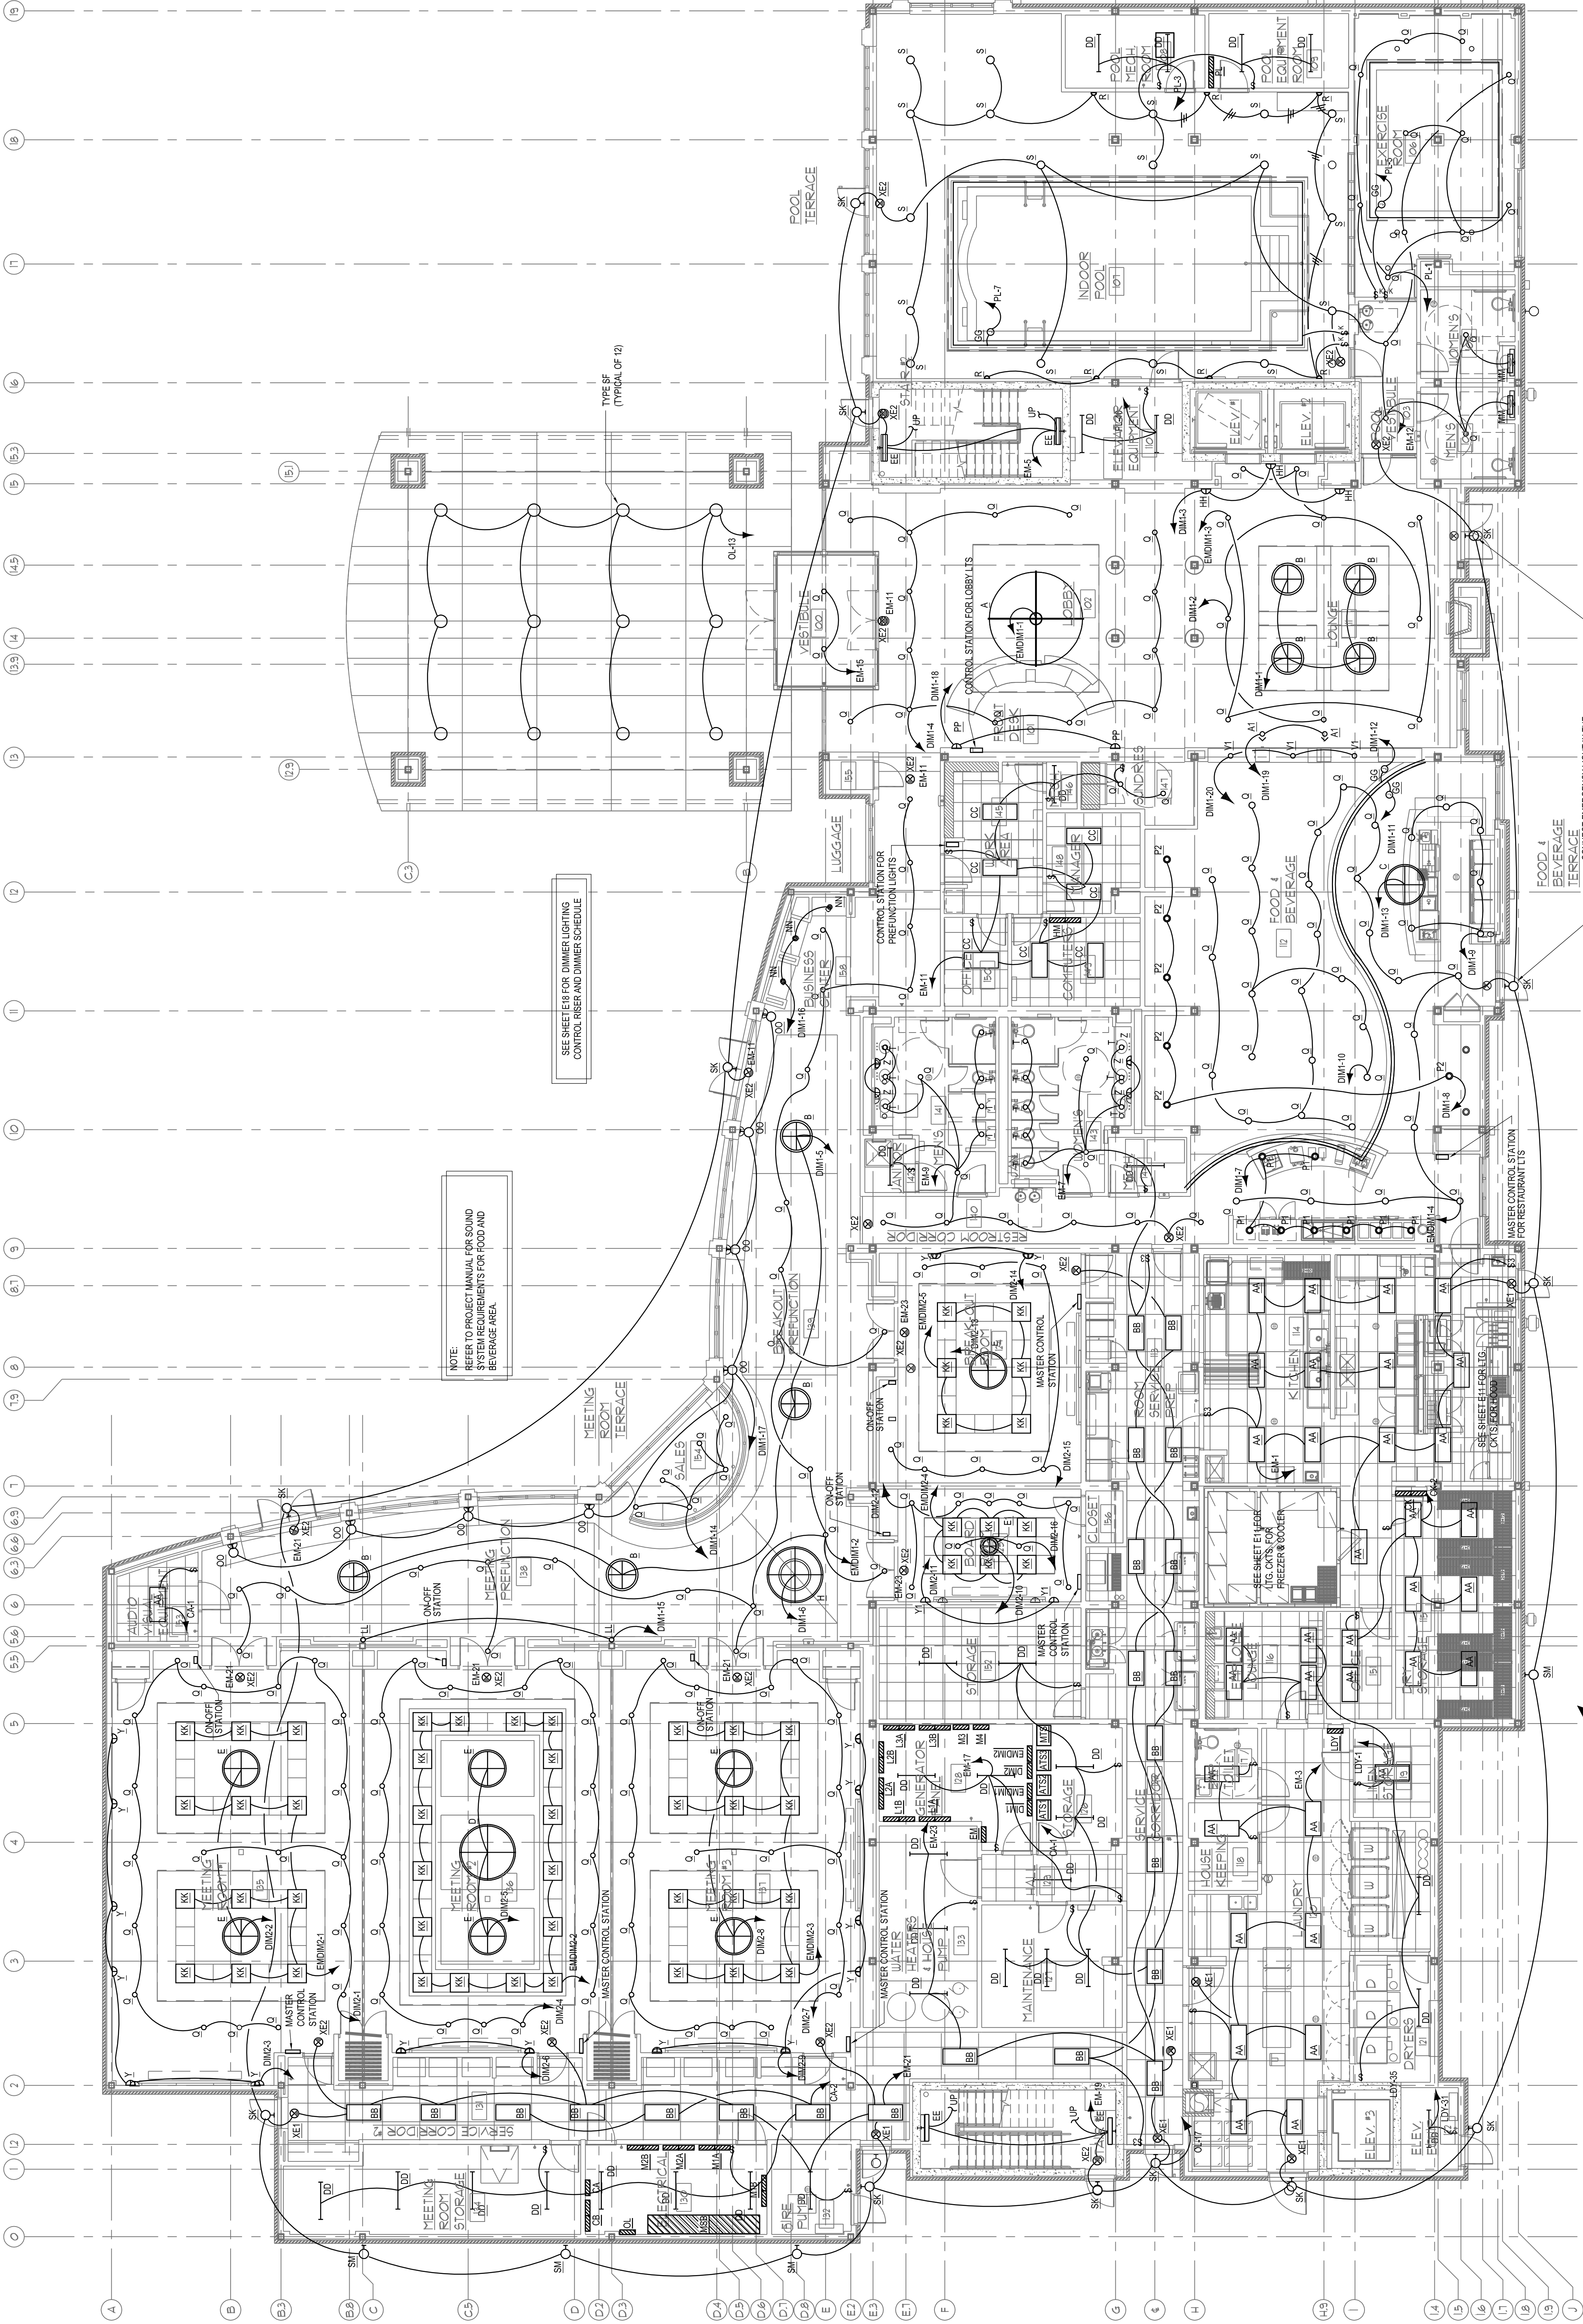

GROUND FLOOR PLAN - LIGHTING

SCALE: 1/8" = 1'-0"



CALL NORTH