



803 S. MOUNT MORIAH
SUITE 100B

MEMPHIS, TN 38117
(901) 683-7175 p.
(901) 683-2385 f.

lmw@iwaarchitects.com

NO.	ISSUED	DATE
1	ISSUED	10/26/07

NO.	REVISIONS	DATE


CONSULTANTS
STRUCTURAL:
SK INTERNATIONAL, INC.
130 SOUTH MAIN STREET
HUNTSVILLE, AL 35811
(256) 852-3098

MECHANICAL:
CRABTREE ENGINEERING
726 S. MT. MORIAH
MEMPHIS, TN 38117
(901) 767-9898

PLUMBING:
CRABTREE ENGINEERING
726 S. MT. MORIAH
MEMPHIS, TN 38117
(901) 767-9898

ELECTRICAL:
CHS ENGINEERING
726 S. MT. MORIAH
MEMPHIS, TN 38117
(901) 767-2557

SEAL

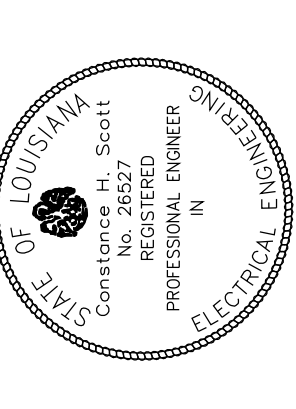


Holiday Inn MILLENNium
BOSSIER CITY,
LOUISIANA

SHEET NAME
FIFTH FLOOR
PLAN - ELECTRICAL

DATE	10/26/07
DRAWN BY	JSH
CHECKED BY	CHS
FILE NAME	
SCALE	AS NOTED
PROJECT NO.	1507
DRAWING	

E06

- ELECTRICAL POWER NOTES:
- COORDINATE LOCATION OF ALL EQUIPMENT IN ELEVATOR EQUIPMENT ROOMS WITH ELEVATOR VENDOR. EQUIPMENT LOCATION SHALL BE IN COMPLIANCE WITH ALL NATIONAL AND LOCAL CODES.
 - PROVIDE ALL ASSOCIATED ELECTRICAL REQUIRED FOR FREEMANS ELEVATOR RECALL.
 - CONTRACTOR SHALL PROVIDE A COMPLETE, OPERATIONAL FIRE ALARM SYSTEM IN ACCORDANCE WITH ALL CODE, INTERCONTINENTAL HOTELS, INC. FRANCHISE, AND MANUFACTURER'S REQUIREMENTS. INCLUDING DEVICES (PANELS, DETECTORS, TAMPERS, AND TAMPERS) SHALL BE PROVIDED. PROVIDE P.I.V. AND DUCT SMOKE DETECTORS FOR MECHANICAL UNITS. PROVIDE CARBON MONOXIDE DETECTORS IN ALL AREAS OF GAS FIRED APPLIANCES.
 - REFER TO MECHANICAL PLANS FOR EXACT LOCATION OF EQUIPMENT.
 - LAUNDRY CHUTE DOOR INTERLOCK TO TIE CIRCUIT LVD-37, TYPICAL EACH FLOOR.
 - PROVIDE REMOTE ON/OFF SWITCH FOR FIREPLACE PILOT LIGHT, LOCATE ON SIDEWALL OF FRONT DESK.
 - CONTRACTOR TO COORDINATE EXACT LOCATIONS OF ALL FLOOR MOUNTED RECEPTACLES, LIGHTS, AND OUTLETS WITH OTHER TRADES. PROVIDE DESIGNER AND FINAL FURNITURE LAYOUT PRIOR TO BEGINNING INSTALLATION.
8. HOUSE PHONE AT *48* ONLY WITH AUTOMATIC DIAL TO FRONT DESK
9. CARD READERS INSTALLED PER MANUFACTURERS INSTRUCTIONS.
CARD READER HARD WIRE CONNECTION
10. CONTRACTOR SHALL PROVIDE A COMPLETE, OPERATIONAL FIRE ALARM SYSTEM IN ACCORDANCE WITH ALL CODE AND MANUFACTURING REQUIREMENTS, INCLUDING DETECTORS, TAMPERS, AND TAMPERS BUT NOT INDICATED HEREIN. SYSTEM SHALL INCLUDE RED CONNECTIONS TO FLOW AND TAMPER SWITCHES AS WELL AS P.I.V., AND DUCT SMOKE DETECTORS FOR MECHANICAL UNITS.
11. EMERGENCY PANG BUTTON AT 38" MAX. A.F.F. W/ ANNUNCIATION BELL LOCATED AT FRONT DESK.
12. CONTRACTOR SHALL PROVIDE 100V POWER, CONNECT TO CIRCUIT #M-20 FOR BUILDING ALARM SYSTEM INSTALLATION BY OTHERS. COORDINATE EXACT LOCATION OF PANEL WITHIN OFFICE AREA WITH ALARM VENDOR.
13. ALL W/90G0 RECEPTACLES TO HAVE IN-USE COVERS.
14. FIRE ALARM CONTRACTOR SHALL ENSURE THAT FINAL PLACEMENT OF CEILING MOUNTED FIXTURES DO NOT CONFLICT WITH OTHER CEILING MOUNTED EQUIPMENT (e.g. LIGHTS, DIFFUSERS).

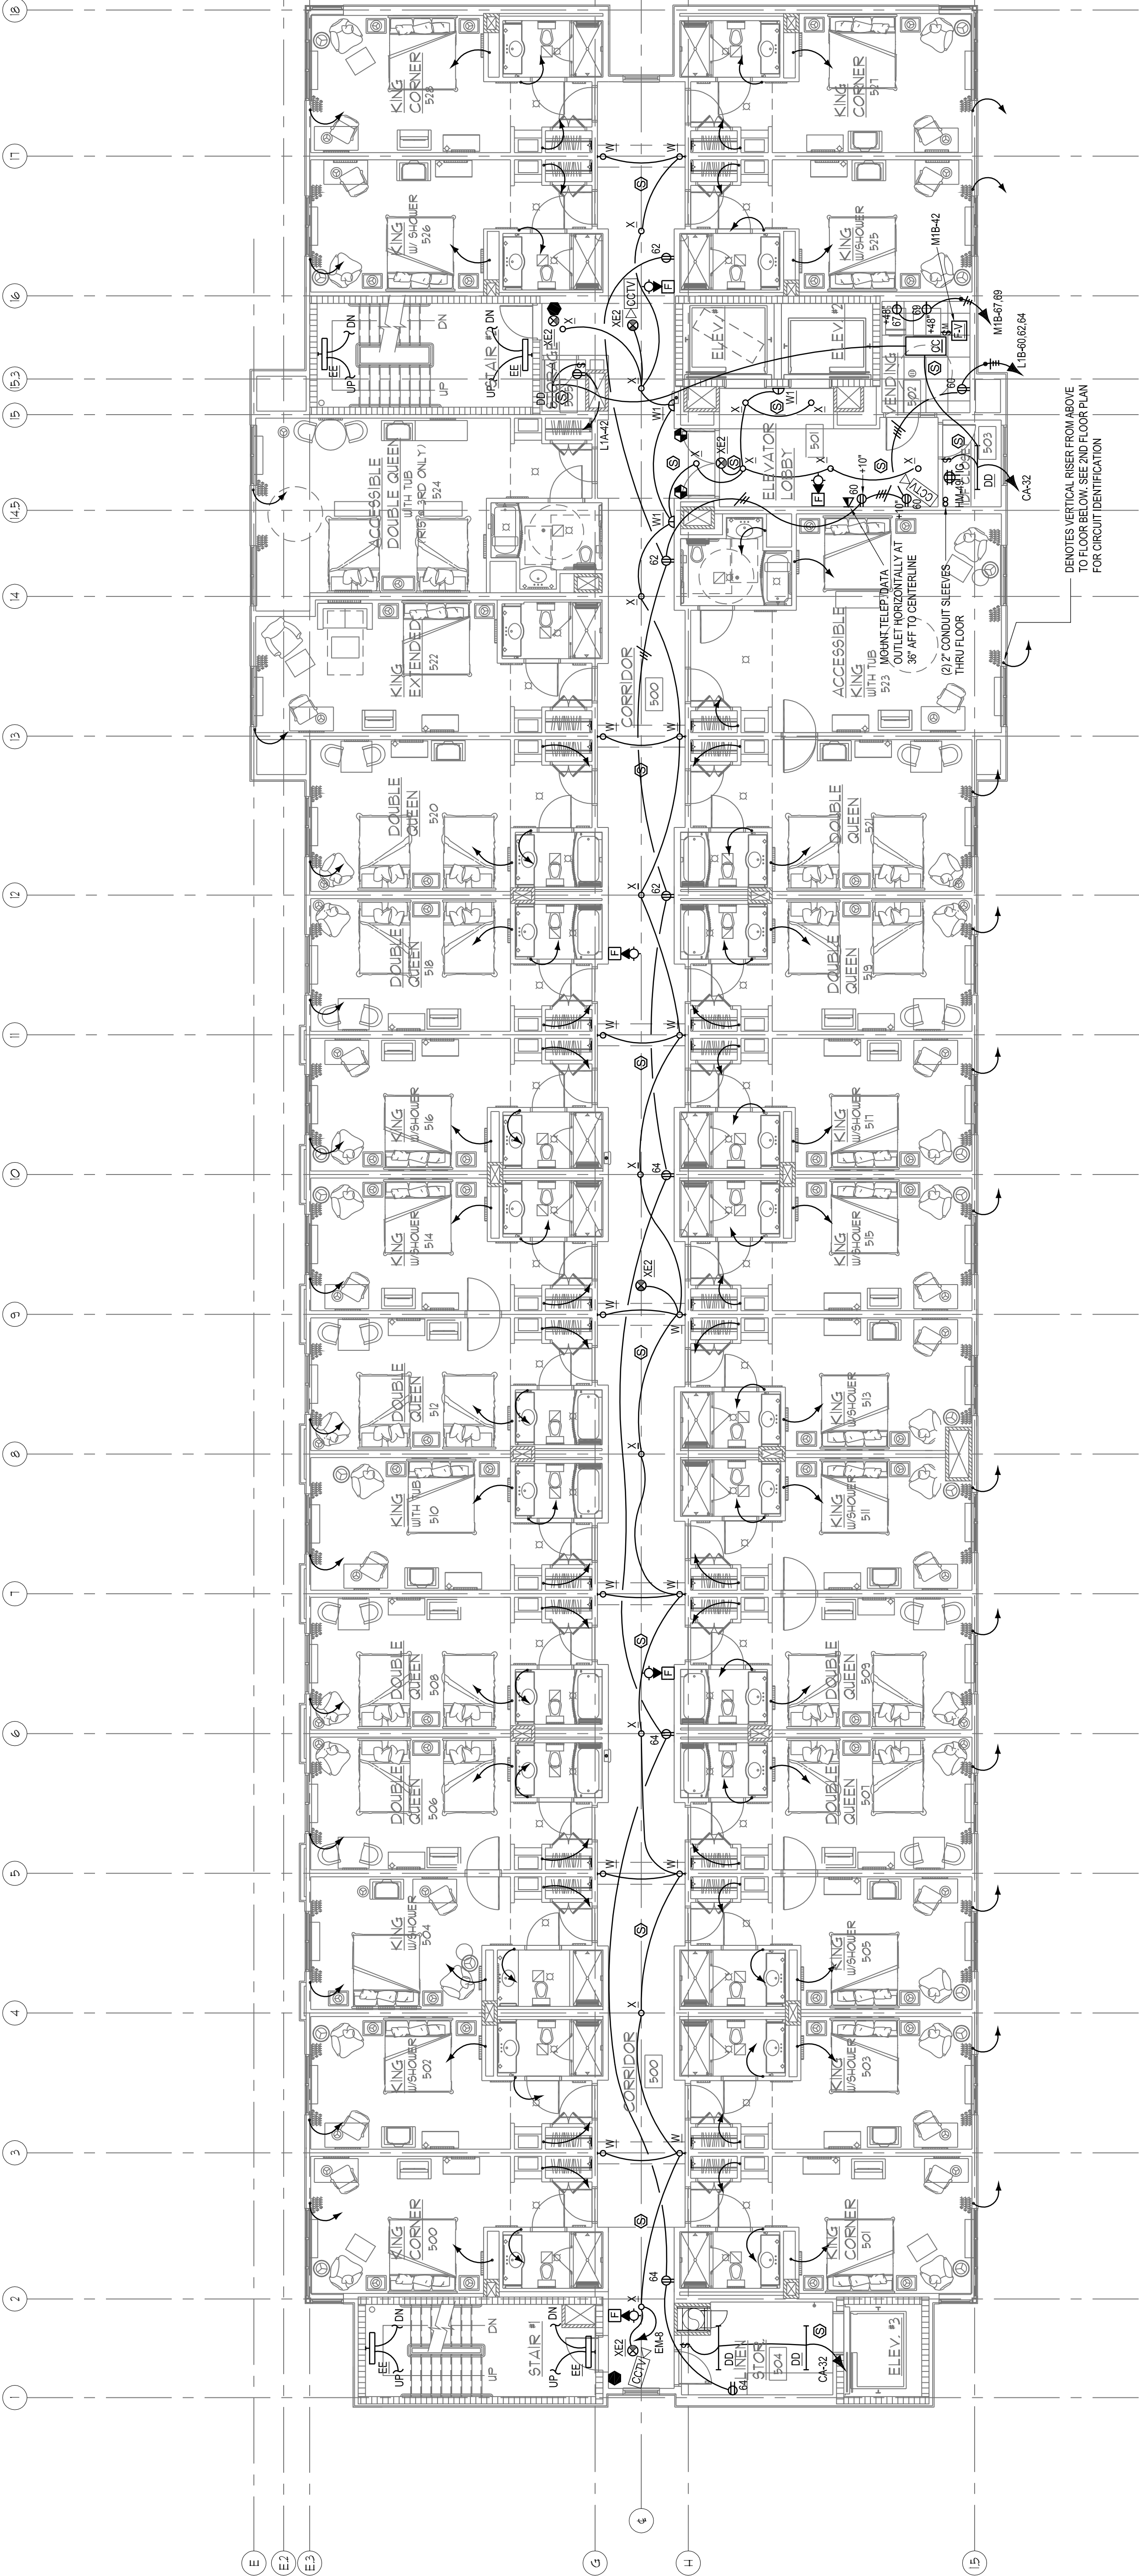

FIFTH FLOOR PLAN - ELECTRICAL

SCALE: 1/8" = 1'-0"

