



803 S. MOUNT MORIAH
SUITE 100B

MEMPHIS, TN 38117
(901) 683-7175 p.

(901) 683-2385 f.
llw@llwarchitects.com

[illegible]CONSULTANTS
STRUCTURAL:


INTERNATIONAL, INC.
SOUTH MAIN STREET
MONTSVILLE, AL 35811
(205) 852-3098

MECHANICAL:
ABTREE ENGINEERING
S. MT. MORIAH
MEMPHIS, TN 38117
(910) 767-9898

JIMMING:
 ABTREE ENGINEERING
 S. MT. MORIAH
 MPHIS, TN 38117
 (1) 767-9898

ELECTRICAL:
S. ENGINEERING
S. MT. MORIAH
MPHIS, TN 38117
(1) 767-2557

AL

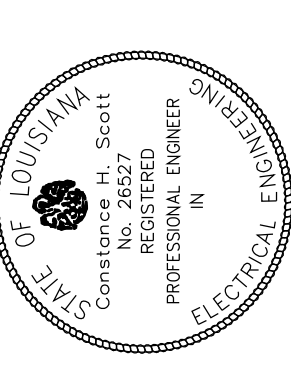

Holiday Inn
MILLENNIUM
BOSSIER CITY,
LOUISIANA

HEET NAME
ROOF AND ATTIC
LAN - ELECTRICAL


E	10/26/07
OWN BY	JSH
CHECKED BY	CHS
E NAME	
FILE	AS NOTED
SUBJECT NO.	1507
DRAWING	

80
E

ELECTRICAL POWER NOTES:


1. COORDINATE LOCATION OF ALL EQUIPMENT IN ELEVATOR EQUIPMENT SHAFTS WITH ELEVATOR VENDOR. EQUIPMENT LOCATION SHALL BE IN COMPLIANCE WITH ALL NATIONAL AND LOCAL CODES.
2. PROVIDE ALL ASSOCIATED ELECTRICAL REQUIRED FOR FIREMANS ELEVATOR RECALL.
3. CONTRACTOR SHALL PROVIDE A COMPLETE, OPERATIONAL FIRE ALARM SYSTEM IN ACCORDANCE WITH ALL CODE. CONTINENTAL HOTELS, INC. FRANCHISE, AND MANUFACTURERS REQUIREMENTS, INCLUDING DEVICES REQUIRED BY ALL CODES BUT NOT LIMITED HEREIN. SYSTEM SHALL INCLUDE ALL CONNECTIONS TO PULL AND TAMPER SWITCHES AS WELL AS P.I.V. AND COLD SMOKE DETECTORS FOR WALL AREAS OF GAS FIDED APPLIANCES. CARBON MONOXIDE DETECTORS SHALL BE IN ALL WALL AREAS OF EQUIPMENT.
4. REFER TO MANUFACTURER PLANS FOR EXACT LOCATION OF EQUIPMENT.
5. LAUNDRY CHUTE DROO INTERLOCK TO BE CIRCUIT LDY-37, TYPICAL EACH FLOOR.
6. PROVIDE REMOTE ON/OFF SWITCH FOR FIREPLACE FLUO LIGHT. LOCATE ON SUBFLOOR OF FRONT SECT.
7. CONTRACTOR TO COORDINATE EXACT LOCATIONS OF ALL FLOOR MOUNTED RECEPTALS AND TV POWER AND CABLE CONNECTIONS WITH INTERIOR DESIGNER AND FINAL FURNITURE LAYOUT PRIOR TO BEGINNING INSTALLATION.

8. HOUSE PHONE AT "48" ONLY, WITH AUTOMATIC DIAL TO FRONT DESK.
9. CARD READER HARD WIRE CONNECTION
10. CONTRACTOR SHALL PROVIDE A COMPLETE, OPERATIONAL FIRE ALARM SYSTEM IN ACCORDANCE WITH ALL CODE AND MANUFACTURING REQUIREMENTS, INCLUDING DETECTORS, NOTIFICATION DEVICES BUT NOT LIMITED TO, SIRENS, STROBES, AND TAPER SWITCHES, AS WELL AS T-1, T-2, AND DUCT SMOKE DETECTORS FOR MECHANICAL UNITS.
11. EMERGENCY PANIC BUTTON AT "38" MAX. A.F.F. W/ ANNUNCIATION BELL LOCATED AT FRONT DESK.
12. CONTRACTOR SHALL PROVIDE 120V POWER, CONNECT TO CIRCUIT HA-20 FOR BUILDING ALARM SYSTEM INSTALLATION BY OTHERS, COORDINATE EXACT LOCATION OF PANEL WITHIN OFFICE AREA WITH ALARM VENDOR.
13. ALL W/PVFCI RECEPTORS SHALL BE IN USE INHOUSE COUNCILS.
14. FIRE ALARM CONTRACTORS SHALL ENSURE THAT FINAL PLACEMENT OF MOUNTING EQUIPMENT (E.G. LIGHTS, DIFFUSERS),

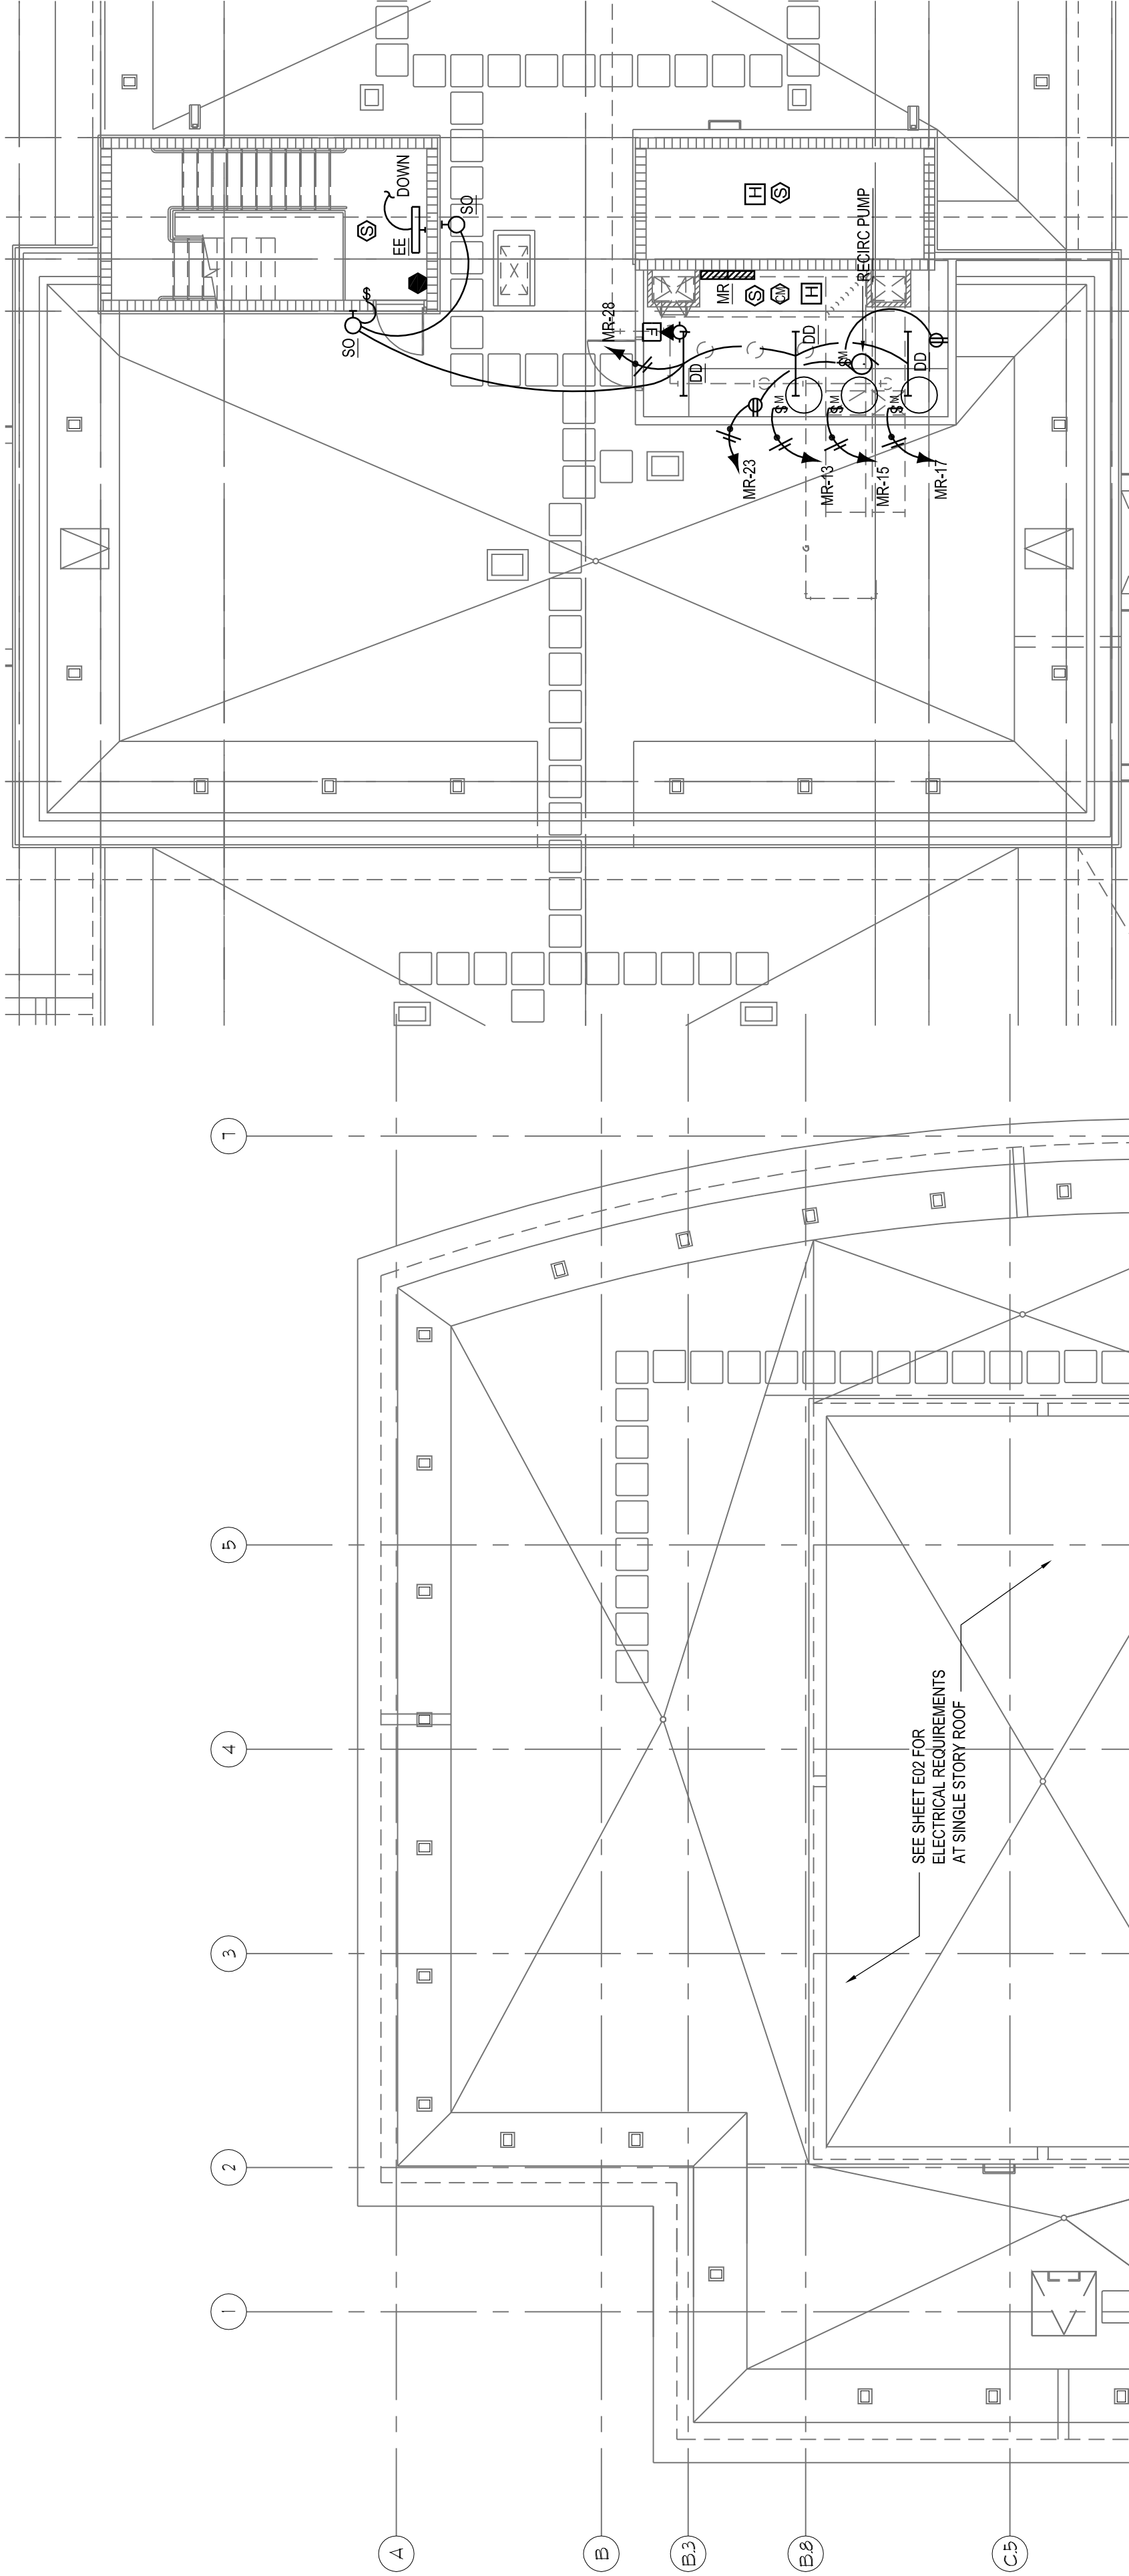


-MECHANICAL ROOM PLAN - ELECTRICAL

SCALE: 1/8" = 1'-0"

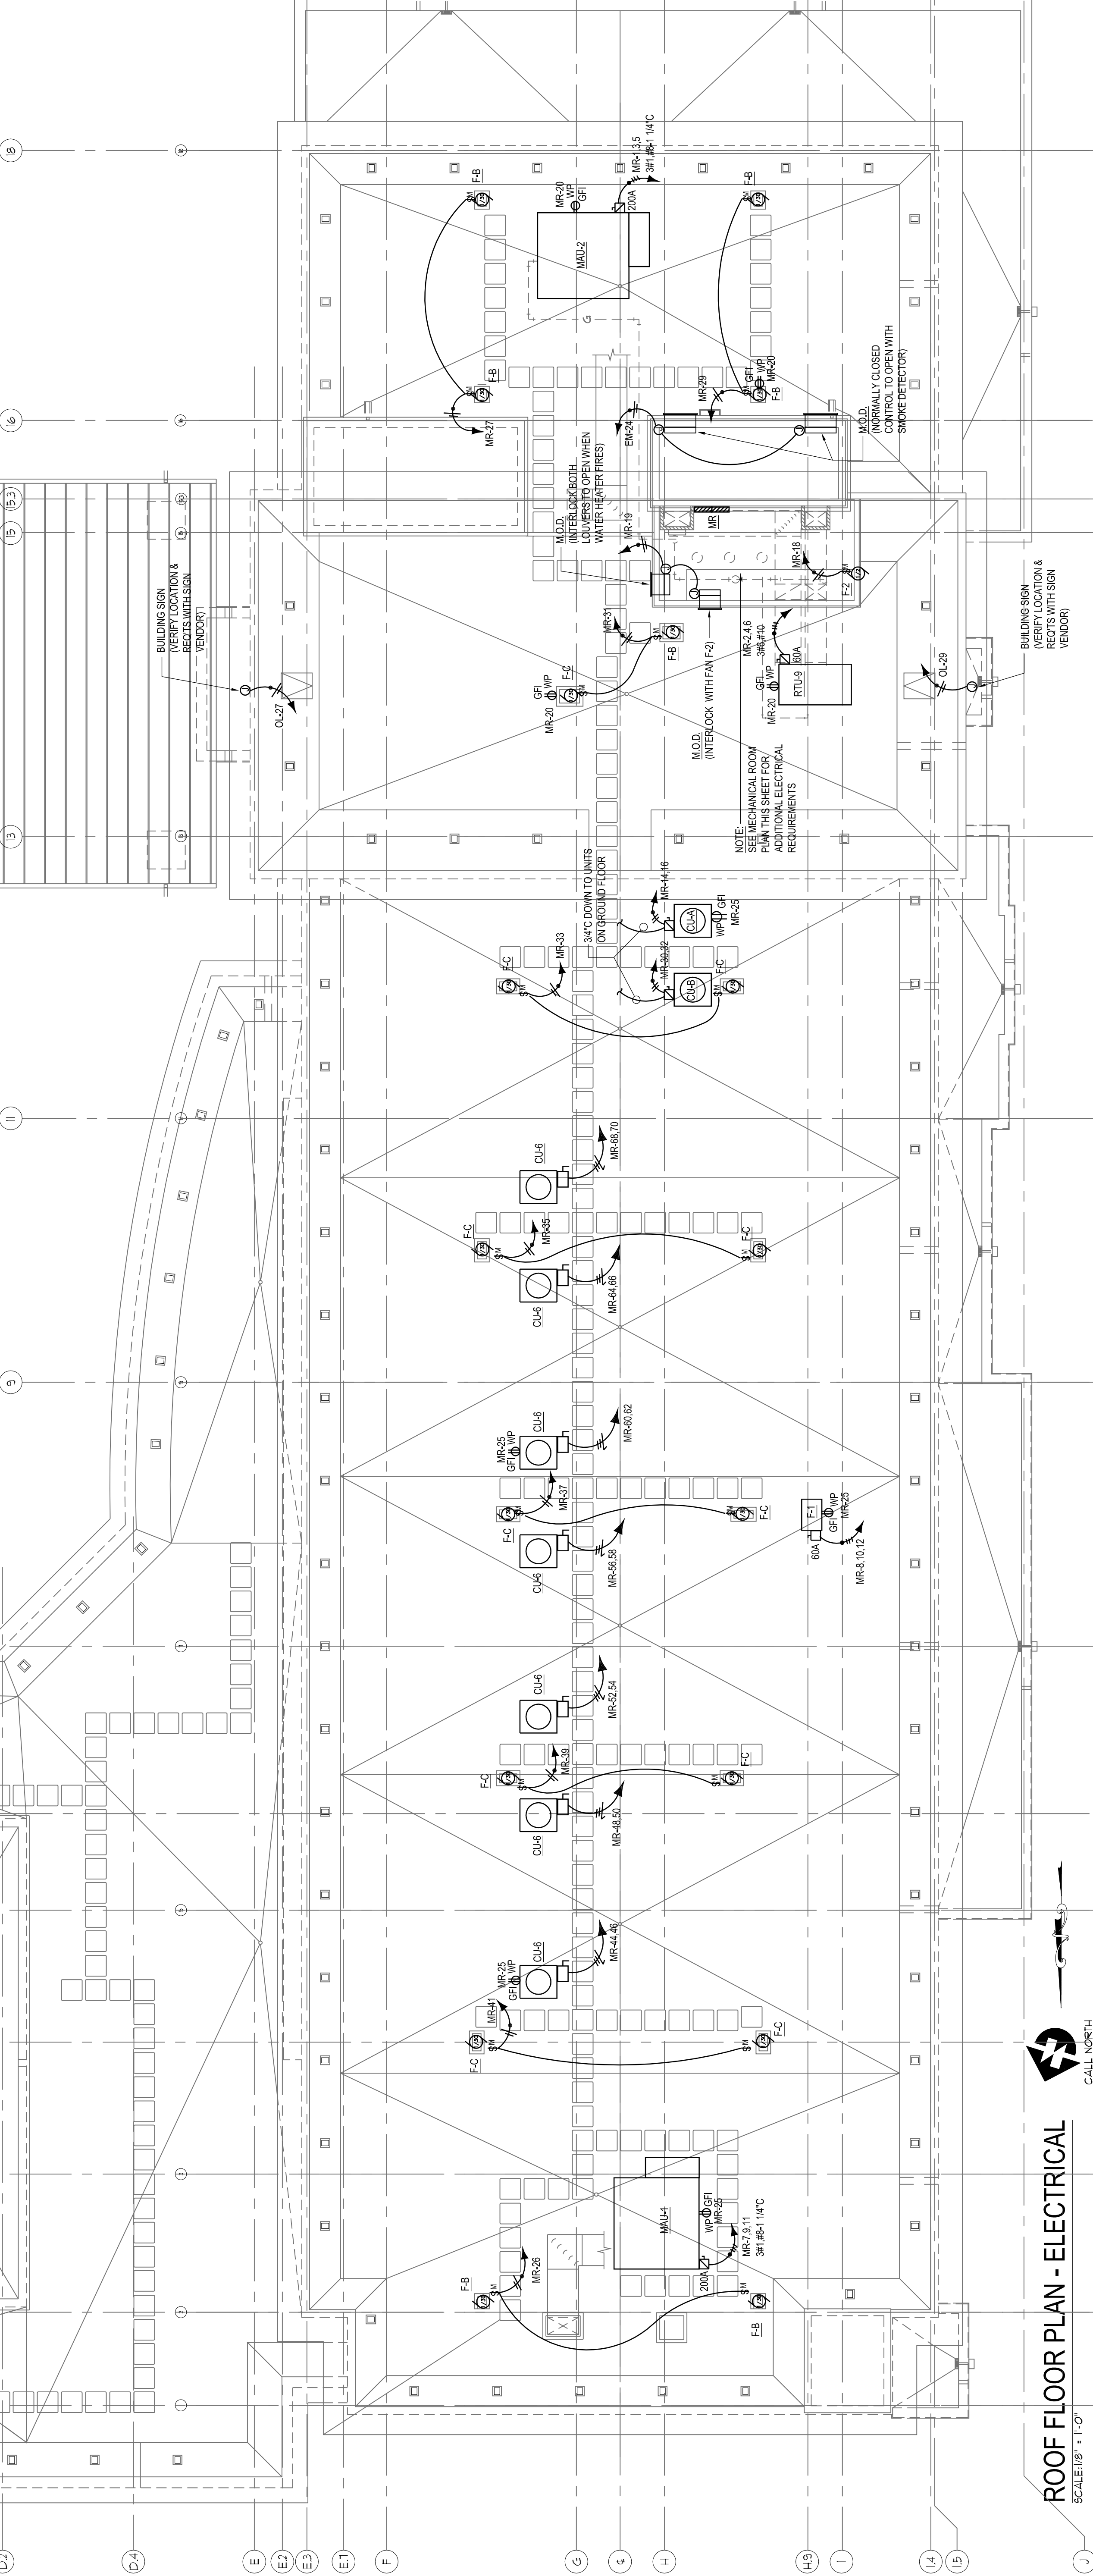

ROOF FLOOR PLAN - ELECTRICAL

SCA E-18 : "O"

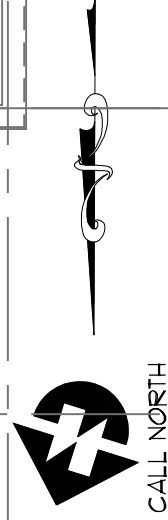

CALL NORTH