

803 S. MOUNT MORIAH
SUITE 100B
MEMPHIS, TN 38117
(901) 663-7175 p.
(901) 663-2365 f.
lmw@lmwarchitects.com

NO.	ISSUED	DATE
1	ISSUED	10/26/07
NO.	REVISIONS	DATE
CONTRACTOR'S REVISIONS, INC. 1000 W. WOODWARD AVE., SUITE 100 MEMPHIS, TN 38104 U.S. COPYRIGHT LAWS AND WILL SUBJECT THE VIOLATOR TO LEGAL PROSECUTION.		

CONSULTANTS


STRUCTURAL:
SK INTERNATIONAL, INC.
130 SOUTH MAIN STREET
HUNTSVILLE, AL 35811
(256) 852-3098

MECHANICAL:
CRABTREE ENGINEERING
726 S. MT. MORIAH
MEMPHIS, TN 38117
(901) 767-9898

PLUMBING:
CRABTREE ENGINEERING
726 S. MT. MORIAH
MEMPHIS, TN 38117
(901) 767-9898

ELECTRICAL:
CHS ENGINEERING
726 S. MT. MORIAH
MEMPHIS, TN 38117
(901) 767-2557

SEAL

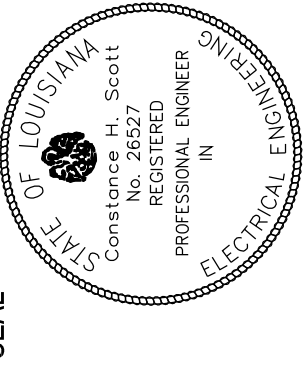

*** Holiday Dnn**
MILLENNIUM
BOSSIER CITY,
LOUISIANA

SHEET NAME
LARGE SCALE
GUEST ROOM
PLANS - ELECTRICAL

DATE	10/26/07
DRAWN BY	JSH
CHECKED BY	CHS
FILE NAME	
SCALE	AS NOTED
PROJECT NO.	

1507

DRAWING

E09


GENERAL NOTES

- REFER TO ARCHITECTURAL DRAWINGS FOR EXACT DIMENSIONS.
- REFER TO SHEET E14 FOR ELECTRICAL DETAILS. REFER TO SHEET E15 FOR LIGHTING SCHEDULE.
- ACCESSIBLE AND HEARING IMPAIRED GUESTROOMS SHALL COMPLY WITH REQUIREMENTS OF THE A.D.A. GUIDELINES MANUAL. NAMELY ADA 92.2, 93, 94, 916. TELEPHONES SHALL HAVE ADJUSTABLE VOLUME CONTROLS. TELEPHONES SHALL BE LOCATED WITHIN 700A GUESTROOM DOOR ANNUNCIATOR, AND FOR INCOMING TELEPHONE CALLS.
- NO BACK TO BACK DEVICES SHALL BE ALLOWED. DEVICES MUST BE OFFSET A MINIMUM OF 24" BETWEEN DEVICES. SEE DETAILS 3 & 3 ON SHEET E14.
- SMOKE DETECTORS IN ALL GUESTROOMS SHALL BE EQUIPPED WITH ANNUNCIATOR AND/OR STROBE DEVICES AS REQUIRED. GUESTROOM ALARM SHALL PROVIDE INDIVIDUAL ALARM WITHIN GUESTROOM ONLY AND AT MAIN FIRE ALARM CONTROL PANEL IN MAIN OFFICE. A SEPARATE SYSTEM NOTIFICATION DEVICE SHALL BE ACTIVATED UPON GENERAL FIRE ALARM. ALSO, DEVICES WITHIN STANDARD GUESTROOMS SHALL BE STROBE DEVICES WITH SOUNDER BASE. IN ADJACENT BATHROOMS, DEVICES SHALL BE STROBE DEVICES. DEVICES SHALL BE PROVIDED WITH AN ADDITIONAL STROBE IN THE BATH. REFER TO SPECIFICATIONS. SEE RISER DETAIL 4A4B SHEET E14.
- HORIZONTALLY MOUNTED DATA OUTLET AT 43" A.F.F. - SEE DETAIL 7 SHEET E14.
- PTAC UNIT USE MECHANICAL DRAWINGS FOR MANUFACTURER AND SPECIFICATIONS. EXTEND POWER FROM JBOX IN WALL AND PROVIDE SCHED 40 EMT TO UNIT. PROVIDE SCHED 40 EMT TO UNIT. RECOMMENDATIONS. NO CORDS SHALL BE EXPOSED. SEE DETAIL 88 SHEET E14.
- HOSPITALITY UNIT RISER FOR GUEST ROOM. MICROVAPE, COFFEE MAKER AND UNDERCOUNTER REFRIGERATOR. SEE DETAIL 8A SHEET E14 AND SEE HOSPITALITY UNIT DETAIL 4 ON ARCHITECTURAL SHEET A505.
- INCREASE HOMERUN WIRE SIZES FOR VOLTAGE DROP OVER 100 FEET ONE SIZE AND OVER 250 FEET TWO SIZES.
- MOUNT ALL RECEPTACLES AND TELEPHONE SYSTEM OUTLETS IN GUESTROOMS TO BE LOCATED 48" TO CENTER A.F.F. 14" ACCESSIBLE OTHERWISE. MOUNT ALL RECEPTACLES, TELEVISION, AND TELEPHONE SYSTEM OUTLETS IN HANDICAPPED ROOMS AT 18" A.F.F. ACCESSIBLE ROOMS SHALL MEET ADA REQUIREMENTS. REFER TO DETAIL 7 SHEET E14.
- TV SYSTEM OUTLET - SEE DETAILS 3 & 7 SHEET E18. TYPICAL OF RMS) UNLESS NOTED OTHERWISE.
- 500 RECEPTACLES AND SWITCHES IN GUEST BATHROOMS SHALL BE LOCATED 48" TO CENTER A.F.F. 14" ACCESSIBLE. 500 RECEPTACLES AND SWITCHES IN GUESTROOM BATHROOMS TO CENTER A.F.F. 6" RECEPTACLE IN GUESTROOM BATHROOMS SHALL BE ON ITS OWN SEPARATE CIRCUIT. SEE DETAIL 7 SHEET E14.
- ALL SWITCHES IN GUESTROOM TO BE MOUNTED 48" A.F.F. TO CENTER UNLESS NOTED OTHERWISE.
- HORIZONTALLY MOUNTED DUPLEX OUTLET WITH SURGE PROTECTION SHALL TO F86 (5624SP) MOUNTED AT 35" A.F.F. SEE DETAIL 7 SHEET E14.

NOTE:
CONTRACTOR SHALL PROVIDE A COMPLETE, OPERATIONAL FIRE ALARM SYSTEM IN ACCORDANCE WITH ALL CODE, FRANCHISE, AND MANUFACTURER'S REQUIREMENTS. ALL DEVICES SHALL BE IDENTIFIED BY LOCAL CODE BUT NOT INDICATED HEREIN. SYSTEM SHALL INCLUDE ALL CONNECTIONS TO FLOW AND TAMPER SWITCHES AS WELL AS P.I.V., AND DUCT SMOKE DETECTORS FOR MECHANICAL UNITS.

ELECTRICAL SYMBOLS GUEST ROOMS		
§	SINGLE POLE SWITCH	AFT
⊖	SINGLE RECEPTACLE, GROUND POLE UP	⊖ GFI
⊕	DUPLEX RECEPTACLE, GROUND POLE UP	448"
⊕	QUAD RECEPTACLE, GROUND POLE UP	⊕
⊕	JUNCTION BOX	⊕
⊕	EXHAUST FAN	⊕
•	RISER IN WALL	•
⊕	RECESSED CAN	⊕
⊕	WALL MOUNTED VANITY LIGHT	⊕

ACCESSIBLE & HEARING IMPAIRED ROOMS
PER ARCHITECTURAL PLANS:
223
323, 324
423, 424
523, 524
VERIFY LOCATIONS PRIOR TO ROUGH-IN

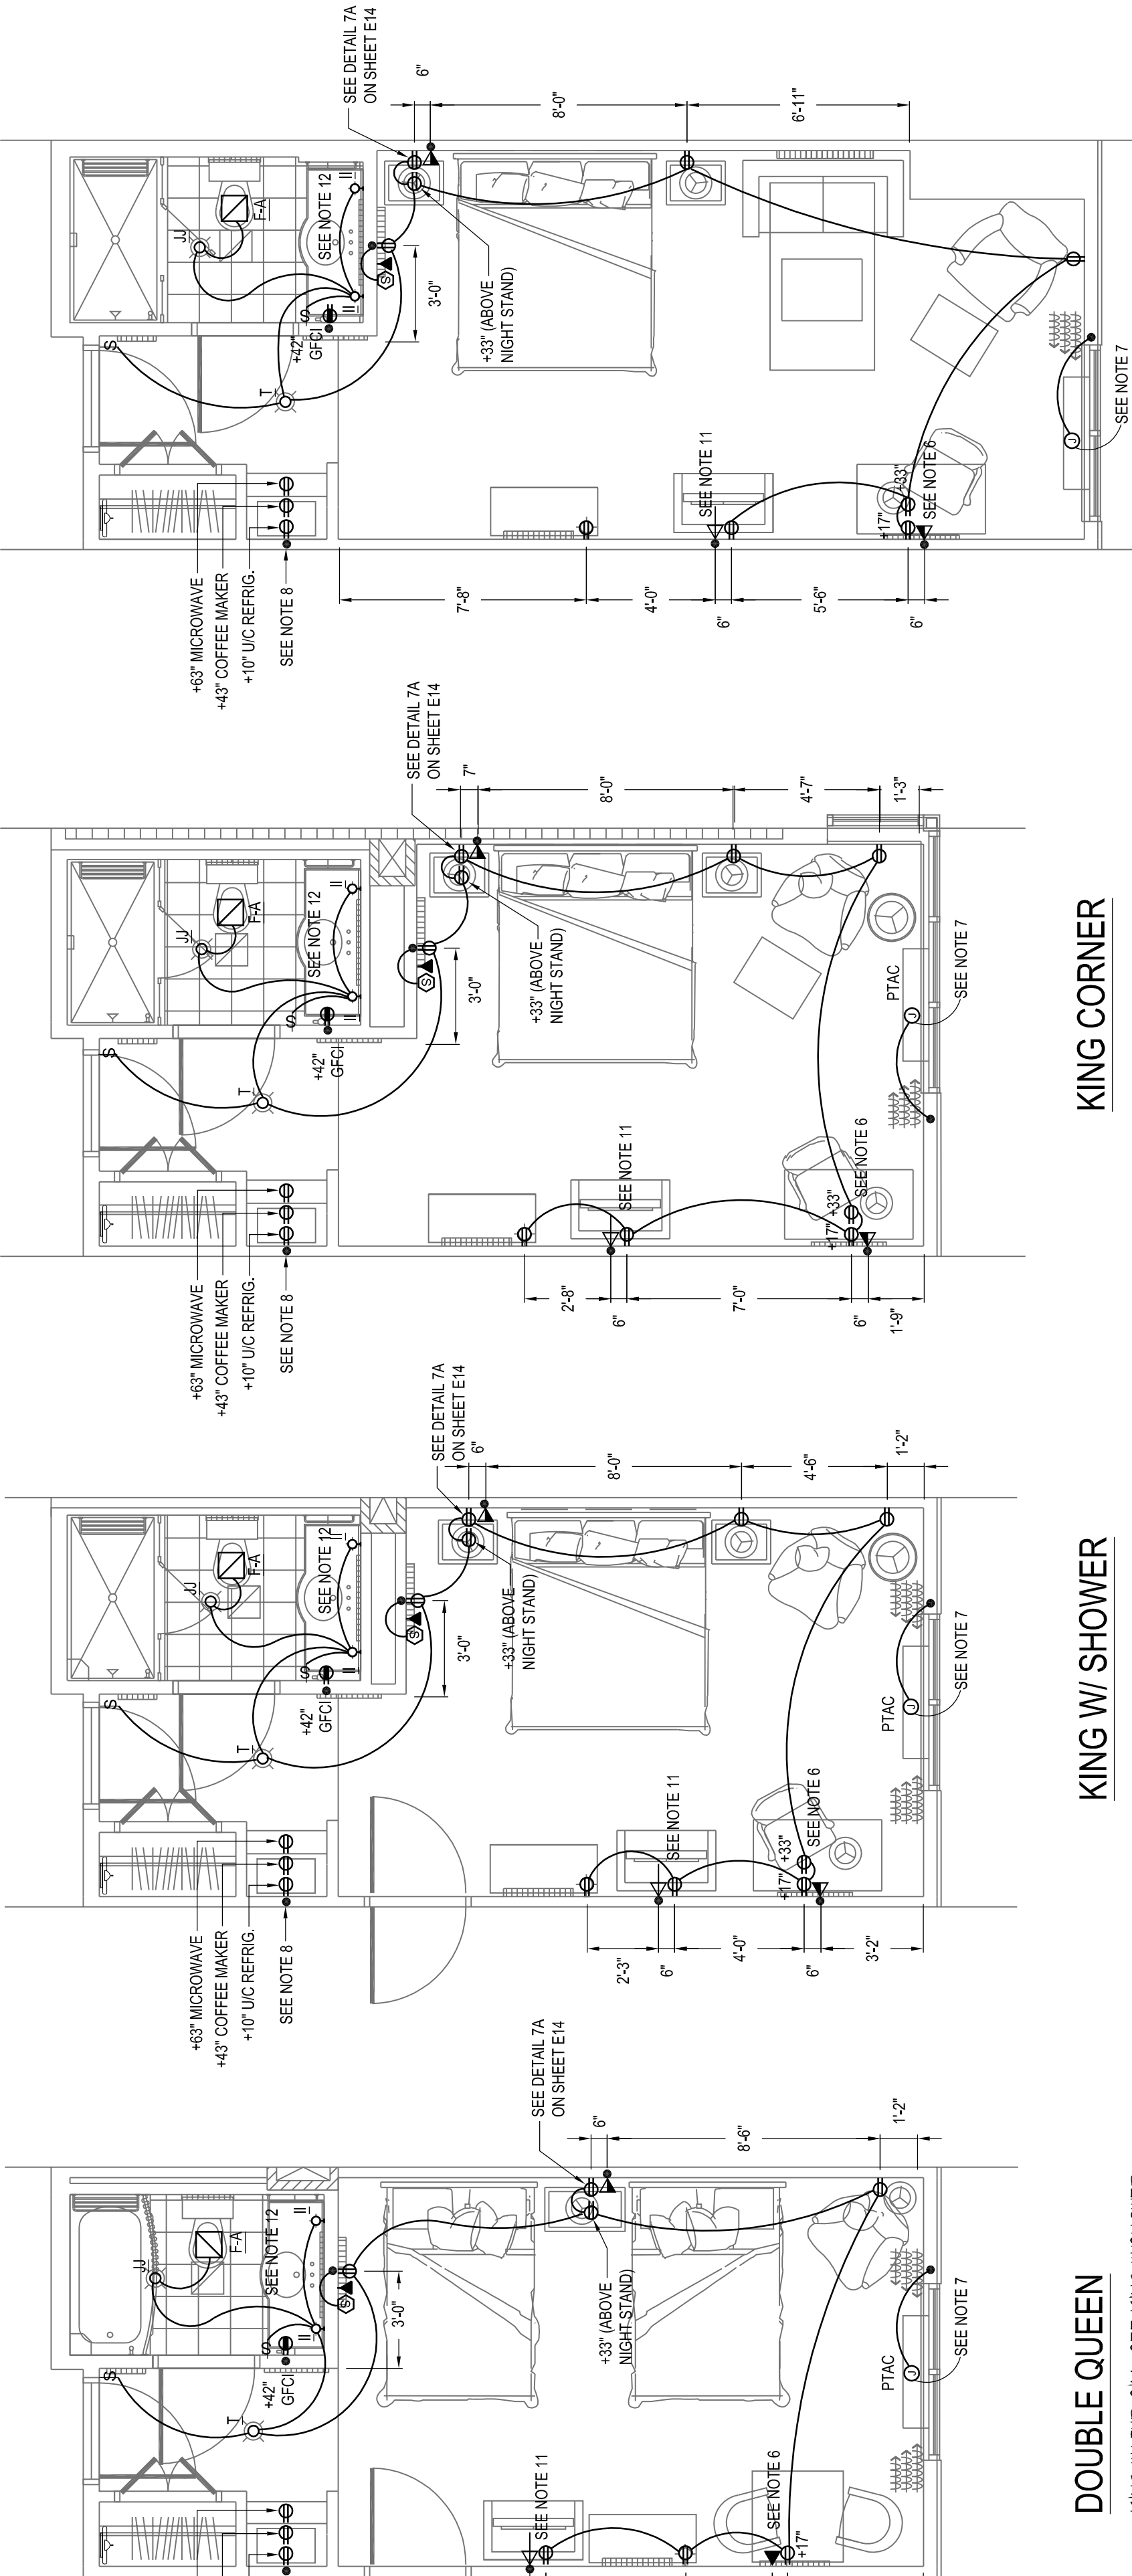


DOUBLE QUEEN

KING W/ TUB SIM. SEE KING W/SHOWER FOR FURNITURE LAYOUT


KING W/ SHOWER

KING CORNER


KING EXTENDED

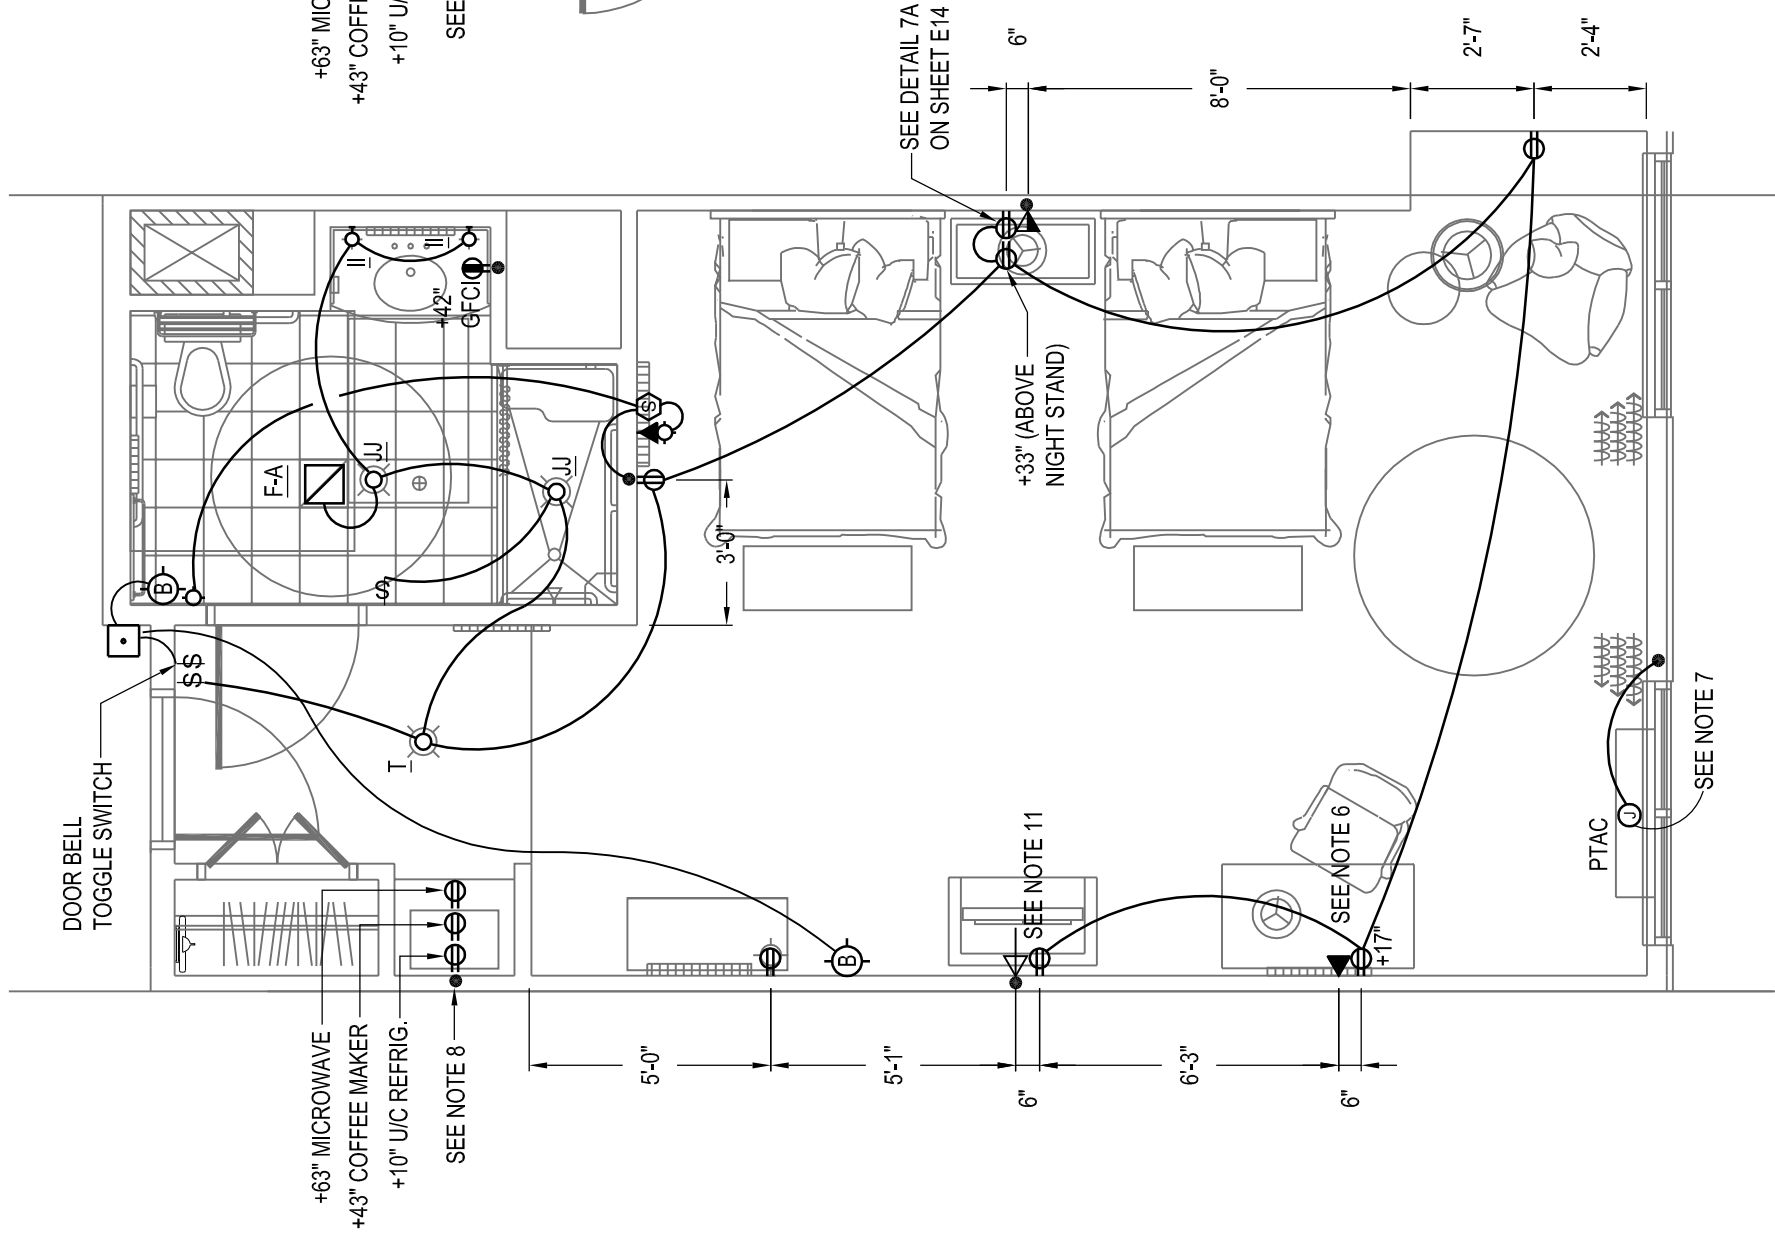


ACCESSIBLE DOUBLE QUEEN W/ RIS

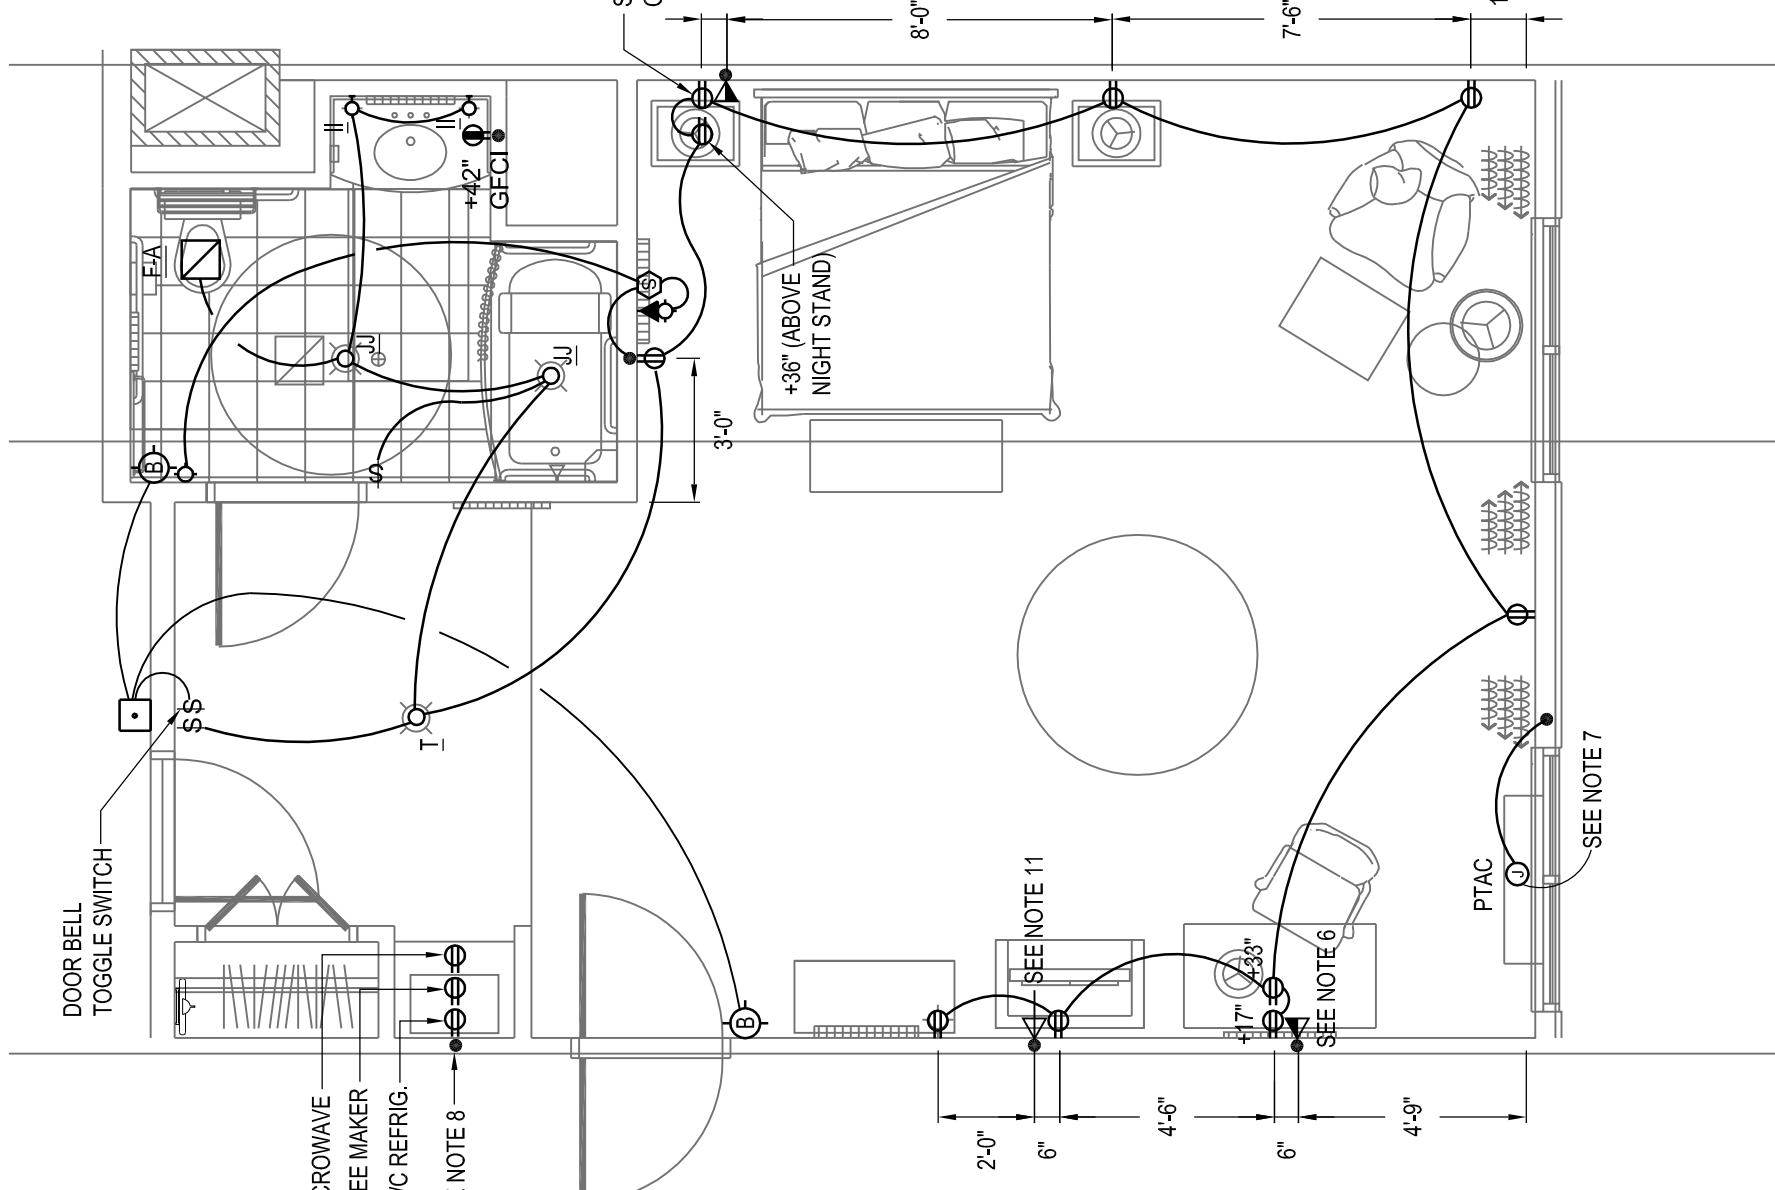


ACCESSIBLE KING W/ TUB

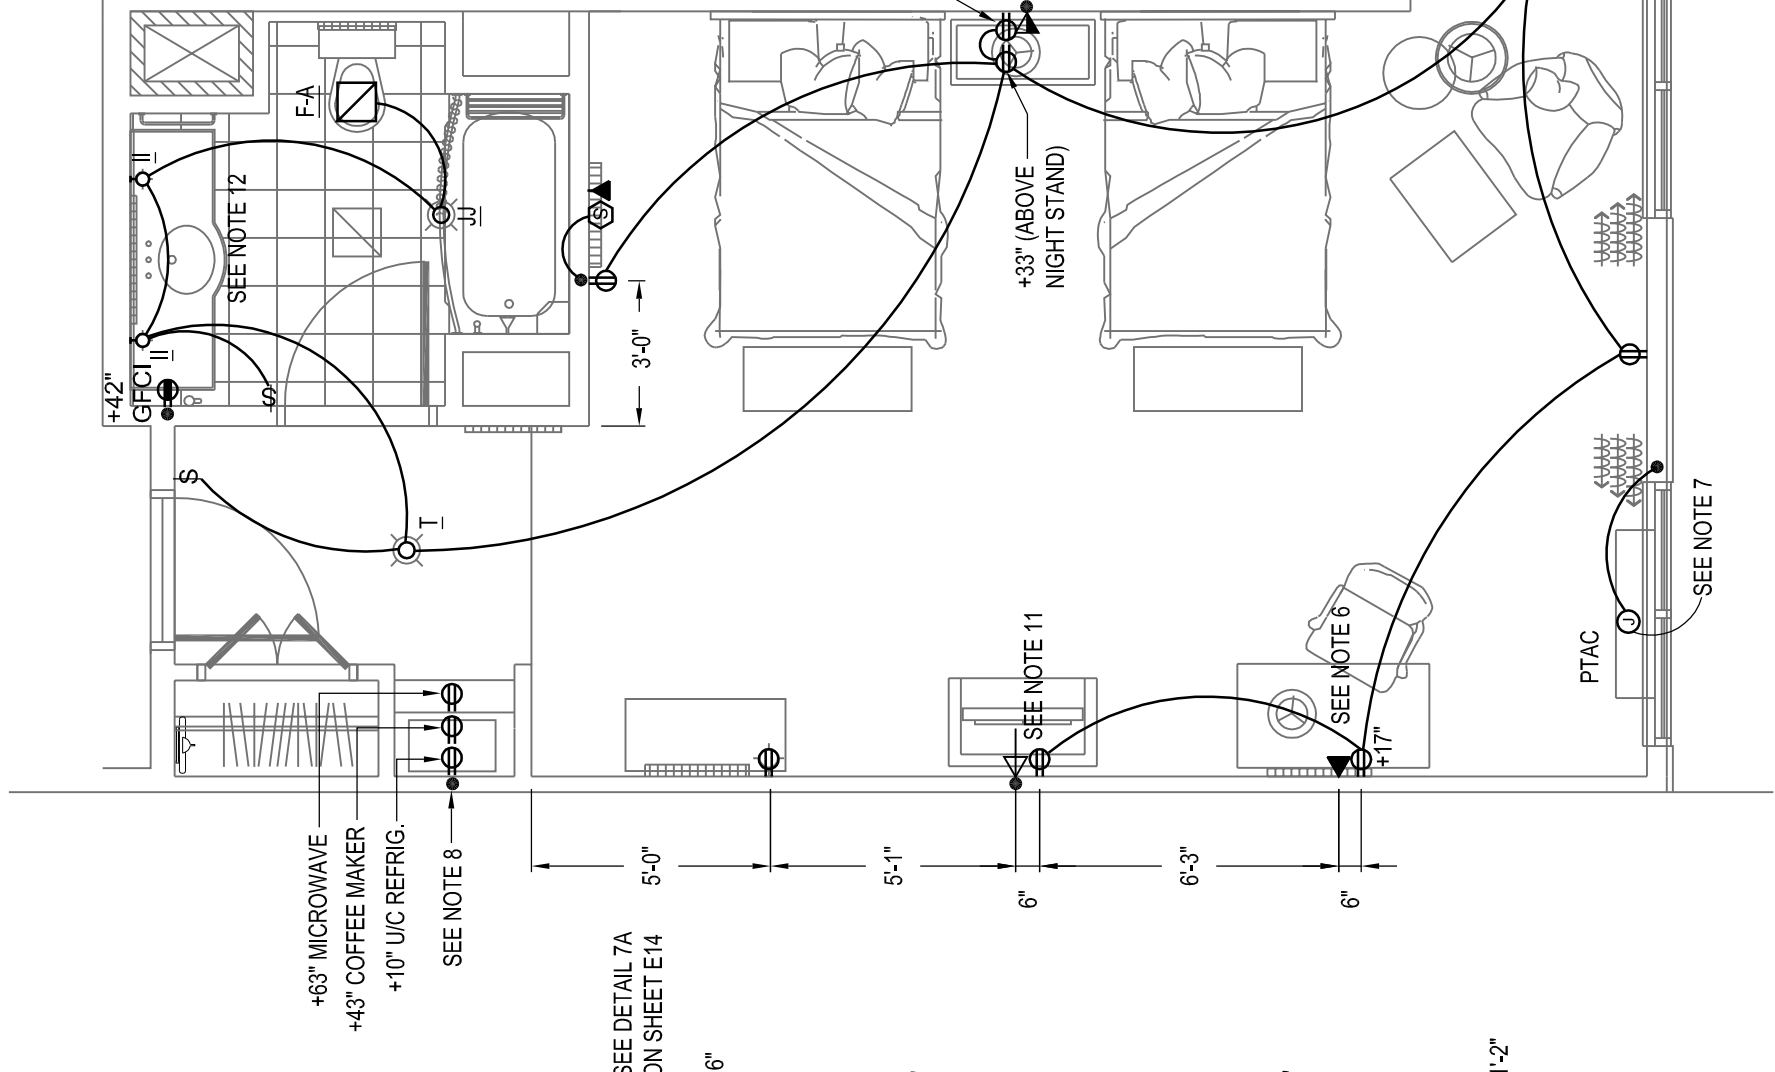

DOUBLE QUEEN PARLOR

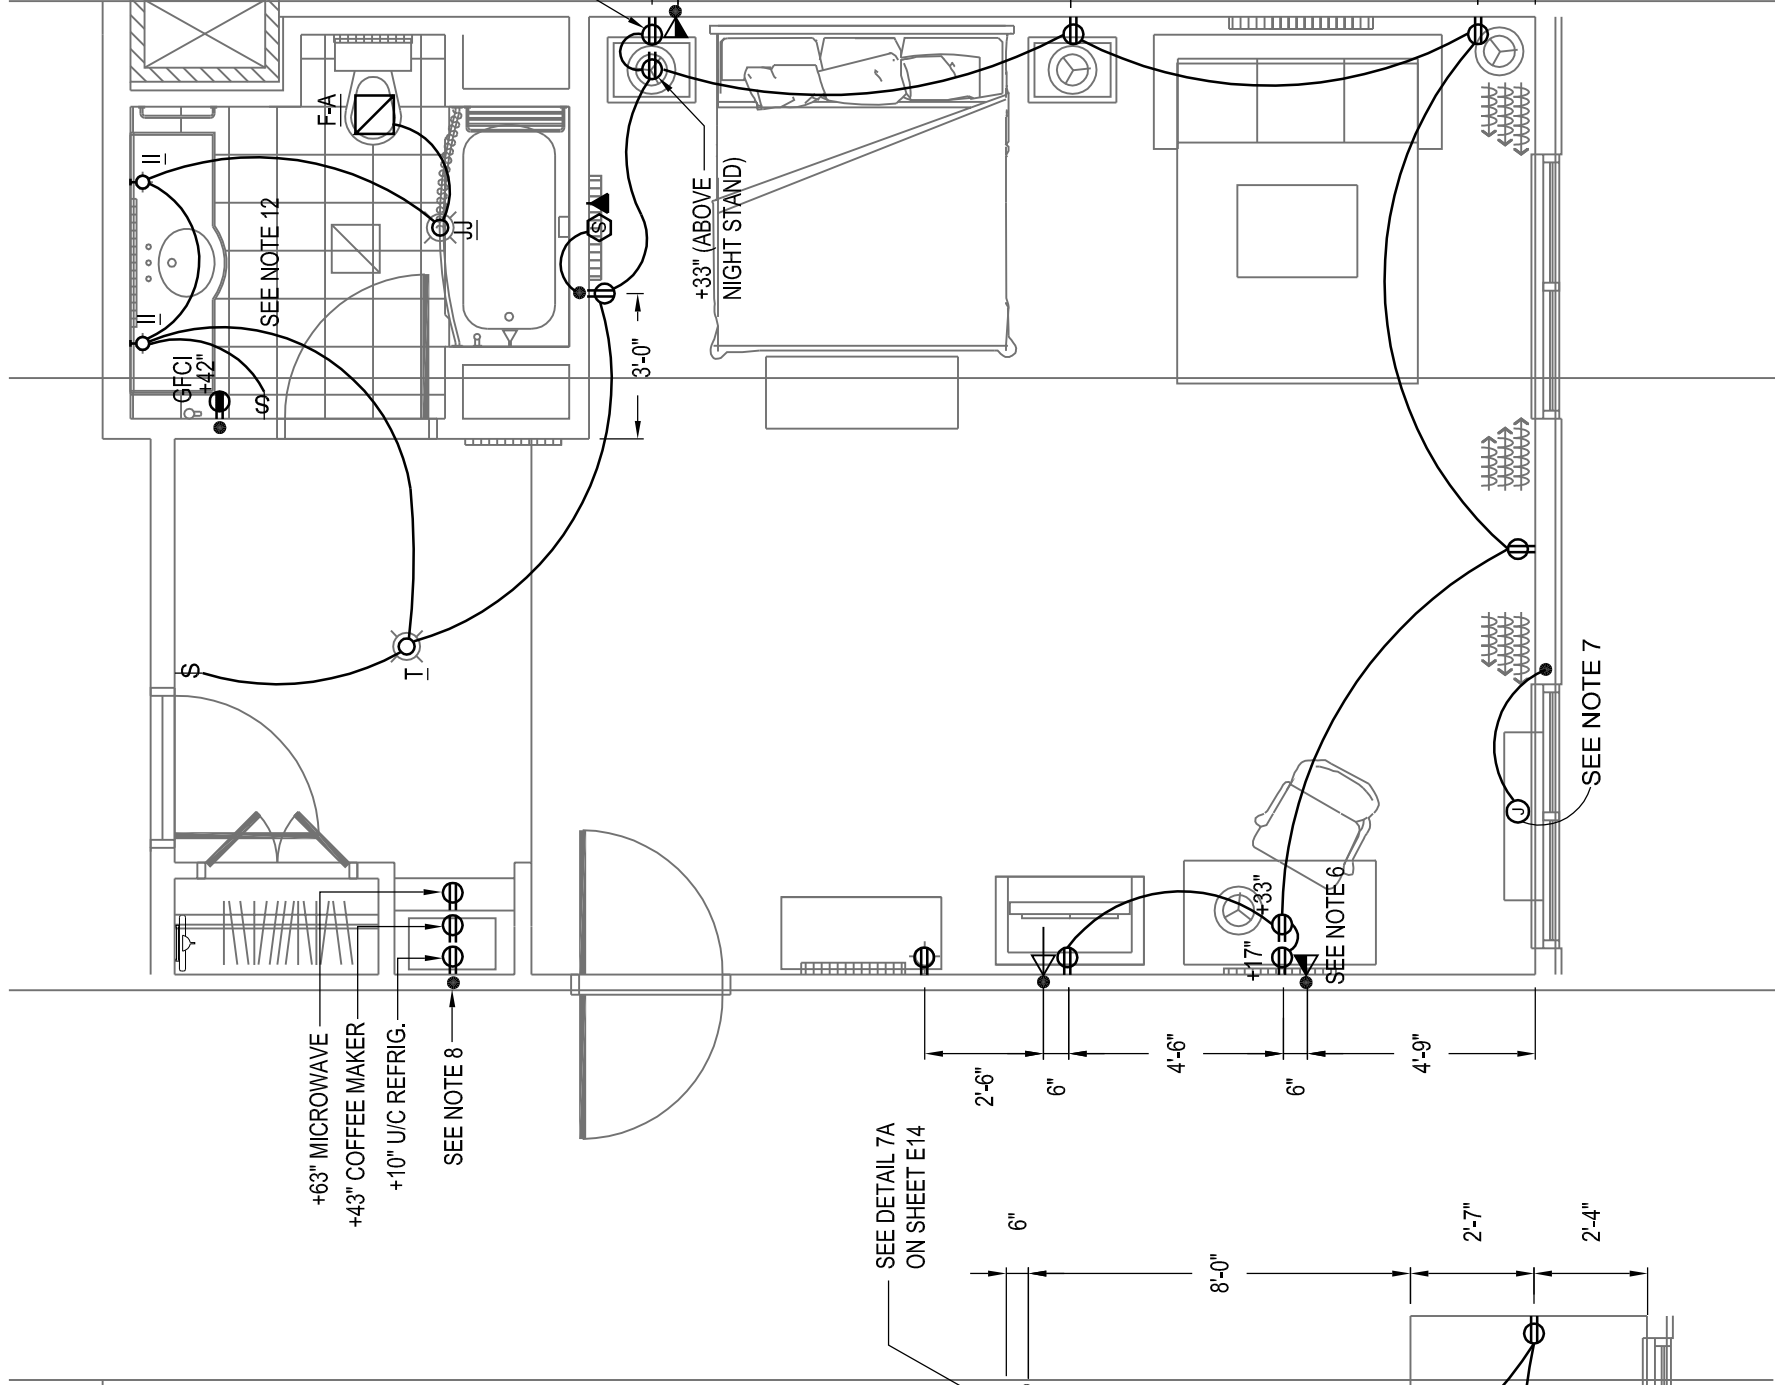


KING PARLOR

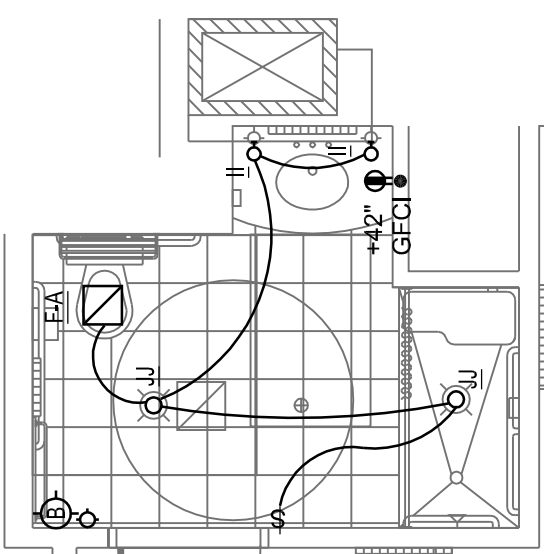

ACCESSIBLE KING W/ RIS

SEE ACCESSIBLE KING W/ TUB FOR FURNITURE LAYOUT

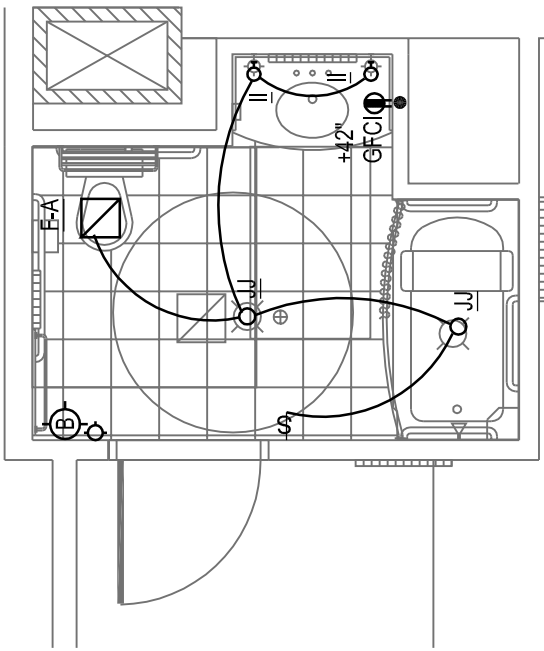

ACCESSIBLE DOUBLE QUEEN W/ TUB

SEE ACCESSIBLE DOUBLE QUEEN W/ RIS FOR FURNITURE LAYOUT

LARGE SCALE GUEST ROOM PLANS - ELECTRICAL

SCALE: 1/4" = 1'-0"

DOUBLE QUEEN PARLOR

KING PARLOR

ACCESSIBLE DOUBLE QUEEN W/ RIS

ACCESSIBLE KING W/ TUB

DOUBLE QUEEN PARLOR

KING PARLOR

ACCESSIBLE DOUBLE QUEEN W/ TUB

SEE ACCESSIBLE DOUBLE QUEEN W/ RIS FOR FURNITURE LAYOUT

LARGE SCALE GUEST ROOM PLANS - ELECTRICAL

SCALE: 1/4" = 1'-0"