




803 S. MOUNT MORIAH
SUITE 100B
MEMPHIS, TN 38117
(901) 683-7175 p.
(901) 683-2385 f.
lmw@lwarchitects.com

NO.	ISSUED	DATE
1	ISSUED	10/26/07
NO.	REVISIONS	DATE
CONTRACT DOCUMENTS, INC. OWNER'S AUTHORIZED REPRESENTATIVE U.S. COPYRIGHT LAWS AND WILL SUBJECT THE VIOLATOR TO LEGAL PROSECUTION.		

CONSULTANTS
STRUCTURAL:
SK INTERNATIONAL, INC.
130 SOUTH MAIN STREET
HUNTSVILLE, AL 35811
(256) 852-3098
MECHANICAL:
CRABTREE ENGINEERING
726 S. MT. MORIAH
MEMPHIS, TN 38117
(901) 767-9898
PLUMBING:
CRABTREE ENGINEERING
726 S. MT. MORIAH
MEMPHIS, TN 38117
(901) 767-9898
ELECTRICAL:
CHS ENGINEERING
726 S. MT. MORIAH
MEMPHIS, TN 38117
(901) 767-2557
SEAL

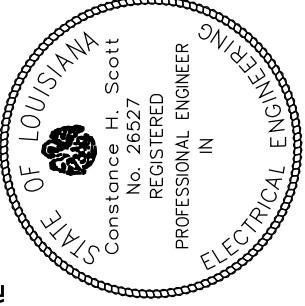

Holiday Dnn
MILLENNIUM
BOSSIER CITY,
LOUISIANA


SHEET NAME
LARGE SCALE
AREA "C"
FLOOR PLAN -
POWER

DATE	10/26/07
DRAWN BY	JSH
CHECKED BY	CHS
FILE NAME	
SCALE	AS NOTED
PROJECT NO.	1507
DRAWING	



LARGE SCALE AREA "C" FLOOR PLAN - POWER
SCALE: 1/4" = 1'-0"

E12

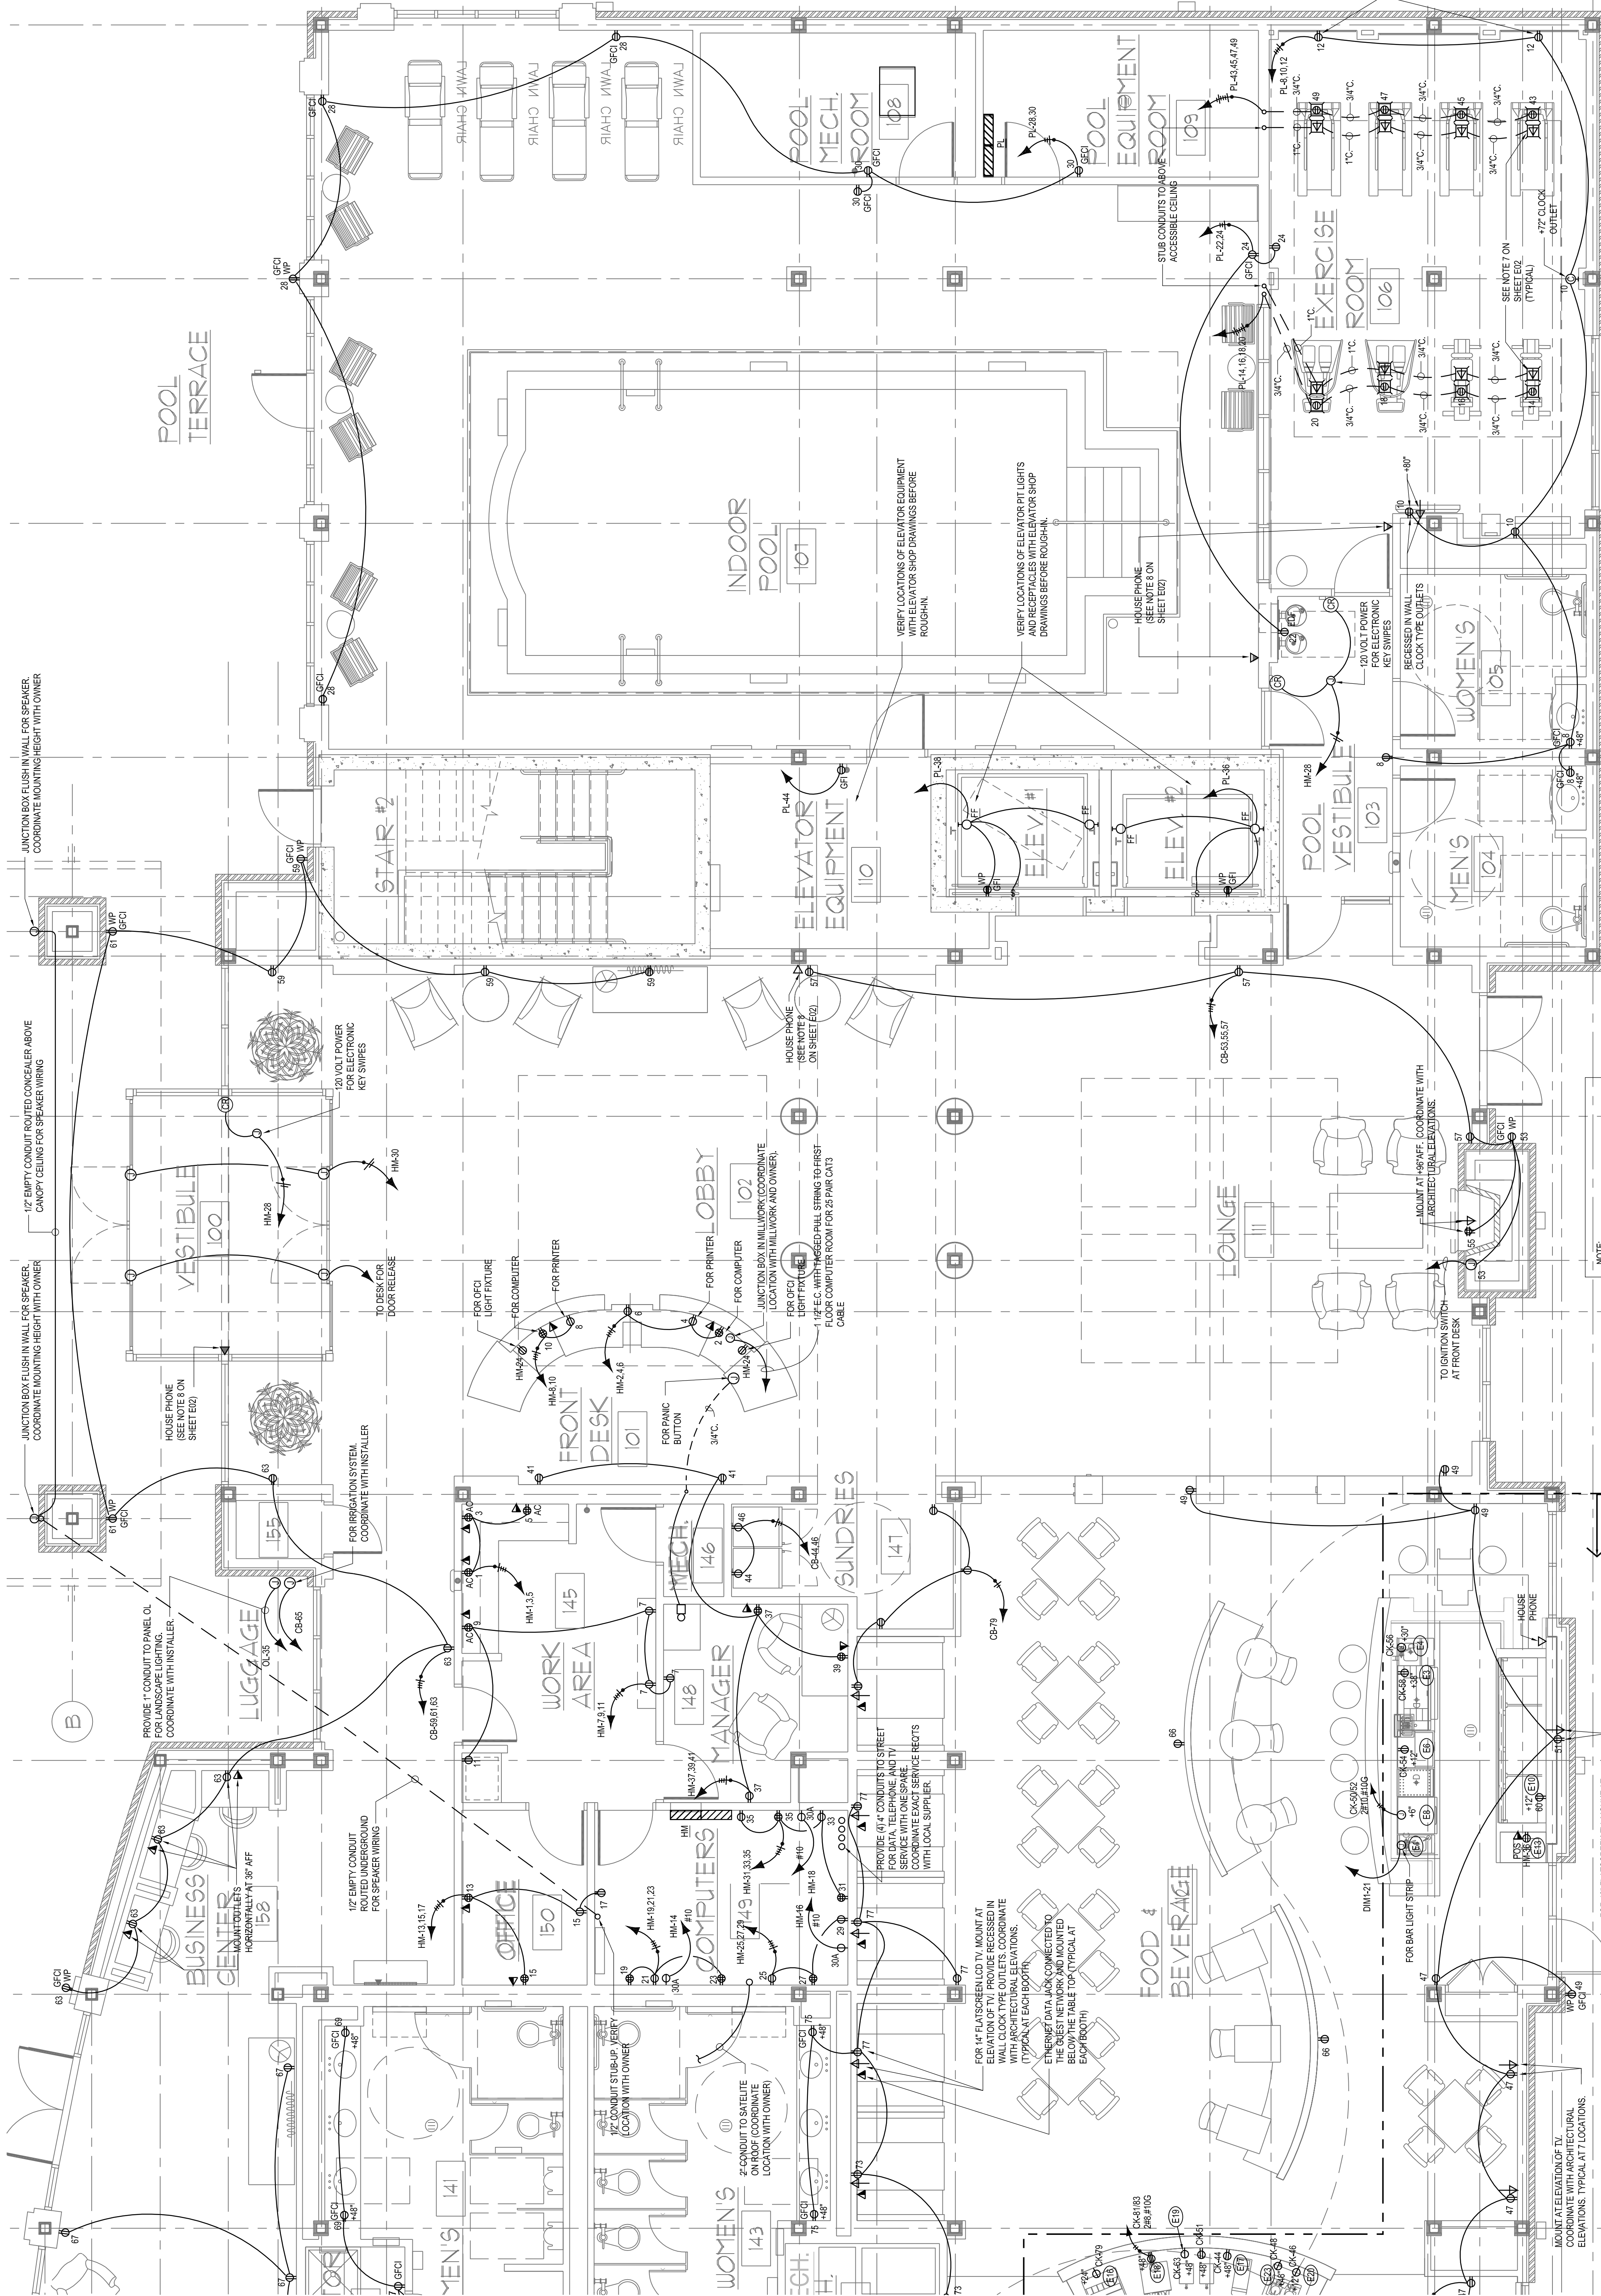

CONNECT REC.
FOOD & TO PANEL CK
BEVERAGE

FOR 42" FLAT-SCREEN TV, MOUNT AT
ELEVATION OF TV, RECESSED IN WALL
COORDINATE WITH ARCHITECTURAL
ELEVATIONS. TYPICAL AT 7 LOCATIONS.

FOR 14" FLAT-SCREEN TV, MOUNT AT
ELEVATION OF TV, PROVIDE RECESSED IN
WALL CLOCK TYPE OUTLETS, COORDINATE
WITH ARCHITECTURAL ELEVATIONS.
(TYPICAL AT EACH BOOTH)
ETHERNET DATA JACK CONNECTED TO
THE BUS NETWORK AND MOUNTED
BELOW THE TABLE TOP (TYPICAL AT
EACH BOOTH)

FOR 14" FLAT-SCREEN TV, MOUNT AT
ELEVATION OF TV, PROVIDE RECESSED IN
WALL CLOCK TYPE OUTLETS, COORDINATE
WITH ARCHITECTURAL ELEVATIONS.
(TYPICAL AT EACH BOOTH)
ETHERNET DATA JACK CONNECTED TO
THE BUS NETWORK AND MOUNTED
BELOW THE TABLE TOP (TYPICAL AT
EACH BOOTH)

FOR 14" FLAT-SCREEN TV, MOUNT AT
ELEVATION OF TV, PROVIDE RECESSED IN
WALL CLOCK TYPE OUTLETS, COORDINATE
WITH ARCHITECTURAL ELEVATIONS.
(TYPICAL AT EACH BOOTH)
ETHERNET DATA JACK CONNECTED TO
THE BUS NETWORK AND MOUNTED
BELOW THE TABLE TOP (TYPICAL AT
EACH BOOTH)