


REVISIONS		
No.	Date	Description
1	4/6/16	Overflow Drains
2	5/26/16	Owner Changes

Information contained on this drawing and in all digital files associated is authorized for use on the project named herein only and is the property of MISHRA ARCHITECTURE PLLC and may not be reproduced in any manner without express written or verbal permission from authorized individuals. Original drawing is 24"x36" and scales are as indicated. ©2013 MISHRA ARCHITECTURE PLLC

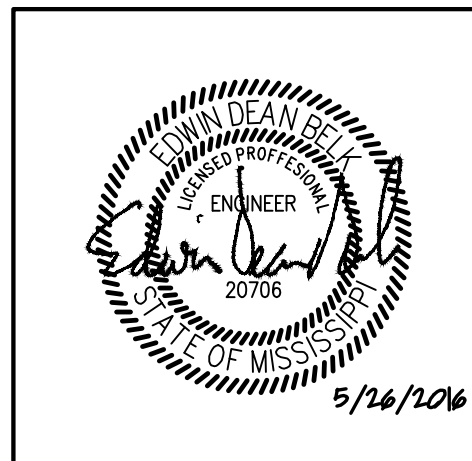

KEY PLAN

Shiva Southaven Inc.

Holiday Inn Express & Suites

Lot 16 (Rev Lot 3) Southcrest Pkwy.
Southcrest Subdivision
Southaven, MS 38671


Drawing Title

1ST FLOOR PLAN - LIGHTING

Phase
Construction Documents

Project No.	14-081	Sheet No.	E101
Prepared by	MAH		
Checked by	EDB		
Date	Feb. 27, 2015		

Holiday Inn Express & Suites

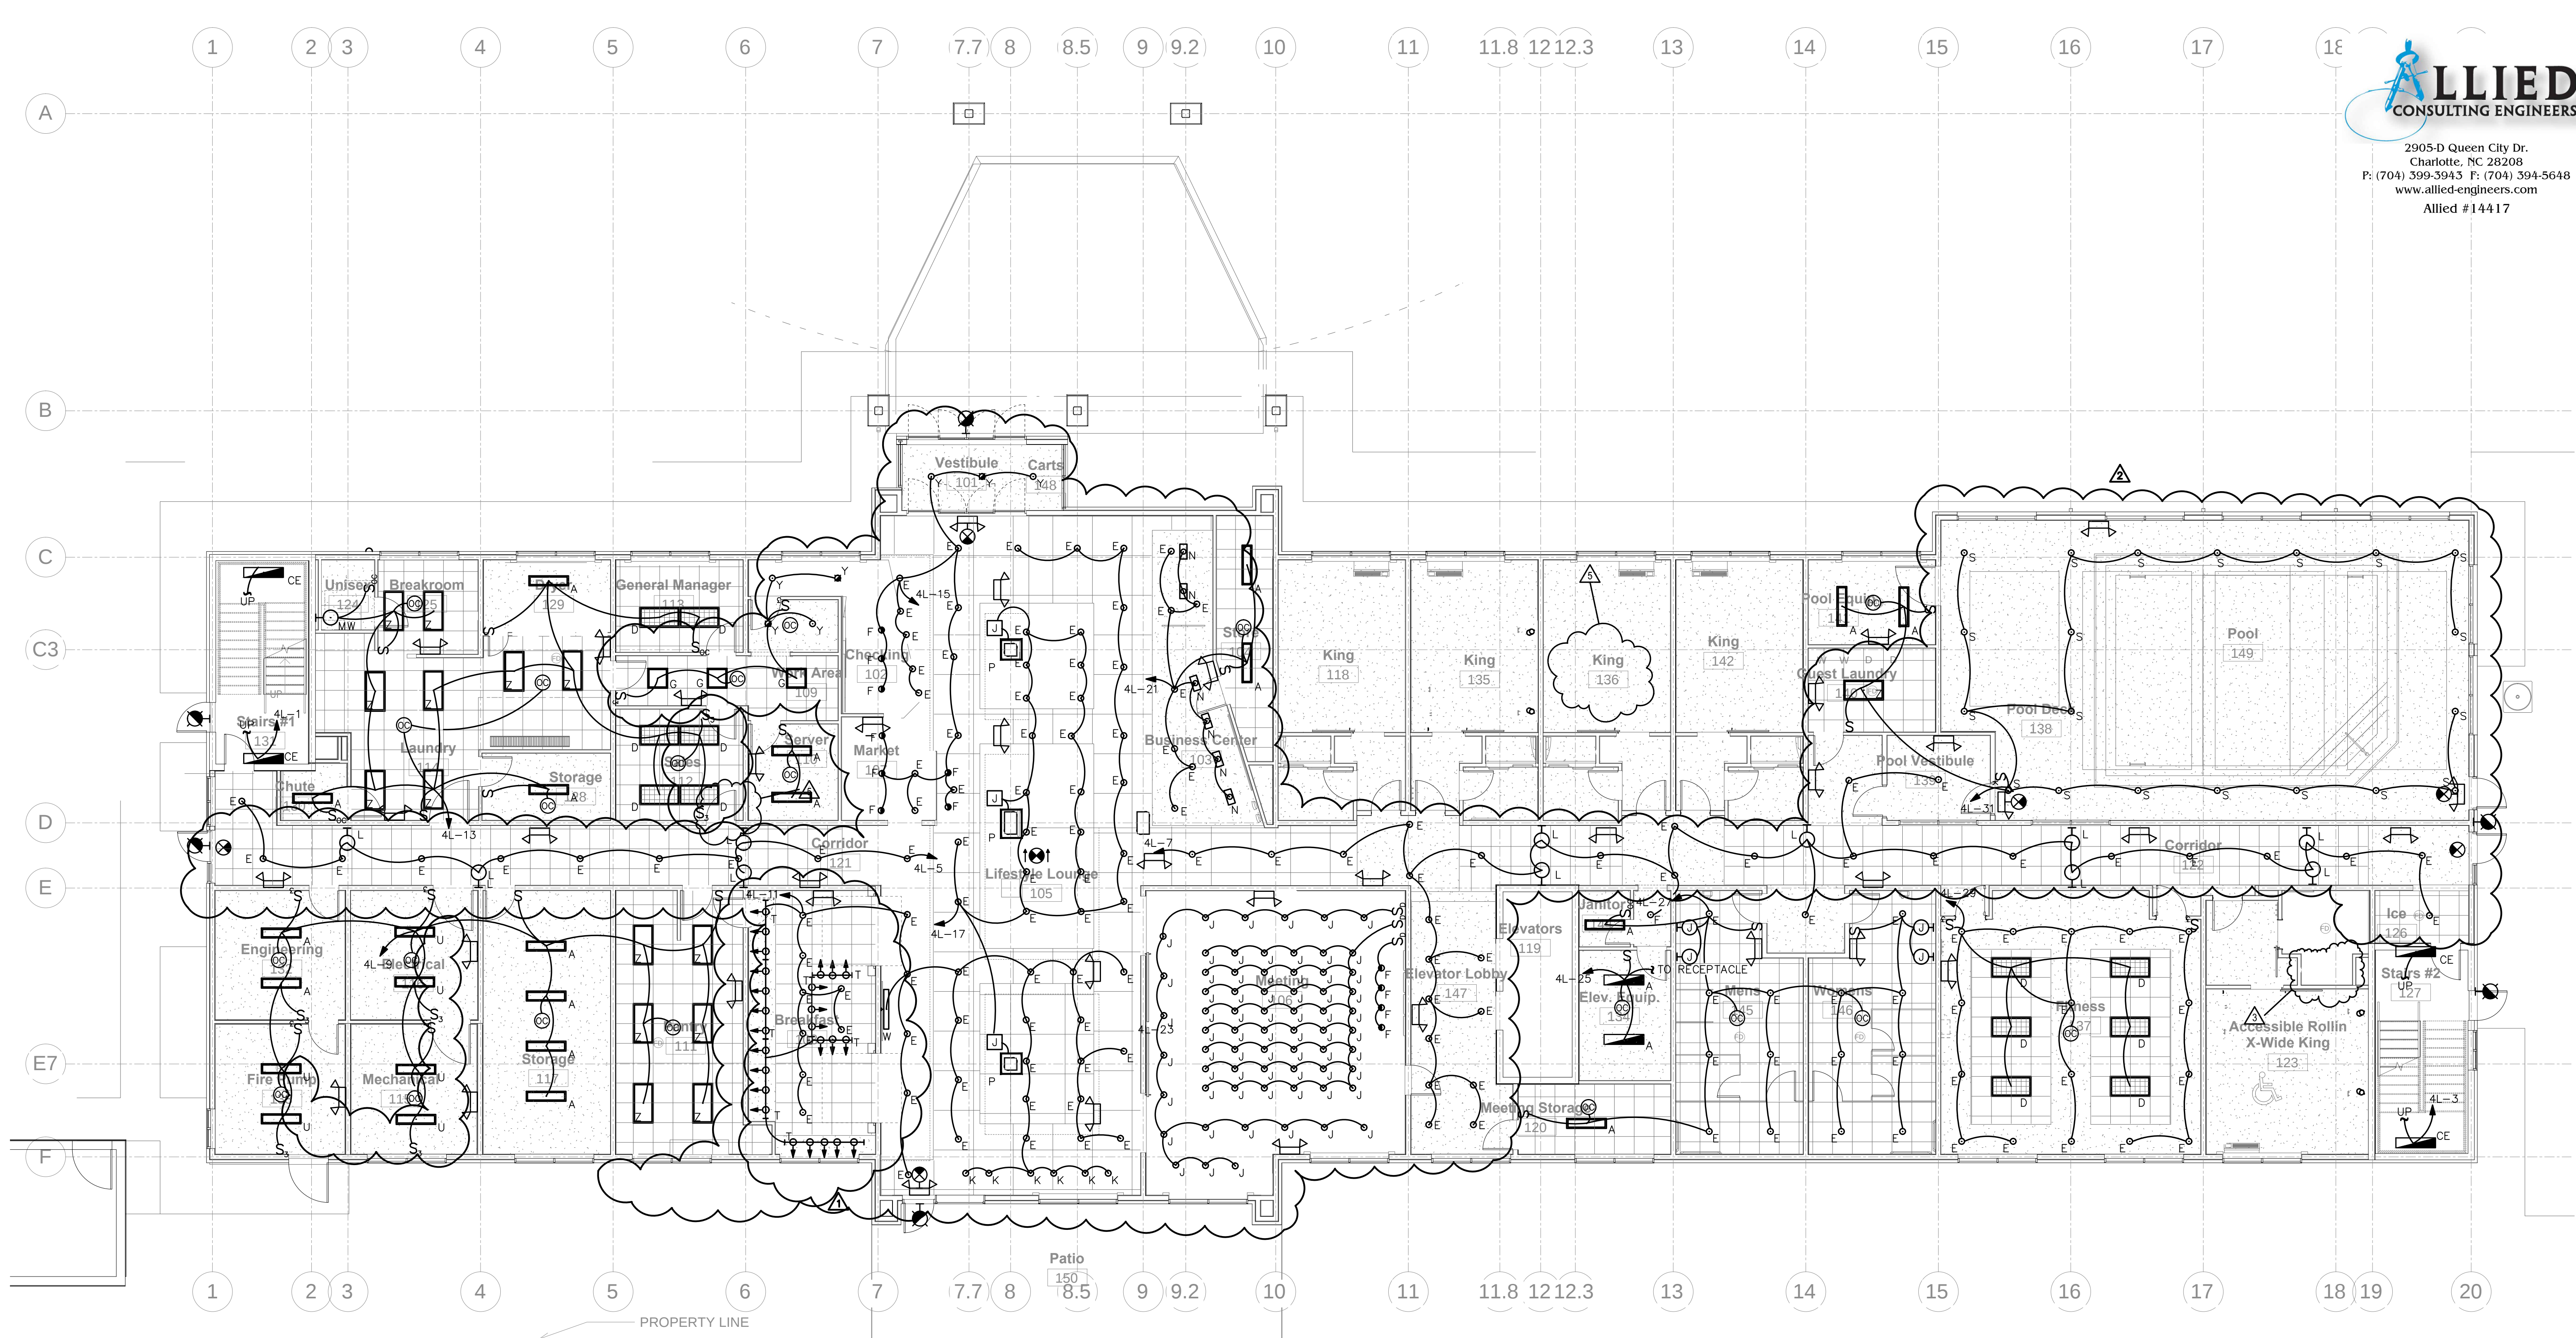

LIGHTING CONTROL PANEL SCHEDULE						PANEL: LCP-1			
LOCATION: ELECTRICAL ROOM 116				VOLTAGE:		MOUNTING: SURFACE			
NOTES	CONTROL DEVICE	LOAD DESCRIPTION	PANEL/ CIRCUIT	RELAY NO		PANEL/ CIRCUIT	LOAD DESCRIPTION	CONTROL	NOTES
1	TC, 1st Floor	Corridor/stairs	4L-5	1	2	OL-1,3	Parking Lot lights	TC, PS	1
1	TC, SW	Lobby/REGISTRATION	4L-15	3	4	OL-17	Canopy Lights	TC, PS	1
1	TC	Lobby/Lounge	4L-17	5	6	OL-16,18,20	Building Sign Lights	TC, PS	1
1	TC,SW	Lobby/BUSINESS CTR	4L-21	7	8	OL-5,7	Exterior Wall Lights	TC, PS	1
1		Spare	--	9	10	4L-31	Pool Lights	TC	1
1	TC,D	Breakfast SERVING	4L-11	11	12	OL-9,11	Exterior Wall Lights	TC, PS	1
1	TC,SW	Meeting	4L-23	13	14	OL-28,30,32	Building Sign Lights	TC, PS	1
1	TC	Elev Lobby/Corridor	4L-7	15	16	OL-13,15	Entry Signage	TC, PS	1
1		Spare	--	17	18	OL-2,4,6	Building Sign Lights	TC, PS	1
1		Spare	--	19	20		Spare		
1		Spare	--	21	22		Spare		
		Spare		23	24		Spare		
INPUT NO	CONTROL DEVICE, LOCATION			RELAYS CONTROLLED					
1									
2									
3									
4									
5									
6									
7									
NOTES:									
1: Control panel will turn lights "on" at predetermined time by owner, sweep lights "off" at time determined by owner.									
TC = TIME CLOCK, OS = OCCUPANCY SENSOR, PS = PHOTO SENSOR, SW = SWITCH, FA = FIRE ALARM									

1ST FLOOR PLAN - LIGHTING

SCALE: 1/8" = 1'-0"

NOTES:

1. CONNECT EXIT/EMERGENCY LIGHTS TO NEAREST CIRCUIT AHEAD OF ALL CONTROLS.