




2905-D Queen City Dr.
Charlotte, NC 28208
P: (704) 399-3943 F: (704) 394-5648
www.allied-engineers.com
Allied #14417

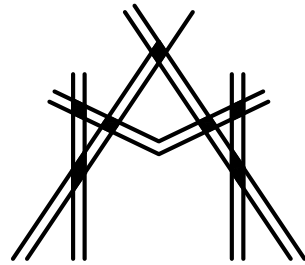

MISHRA
ARCHITECTURE PLLC

6800 S Creek Rd., Charlotte, NC 28277
Ph: (704) 625-6554 Fax: (704) 919-5822
EMAIL: ashish@mishraarch.com
WEB: www.mishraarch.com


CIVIL:
Benchmark Engineering and Surveying
101 Highpointe Court, Suite B
Brandon, MS 39042
Phone: (601) 591-1077
Fax: (601) 591-0177
Email: mikes@bellsouth.net

STRUCTURAL:
WGPM, Inc.
11220 Elm Lane, Suite 201
Charlotte, NC 28277
Phone: (704) 542-7199
Fax: (704) 542-7195
Email: lwright@wgpmc.com

MEP:
Allied Consulting Engineers
2905-D Queen City Drive
Charlotte, NC 28208
Phone: (704) 399-3943
Email: asoler@allied-engineers.com

REVISIONS		
No.	Date	Description
1		

Information contained on this drawing and in all digital files associated is authorized for use on the project named herein only and is the property of MISHRA ARCHITECTURE PLLC and may not be reproduced in any manner without express written or verbal permission from authorized individuals. Original drawing is 24"x36" and scales are as indicated. © 2013 MISHRA ARCHITECTURE PLLC

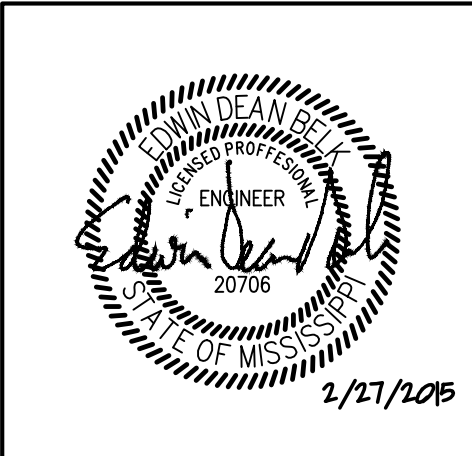

KEY PLAN

Shiva Southaven
Inc.

Holiday Inn Express
& Suites

Lot 16 (Rev Lot 3) Southcrest
Pkwy.
Southcrest Subdivision
Southaven, MS 38671

Drawing Title


MECHANICAL
4TH FLOOR PLAN

Phase
Construction Documents

Project No.	14-081	Sheet No.
Prepared by	CRM	M104
Checked by	EDB	
Date	Feb. 27, 2015	

MECHANICAL KEYED NOTES

- 1 FAN MFR. WALL CAP.

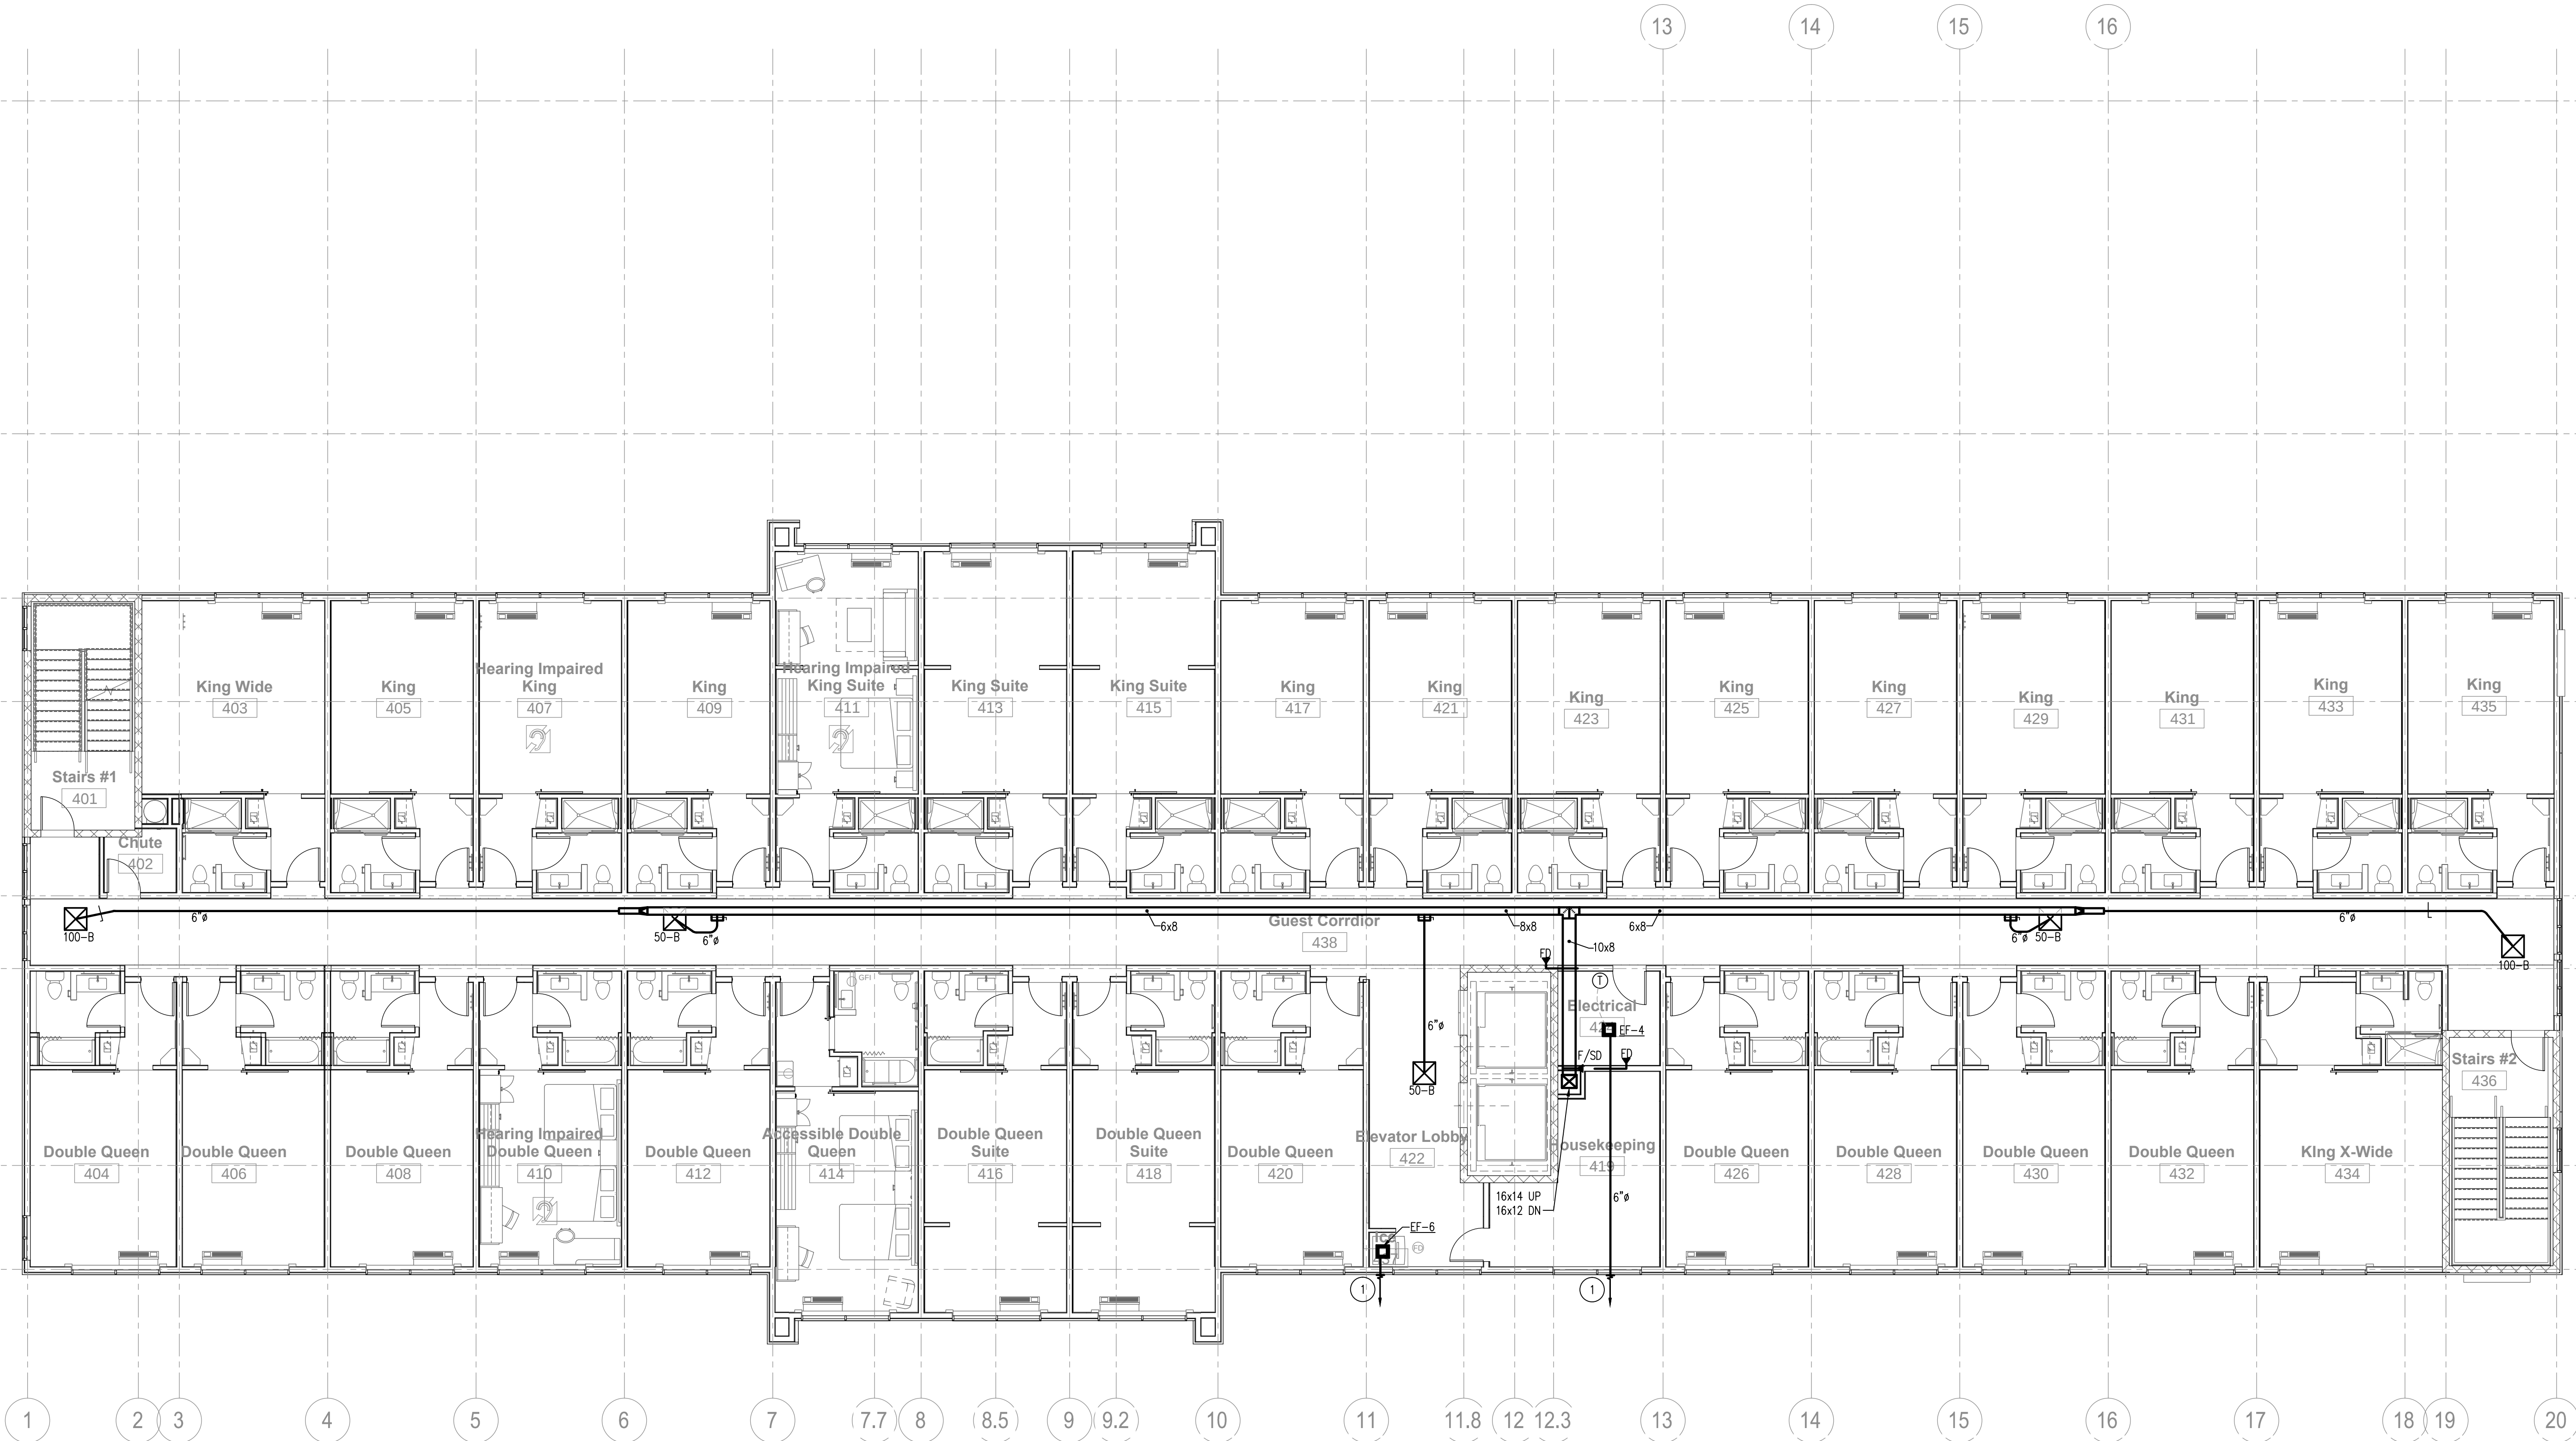

MECHANICAL 4TH FLOOR PLAN
SCALE: 1/8" = 1'-0"

Holiday Inn Express & Suites