


REVISIONS		
No.	Date	Description
1		

Information contained on this drawing and in all digital files associated is authorized for use on the project named herein only and is the property of MISHRA ARCHITECTURE PLLC and may not be reproduced in any manner without express written or verbal permission from authorized individuals. Original drawing is 24"x36" and scales are as indicated. © 2013 MISHRA ARCHITECTURE PLLC

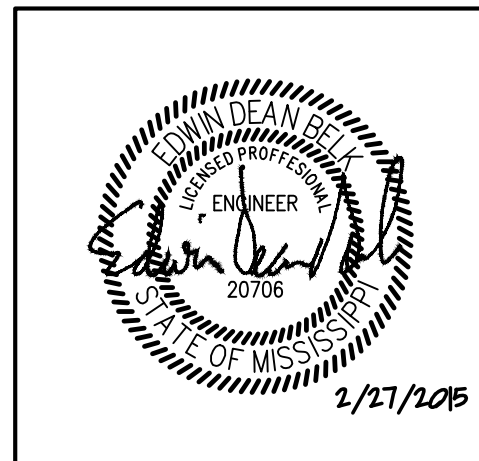

KEY PLAN

Shiva Southaven Inc.


Holiday Inn Express & Suites

Lot 16 (Rev Lot 3) Southcrest Pkwy.
Southcrest Subdivision
Southaven, MS 38671

Drawing Title
Plumbing
First Floor Plan
Sanitary and Storm
Phase
Construction Documents

Project No.	14-081	Sheet No.	
Prepared by	MJS		P100
Checked by	EDB		
Date	Feb. 27, 2015		

Holiday Inn Express & Suites

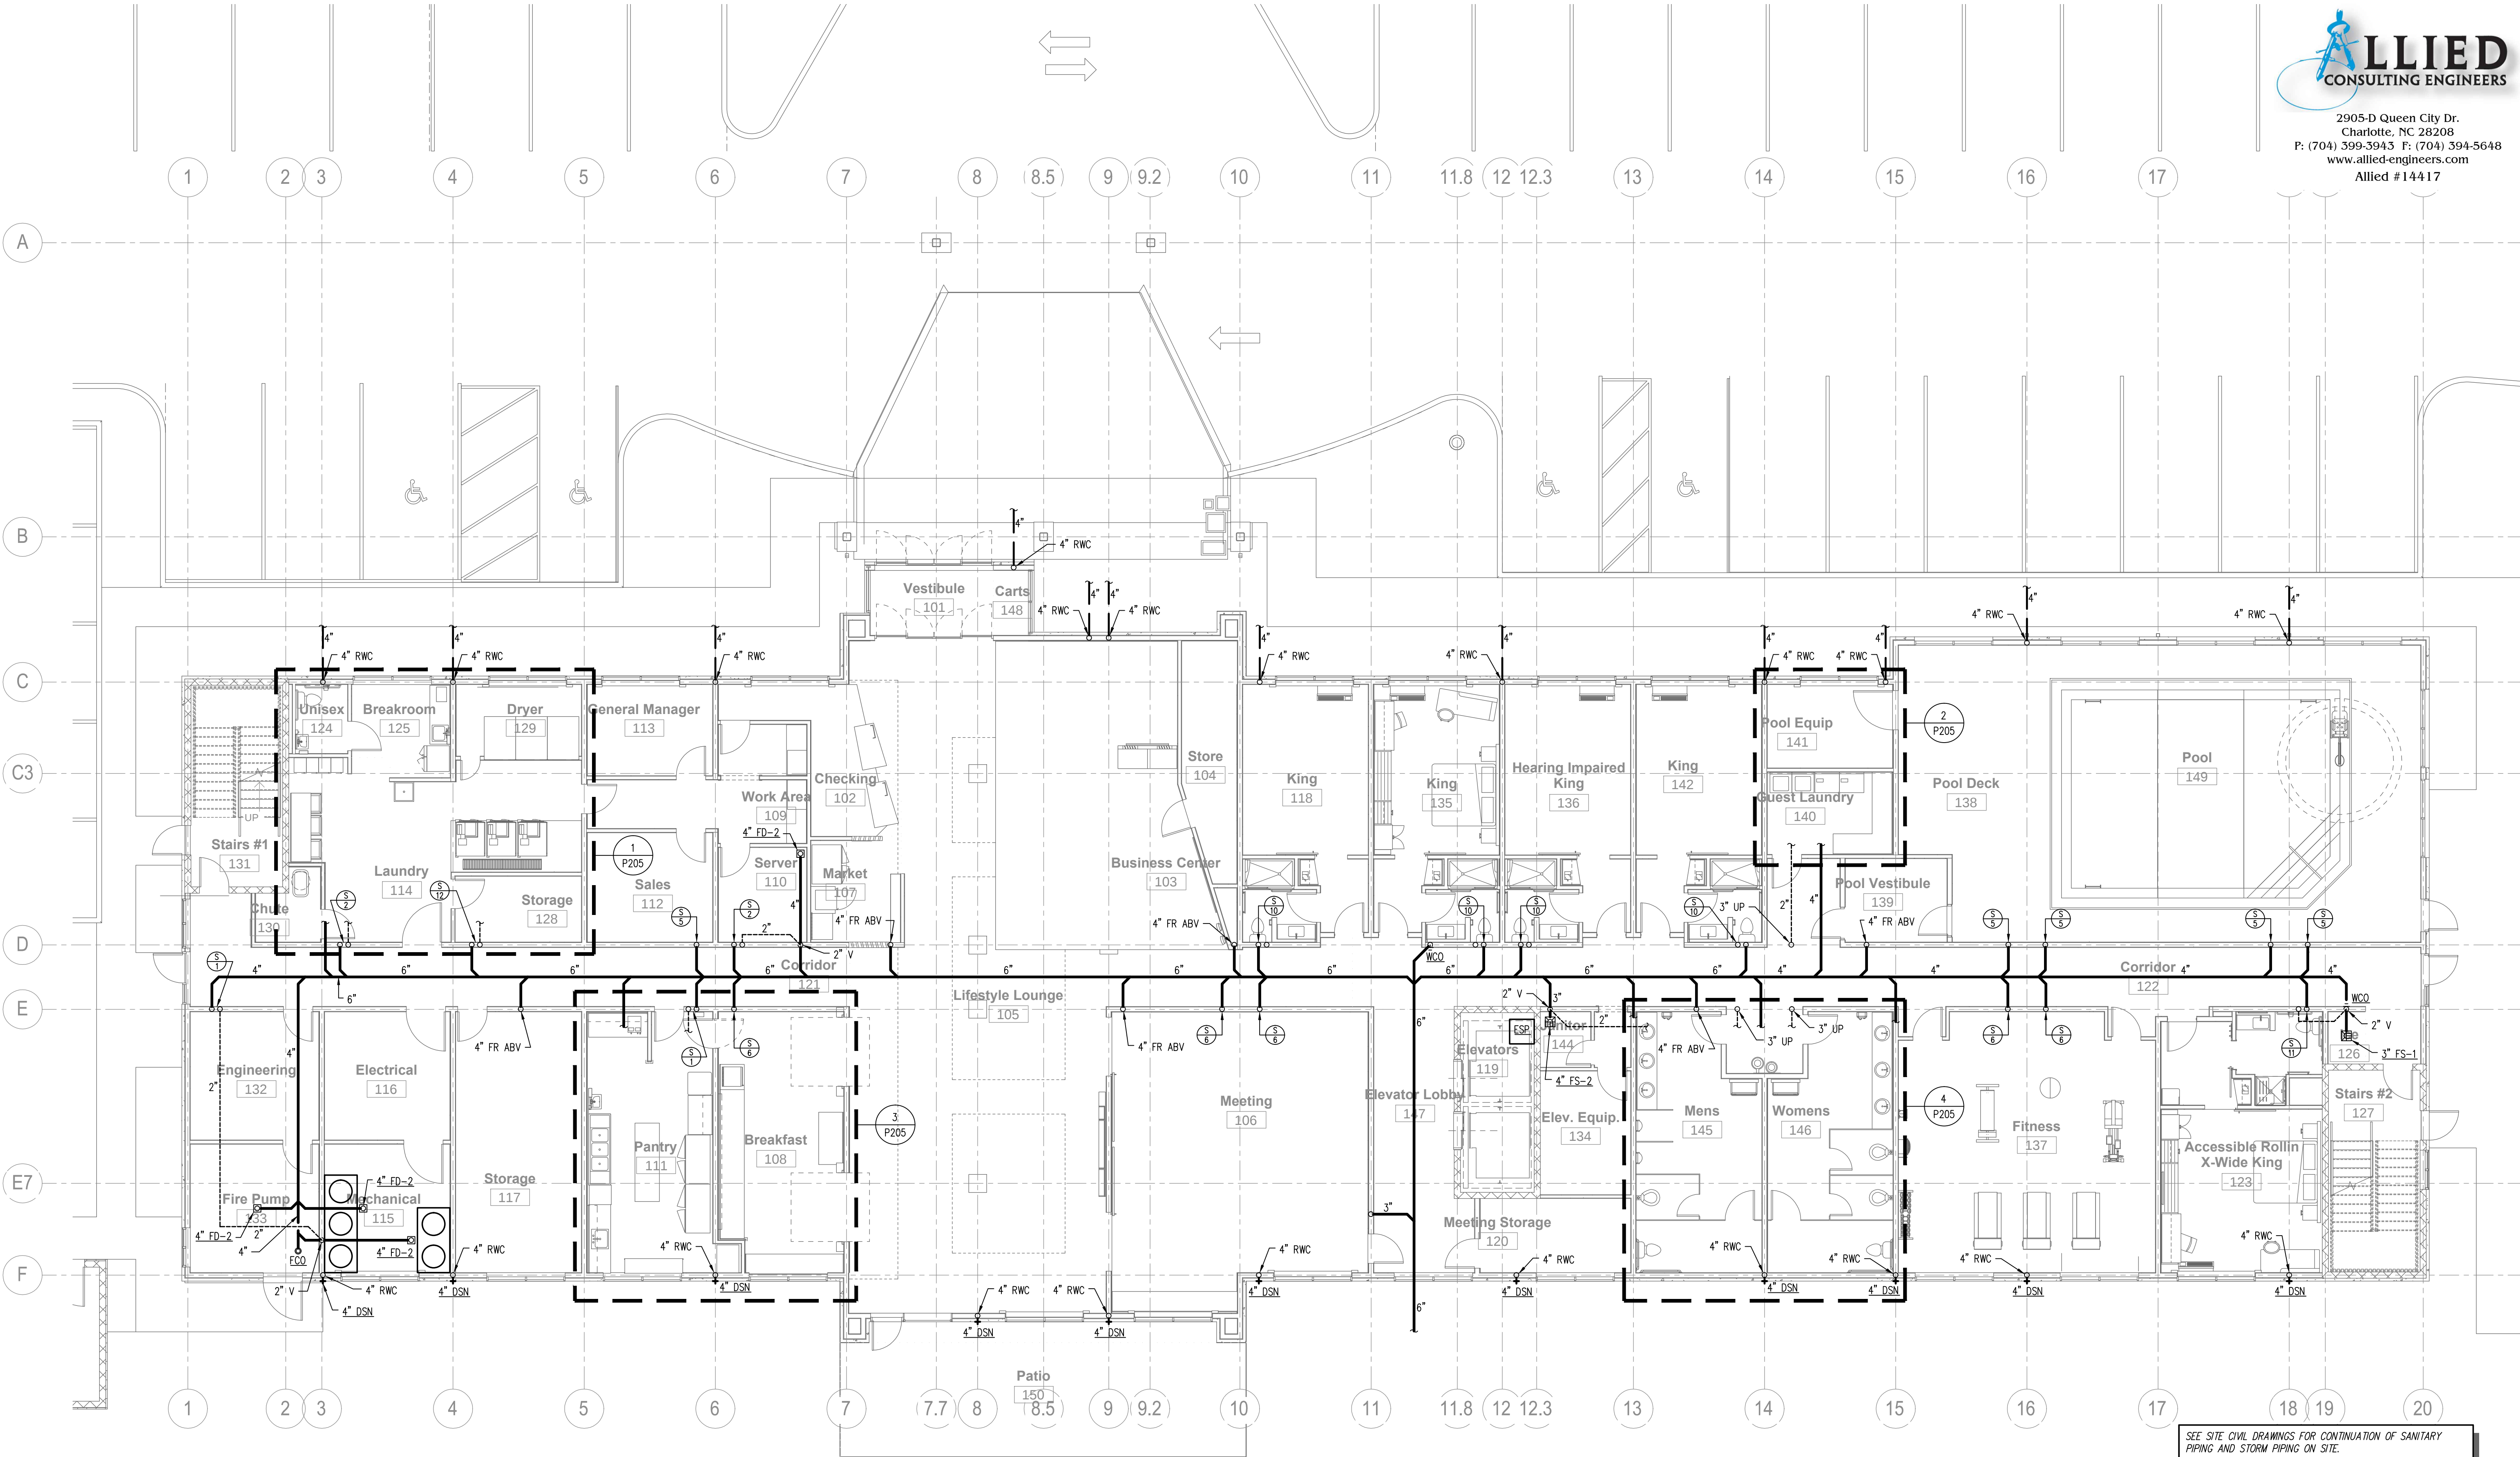

1 FIRST FLOOR PLAN - SANITARY AND STORM
P100 SCALE: 1/8" = 1'-0"

SEE SITE CIVIL DRAWINGS FOR CONTINUATION OF SANITARY PIPING AND STORM PIPING ON SITE.

SEE ENLARGED TYPICAL GUEST ROOM PLANS ON SHEETS P201 AND P202 FOR PIPING IN GUEST ROOMS.

SEE SANITARY & VENT PIPING RISER DIAGRAMS ON SHEETS P301 THROUGH P303 FOR PIPE SIZES AND ADDITIONAL INFORMATION.

MINIMUM SIZE FOR SANITARY AND VENT PIPING BELOW GROUND SHALL BE 2".

ALL VENT PIPING SHOWN ON THIS SHEET SHALL BE RUN ABOVE CEILINGS IN AREAS WITH CEILINGS AND SHALL BE RUN AS HIGH AS POSSIBLE IN AREAS WITHOUT CEILINGS, UNLESS OTHERWISE NOTED; ALL SANITARY PIPING AND ALL STORM PIPING SHOWN ON THIS SHEET SHALL BE RUN BELOW FLOORS, UNLESS OTHERWISE NOTED.