

FILENAME	POA-3-B
JOB NO.	00000
DATE	SEP 30, 1998
SCALE	1/8"=1'-0"
CHKD	
DRAWN	SH
SHEET NO. 07	
MECHANICAL	
ROOF PLAN	
SHEET TITLE	

PROJECT
PROPOSED 37-UNIT HOTEL
2834 EL CAMINO REAL
REDWOOD CITY, CA 94063
OWNER
H.L. PATEL
CONTACT: VIJAY PATEL
1133 PEBBLEWOOD WAY
SAN MATEO, CA 94403
TEL: (415) 570 6970


SKL ARCHITECTURE & PLANNING
3018 W. 15th Ave., Suite 206
Berkeley, CA 94704
Phone: 510 880 2711
Fax: 510 880 2712

SHEET NOTES
1. ALL ROOFING MATERIAL SHALL BE APPLIED AS RECOMMENDED BY THE MANUFACTURER.
2. ALL ROOFING MATERIAL SHALL BE SPREAD INCLUSIVE OF ANY ACCESSORIES RECOMMENDED BY THE MANUFACTURER.
3. ALL ROOFING MATERIAL MUST COMPLY WITH THE REQUIREMENTS OF UBC CHAPTER 20.
4. ALL WALLS MUST COMPLY WITH THE REQUIREMENTS OF UBC CHAPTER 20.
5. PROVIDE GRAFT STOPS AND FIRE STOPS PER UBC SECTION 20.1.1.1.1.

LEGEND

I HAVE REVIEWED THE CURRENT CALIFORNIA ENERGY CONSERVATION STANDARDS FOR RESIDENTIAL BUILDINGS. IN MY PROFESSIONAL JUDGEMENT, THE DESIGN ON THIS SET OF PLANS AND SECTIONS SUBCHAPTER 7 & 8, SECTIONS 150 & 151, WILL CONFORM SUBSTANTIALLY WITH TITLE 24.

MECHANICAL PLAN
ROOF PLAN

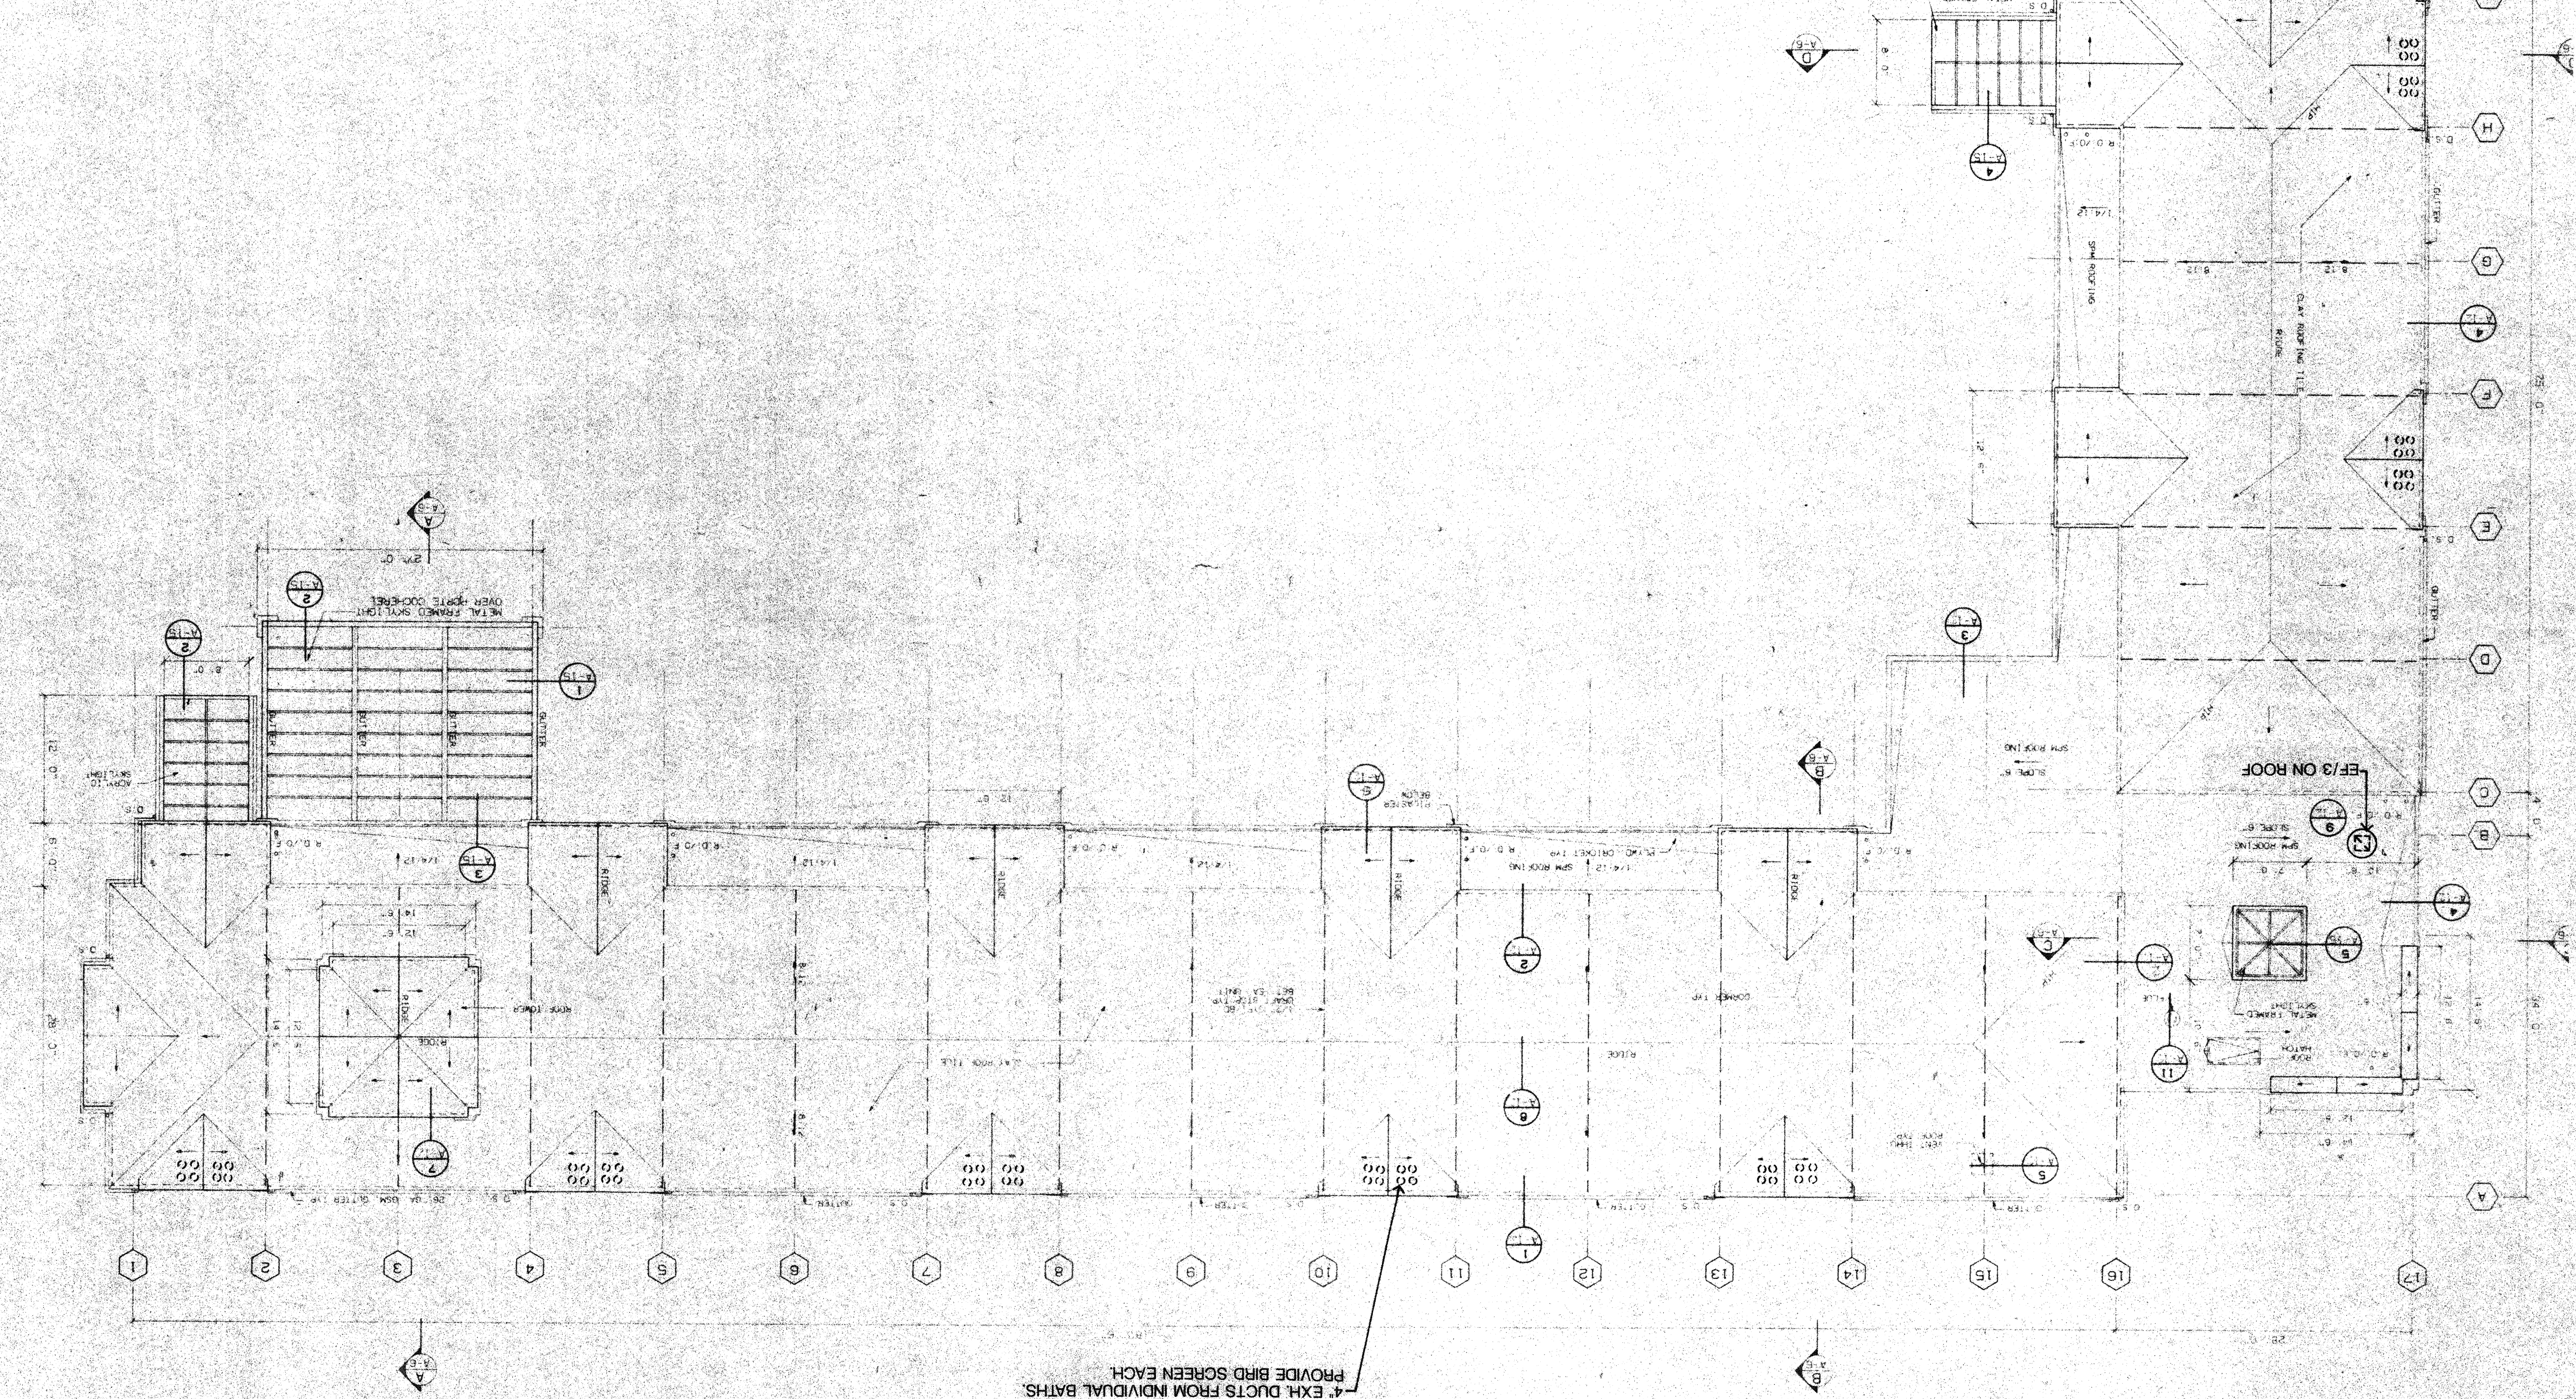

ARTURO O. CABRERA, P.E.
REGISTERED PROFESSIONAL ENGINEER
No. 010569
State of California
Mechanical Engineering

ARTURO O. CABRERA, P.E.
REGISTERED PROFESSIONAL ENGINEER
No. 010569
State of California
Mechanical Engineering