


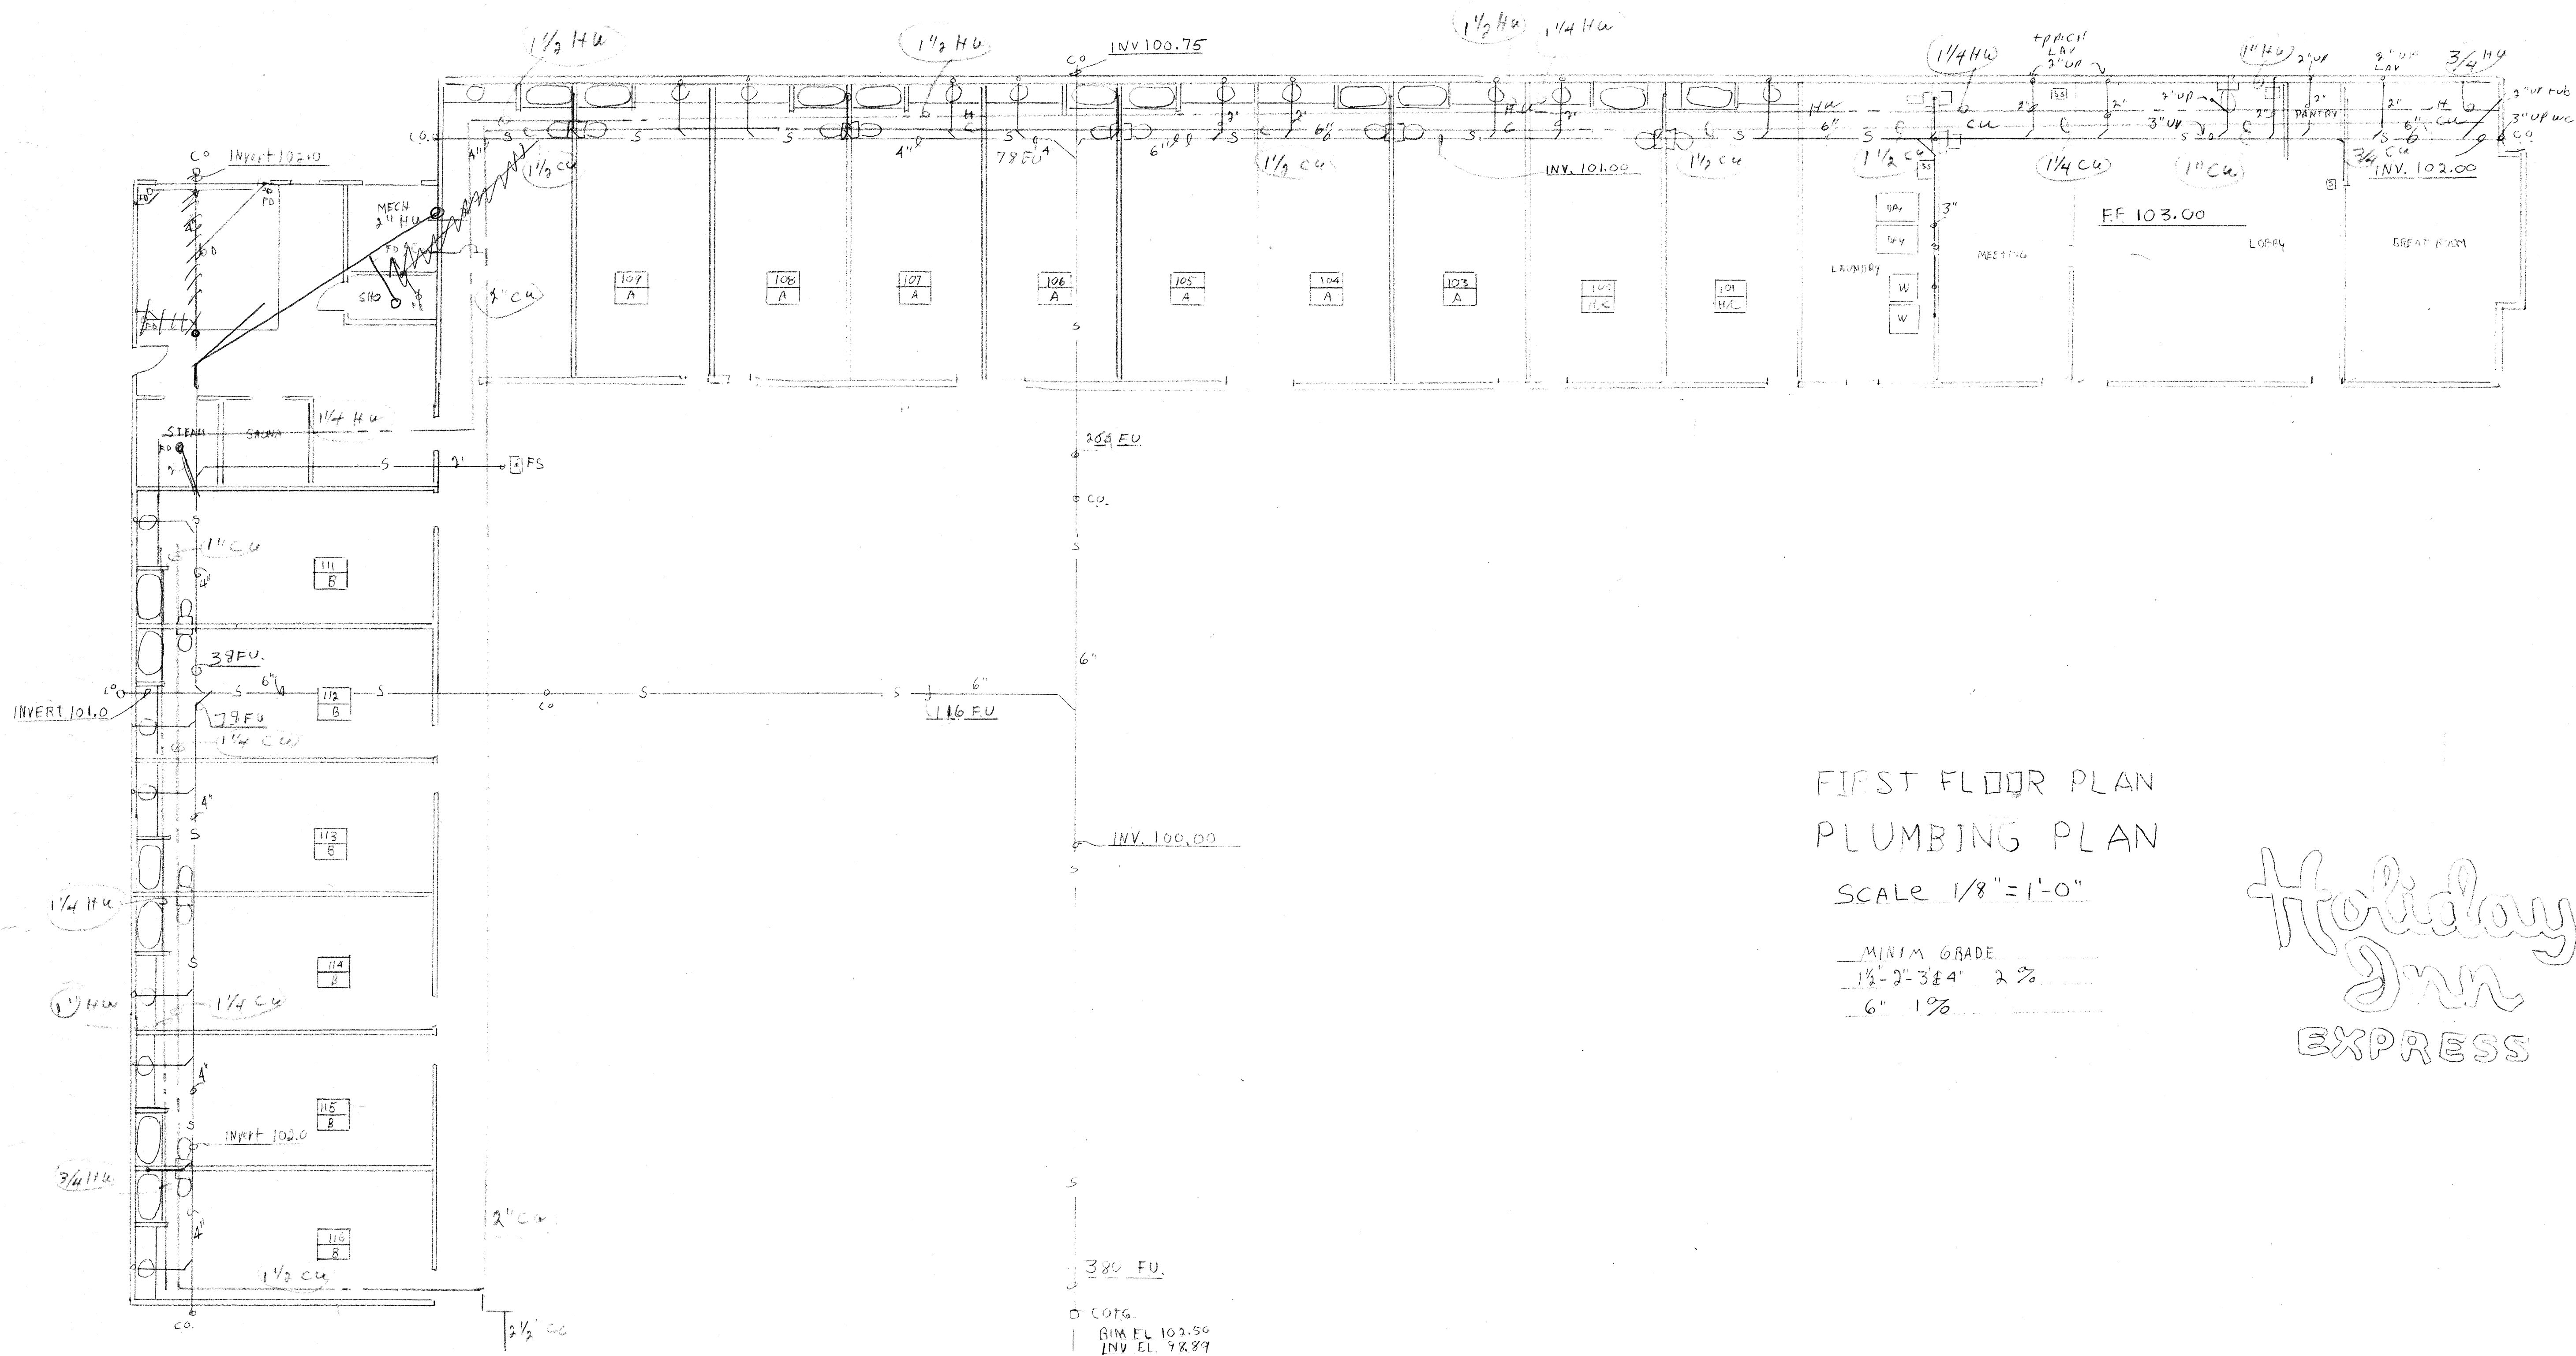

FIRST FLOOR PLAN
PLUMBING PLAN
SCALE 1/8" = 1'-0"

MINIM GRADE
1 1/2" - 2" - 3" & 4" 2%
6" 1%

Holiday Inn
EXPRESS

"Revised Plumbing"
2834 EL CAMINO REAL
REDWOOD CITY, CA 94063

SCALE: 1/8" = 1'-0"	APPROVED BY:	DR:
DATE: 2-5-93		