




LEGEND

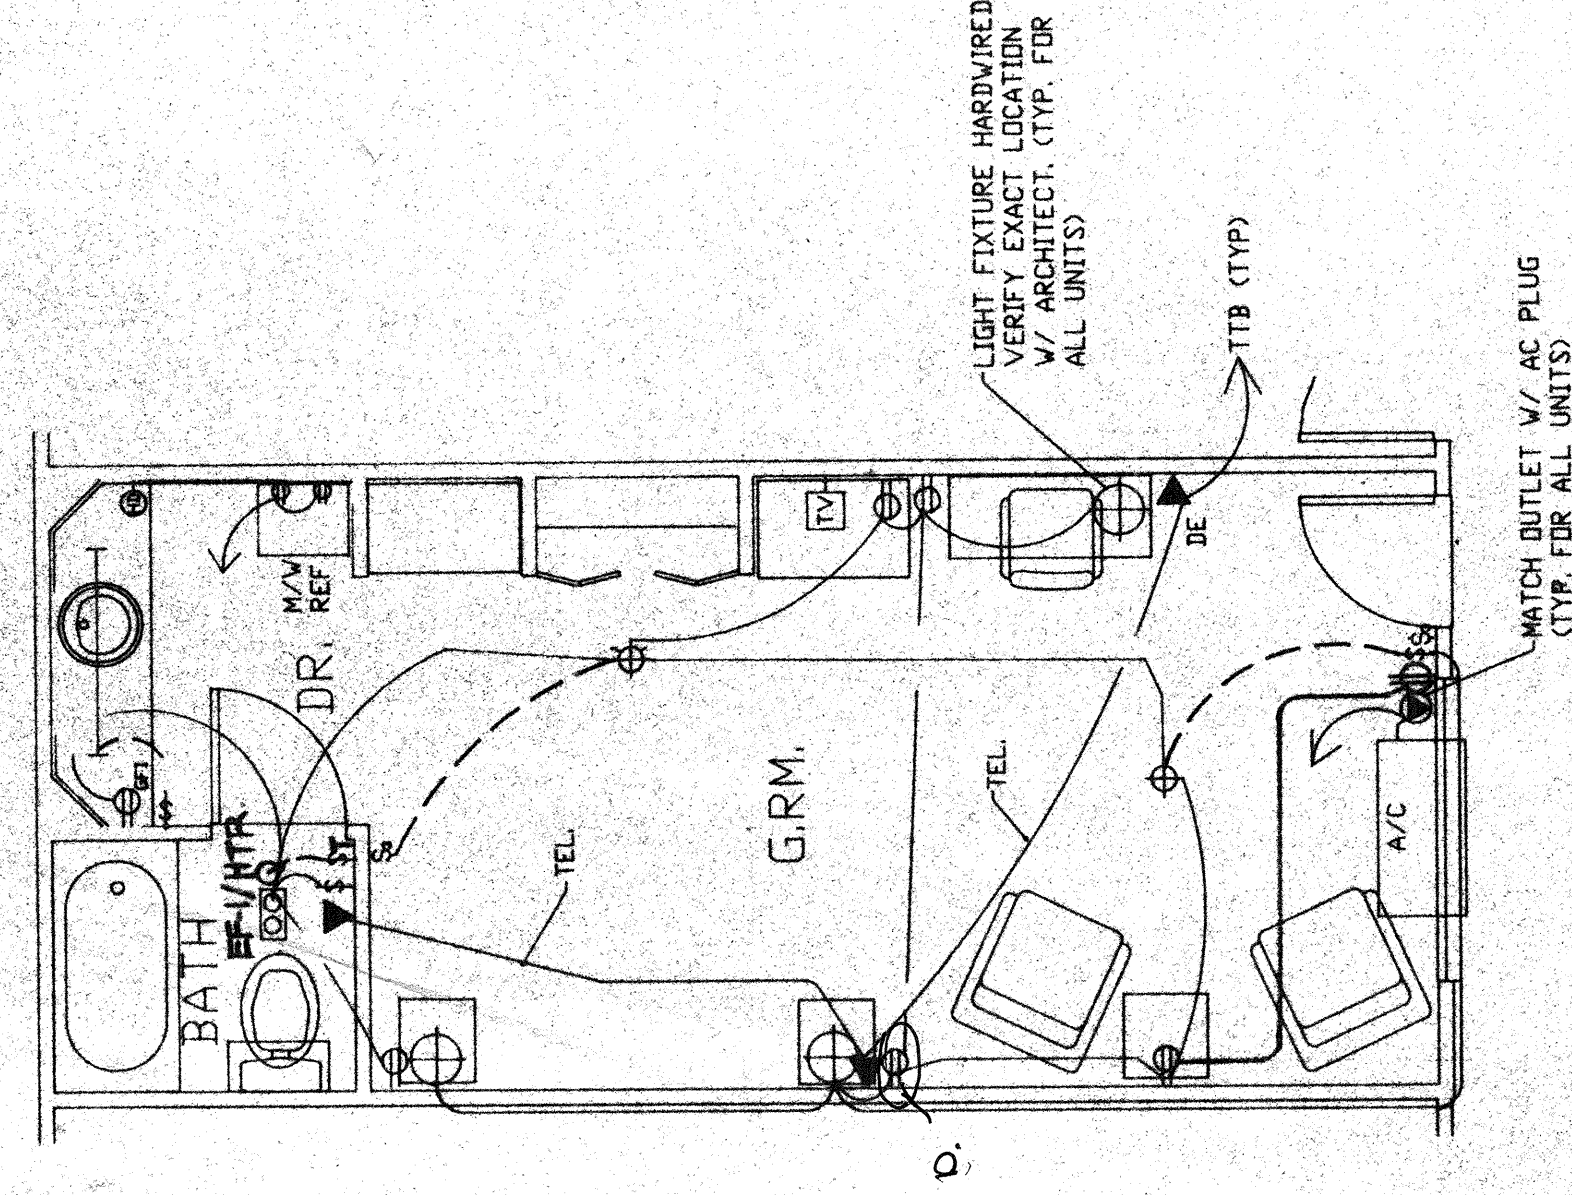


UNIT-A PLAN

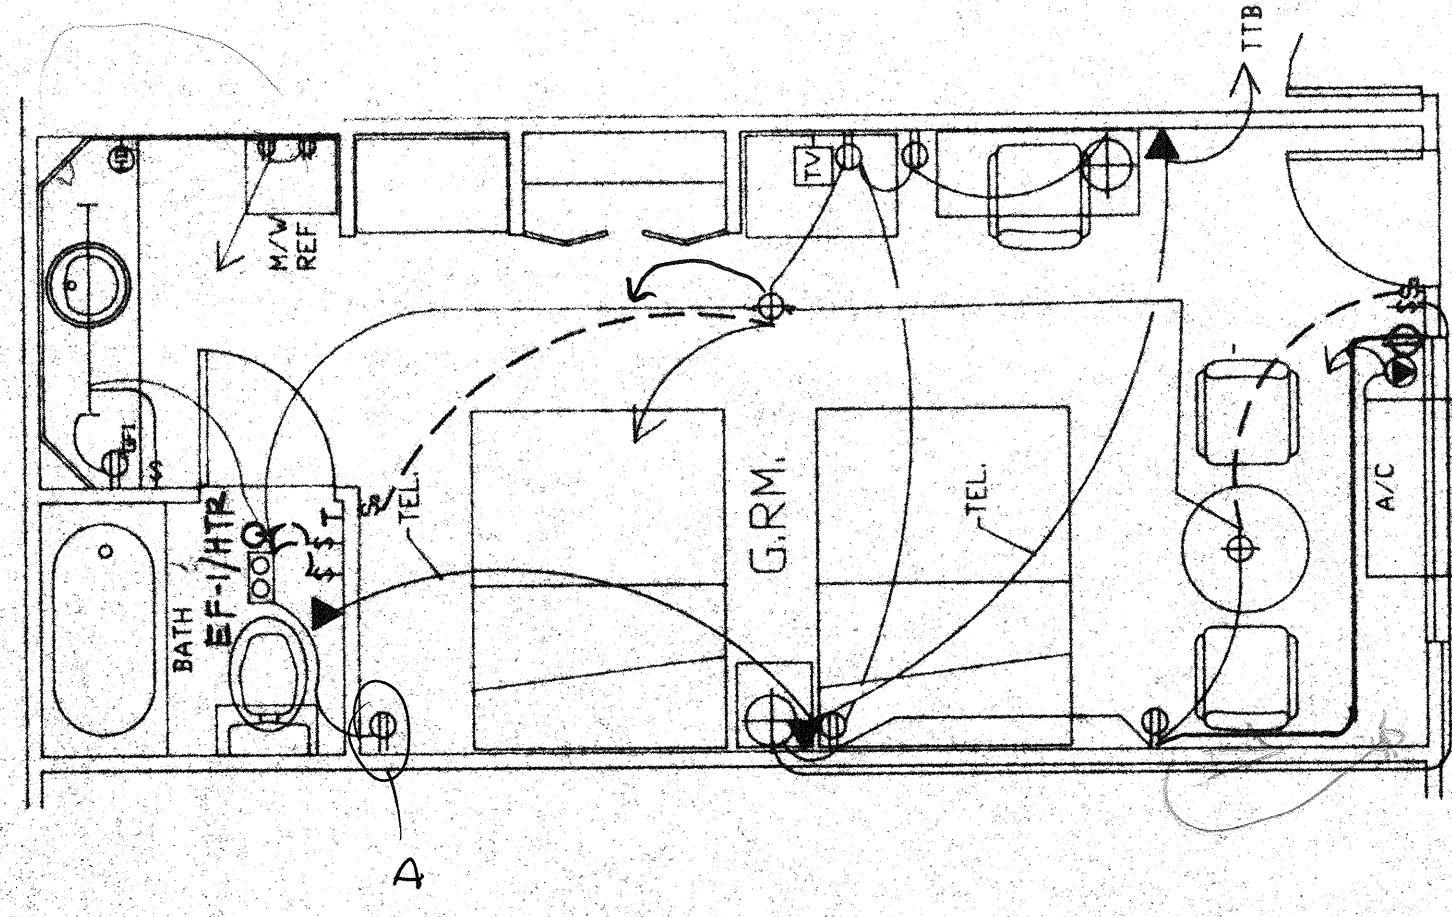


UNIT-B PLAN

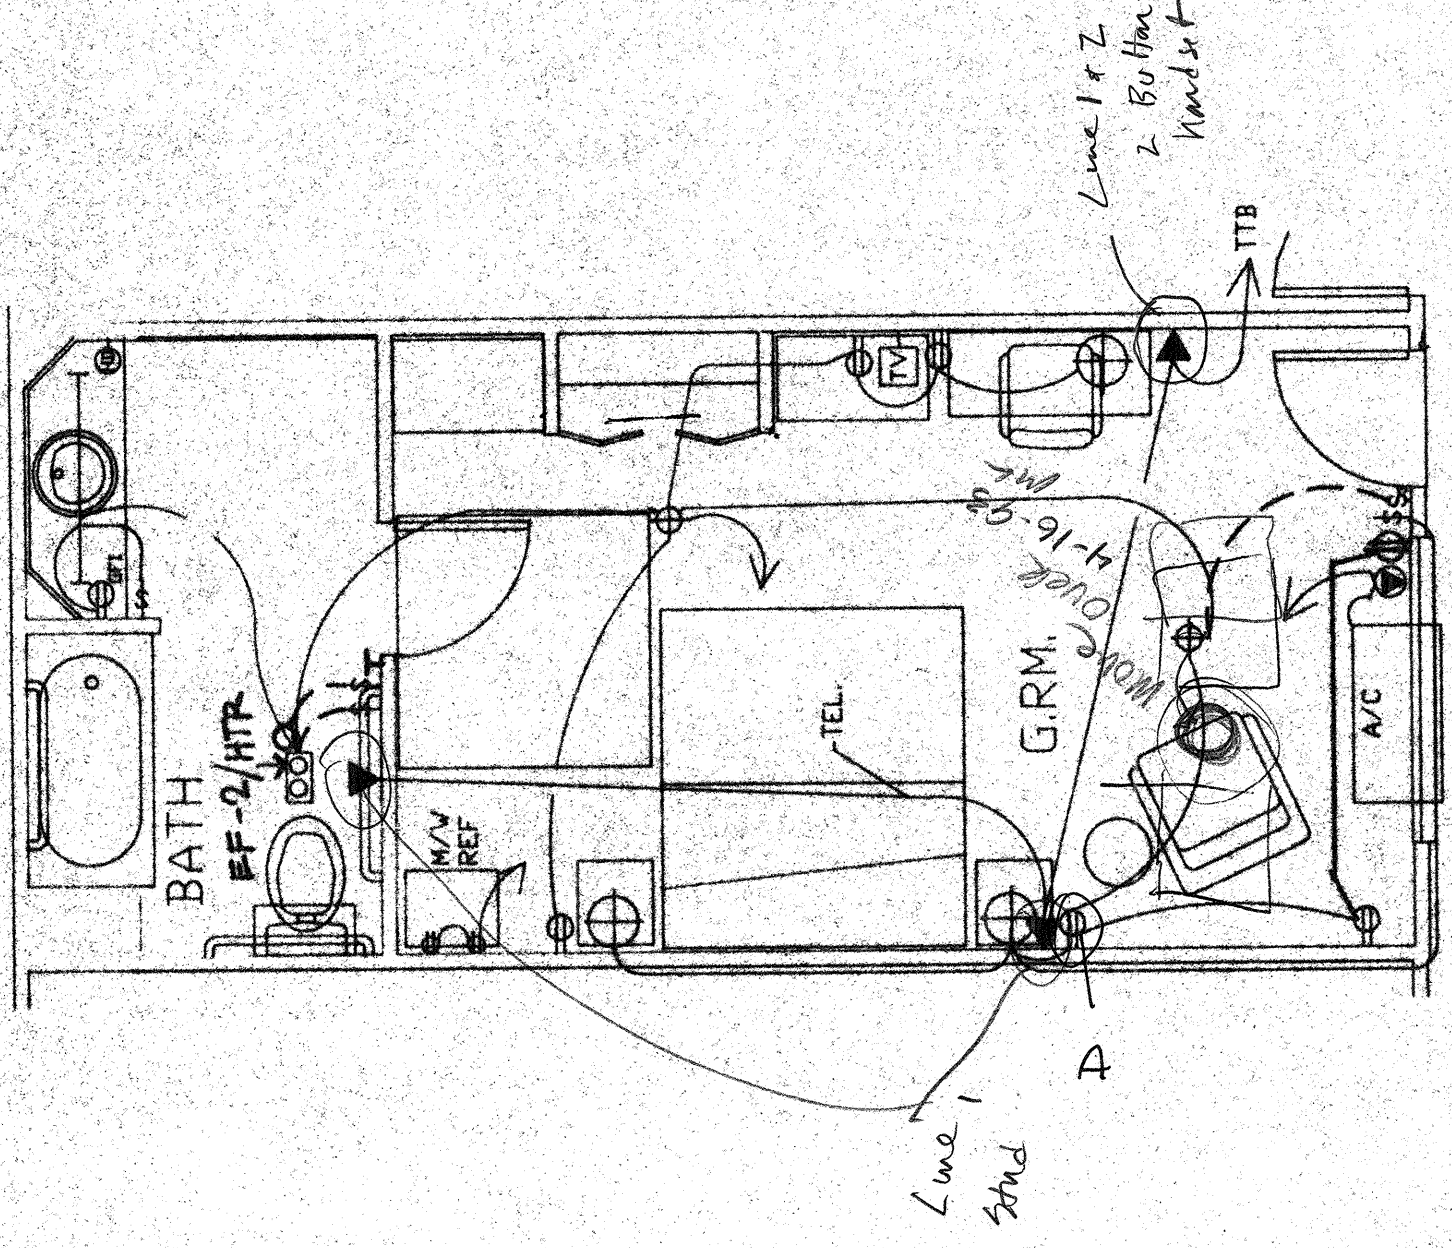


HANDICAP ROOM PLAN

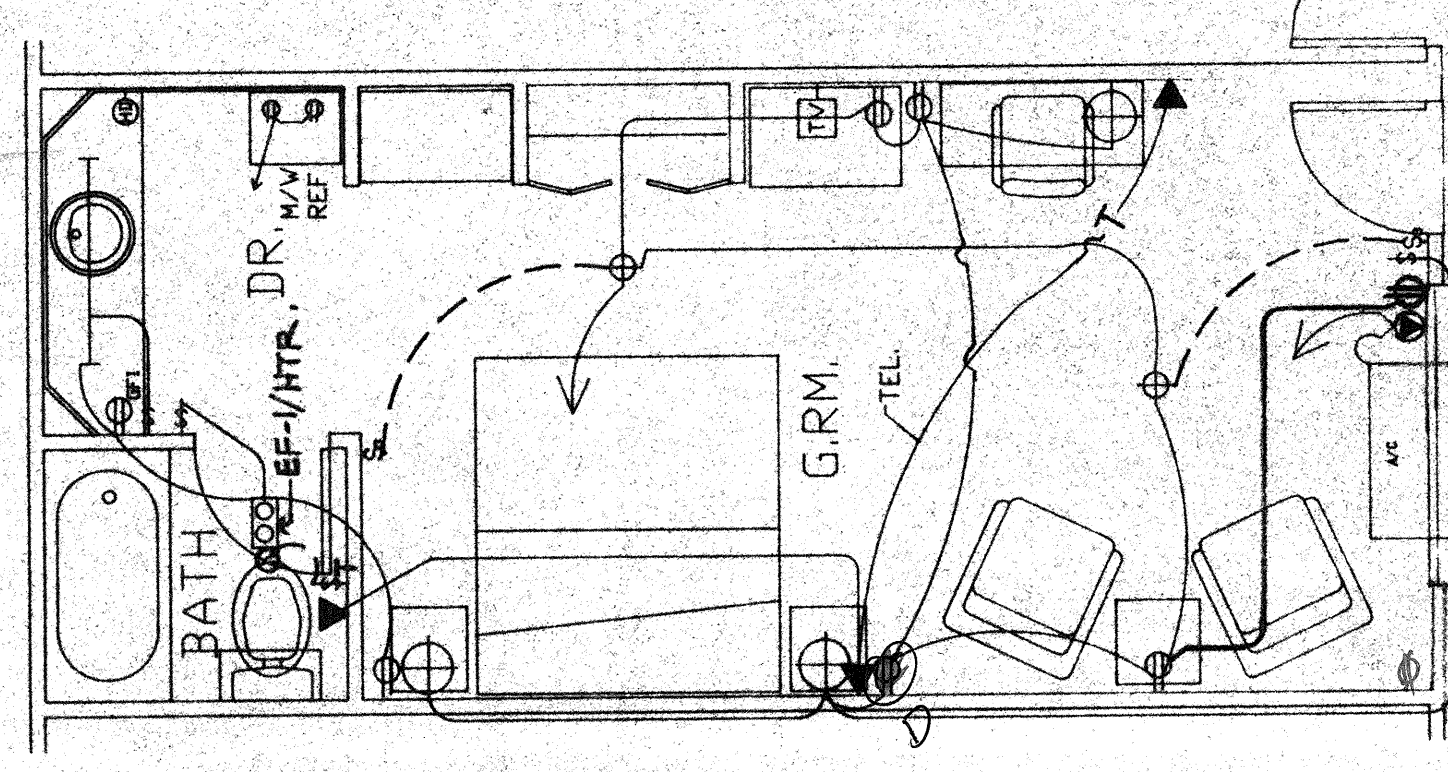

UNIT-C PLAN

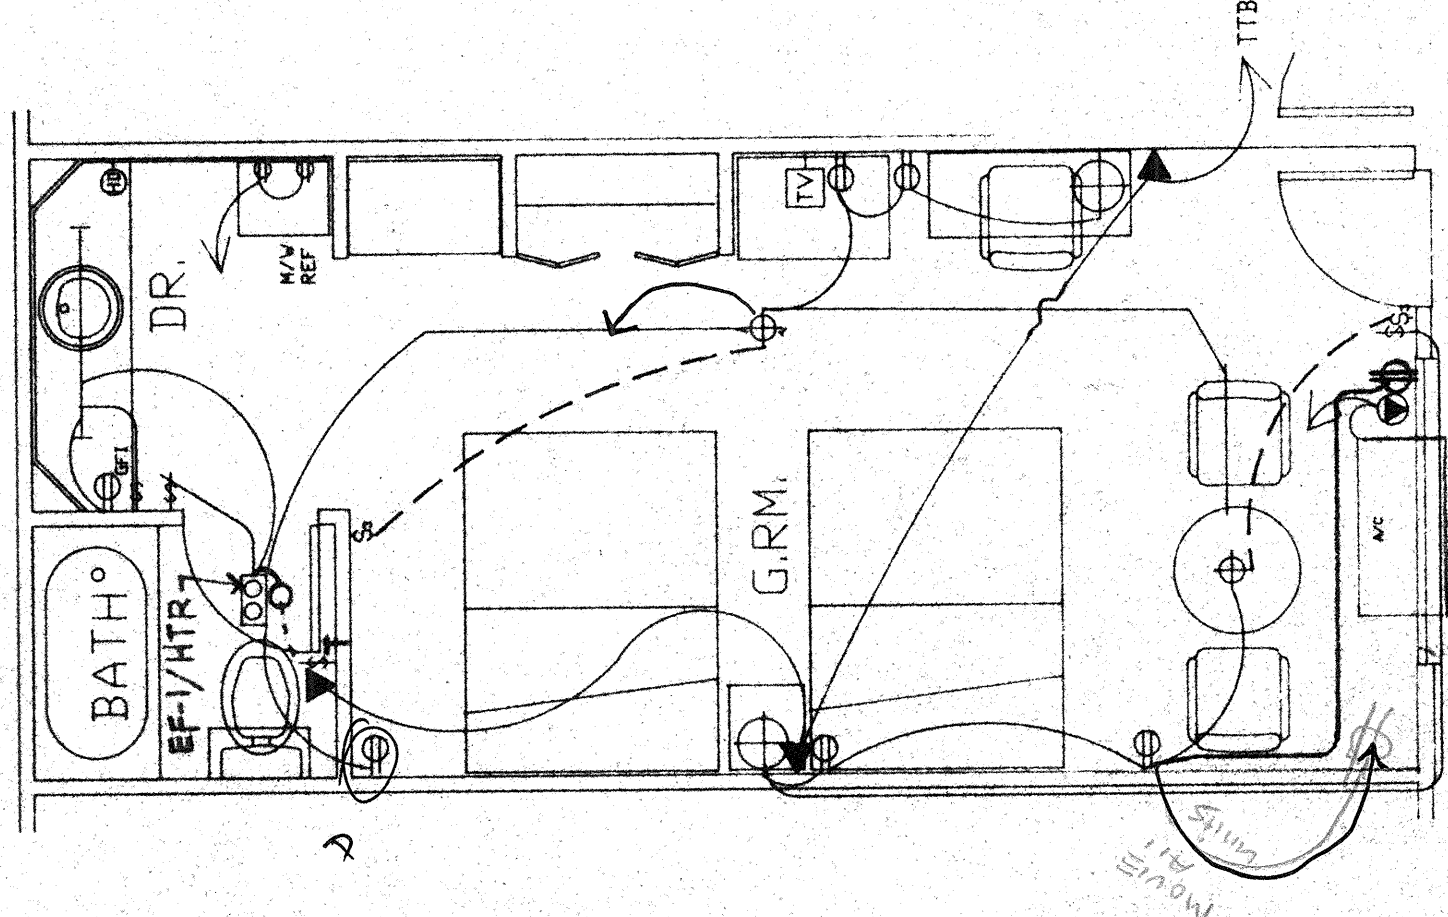

UNIT-D PLAN

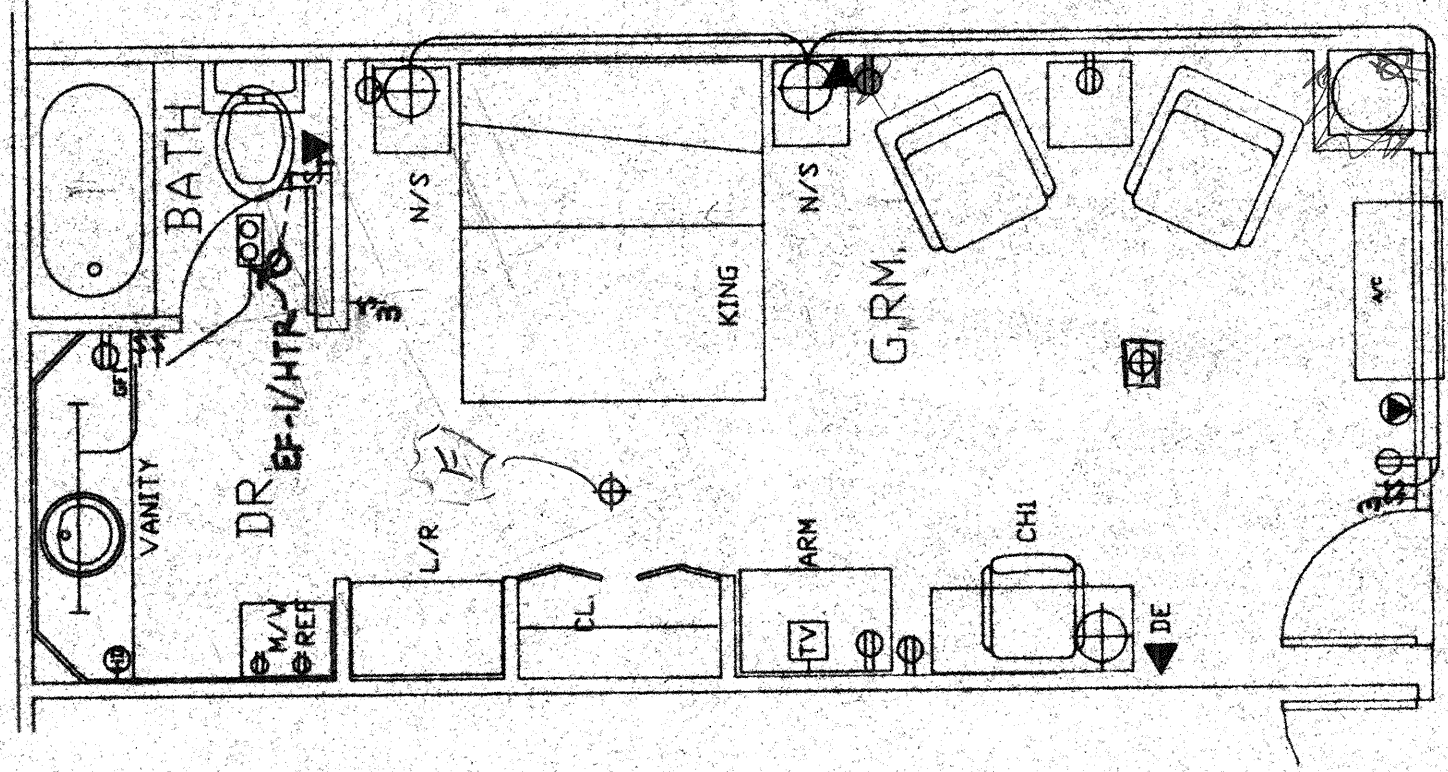


NOTE: TYPICAL WIRING AS IN UNIT-C

UNIT-C PLAN W/ CHUTE

SHEET NOTES

1. THREE WAY SWITCH LOCATED IN GUEST ROOM AT BATH WALL TO HAVE ILLUMINATED TOGGLE HANDLE AT OFF POSITION. PROVIDE 'BRYANT' LIGHTED HANDLE SWITCH OR EQUAL.

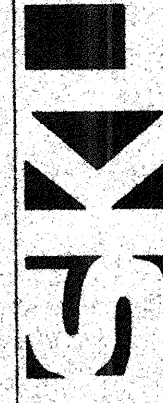

SKL ARCHITECTURE & PLANNING
3018 Willow Pass Road, Suite 206
Concord, California 94519
Phone 510 680 2711
Fax 510 680 2717

OWNER: H.L. PATEL
CONTACT: VIJAY PATEL
1133 PEBBLEWOOD WAY
SAN MATEO, CA 94403
TEL: (415) 570 6970

PROJECT

PROPOSED 37-UNIT MOTEL
2834 EL CAMINO REAL
REDWOOD CITY, CA 94603

SHEET TITLE

UNIT PLAN, POWER
AND
LIGHTING PLAN

SHEET NO.

E-6

DF

I HAVE REVIEWED THE CURRENT CALIFORNIA ENERGY CONSERVATION STANDARDS FOR RESIDENTIAL BUILDINGS AND PROFESSIONAL JUDGEMENT. THE DESIGN OF THIS SET OF PLANS AND SPECIFICATIONS CONFORM SUBSTANTIALLY WITH TITLE 24 SUBCHAPTER 7 & 8, SECTIONS 150 & 151.

