

PROJECT:
HOME2 SUITES BY HILTON
550 GATEWAY BLVD.
SOUTH SAN FRANCISCO, CA
80 KIRKMAN OVERPASS
300 GATEWAY BOULEVARD
SOUTH SAN FRANCISCO, CA 94080

DRAWING:
SECOND TO FIFTH
FLOOR PLAN

SCALE:
1/8" = 1'-0"

DATE:
JAN. 12, 2017

DRAWN BY:
K SUTHERLAND


DRAWING NUMBER:
ID1.01

REVISIONS:

REV #	DATE	NOTES
0	APR 28, 2017	RELEASE
1	MAY 05, 2017	GRAPHIC REVISIONS
2	MAY 08, 2017	PATIO REV.
3	JUN 05, 2017	K STUDIO CONV.
4	AUG 01, 2017	REALIGN TO RING AND ARCH. PLANS

GENERAL:
1. CONTRACTOR(S) SHALL VERIFY SITE CONDITIONS.
2. NOTIFY THE DISORDER IMMEDIATELY OF ANY DISCREPANCY OR OMISSION.
3. CONTRACTOR(S) SHALL COMPLY WITH CONTRACT DOCUMENTS, PERFORMANCE REQUIREMENTS, AND ALL APPLICABLE LOCAL, STATE, AND FEDERAL REGULATIONS.
4. ALL MATERIALS SHALL MEET CODE.
5. THIS DRAWING AND THE INFORMATION SHOWN OR IMPLIED HEREIN CONSTITUTE THE ORIGINAL AND UNPUBLISHED WORK OF STUDIO K DESIGN COMPANY, AND MAY NOT BE USED OR DISCLOSED WITHOUT PRIOR WRITTEN CONSENT OF STUDIO K DESIGN COMPANY.
6. DO NOT SCALE DRAWINGS.

STUDIO K
DESIGN COMPANY
8853 213 Street
Langley, BC V1M 1Z3
604-619-4119
studiokdesign@outlook.com

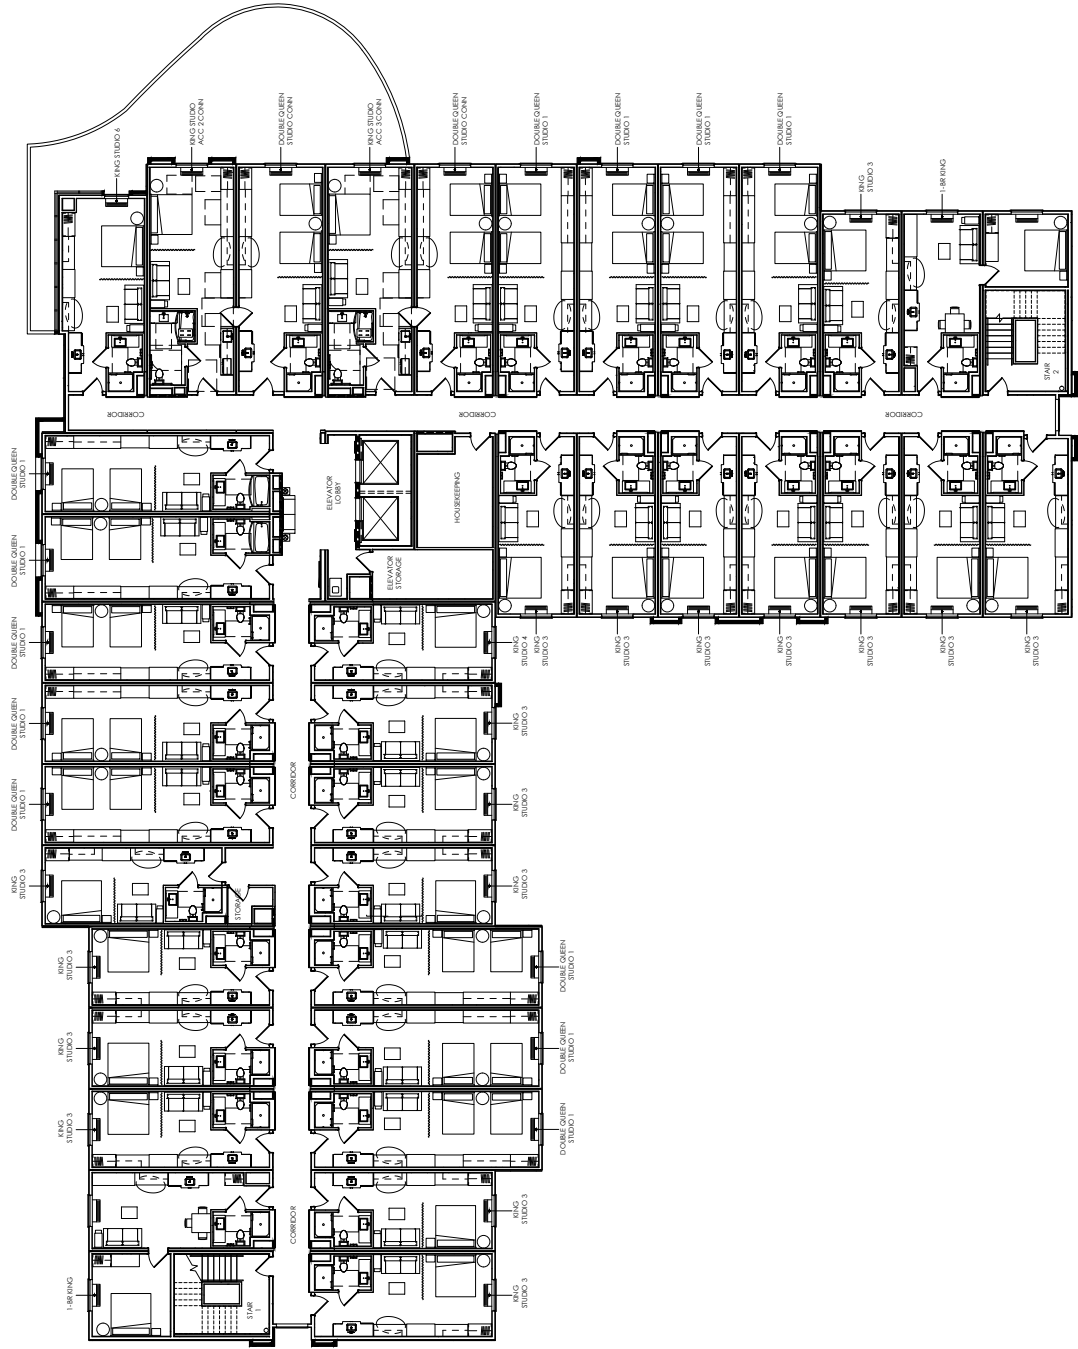

PROJECT:
HOME2 SUITES BY HILTON
550 GATEWAY BLVD.
SOUTH SAN FRANCISCO, CA

DRAWING:
SIXTH FLOOR PLAN
(DETAIL)

SCALE:
1/4" = 1'-0"

DATE: JULY 12, 2017

DRAWN BY:
K SUTHERLAND

DRAWING NUMBER:
ID1.02

REVISIONS:

REV #	DATE	NOTES
0	AUG 29, 2017	RELEASE FOR REVIEW

GENERAL:

1. CONTRACTOR(S) SHALL VERIFY SITE CONDITIONS.
2. NOTIFY THE DISCREPANCY IMMEDIATELY OF ANY DISCREPANCY OR OMISSION.
3. CONTRACTOR(S) SHALL COMPLY WITH CONTRACT DOCUMENTS, PERFORMANCE REQUIREMENTS, AND ALL APPLICABLE LOCAL, STATE, AND FEDERAL REGULATIONS.
4. ALL MATERIALS SHALL MEET CODE.
5. THIS DRAWING, AND THE INFORMATION SHOWN OR IMPLIED HEREIN, CONSTITUTE THE ORIGINAL AND UNPUBLISHED WORK OF STUDIO K DESIGN COMPANY, AND MAY NOT BE USED OR REPRODUCED WITHOUT PRIOR WRITTEN CONSENT OF STUDIO K DESIGN COMPANY.
6. DO NOT SCALE DRAWINGS.


STUDIO K


DESIGN COMPANY

8853 213 Street
Langley, BC V1M 1Z3

604-619-4119

studiokdesign@outlook.com

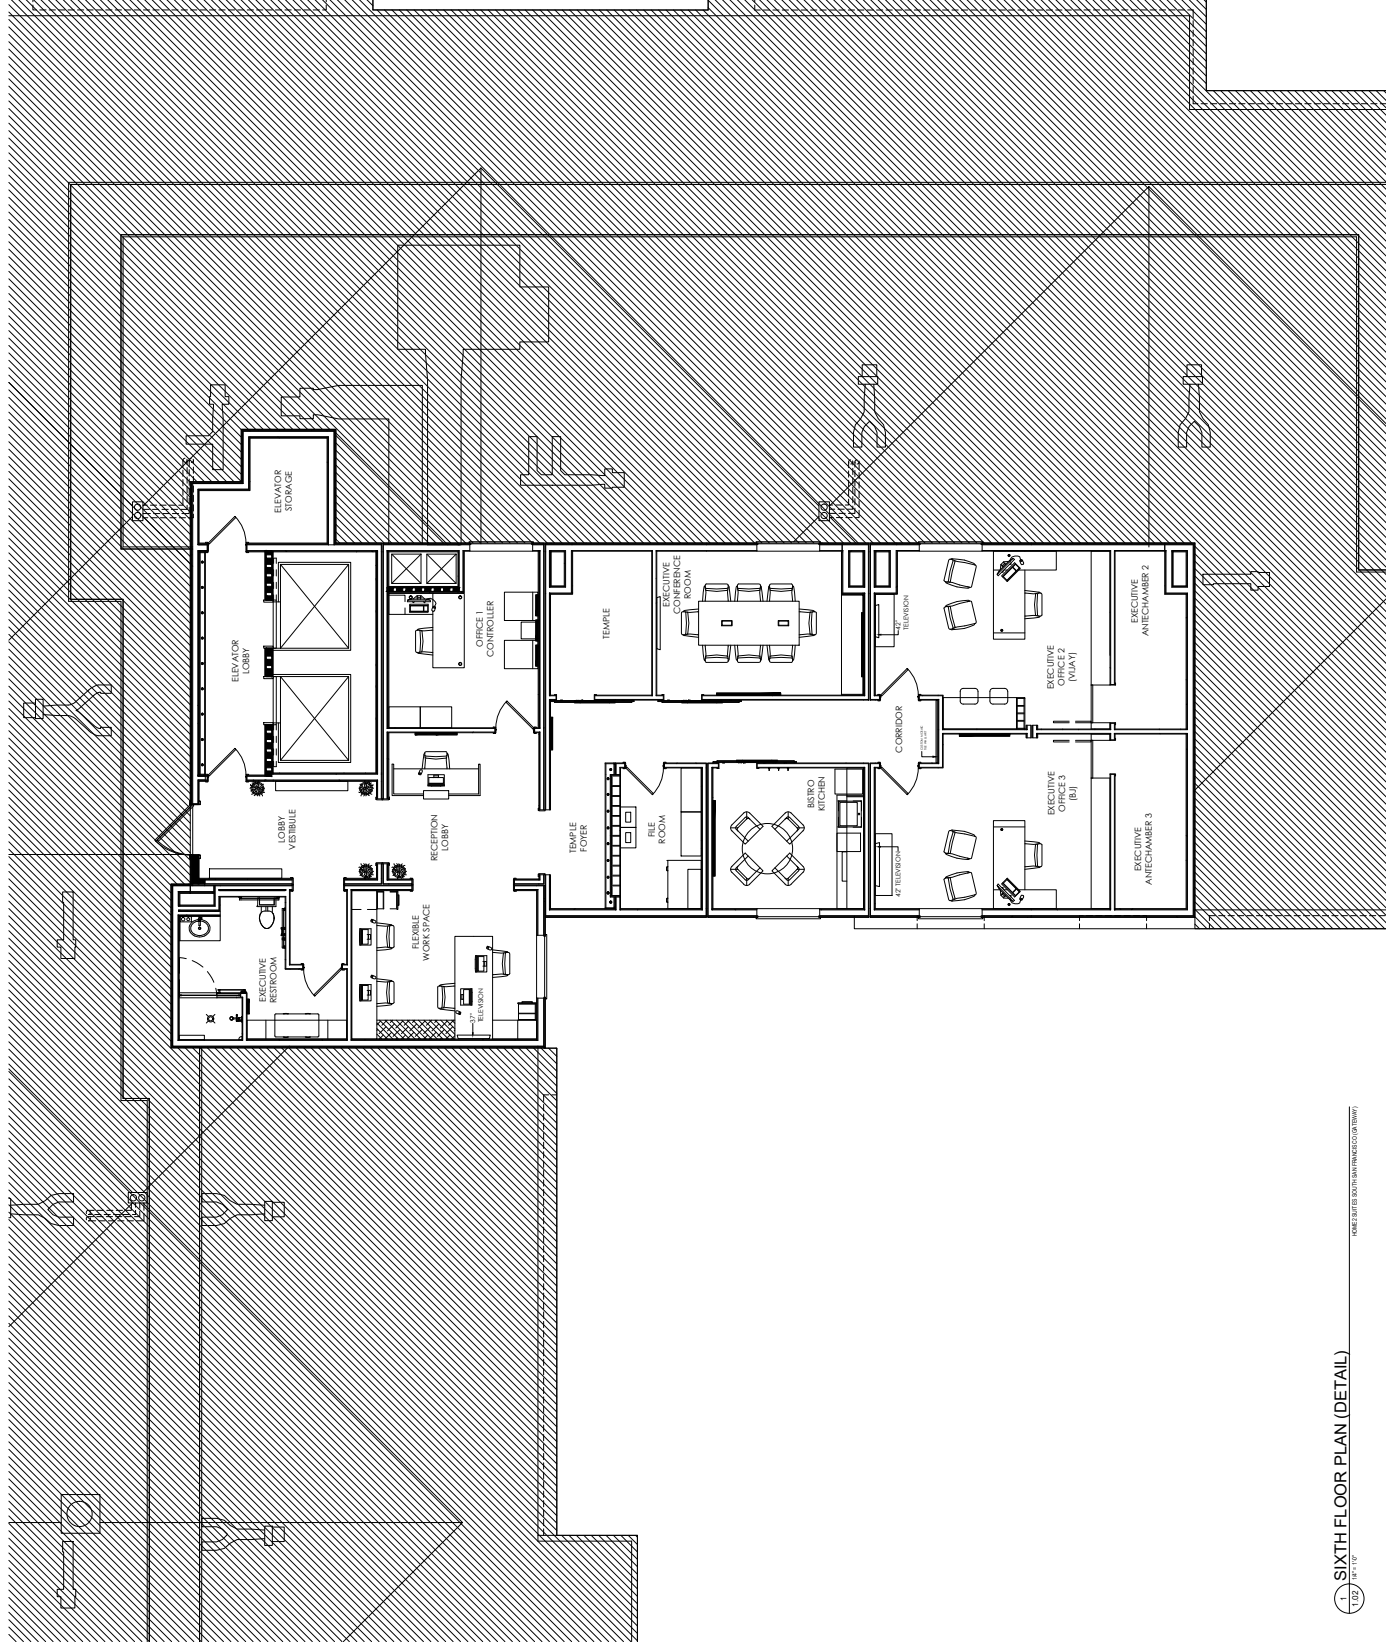

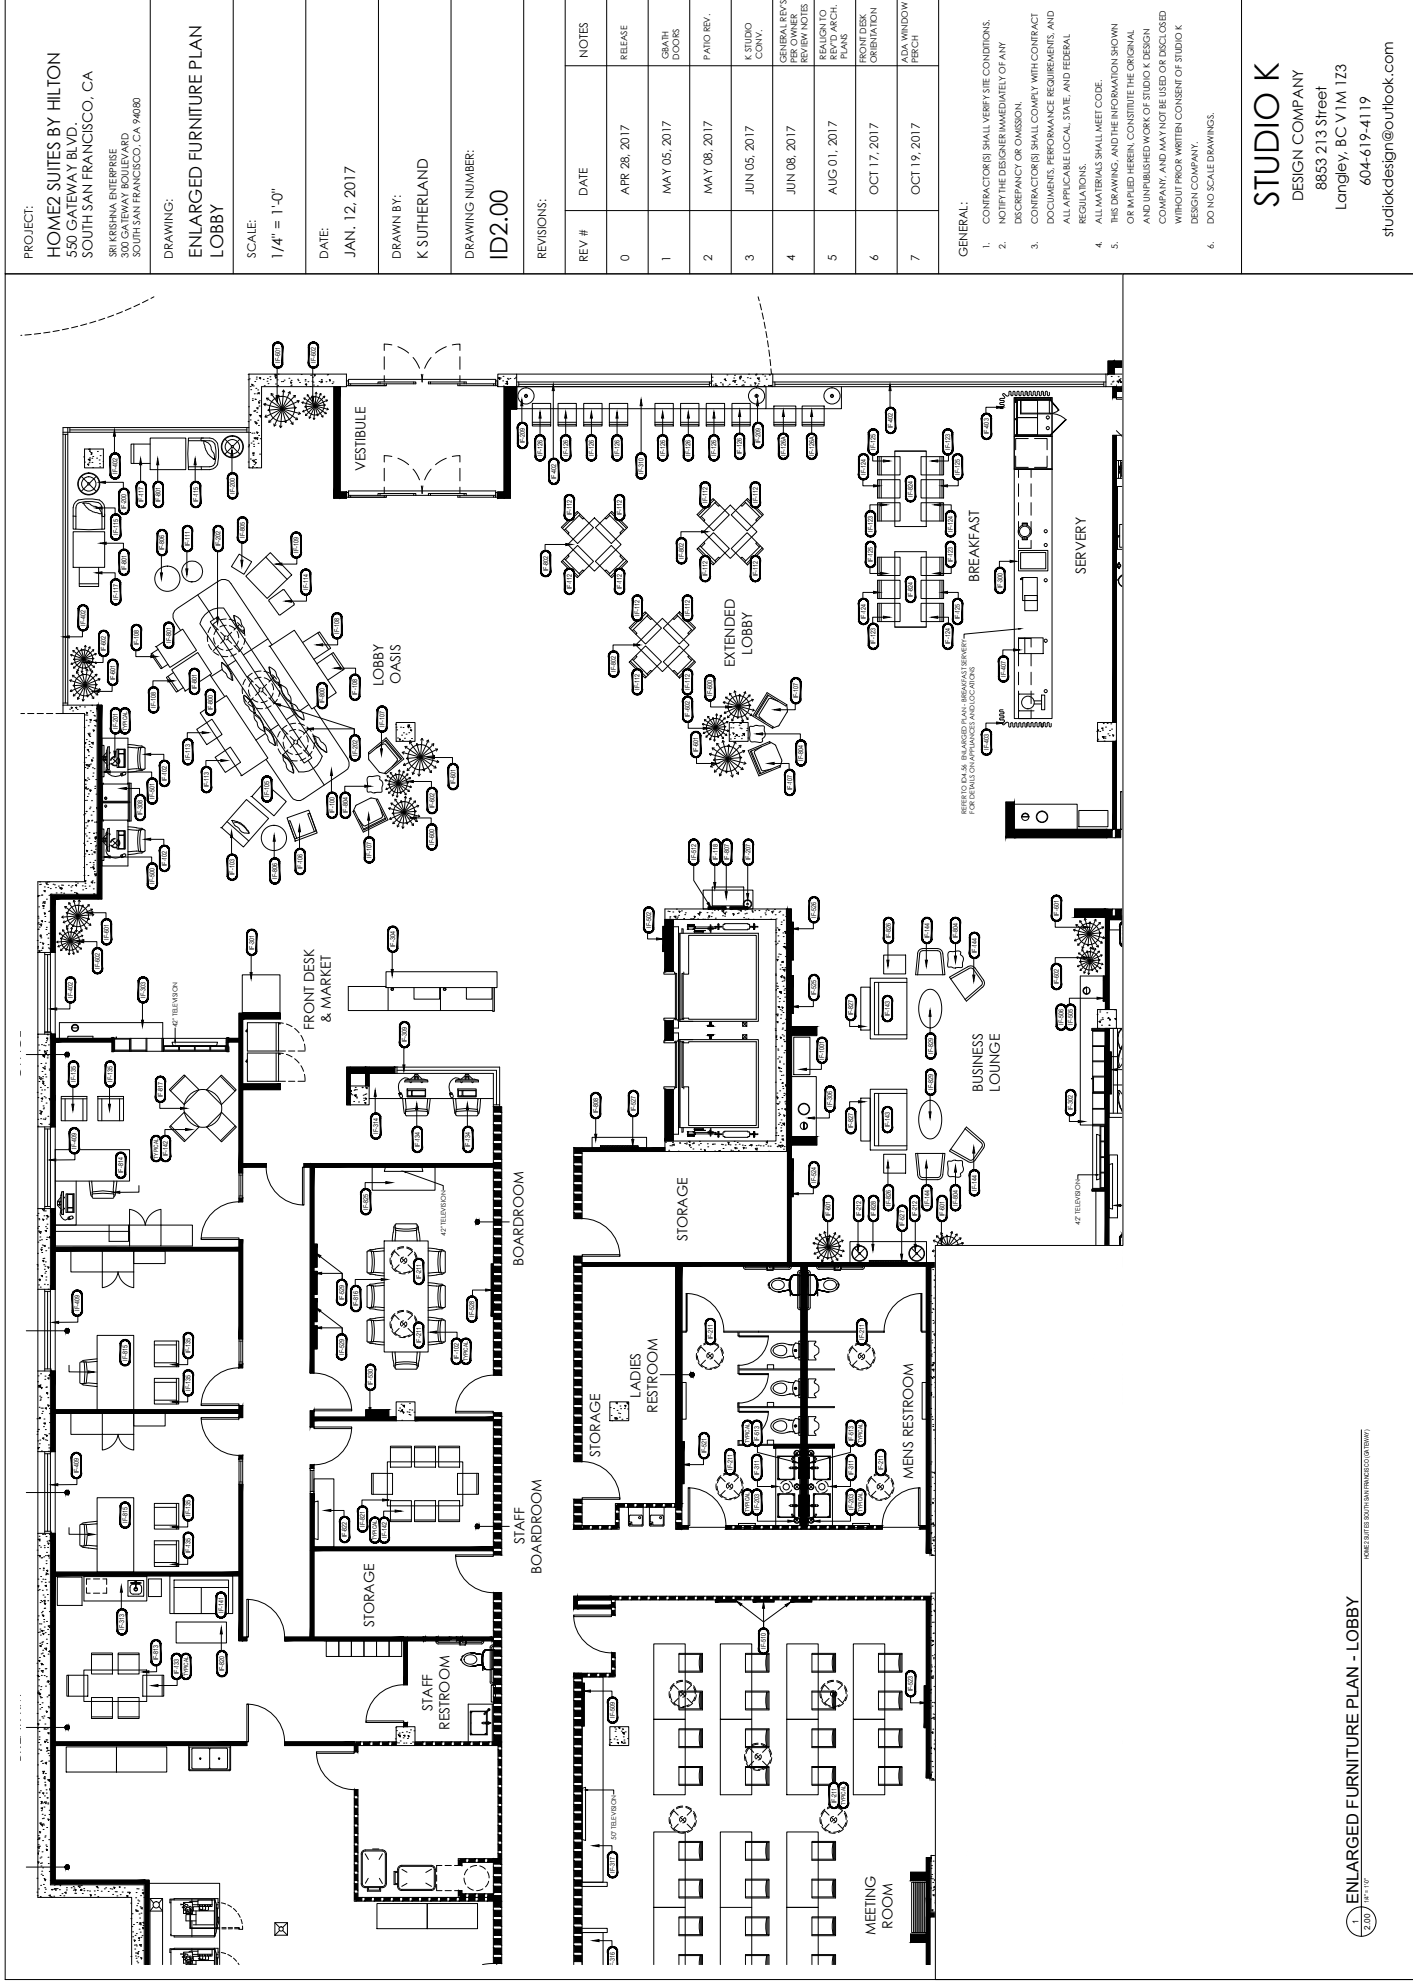

PROJECT:
HOME2 SUITES BY HILTON
550 GATEWAY BLVD.
SOUTH SAN FRANCISCO, CA

SRI KRISHNA ENTERPRISE
300 GATEWAY BOULEVARD
SOUTH SAN FRANCISCO, CA 94080

DRAWING:
ENLARGED PUBLIC AREA
PLANS

SCALE:
3/8" = 1'-0"

DATE: JAN. 12, 2017

DRAWN BY:
K SUTHERLAND

DRAWING NUMBER:
ID2.01

REVISIONS:


REV #	DATE	NOTES
0	APR 28, 2017	RELEASE
1	MAY 05, 2017	GRAPH DOORS
2	MAY 08, 2017	PATIO REV.
3	JUN 27, 2017	ADD PLAN DETAIL 4
4	AUG 01, 2017	FRANCH TO REV'D ARCH. PLANS

GENERAL:


1. CONTRACTOR(S) SHALL FURNISH THE CONDITIONS.
2. NOTIFY THE DESIGNER IMMEDIATELY OF ANY DISCREPANCY OR OMISSION.
3. CONTRACTOR(S) SHALL COMPLY WITH CONTRACT DOCUMENTS, PERFORMANCE REQUIREMENTS, AND ALL APPLICABLE LOCAL, STATE, AND FEDERAL REGULATIONS.
4. ALL MATERIALS SHALL MEET CODE.
5. THIS DRAWING, AND THE INFORMATION SHOWN OR IMPLIED HEREIN, CONSTITUTE THE ORIGINAL AND UNPUBLISHED WORK OF STUDIO K DESIGN COMPANY, AND MAY NOT BE REUSED OR DISCLOSED WITHOUT PRIOR WRITTEN CONSENT OF STUDIO K DESIGN COMPANY.
6. DO NOT SCALE DRAWINGS.

STUDIO K
DESIGN COMPANY

8853 213 Street
Langley, BC V1M 1Z3
604-619-4119
studiokdesign@outlook.com

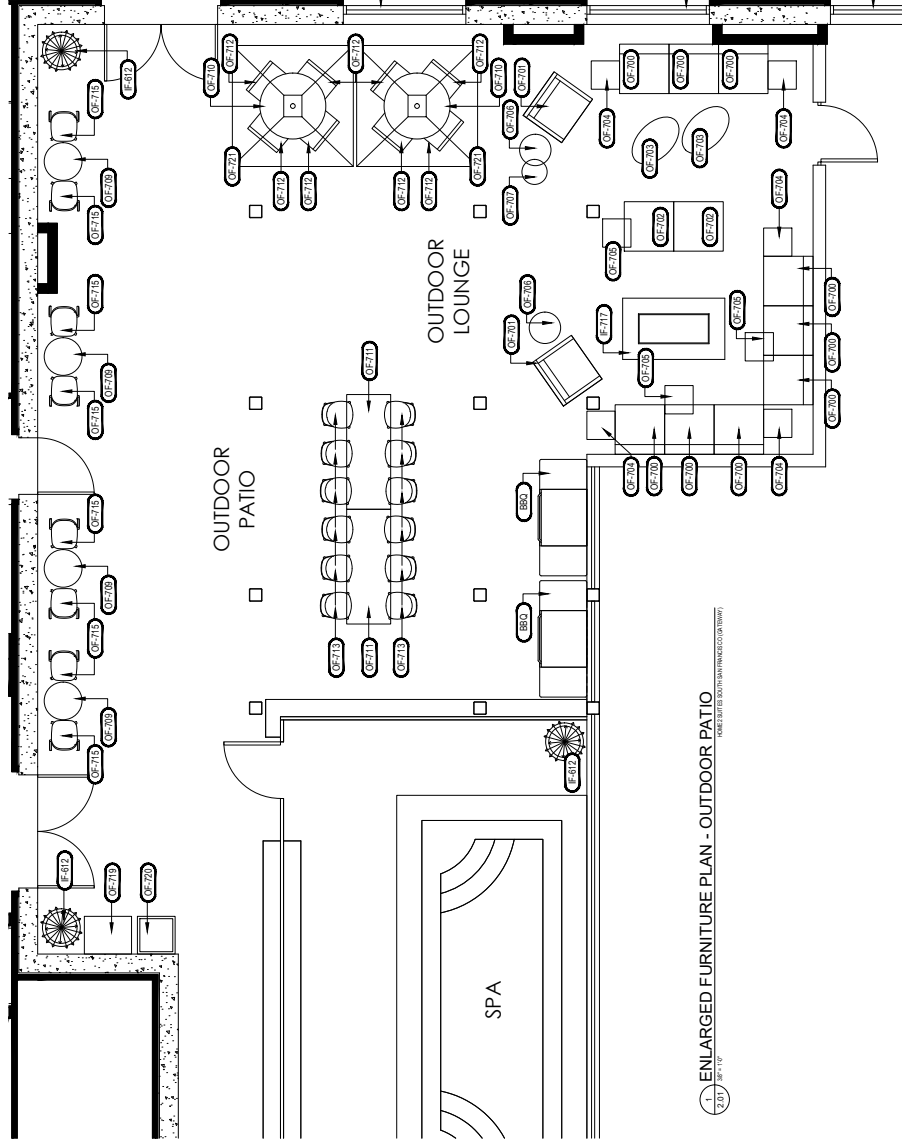

1 ENLARGED FURNITURE PLAN - OUTDOOR PATIO
2.01 36" x 1'0"

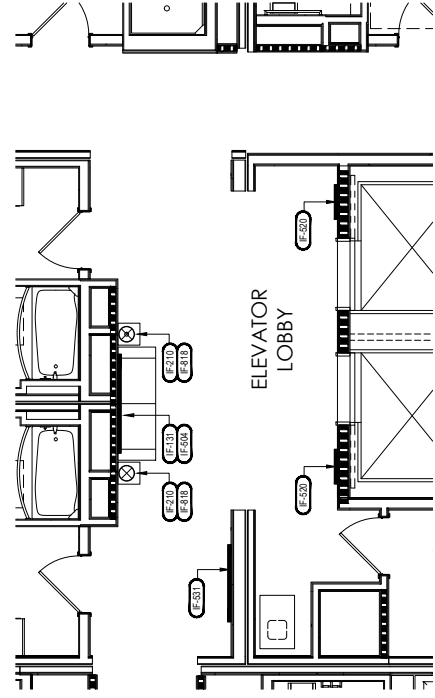

ENLARGED FURNITURE PLAN - UPPER LEVEL ELEV. LOBBY

PROJECT:
HOME2 SUITES BY HILTON
550 GATEWAY BLVD.
SOUTH SAN FRANCISCO, CA

DRAWING:
ENLARGED GAMES ROOM
PLAN DETAILS

SCALE:
3/8" = 1'-0"

DATE: JAN. 12, 2017

DRAWN BY:
K SUTHERLAND

DRAWING NUMBER:
ID2.02

REVISIONS:

REV #	DATE	NOTES
0	APR 28, 2017	RELEASE
1	JUN 10, 2017	REVISION PER BRAND REVIEW


GENERAL

1. CONTRACTOR SHALL VERIFY SITE CONDITIONS.
2. NOTIFY THE DESIGNER IMMEDIATELY OF ANY DISCREPANCY OR OMISSION.
3. CONTRACTOR SHALL COMPLY WITH CONTRACT DOCUMENTS, PERFORMANCE REQUIREMENTS, AND ALL APPLICABLE LOCAL, STATE, AND FEDERAL REGULATIONS.
4. ALL MATERIALS SHALL MEET CODE.
5. THIS DRAWING, AND THE INFORMATION SHOWN OR IMPLIED THEREON, CONSTITUTE THE ORIGINAL AND UNPUBLISHED WORK OF STUDIO K DESIGN COMPANY, AND MAY NOT BE USED OR DISCLOSED WITHOUT PRIOR WRITTEN CONSENT OF STUDIO K DESIGN COMPANY.
6. DO NO SCALE DRAWINGS.


STUDIO K
DESIGN COMPANY

8853 213 Street
Langley, BC V1M 1Z3
604-619-4119

studiokdesign@outlook.com

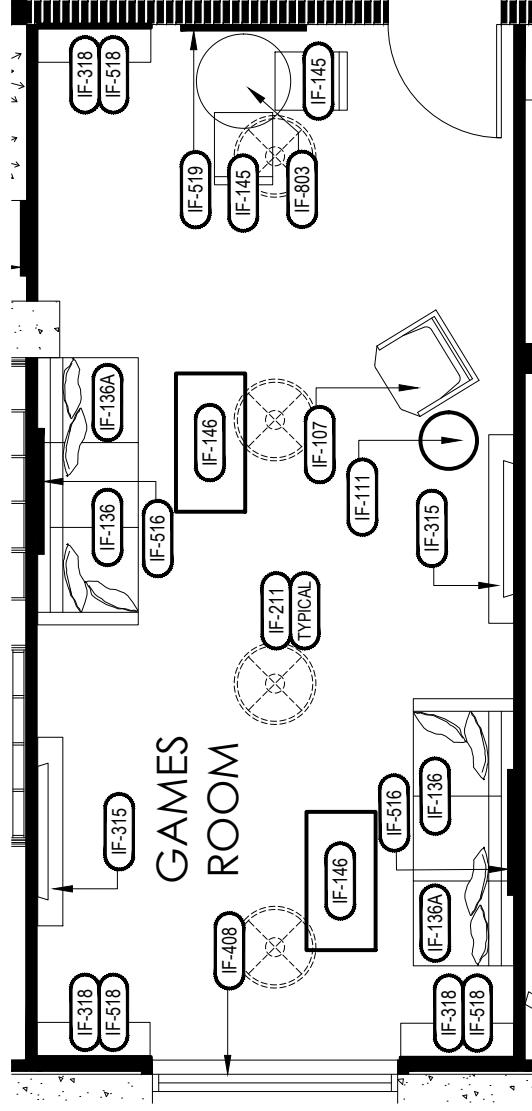

ENLARGED FURNITURE PLAN - GAMES ROOM

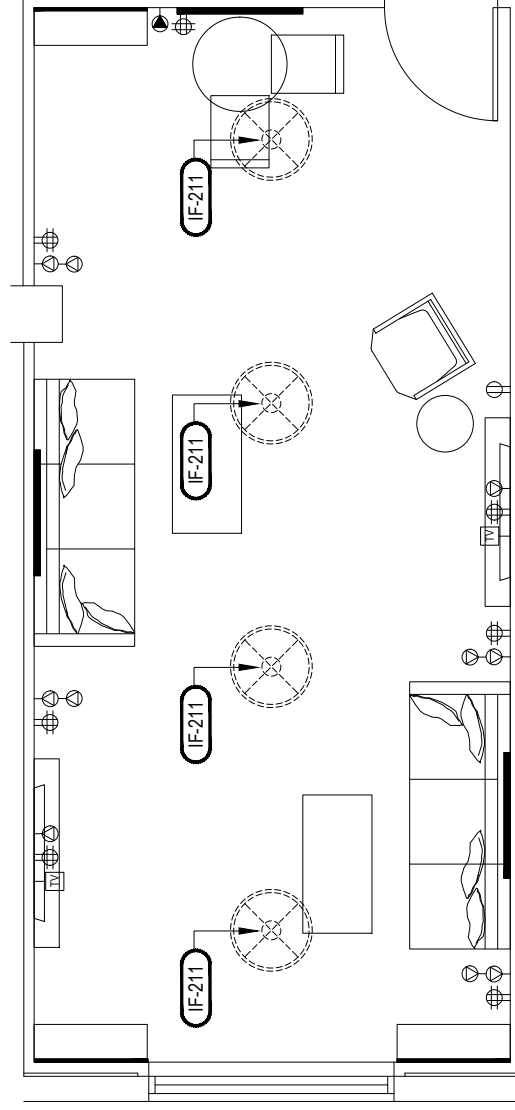

ENLARGED POWER & CABLE PLAN - GAMES ROOM

PROJECT:
HOME2 SUITES BY HILTON
550 GATEWAY BLVD.
SOUTH SAN FRANCISCO, CA

SRI KRISHNA ENTERPRISE
300 GATEWAY BOULEVARD
SOUTH SAN FRANCISCO, CA 94080

DRAWING:
INTERIOR ELEVATIONS

SCALE:
3/8" = 1'-0"

DATE: JAN. 12, 2017

DRAWN BY:
K SUTHERLAND

DRAWING NUMBER:
ID3.01

REVISIONS:


REV #	DATE	NOTES
0	APR 28, 2017	RELEASE
1	AUG 03, 2017	ALIGN TO ARCH. PLANS

GENERAL:


1. CONTRACTORS SHALL VERIFY SITE CONDITIONS.
2. NOTIFY THE DESIGNER IMMEDIATELY OF ANY DISCREPANCY OR OMISSION.
3. CONTRACTOR SHALL COMPLY WITH CONTRACT DOCUMENTS, PERFORMANCE REQUIREMENTS, AND ALL APPLICABLE LOCAL, STATE, AND FEDERAL REGULATIONS.
4. ALL MATERIALS SHALL MEET CODE.
5. THIS DRAWING, AND THE INFORMATION SHOWN OR IMPLIED THEREON, CONSTITUTE THE ORIGINAL AND UNPUBLISHED WORK OF STUDIO K DESIGN, AND MAY NOT BE USED OR DISCLOSED WITHOUT PRIOR WRITTEN CONSENT OF STUDIO K DESIGN COMPANY.
6. DO NOT SCALE DRAWINGS.
7. REFER TO ELECTRICAL PLANS FOR ALL VERIFIED OUTLET LOCATIONS.

STUDIO K
DESIGN COMPANY
8853 213 Street
Langley, BC V1M 1Z3

604-619-4119
studiokdesign@outlook.com

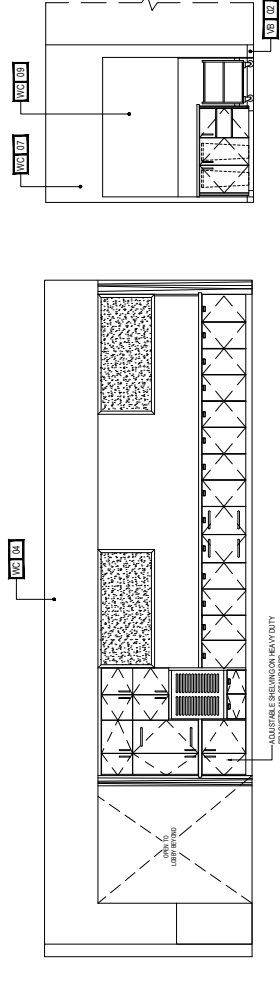


1 INTERIOR ELEVATION - BUFFET WORK SPACE

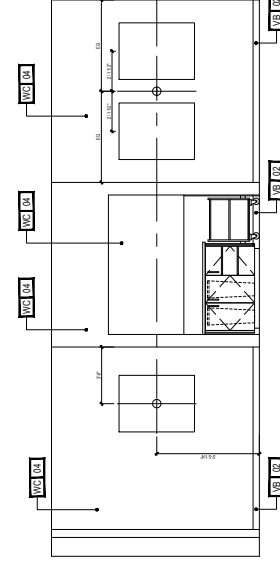


3.01 36" = 1'0" **INTERIOR ELEVATION - BUSINESS LOUNGE** HOTEL SU




2 INTERIOR ELEVATION - LOBBY
3.01 3/8" = 1'-0"
MOORE 2 SUITE S SOUTH SAN FRANCISCO CO. (CA TEXAS)

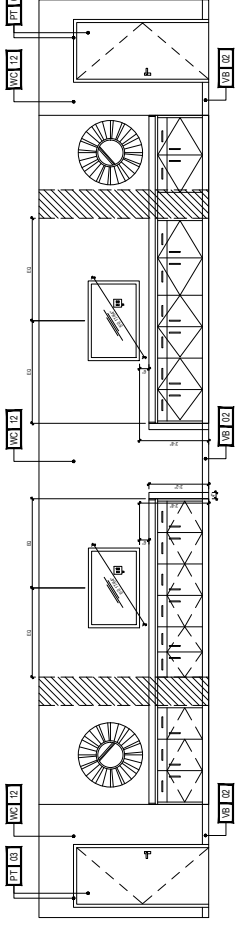


4 INTERIOR ELEVATION - MEETING ROOM 2.04 38" = 1:17

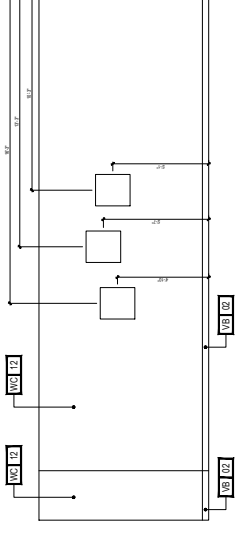


5 INTERIOR ELEVATION - MEETING ROOM
2.04 3/8" = 1'-0"

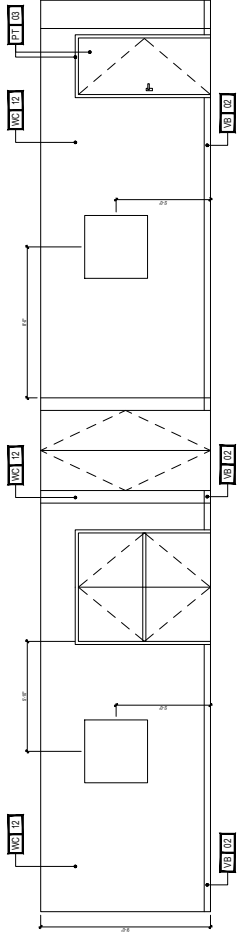


6 INTERIOR ELEVATION - MEETING ROOM
3/10 3/10 = 1/2 HOMER SUITES SOLE

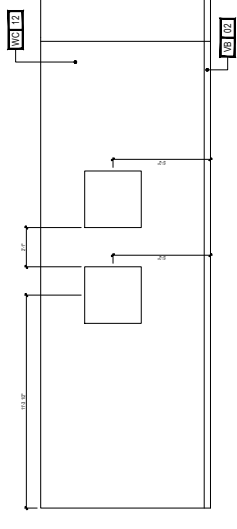


7 INTERIOR ELEVATION - MEETING ROOM

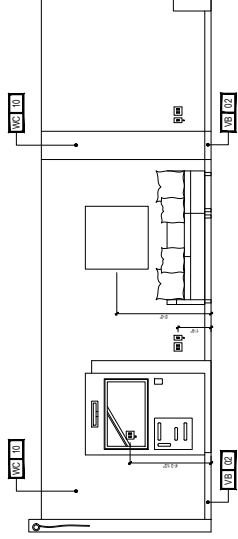

8 INTERIOR ELEVATION - GAMES ROOM
3.01 35" x 1'0"

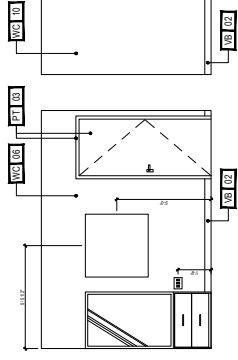


9 INT. ELEV. - GAMES ROOM
3.01 36" x 1'-0" HOMER'S SUITE SOUTH EASY FRANK SCOTT WAY

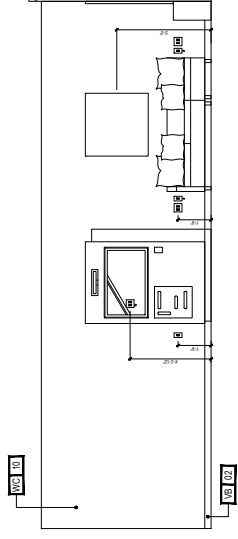

10
3.01 30' x 12'

INTERIOR ELEVATION - GAMES ROOM

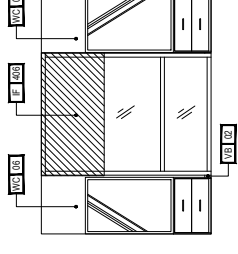

11 INT. ELEV. - GAMES ROOM
3.01 38" x 1'-0" HOMER BLUES SOUTH SAN FRANCISCO (GATEWAY)

PROJECT:
HOME2 SUITES BY HILTON
550 GATEWAY BLVD.
SOUTH SAN FRANCISCO, CA

SRI KRISHNA ENTERPRISE
300 GATEWAY BOULEVARD
SOUTH SAN FRANCISCO, CA 94080

DRAWING:
INTERIOR ELEVATIONS

SCALE:
3/8" = 1'-0"

DATE: JAN. 12, 2017

DRAWN BY:
K SUTHERLAND

DRAWING NUMBER:
ID3.02

REVISIONS:

REV #	DATE	NOTES
0	APR 28, 2017	RELEASE
1	AUG 03, 2017	ALIGN TO FACIL PLANS

GENERAL:


1. CONTRACTOR(S) SHALL FULFILL THE CONDITIONS.
2. NOTIFY THE DESIGNER IMMEDIATELY OF ANY DEFICIENCY OR OMISSION.
3. CONTRACTOR(S) SHALL COMPLY WITH CONTRACT DOCUMENTS, PERFORMANCE REQUIREMENTS, AND ALL APPLICABLE LOCAL, STATE, AND FEDERAL REGULATIONS.
4. ALL MATERIALS SHALL MEET CODE.
5. THIS DRAWING, AND THE INFORMATION SHOWN OR IMPLIED THEREON, CONSTITUTE THE ORIGINAL AND UNPUBLISHED WORK OF STUDIO K DESIGN AND COMPANY, AND MAY NOT BE USED OR DISCLOSED WITHOUT PRIOR WRITTEN CONSENT OF STUDIO K DESIGN COMPANY.
6. DO NO SCALE DRAWINGS.
7. REFER TO ELECTRICAL PLANS FOR ALL VERIFIED OUTLET LOCATIONS.

STUDIO K


DESIGN COMPANY
8853 213 Street
Langley, BC V1M 1Z3

604-619-4119


studiokdesign@outlook.com

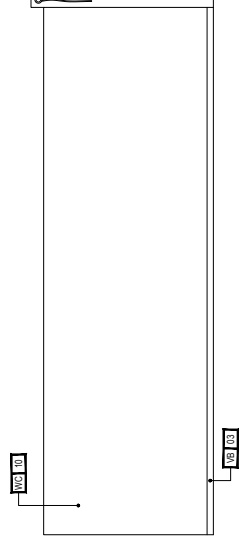


3 INTERIOR ELEVATION - FITNESS

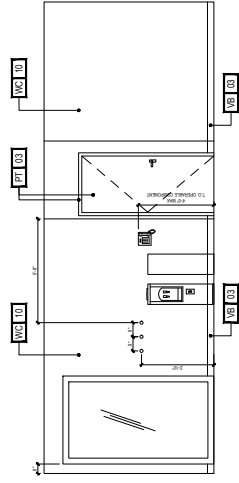


2 INTERIOR ELEVATION - FITNESS

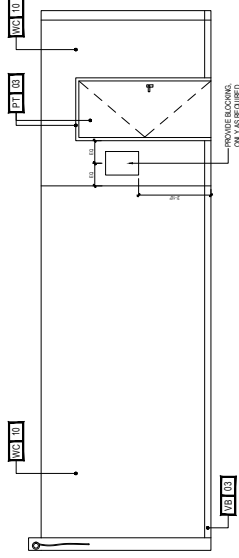


① INTERIOR ELEVATION - FITNESS

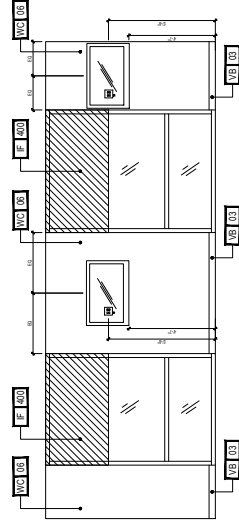


4 INTERIOR ELEVATION - FITNESS

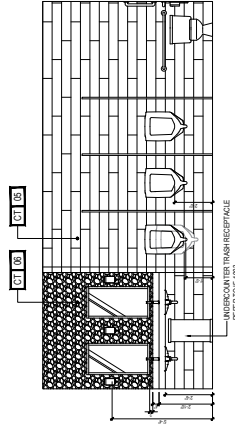


5 INTERIOR ELEVATION - MENS PUBLIC RESTROOM

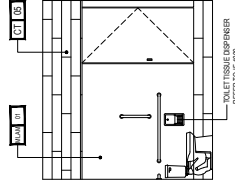


6 MENS RESTROOM

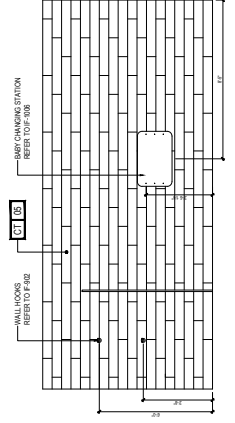


7 MENS RESTROOM

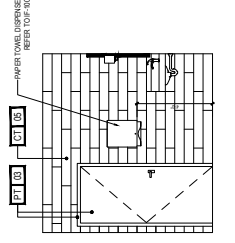


8 MENS RESTROOM

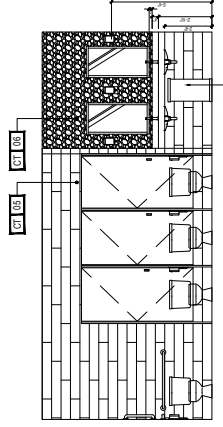


INTERIOR ELEVATION - LADIES PUBLIC RESTROOM

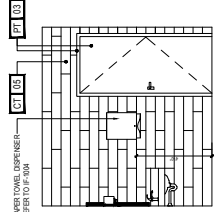

10 LADIES RESTROOM

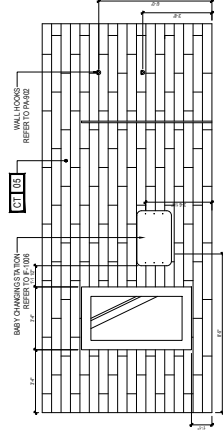

11 LADIES RESTROOM

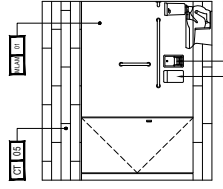

12 LADIES RESTROOM

PROJECT:
HOME2 SUITES BY HILTON
550 GATEWAY BLVD.
SOUTH SAN FRANCISCO, CA

SRI KRISHNA ENTERPRISE
300 GATEWAY BOULEVARD
SOUTH SAN FRANCISCO, CA 94080

DRAWING:

- MEDIA WALL DETAILS
- BOARDROOM
- STAFF RESTROOM

SCALE:
VARIES

DATE: JAN. 12, 2017

DRAWN BY:
K SUTHERLAND

DRAWING NUMBER:
ID3.04

REVISIONS:

REV #	DATE	NOTES
0	APR 28, 2017	RELEASE
1	AUG 03, 2017	ALIGN TO LOCAL PLANS
2	AUG 24, 2017	TRANSFER REV.

GENERAL:

1. CONTRACTOR(S) SHALL VERIFY SITE CONDITIONS.
2. NOTIFY THE DESIGNER IMMEDIATELY OF ANY DISCREPANCY OR OMISSION.
3. CONTRACTOR(S) SHALL COMPLY WITH CONTRACT DOCUMENTS, PERFORMANCE REQUIREMENTS, CONDITIONS, SPECIFICATIONS, AND ALL APPLICABLE LOCAL, STATE, AND FEDERAL REGULATIONS.
4. ALL DRAWINGS SHALL MEET CODE.
5. ALL MATERIALS SHALL BE INFORMATION SHOWN OR IMPLIED HEREIN, CONSTITUTE THE ORIGINAL AND UNPUBLISHED WORK OF STUDIO C DESIGN COMPANY, AND MAY NOT BE USED OR DISCLOSED WITHOUT PRIOR WRITTEN CONSENT OF STUDIO C DESIGN COMPANY.
6. DO NO SCALE DRAWINGS.
7. REFER TO ELECTRICAL PLANS FOR ALL VERIFIED OUTLET LOCATIONS.


 




STUDIO K

DESIGN COMPANY

8853 213 Street
Langley, BC V1M 1Z3

604-619-4119

studiokdesign@outlook.com

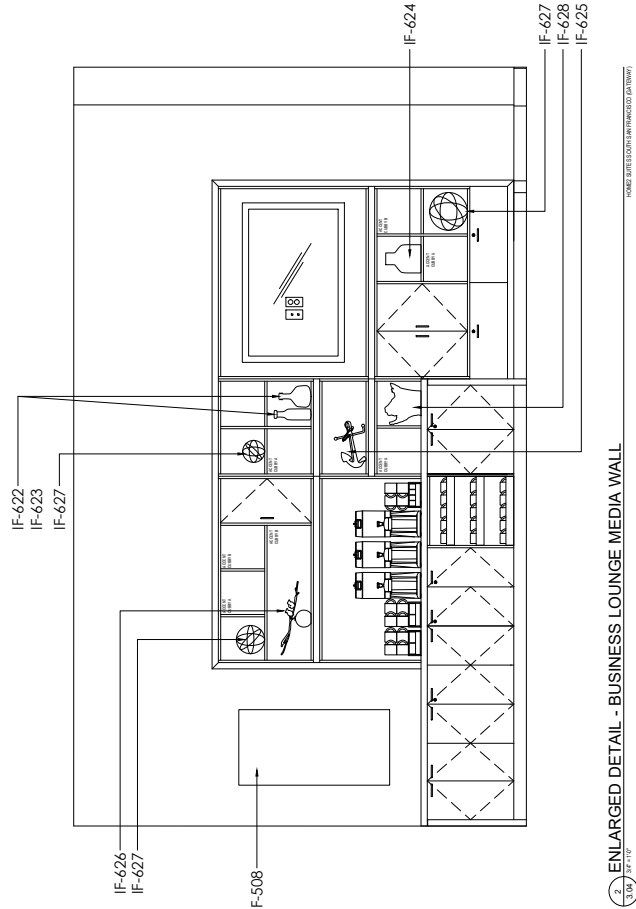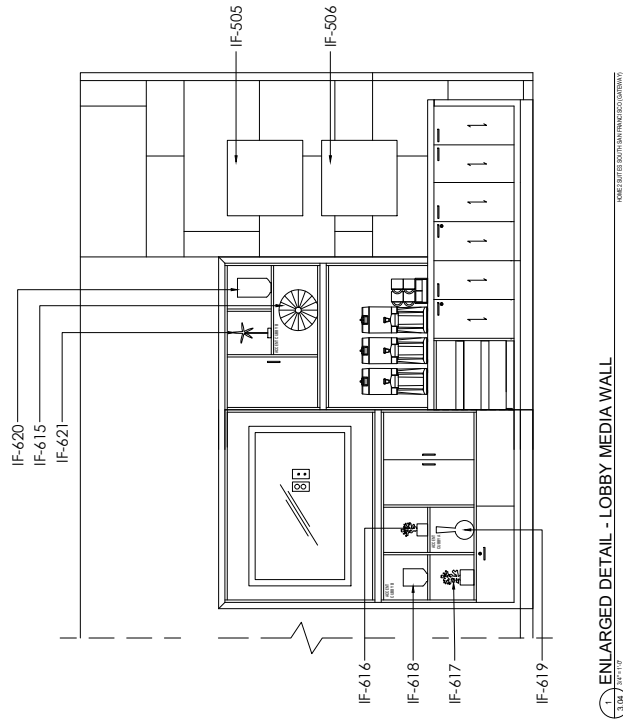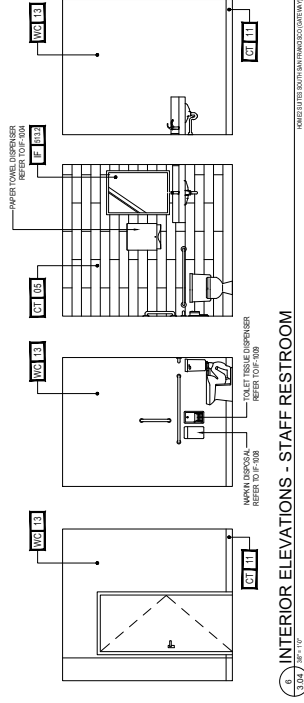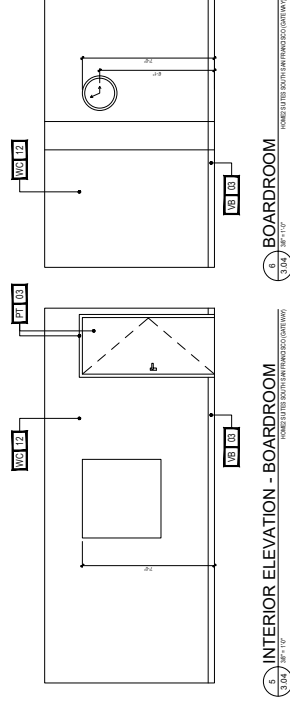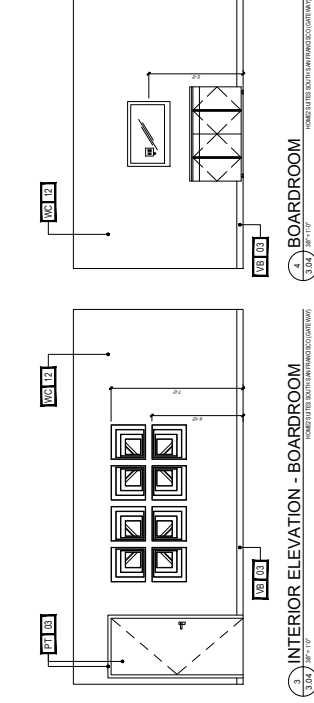

PROJECT:
HOME2 SUITES BY HILTON
550 GATEWAY BLVD.
SOUTH SAN FRANCISCO, CA

DRAWING:
INTERIOR ELEVATIONS
PENTHOUSE - 6TH FLR

SCALE:
1/2" = 1'-0"

DATE: JAN. 12, 2017

DRAWN BY:
K SUTHERLAND

DRAWING NUMBER:
ID3.05

REVISIONS:

REV #	DATE	NOTES
0	AUG 29, 2017	RELEASED

GENERAL:

1. CONTRACTORS SHALL VERIFY SITE CONDITIONS.
2. NOTIFY THE DESIGNER IMMEDIATELY OF ANY DISCREPANCY OR OMISSION.
3. CONTRACTORS SHALL COMPLY WITH CONTRACT DOCUMENTS, PERFORMANCE REQUIREMENTS, AND ALL APPLICABLE LOCAL, STATE, AND FEDERAL REGULATIONS.
4. ALL MATERIALS SHALL MEET CODE.
5. THIS DRAWING, AND THE INFORMATION SHOWN OR IMPLIED THEREON, CONSTITUTE THE ORIGINAL AND UNPUBLISHED WORK OF STUDIO K DESIGN AND COMPANY, AND MAY NOT BE USED OR DISCLOSED WITHOUT PRIOR WRITTEN CONSENT OF STUDIO K DESIGN COMPANY.
6. DO NO SCALE DRAWINGS.
7. REFER TO ELECTRICAL PLANS FOR ALL VERIFIED OUTLET LOCATIONS.





STUDIO K

DESIGN COMPANY




8853 213 Street
Langley, BC V1M 1Z3

604-619-4119



studiokdesign@outlook.com

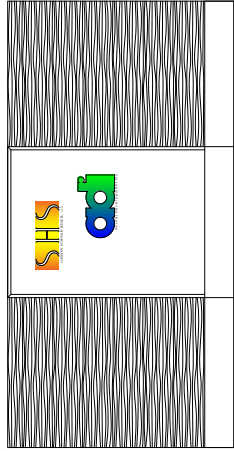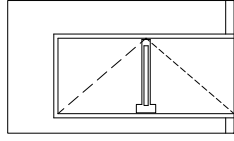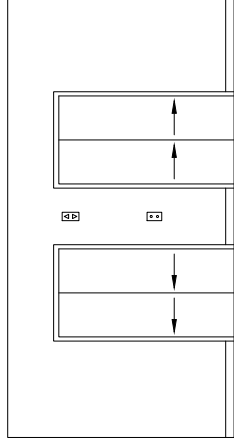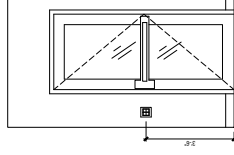

INTERIOR ELEVATION - ELEVATOR LOBBY

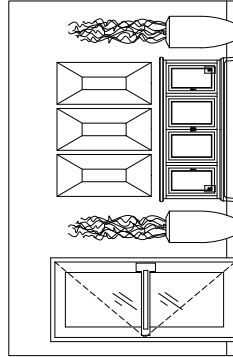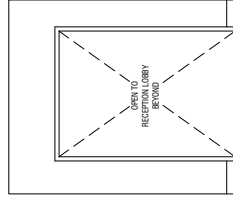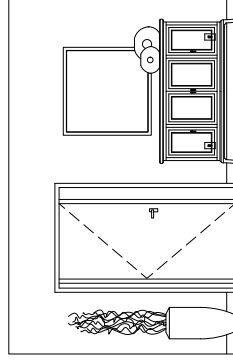

INTERIOR ELEVATION - LOBBY VESTIBULE

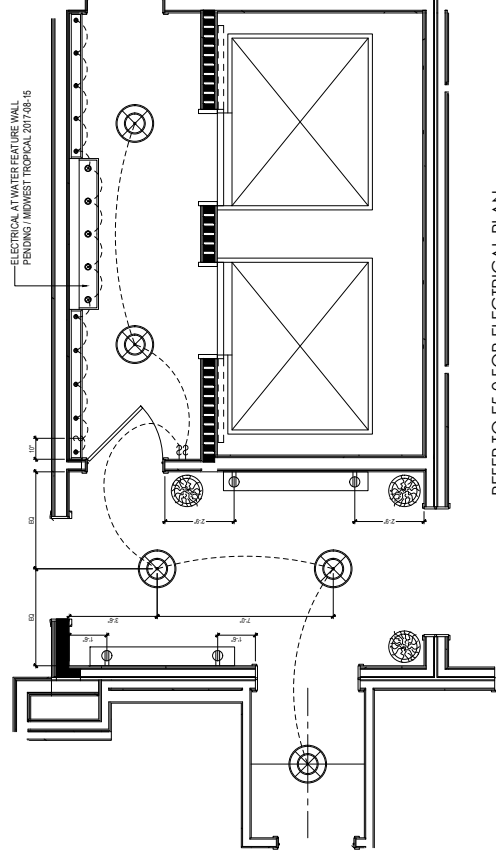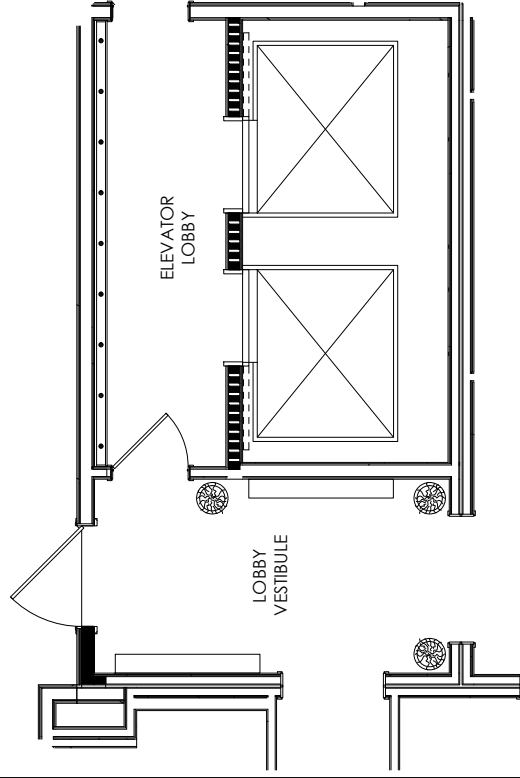


REFER TO E5.0 FOR ELECTRICAL PLAN

3 FURNITURE PLAN - DETAIL

4 ELECTRICAL & RCP - GENERAL


HOME 29 JUL 8 00:17H SAN FRANCISCO CALIFORNIA 05ND0100

HOME2 GUTTERS & DOWNSPUTS

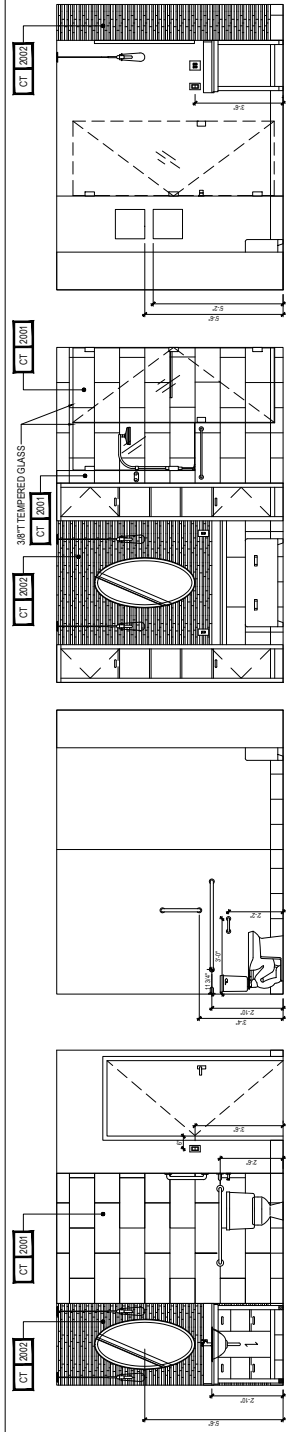


1.30 1/2" = 1'-0"
INTERIOR ELEVATION - EXECUTIVE RESTROOM

HOMES SUITES SOUTH SAN FRANCISCO GATEWAY - PENTHOUSE

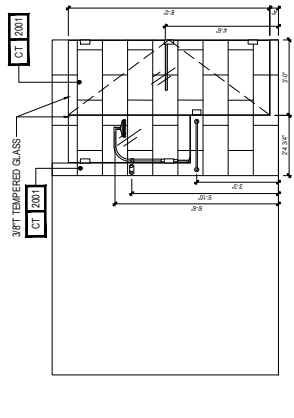

2.30 1/2" = 1'-0"
INTERIOR ELEVATION - SHOWER DETAIL

HOMES SUITES SOUTH SAN FRANCISCO GATEWAY - PENTHOUSE

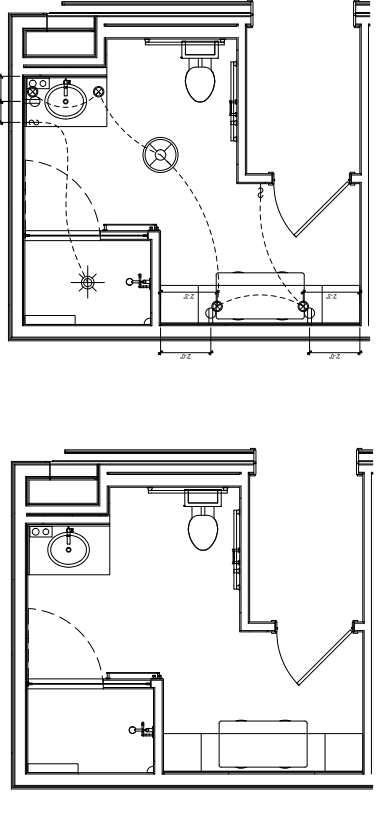

3.30 1/2" = 1'-0"
FURNITURE PLAN - DETAIL

HOMES SUITES SOUTH SAN FRANCISCO GATEWAY - PENTHOUSE

REFER TO E5.0 FOR ELECTRICAL PLAN

4.30 1/2" = 1'-0"
ELECTRICAL & RCP - GENERAL

HOMES SUITES SOUTH SAN FRANCISCO GATEWAY - PENTHOUSE

PROJECT: HOMES SUITES BY HILTON 550 GATEWAY BLVD. SOUTH SAN FRANCISCO, CA 80 VESPAIA ENTERPRISE 300 GATEWAY BOULEVARD SOUTH SAN FRANCISCO, CA 94080	
DRAWING: INTERIOR ELEVATIONS PENTHOUSE - 6TH FLR	
SCALE: 1/2" = 1'-0"	
DATE: JAN. 12, 2017	
DRAWN BY: K SUTHERLAND	
DRAWING NUMBER: ID3.06	
REVISIONS:	
REV #	DATE
0	AUG 29, 2017
NOTES	
RELEASE FOR REVIEW	
GENERAL: 1. CONTRACTOR(S) SHALL VERIFY SITE CONDITIONS. 2. NOTIFY THE DESIGNER IMMEDIATELY OF ANY DISCREPANCY OR OMISSION. 3. CONTRACTOR(S) SHALL COMPLY WITH CONTRACT DOCUMENTS, PERFORMANCE REQUIREMENTS, AND ALL APPLICABLE LOCAL, STATE, AND FEDERAL REGULATIONS. 4. ALL MATERIALS SHALL MEET CODE. 5. THIS DRAWING, AND THE INFORMATION SHOWN OR IMPLIED HEREIN, CONSTITUTE THE ORIGINAL AND UNPUBLISHED WORK OF STUDIO K DESIGN COMPANY, AND MAY NOT BE USED OR DISCLOSED WITHOUT PRIOR WRITTEN CONSENT OF STUDIO K DESIGN COMPANY. 6. DO NOT SCALE DRAWINGS. 7. REFER TO ELECTRICAL PLANS FOR ALL VERIFIED OUTLET LOCATIONS.	
STUDIO K DESIGN COMPANY 8853 213 Street Langley, BC V1M 1Z3 604-619-4119 studiokdesign@outlook.com	

PROJECT:
HOME2 SUITES BY HILTON
550 GATEWAY BLVD.
SOUTH SAN FRANCISCO, CA

DRAWING:
INTERIOR ELEVATIONS
PENTHOUSE - 6TH FLR

SCALE:
1/2" = 1'-0"

DATE: JAN. 12, 2017

DRAWN BY:
K SUTHERLAND

DRAWING NUMBER:
ID3.07

REVISIONS:

REV #	DATE	NOTES
0	AUG 29, 2017	RELEASE FOR REVIEW

GENERAL:

1. CONTRACTOR(S) SHALL VERIFY SITE CONDITIONS.
2. NOTIFY THE DISORDER IMMEDIATELY OF ANY DEFICIENCY OR OMISSION.
3. CONTRACTOR(S) SHALL COMPLY WITH CONTACT DOCUMENTS, PERFORMANCE REQUIREMENTS, AND ALL APPLICABLE LOCAL, STATE, AND FEDERAL REGULATIONS.
4. ALL MATERIALS SHALL MEET CODE.
5. THIS DRAWING, AND THE INFORMATION SHOWN ORIMATED HEREIN, CONSTITUTE THE ORIGINAL AND UNPUBLISHED WORK OF STUDIO K DESIGN COMPANY, AND MAY NOT BE USED OR DISCLOSED WITHOUT PRIOR WRITTEN CONSENT OF STUDIO K DESIGN COMPANY.
6. DO NOT SCALE DRAWINGS.
7. REFER TO ELECTRICAL PLANS FOR ALL VERIFIED OUTLET LOCATIONS.


STUDIO K

DESIGN COMPANY


8853 213 Street
Langley, BC V1M 1Z3

604-619-4119

studiokdesign@outlook.com

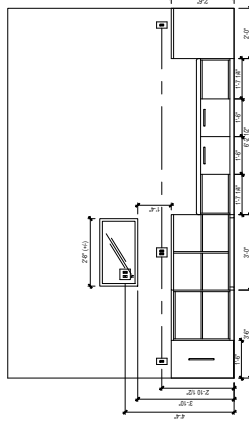


4
3.07
17' = 1'-0"

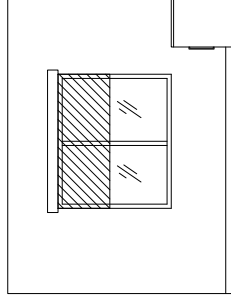


3.07' 12" = 1'-0"

ELEVATION - FLEXIBLE OFFICE


HOMER 3013 SOUTH MAIN FRANKS CO. GATEWAY - PENTHOUSE

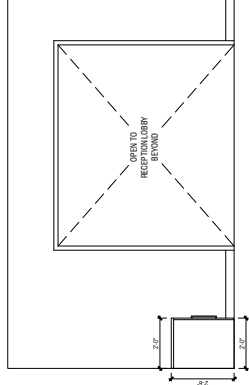


2 ELEVATION - FLEXIBLE OFFICE
3.07 1/2" = 1'-0"
HOTEL 11111 SOUTH SAN FRANCISCO AVENUE, PENTHOUSE

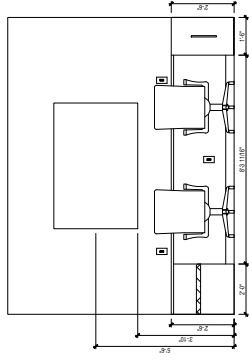

1 ELEVATION - FLEXIBLE OFFICE
3.07 12" = 1'-0"
HOME2 SUITES SOUTH SAN FRANCISCO GATEWAY, PENTHOUSE

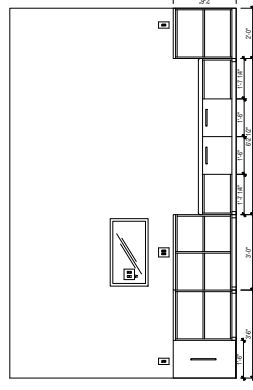


7 INTERIOR ELEVATION - CASEWORK DETAIL
HOME 2 BUILT BY SOUTH SAN FRANCISCO (GATEWAY) - PLANT HOUSE
3.07' 1/2" x 14"

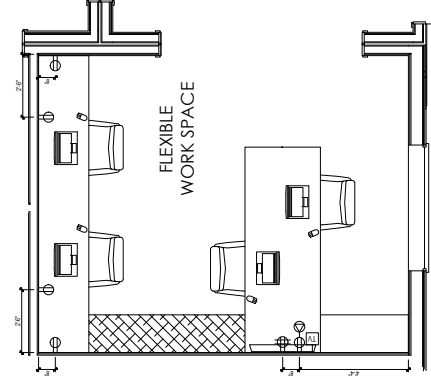

REFER TO E5.0 FOR ELECTRICAL PLAN

6 ELECTRICAL & RCP - GENERAL 307 1/2" x 11"

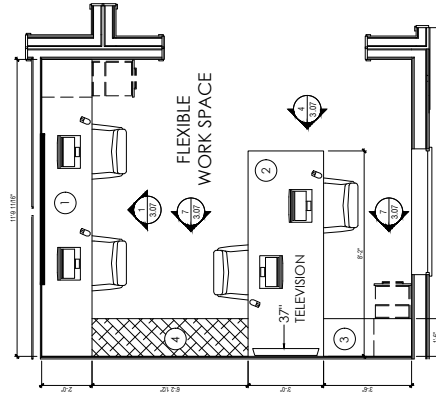

5 FURNITURE PLAN - DETAIL
3.07 1/2" = 1'-0"

PROJECT:
HOME2 SUITES BY HILTON
550 GATEWAY BLVD.
SOUTH SAN FRANCISCO, CA

DRAWING:
INTERIOR ELEVATIONS
PENTHOUSE - 6TH FLR

SCALE:
1/2" = 1'-0"

DATE: JAN. 12, 2017

DRAWN BY:
K SUTHERLAND

DRAWING NUMBER:
ID3.08

REVISIONS:

REV #	DATE	NOTES
0	AUG 29, 2017	RELEASE FOR REVIEW

GENERAL:

1. CONTRACTOR SHALL VERIFY SITE CONDITIONS.
2. NOTIFY THE DESIGNER IMMEDIATELY OF ANY DISCREPANCY OR OMISSION.
3. CONTRACTOR SHALL COMPLY WITH CONTRACT DOCUMENTS, PERFORMANCE REQUIREMENTS, AND ALL APPLICABLE LOCAL, STATE, AND FEDERAL REGULATIONS.
4. ALL MATERIALS SHALL MEET CODE.
5. THIS DRAWING, AND THE INFORMATION SHOWN OR IMPLIED THEREON, CONSTITUTE THE ORIGINAL AND UNPUBLISHED WORK OF STUDIO K DESIGN COMPANY, AND MAY NOT BE USED OR DISCLOSED WITHOUT PRIOR WRITTEN CONSENT OF STUDIO K DESIGN COMPANY.
6. DO NO SCALE DRAWINGS.
7. REFER TO ELECTRICAL PLANS FOR ALL VERIFIED OUTLET LOCATIONS.


STUDIO K

DESIGN COMPANY


8853 213 Street
Langley, BC V1M 1Z3

604-619-4119


studiokdesign@outlook.com

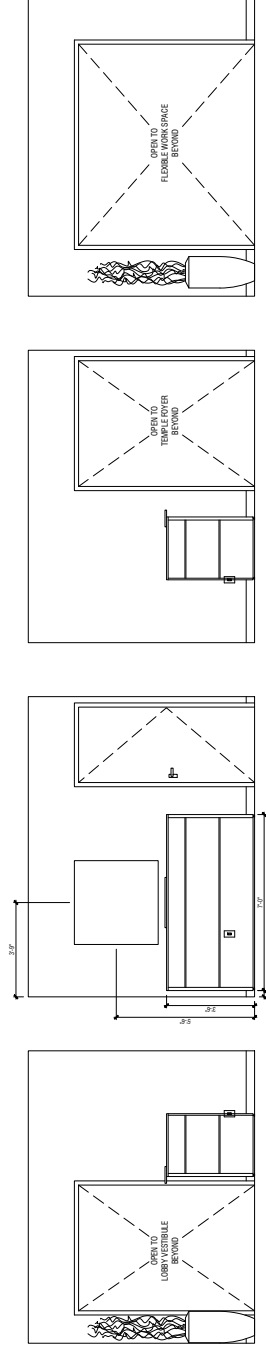


1 INTERIOR ELEVATION - RECEPTION LOBBY 3/08 1/2"=1'-0"

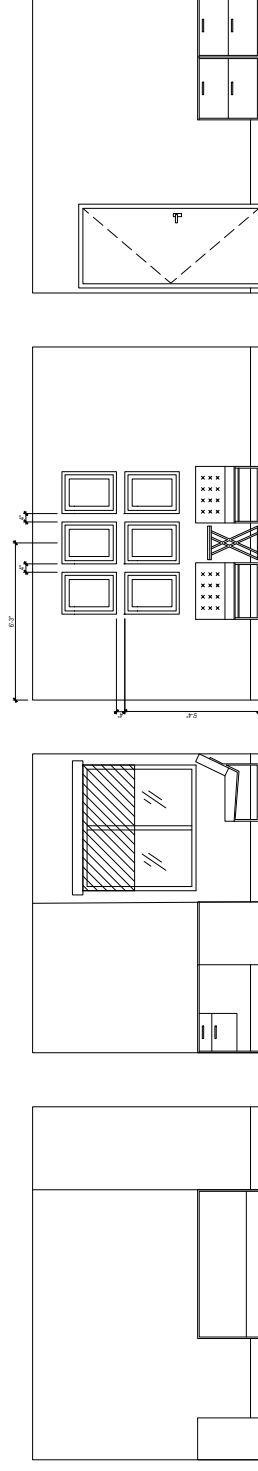


2 INTERIOR ELEVATION - CONTROLLERS OFFICE

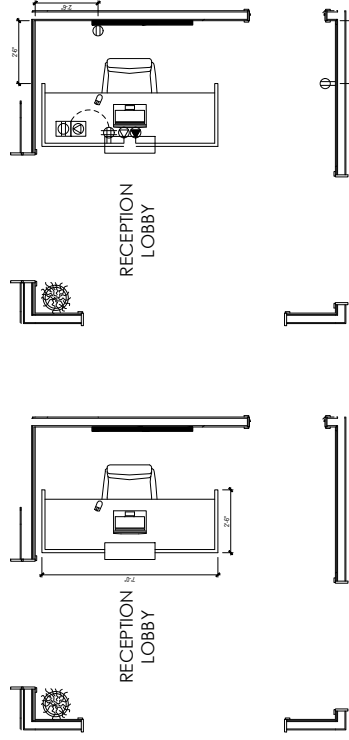

REFER TO E5.0 FOR ELECTRICAL PLAN

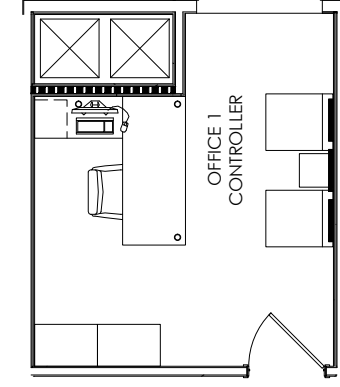

5 FURNITURE PLAN - DETAIL
3.08 10" = 1'-0"
HOMESUITES SOUTH SAN FRANCISCO

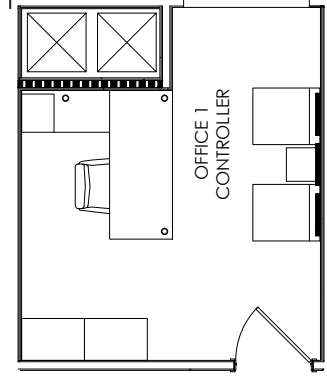

REFER TO E5.0 FOR ELECTRICAL PLAN



PROJECT:
HOME2 SUITES BY HILTON
550 GATEWAY BLVD.
SOUTH SAN FRANCISCO, CA

DRAWING:
INTERIOR ELEVATIONS
PENTHOUSE - 6TH FLR

SCALE:
1/2" = 1'-0"

DATE: JAN. 12, 2017

DRAWN BY:
K SUTHERLAND

DRAWING NUMBER:
ID3.09

REVISIONS:

REV #	DATE	NOTES
0	AUG 29, 2017	RELEASE FOR NORMAL

GENERAL:

1. CONTRACTOR(S) SHALL VERIFY SITE CONDITIONS.
2. NOTIFY THE DISORDER IMMEDIATELY OF ANY DEFICIENCY OR OMISSION.
3. CONTRACTOR(S) SHALL COMPLY WITH CONTACT DOCUMENTS, PERFORMANCE REQUIREMENTS, AND ALL APPLICABLE LOCAL, STATE, AND FEDERAL REGULATIONS.
4. ALL MATERIALS SHALL MEET CODE.
5. THIS DRAWING, AND THE INFORMATION SHOWN ORIMATED HEREIN, CONSTITUTE THE ORIGINAL AND UNPUBLISHED WORK OF STUDIO K DESIGN COMPANY, AND MAY NOT BE USED OR DISCLOSED WITHOUT PRIOR WRITTEN CONSENT OF STUDIO K DESIGN COMPANY.
6. DO NOT SCALE DRAWINGS.
7. REFER TO ELECTRICAL PLANS FOR ALL VERIFIED OUTLET LOCATIONS.


STUDIO K

DESIGN COMPANY


8853 213 Street
Langley, BC V1M 1Z3

604-619-4119


studiokdesign@outlook.com

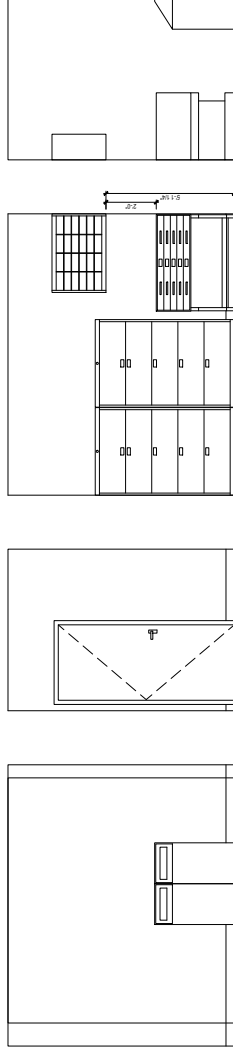

1 INTERIOR ELEVATION - FILE ROOM
3.00 12" x 10"

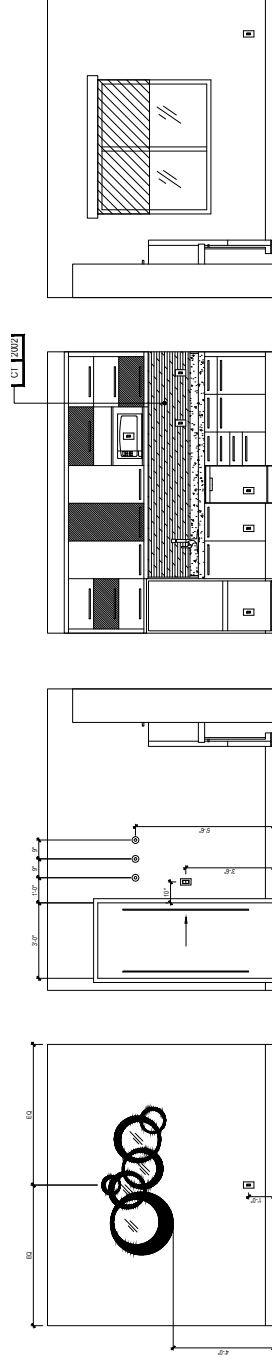

2 INTERIOR ELEVATION - BISTRO KITCHEN
3.09' 12" = 1'-0"

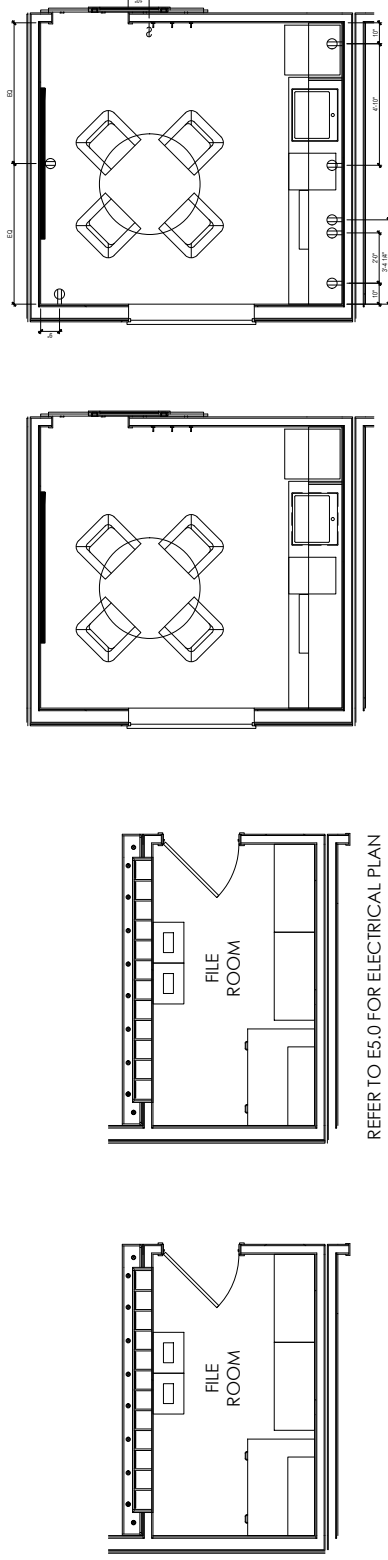

REFER TO E5.0 FOR ELECTRICAL PLAN

ELIPIREPIAN - DETAIL

4 ELECTRICAL & RCP - GENERAL

5 FURNITURE PLAN - DETAIL

REFER TO E5.0 FOR ELECTRICAL PLAN

ELECTRICAL & RCP - GENERAL

PROJECT:
HOME2 SUITES BY HILTON
550 GATEWAY BLVD.
SOUTH SAN FRANCISCO, CA

SRI KRISHNA ENTERPRISE
300 GATEWAY BOULEVARD
SOUTH SAN FRANCISCO, CA 94080

DRAWING:
INTERIOR ELEVATIONS
PENTHOUSE - 6TH FLR

SCALE:
1/2" = 1'-0"

DATE: JAN. 12, 2017

DRAWN BY:
K SUTHERLAND

DRAWING NUMBER:
ID3.11

REVISIONS:

REV #	DATE	NOTES
0	AUG 29, 2017	BREAK FOR REVIEW

GENERAL:

1. CONTRACTOR(S) SHALL VERIFY SITE CONDITIONS.
2. NOTIFY THE DESIGNER IMMEDIATELY OF ANY DISCREPANCY OR OMISSION.
3. CONTRACTOR(S) SHALL COMPLY WITH CONTRACT DOCUMENTS, PERFORMANCE REQUIREMENTS, AND ALL APPLICABLE LOCAL, STATE, AND FEDERAL REGULATIONS.
4. ALL MATERIALS SHALL MEET CODE.
5. THE DRAWING, AND THE INFORMATION SHOWN OR IMPLIED HEREIN, CONSTITUTE THE ORIGINAL AND UNPUBLISHED WORK OF STUDIO C DESIGN COMPANY, AND MAY NOT BE USED OR EXCISED WITHOUT PRIOR WRITTEN CONSENT OF STUDIO C DESIGN COMPANY.
6. NO SCALE DRAWINGS.
7. REFER TO ELECTRICAL PLANS FOR ALL VERIFIED OUTLET LOCATIONS.

STUDIO K

DESIGN COMPANY

8853 213 Street
Langley, BC V1M 1Z3

604-619-4119

studiokdesign@outlook.com

PROJECT:
HOME2 SUITES BY HILTON
550 GATEWAY BLVD.
SOUTH SAN FRANCISCO, CA

DRAWING:
INTERIOR ELEVATIONS
PENTHOUSE - 6TH FLR

SCALE:
1/2" = 1'-0"

DATE: JAN. 12, 2017

DRAWN BY:
K SUTHERLAND

DRAWING NUMBER:
ID3.13

REVISIONS:

REV #	DATE	NOTES
0	AUG 29, 2017	PLEASE FOR REVIEW

GENERAL:

1. CONTRACTOR(S) SHALL VERIFY SITE CONDITIONS.
2. NOTIFY THE DESIGNER IMMEDIATELY OF ANY DISCREPANCY OR OMISSION.
3. CONTRACTOR(S) SHALL COMPLY WITH CONTRACT DOCUMENTS, PERFORMANCE REQUIREMENTS, AND ALL APPLICABLE LOCAL, STATE, AND FEDERAL REGULATIONS.
4. ALL MATERIALS SHALL MEET CODE.
5. THIS DRAWING, AND THE INFORMATION SHOWN OR IMPLIED HEREIN, CONSTITUTE THE ORIGINAL AND UNPUBLISHED WORK OF STUDIO K DESIGN COMPANY, AND MAY NOT BE USED OR DISCLOSED WITHOUT PRIOR WRITTEN CONSENT OF STUDIO K DESIGN COMPANY.
6. DO NOT SCALE DRAWINGS.
7. REFER TO ELECTRICAL PLANS FOR ALL VERIFIED OUTLET LOCATIONS.


STUDIO K

DESIGN COMPANY


8853 213 Street
Langley, BC V1M 1Z3

604-619-4119

studiokdesign@outlook.com

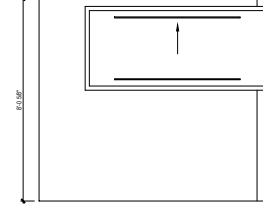


4 INTERIOR ELEVATION
3.13' 1/2" = 1'-0"

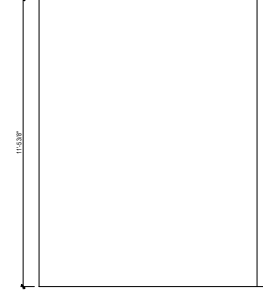


3 INTERIOR ELEVATION
1/2" = 1'-0"
HOME 8 LUTES SOUTH SAN FRANCISCO GATEWAY - FENTON HOUSE




2 INTERIOR ELEVATION
1/2" = 1'0" HOME 2 SUITES SOUTH SAN FRANCISCO (GATEWAY) - PENT HOUSE

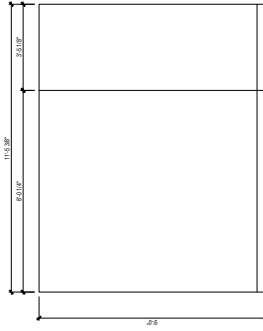


3.13 INTERIOR ELEVATION - TEMPLE
HOME 2 SUITE IS OUT HAWK FAN COO FOR TENNY - PENTHOUSE

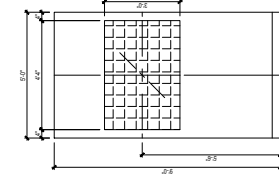

6
3.13
1/2" = 1'-0"

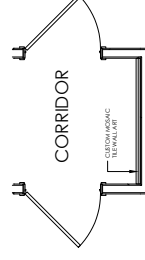

6 PLAN DETAIL - CORRIDOR MURAL
3.13 1/2" = 1'-0"
HOME 3470 S. SOUTH SAN FRANCISCO GATEWAY, PENTHOUSE

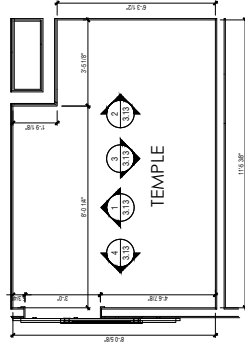

5 TEMPLE - PLAN
3.13 12" = 1'-0"
HOME 2 SUITES SOUTH SAN FRANCISCO (CA) TOWNH - PENTHOUSE

PROJECT:

HOM2 SUITES BY HILTON
550 GATEWAY BLVD.
SOUTH SAN FRANCISCO, CA
381 VESPAVA DRIVE/BRIDGE
300 GATEWAY BOULEVARD
SOUTH SAN FRANCISCO, CA 94080

DRAWING:

FIRST FLOOR
REFLECTED CEILING PLAN
(LIMITED DETAIL)

SCALE:

1/8" = 1'-0"

DATE:

JAN. 12, 2017

DRAWN BY:

K SUTHERLAND

DRAWING NUMBER:

ID5.00

REVISIONS:

REV #	DATE	NOTES
0	APR 28, 2017	RELEASE
1	JUN 08, 2017	GENERAL REV'S PER OWNER
2	AUG 04, 2017	ALIGN TO REV. ARCH. PLANS

GENERAL:

1. CONTRACTOR(S) SHALL VERIFY SITE CONDITIONS.

2. NOTIFY THE DISORDER IMMEDIATELY OF ANY DISCREPANCY OF OMISSION.


3. CONTRACTOR(S) SHALL COMPLY WITH CONTRACT DOCUMENTS, PERFORMANCE REQUIREMENTS, AND ALL APPLICABLE LOCAL, STATE, AND FEDERAL REGULATIONS.

4. ALL MATERIALS SHALL MEET CODE.

5. THIS DRAWING AND THE INFORMATION SHOWN OR IMPLIED HEREIN CONSTITUTE THE ORIGINAL AND UNPUBLISHED WORK OF STUDIO K DESIGN COMPANY, AND MAY NOT BE USED OR REPRODUCED WITHOUT PRIOR WRITTEN CONSENT OF STUDIO K DESIGN COMPANY.

6. NO SCALE DRAWINGS.

STUDIO K
DESIGN COMPANY
8853 213 Street
Langley, BC V1M 1Z3
604-619-4119
studiokdesign@outlook.com

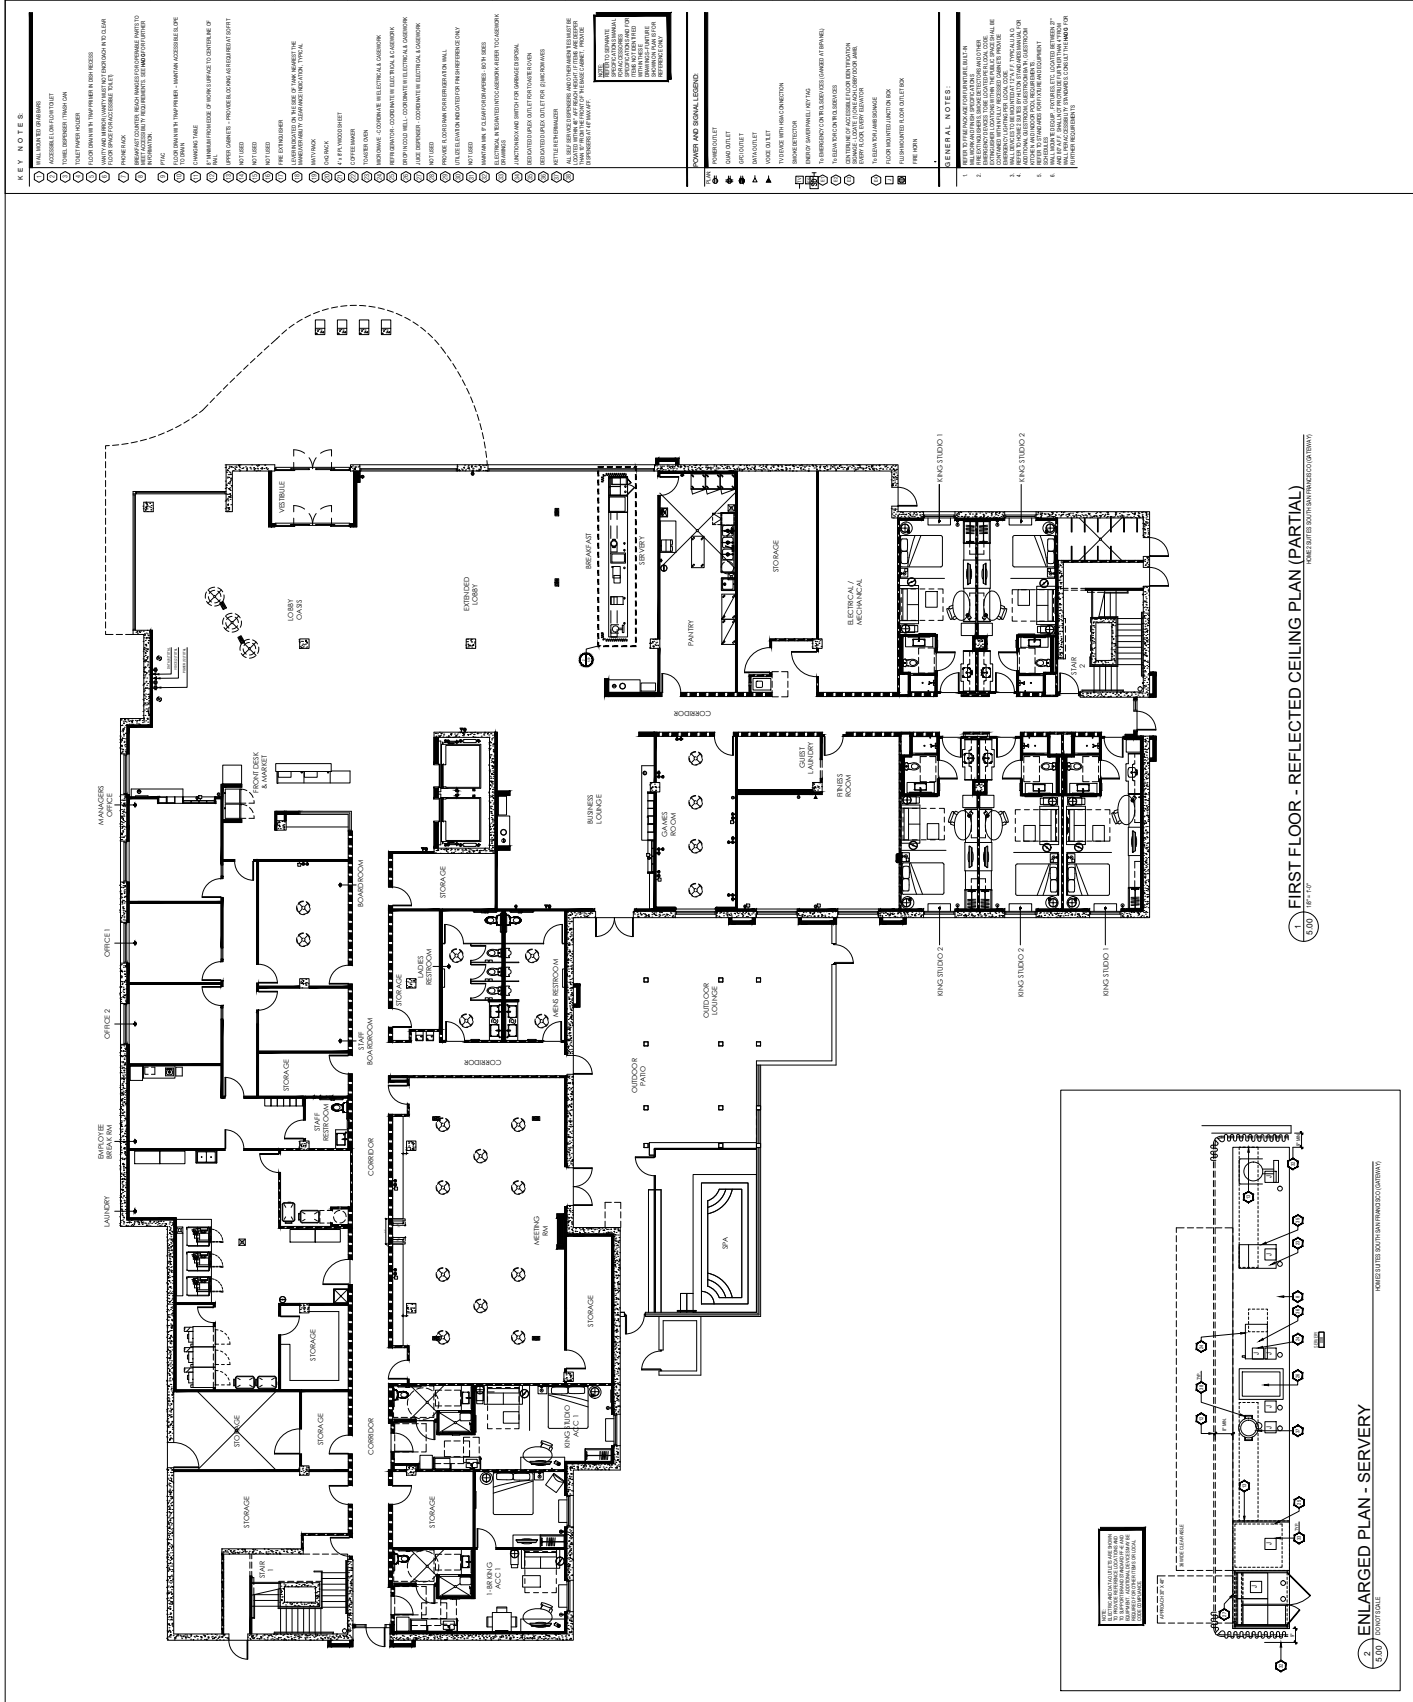

PROJECT:
HOME2 SUITES BY HILTON
550 GATEWAY BLVD.
SOUTH SAN FRANCISCO, CA

DRAWING:

FIRST FLOOR
WALL FINISH PLAN

SCALE:
1/8" = 1'-0"

DATE: JAN. 12, 2017

DRAWN BY:
K SUTHERLAND

DRAWING NUMBER:
ID5.01

REVISIONS:

REV #	DATE	NOTES
0	APR 28, 2017	RELEASE
1	JUN 08, 2017	GENERAL REVIEW REVIEW NOTES
2	AUG 01, 2017	REAGHT TO REV'D ARCH. PLANS
3	AUG 31, 2017	ADD COLOR WALL & FLOOR

GENERAL:

1. CONTRACTOR SHALL VERIFY SITE CONDITIONS.
2. NOTIFY THE ENGINEER IMMEDIATELY OF ANY DISCREPANCY OR OMISSION.
3. CONTRACTOR SHALL COMPLY WITH CONTRACT DOCUMENTS, PERFORMANCE REQUIREMENTS, AND ALL APPLICABLE LOCAL, STATE, AND FEDERAL REGULATIONS.
4. ALL MATERIALS SHALL MEET CODE.
5. THIS DRAWING, AND THE INFORMATION SHOWN OR IMPLIED HEREON, CONSTITUTE THE ORIGINAL AND UNPUBLISHED WORK OF STUDIO K DESIGN COMPANY, AND MAY NOT BE USED OR DISCLOSED WITHOUT PRIOR WRITTEN CONSENT OF STUDIO K DESIGN COMPANY.
6. DO NO SCALE DRAWINGS.


STUDIO K

DESIGN COMPANY

8853 213 Street
Langley, BC V1M 1Z3

604-619-4119

studiokdesign@outlook.com

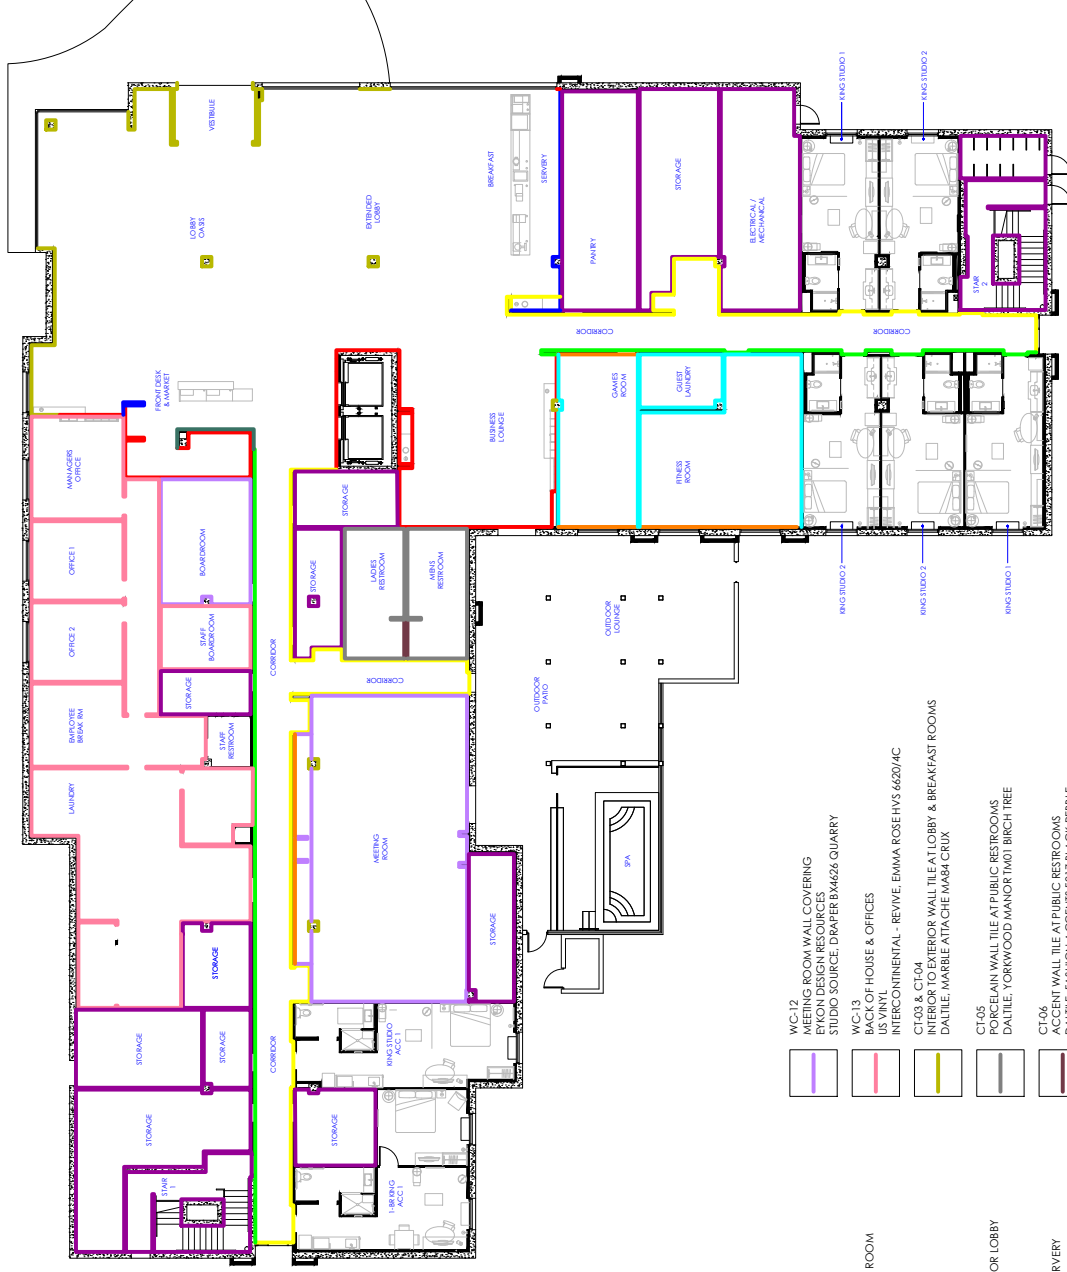

WALL FINISH PLAN KEY

WC-04	WALL COVERING AT LOBBY EYON DESIGN RESOURCES STUDIO SOURCE, DRAPER BX4541 COCKTAIL PARTY
WC-06	ACCENT WALL COVERING AT FINISHES, MEETING, & GAMES ROOM EYON DESIGN RESOURCES STYMPHONT, CHIMES A522974 LOVE IS BLUE
WC-07	WALL COVERING AT GUEST CORRIDOR EYON DESIGN RESOURCES STUDIO SOURCE, PARE MINERALS BX4622 GRANITE
WC-08	ACCENT WALL COVERING AT GUEST CORRIDOR & ELEVATOR LOBBY EYON DESIGN RESOURCES STUDIO SOURCE, DRAPER BX4536 ZOU BROU
WC-09	ACCENT WALL VINYL AT MARKET WALL & WALL BEHIND SERVERY EYON DESIGN RESOURCES SOURCE ONE, SEQUINS Y3YQ04 PLANETARIUM
WC-10	WALL COVERING AT FITNESS ROOM, GUEST LAUNDRY, & GAMES ROOM EYON DESIGN RESOURCES STUDIO SOURCE, PARE MINERALS BX4622 GRANITE
WC-11	ELEVATOR LOBBY WALL COVERING (LEVELS 2 - 5) EYON DESIGN RESOURCES STUDIO SOURCE, DRAPER BX4547 BOARDROOM

WC-12	MEETING ROOM WALL COVERING
BYRON	DESIGN SOURCES
STUDIO SOURCE	DIAPER BA426 QUARRY
WC-13	BACK OF HOUSE & OFFICES
US VINYL	INTERCONTINENTAL - REVIVE, ENMA ROSEHVS 6620/4C
CI03 & CI04	INTERIOR TO EXTERIOR WALL TILE AT LOBBY & BREAKFAST ROOMS
DATILE	MARBLE AT AIGLE MARCH CHUX
CI05	PORCELAIN WALL TILE AT PUBLIC RESTROOMS
DATILE	YORKWOOD MANOR T401 BIRCH TREE
CI06	ACCENT WALL TILE AT PUBLIC RESTROOMS
DATILE	FASHION ACCENTS F017 BECK PEBBLE
SF-06	SUSTAINABLE FOCAL WALL AT LOBBY
	TORZO SURFACES, THEIR NATURAL
PI-05	PAINTED WALL FINISH AT BACK OF HOUSE, STAIRWELLS, & STORAGE
	SW76687 FEUD DE SEL

PROJECT:
HOME2 SUITES BY HILTON
550 GATEWAY BLVD.
SOUTH SAN FRANCISCO, CA

SRI KRISHNA ENTERPRISE
300 GATEWAY BOULEVARD
SOUTH SAN FRANCISCO, CA 94080

DRAWING:
SECOND TO FIFTH FLOOR
WALL FINISH PLAN

SCALE:
1/8" = 1'-0"

DATE: JAN. 12, 2017

DRAWN BY:
K SUTHERLAND

DRAWING NUMBER:
ID502

REVISIONS:

REV #	DATE	NOTES
0	APR 28, 2017	RELEASE
1	JUN 08, 2017	GENERAL REV'S REVIEW NOTES
2	AUG 01, 2017	REALIGN TO REV'D ARCH. PLANS

GENERAL:

1. CONTRACTOR(S) SHALL VERIFY SITE CONDITIONS.
2. NOTIFY THE DESIGNER IMMEDIATELY OF ANY DISCREPANCY OR OMISSION.
3. CONTRACTOR(S) SHALL COMPLY WITH CONTRACT DOCUMENTS, PERFORMANCE REQUIREMENTS, AND ALL APPLICABLE LOCAL, STATE, AND FEDERAL REGULATIONS.
4. ALL MATERIALS SHALL MEET CODE.
5. THIS DRAWING, AND THE INFORMATION SHOWN OR IMPLIED HEREIN, CONSTITUTE THE ORIGINAL AND UNPUBLISHED WORK OF STUDIO K DESIGN COMPANY, AND MAY NOT BE USED OR DISCLOSED WITHOUT PRIOR WRITTEN CONSENT OF STUDIO K DESIGN COMPANY.
6. DO NOT SCALE DRAWINGS.

STUDIO K

DESIGN COMPANY

8853 213 Street
Langley, BC V1M 1Z3

604-619-4119

studiokdesign@outlook.com



WALL FINISH PLAN KEY

WC-04	WALL COVERING AT LOBBY EYKON DESIGN RESOURCES	STUDIO SOURCE. DRAFTER B4534 COCKTAIL PARTY
WC-06	ACCENT WALL COVERING AT FITNESS ROOM & GAMES ROOM EYKON DESIGN RESOURCES	STUDIO SOURCE. CHIMES K23994 LOVEYS BLUE
WC-07	WALL COVERING AT GUEST CORRIDOR EYKON DESIGN RESOURCES	STUDIO SOURCE. RARE MINERALS B46422 GRANITE
WC-08	ACCENT WALL COVERING AT GUEST CORRIDOR & ELEVATOR LOBBY EYKON DESIGN RESOURCES	STUDIO SOURCE. DRAFTER B46534 ZOU BBOU
WC-09	ACCENT WALL VINYL AT MARKET WALL & WALL BETWEEN SERVRY EYKON DESIGN RESOURCES	SOURCE ONE SEQUINS 2452-06 PLANTARIUM
WC-10	WALL COVERING AT FITNESS ROOM, GUEST LAUNDRY, AND GAMES ROOM EYKON DESIGN RESOURCES	STUDIO SOURCE. RARE MINERALS B46422 GRANITE
WC-11	WALL COVER FOR LOBBY WALL COVERING (LEVELS 2 - 5) EYKON DESIGN RESOURCES	STUDIO SOURCE. DRAFTER B4547 BOARDROOM

① SECOND TO FIFTH FLOOR - WALL FINISH PLAN

5.02 16" = 1'0"

HOMES2 SUITES SOUTH SAN FRANCISCO (GATEWAY)

PROJECT:
HOME2 SUITES BY HILTON
550 GATEWAY BLVD.
SOUTH SAN FRANCISCO, CA

DRAWING:
FIRST FLOOR
FLOOR FINISH PLAN

SCALE:
1/8" = 1'-0"

DATE: JAN. 12, 2017

DRAWN BY:
K SUTHERLAND

DRAWING NUMBER:
ID5.03

REVISIONS:

REV #	DATE	NOTES
0	APR 28, 2017	RELEASE
1	JUN 08, 2017	GENERAL REVIEW REVIEW NOTES
2	AUG 01, 2017	REAGHTO REV'D ARCH. PLANS


GENERAL:

1. CONTRACTOR(S) SHALL VERIFY SITE CONDITIONS.
2. NOTIFY THE ENGINEER IMMEDIATELY OF ANY DEFICIENCY OR OMISSION.
3. CONTRACTOR(S) SHALL COMPLY WITH CONTRACT DOCUMENTS, PERFORMANCE REQUIREMENTS, AND ALL APPLICABLE LOCAL, STATE, AND FEDERAL REGULATIONS.
4. ALL MATERIALS SHALL MEET CODE.
5. THE DRAWINGS AND THE INFORMATION SHOWN OR IMPLIED HEREIN, CONSTITUTE THE ORIGINAL AND UNPUBLISHED WORK OF STUDIO K DESIGN COMPANY, AND MAY NOT BE USED OR REPRODUCED WITHOUT PRIOR WRITTEN CONSENT OF STUDIO K DESIGN COMPANY.
6. NO SCALE DRAWINGS.

STUDIO K
DESIGN COMPANY

8853 213 Street
Langley, BC V1M 1Z3

604-619-4119
studiokdesign@outlook.com

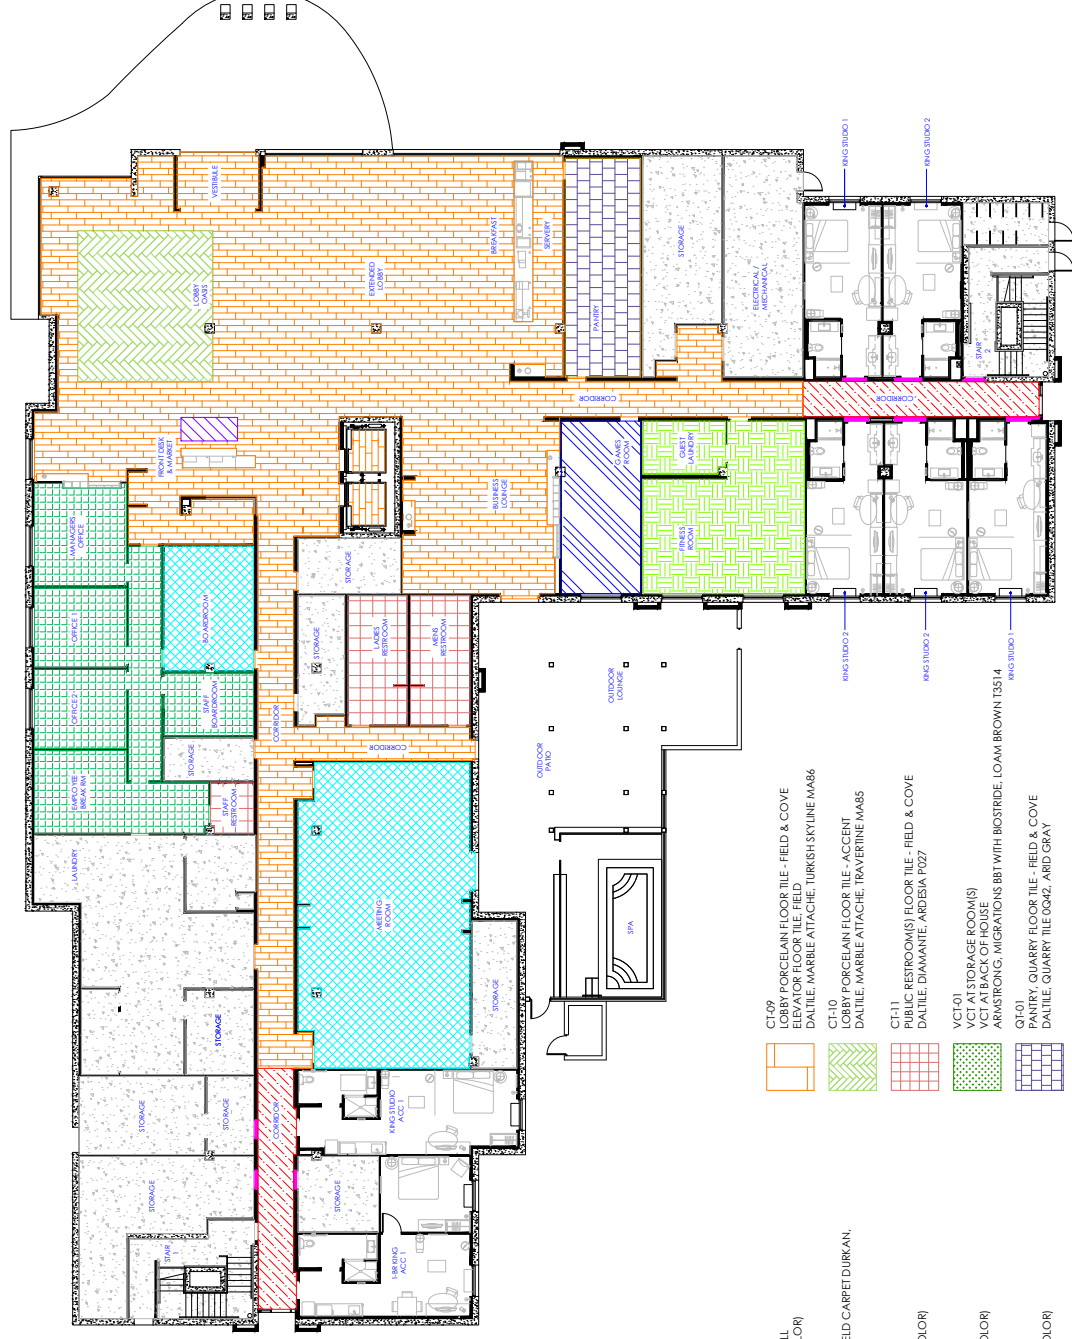

FLOOR FINISH PLAN KEY

- | | |
|---|---|
|  | CP-03
CORRIDOR RUG RUNNER AND OUTFIT
DIRKAN, LAIR D-4445 (CUSTOM COLOR) |
|  | CP-04
ELEVATOR LOBBY - UPPER LEVELS - FIELD CARPET DIRKAN,
LAIR D-4594 (CUSTOM COLOR) |
|  | CP-05
INSET AREA RUG AT LOBBY:
DIRKAN, LAIR D-4593 (CUSTOM COLOR) |
|  | CP-06
MEETING ROOM - FIELD CARPET
DIRKAN, LAIR D-4593 (CUSTOM COLOR) |
|  | CP-07
GAMES ROOM - FIELD CARPET
DIRKAN, LAIR D-4596 (CUSTOM COLOR) |
|  | CP-08
BACK OF HOUSE - FIELD CARPET TILE
MILIKEN, NORDIC STORIES, ISOGRAD IGD172-94 SANDPEPPER |
|  | CP-09
DIRKAN, SOLID BLOTCH col. 36 GUINMETAL |

PROJECT:
HOME2 SUITES BY HILTON
550 GATEWAY BLVD.
SOUTH SAN FRANCISCO, CA

DRAWING:
SECOND TO FIFTH FLOOR
FLOOR FINISH PLAN

SCALE:
1/8" = 1'-0"

DATE: JAN. 12, 2017

DRAWN BY:
K SUTHERLAND

DRAWING NUMBER:
ID5.04

REVISIONS:

REV #	DATE	NOTES
0	APR 28, 2017	RELEASE
1	JUN 08, 2017	GENERAL REVIEW GENERAL REVIEW NOTES
2	AUG 01, 2017	REALIGN TO REV'D ARCH. PLANS

GENERAL:

1. CONTRACTOR(S) SHALL VERIFY SITE CONDITIONS.
2. NOTIFY THE ENGINEER IMMEDIATELY OF ANY DEFICIENCY OR OMISSION.
3. CONTRACTOR(S) SHALL COMPLY WITH CONTRACT DOCUMENTS, PERFORMANCE REQUIREMENTS, AND ALL APPLICABLE LOCAL, STATE, AND FEDERAL REGULATIONS.
4. ALL MATERIALS SHALL MEET CODE.
5. THE DRAWINGS AND THE INFORMATION SHOWN OR IMPLIED HEREIN, CONSTITUTE THE ORIGINAL AND UNPUBLISHED WORK OF STUDIO K DESIGN COMPANY, AND MAY NOT BE USED OR COPIED WITHOUT PRIOR WRITTEN CONSENT OF STUDIO K DESIGN COMPANY.
6. NO SCALE DRAWINGS.

STUDIO K
DESIGN COMPANY

8853 213 Street
Langley, BC V1M 1Z3


604-619-4119
studiokdesign@outlook.com




FLOOR FINISH PLAN KEY

- | | |
|---|---|
|  | CP-03
CORRIDOR RUG RUNNER AND OUTFILL
DUKUNAN, LAKIR D4445 (CUSTOM COLOR) |
|  | CP-04
ELEVATOR LOBBY - UPPER LEVELS - FIELD CARPET DUKUNAN, LAKIR D40594 (CUSTOM COLOR) |
|  | CP-05
INSET AREA RUG AT LOBBY -
DUKUNAN, LAKIR D40593 (CUSTOM COLOR) |
|  | CP-06
MEETING ROOM - FIELD CARPET
DUKUNAN, LAKIR D40593 (CUSTOM COLOR) |
|  | CP-07
GAMES ROOM - FIELD CARPET
DUKUNAN, LAKIR D40606 (CUSTOM COLOR) |
|  | CP-08
BACK OF HOUSE - FIELD CARPET TILE
MILIKEN, NORDIC STORIES, ISOGRAD ISO124-94 SAND PAPER |
|  | CP-09
DUKUNAN, SOLID BLOTCH col. 316 GUNMETAL |

- | | |
|--------------------|---|
| CT-09 | LOBBY PORCELAIN FLOOR TILE - FIELD & COVE
ELEVATOR FLOOR TILE - FIELD
DALLITE, MARBLE ANTACHE, TURKISH SKYLINE MAB6 |
| CT-10 | LOBBY PORCELAIN FLOOR TILE - ACCENT
DALLITE, MARBLE ANTACHE, TRAVERTINE MAB5 |
| CT-11 | PUBLIC RESTROOM(S) FLOOR TILE - FIELD & COVE
DALLITE, DIAMANTE, ANDISIA P027 |
| VC1-01 | VCT K1 STORAGE ROOM(S)
APMS/STRONG, MIGRATIONS BBT WITH BIOSTRIDE, LOAM BROWN T3514 |
| QJ-01 | PANTRY, QUARRY FLOOR TILE - FIELD & COVE
DALLITE, QUARRY TILE Q042, ARID GRAY |
| FE-01 | FINNES ROOM, RUBBER FLOOR TILE (INTERLOCKING)
ECORE, EVERLAST EL38A STEEL BLUE 2 |
| GENERAL - CONCRETE | |

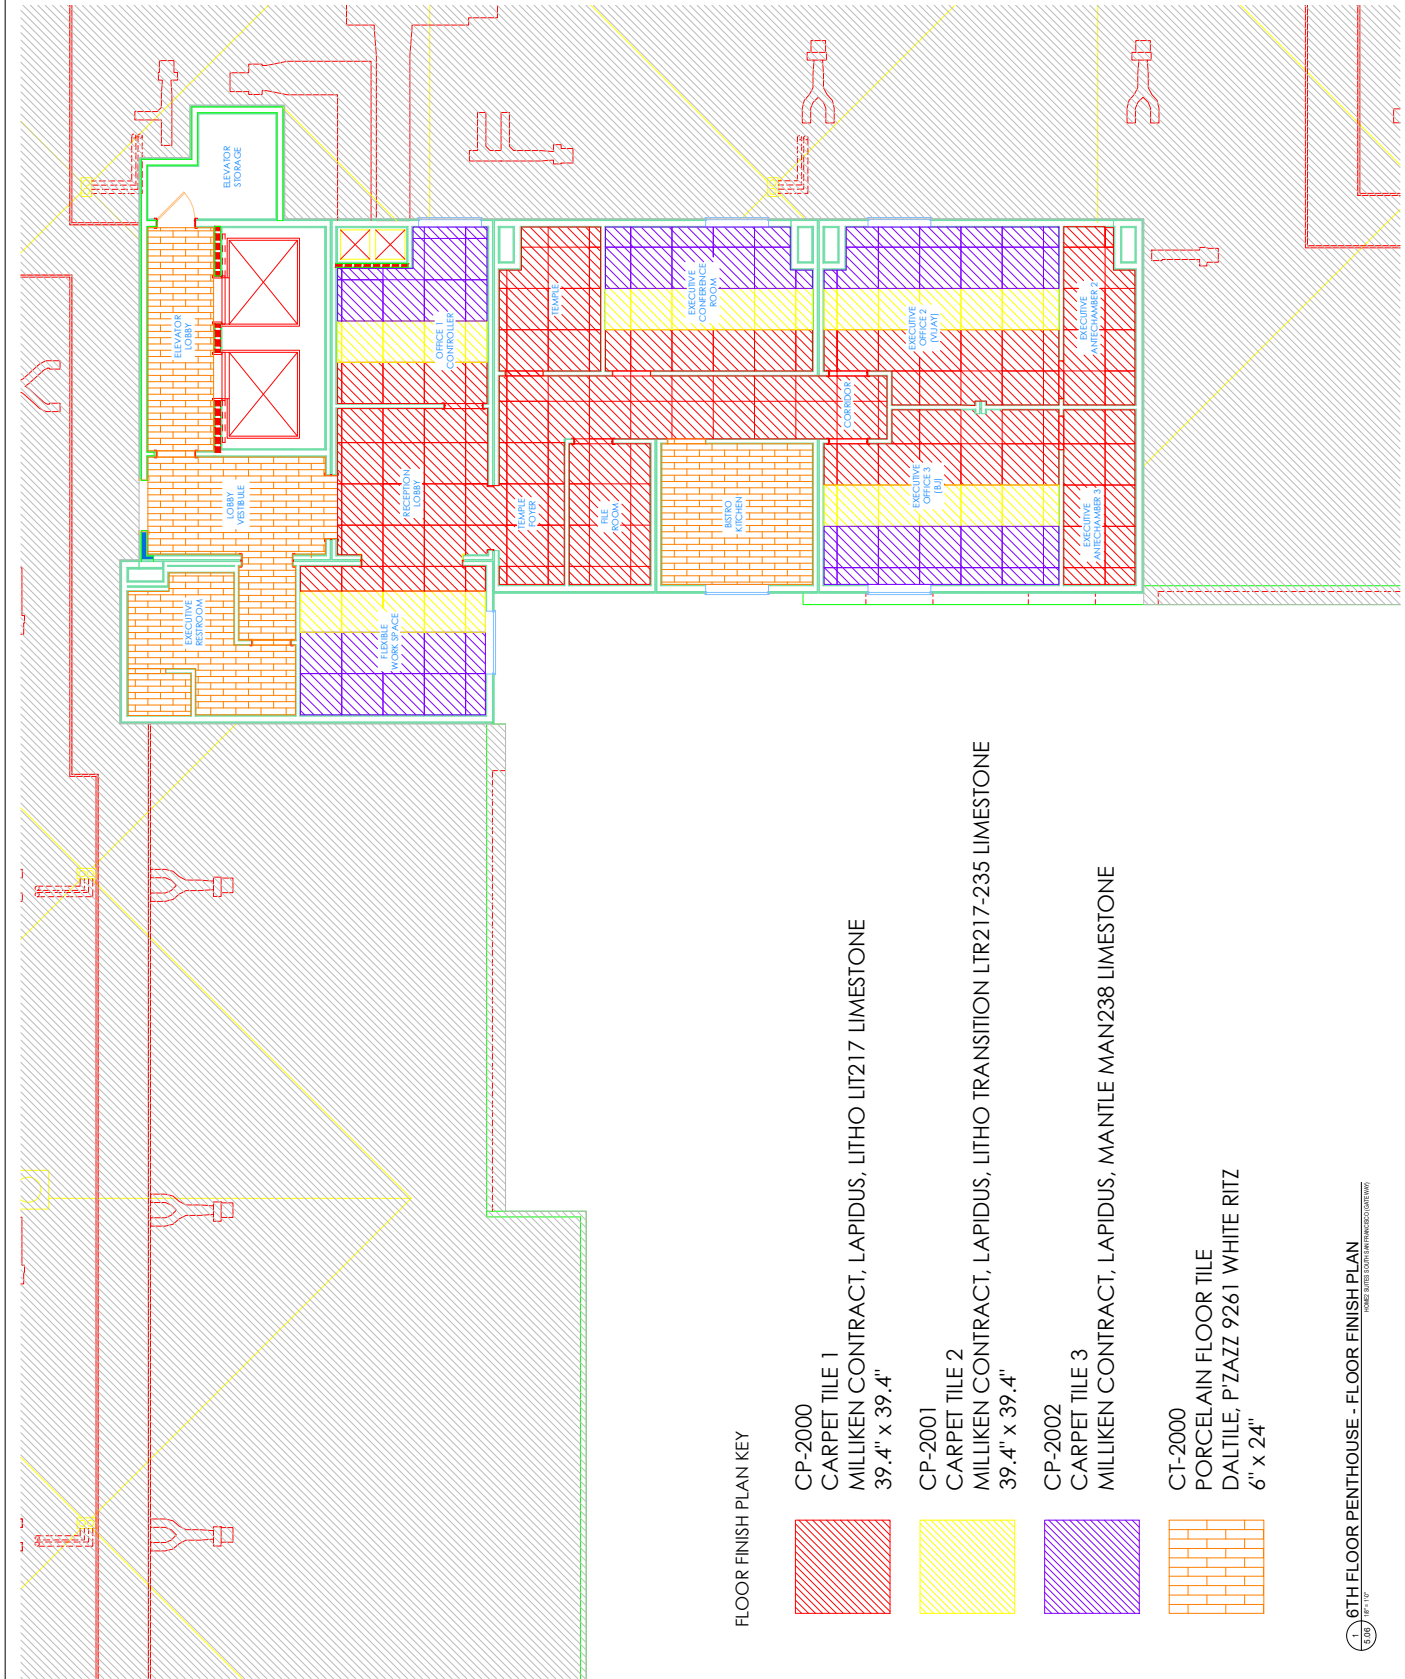

FLOOR FINISH PLAN KEY

 

CP-2000
CARPET TILE 1
MILLIKEN CONTRACT, LAPIDUS, LITHO LIT217 LIMESTONE
39.4" x 39.4"

CP-2001
CARPET TILE 2
MILLIKEN CONTRACT, LAPIDUS, LITHO TRANSITION LTR217-235 LIMESTONE
39.4" x 39.4"

CP-2002
CARPET TILE 3
MILLIKEN CONTRACT, LAPIDUS, MANTLE MAN238 LIMESTONE

CT-2000
PORCELAIN FLOOR TILE
DAL TILE, P'ZAZZ 9261 WHITE RITZ
6" x 24"

PROJECT:
HOMESUITES BY HILTON
550 GATEWAY BLVD.
SOUTH SAN FRANCISCO, CA
380 VESPAVA DRIVE
300 GATEWAY BOULEVARD
SOUTH SAN FRANCISCO, CA 94080

DRAWING:
6TH FLOOR PENTHOUSE
FLOOR FINISH PLAN

SCALE:
1/8" = 1'-0"

DATE:
AUG. 25, 2017

DRAWN BY:
K SUTHERLAND

DRAWING NUMBER:
ID5.06


REVISIONS:

REV #	DATE	NOTES
0	AUG 25, 2017	RELEASE

GENERAL:

- CONTRACTOR(S) SHALL VERIFY SITE CONDITIONS. NOTIFY THE DISCOVERER IMMEDIATELY OF ANY DISCREPANCY OR OMISSION.
- CONTRACTOR(S) SHALL COMPLY WITH CONTRACT DOCUMENTS, PERFORMANCE REQUIREMENTS, AND ALL APPLICABLE LOCAL, STATE, AND FEDERAL REGULATIONS.
- ALL MATERIALS SHALL MEET CODE.
- THIS DRAWING, AND THE INFORMATION SHOWN OR IMPLIED HEREIN, CONSTITUTE THE ORIGINAL AND UNPUBLISHED WORK OF STUDIO K DESIGN COMPANY, AND MAY NOT BE USED OR DISCLOSED WITHOUT PRIOR WRITTEN CONSENT OF STUDIO K DESIGN COMPANY.
- DO NOT SCALE DRAWINGS.

STUDIO K
DESIGN COMPANY
8853 213 Street
Langley, BC V1M 1Z3
604-619-4119
studiokdesign@outlook.com

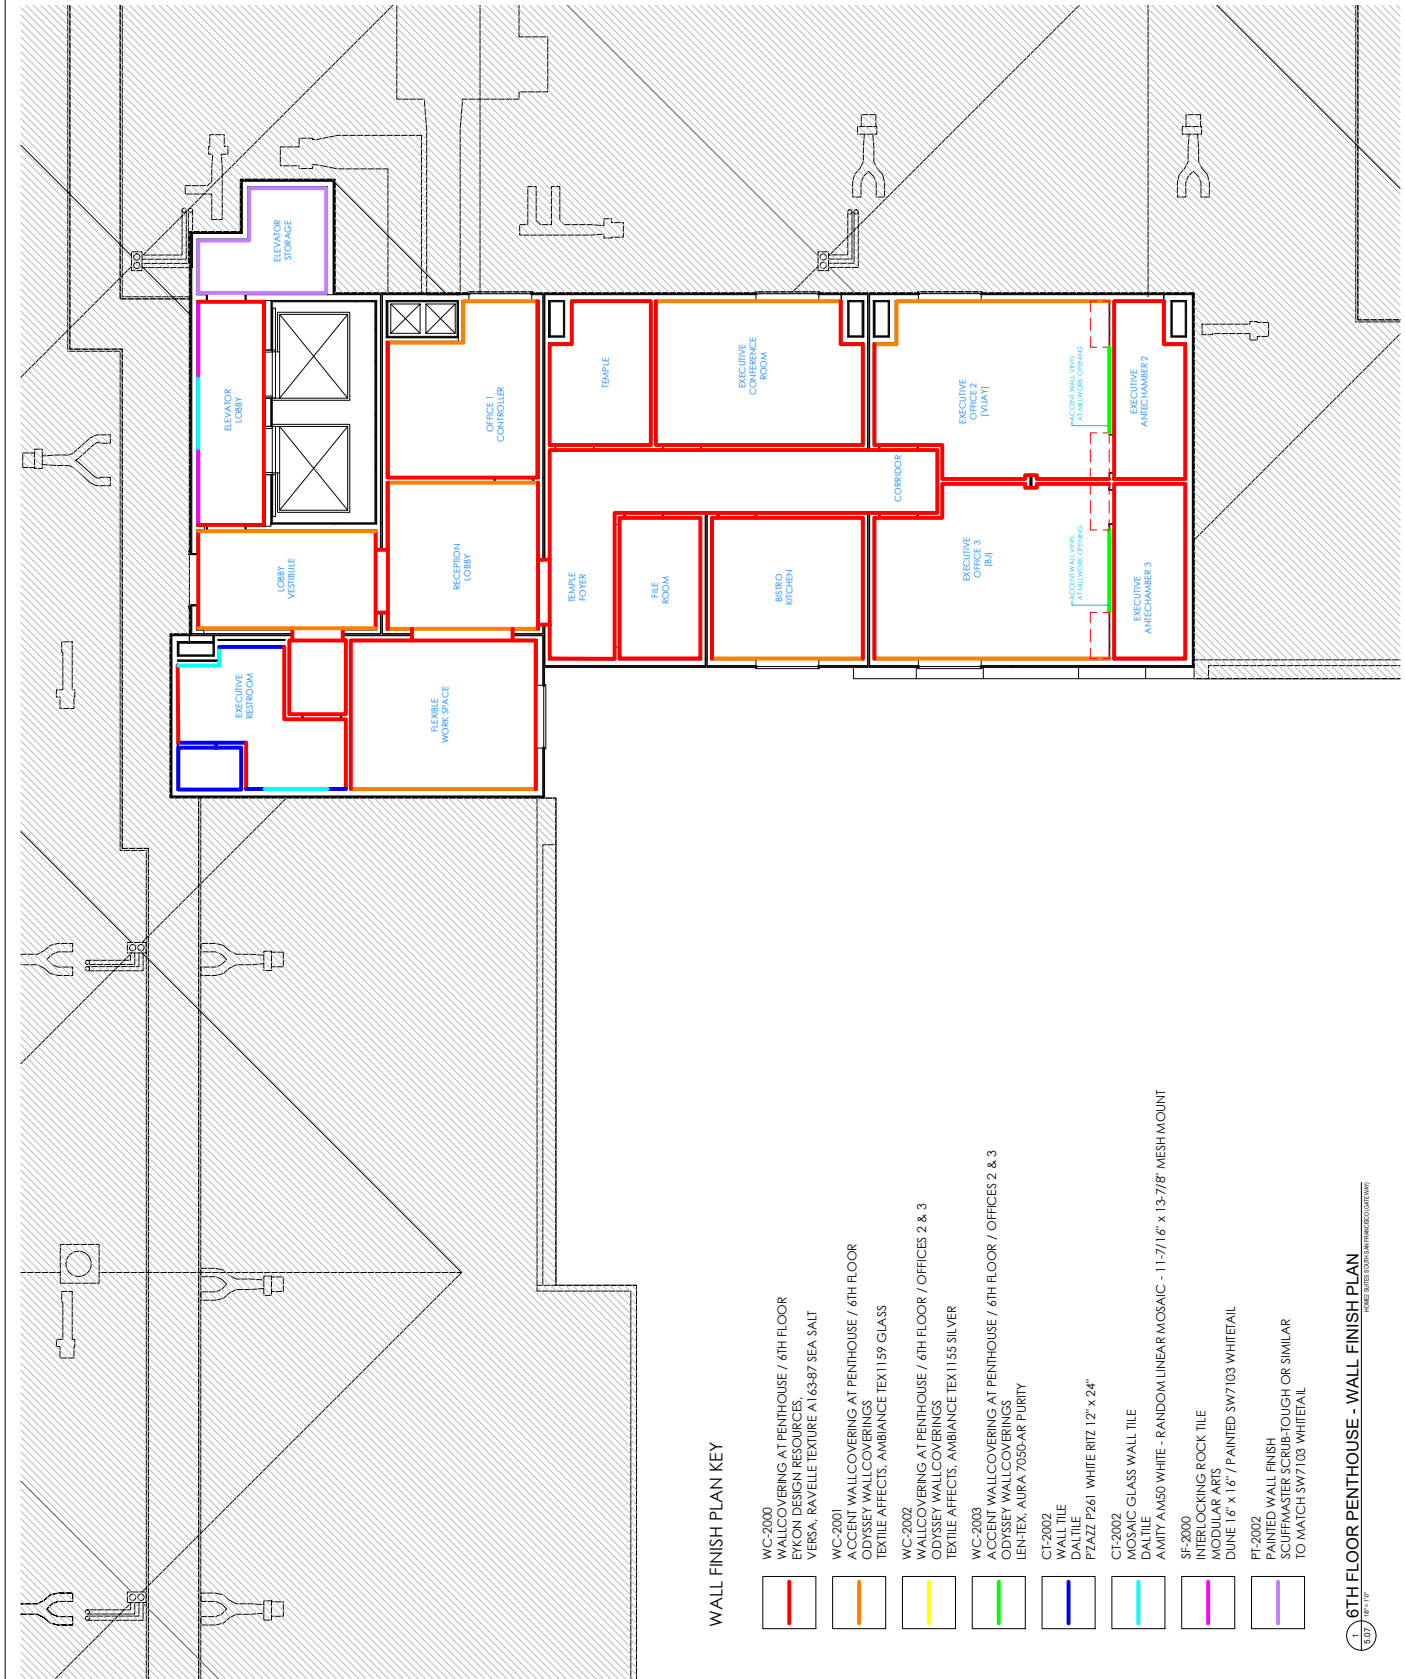

PROJECT:
HOME2 SUITES BY HILTON
550 GATEWAY BLVD.
SOUTH SAN FRANCISCO, CA
300 VESPERA DRIVE
300 GATEWAY BOULEVARD
SOUTH SAN FRANCISCO, CA 94080

DRAWING:
6TH FLOOR PENTHOUSE
WALL FINISH PLAN

SCALE:
1/8" = 1'-0"

DATE:
AUG. 25, 2017

DRAWN BY:
K SUTHERLAND

DRAWING NUMBER:
ID5.07

REVISIONS:

REV #	DATE	NOTES
0	AUG 28, 2017	RELEASE FOR REVIEW

GENERAL:

1. CONTRACTOR(S) SHALL VERIFY SITE CONDITIONS. NOTIFY THE DISCREPANCY IMMEDIATELY OF ANY DISCREPANCY OR OMISSION.
2. CONTRACTOR(S) SHALL COMPLY WITH CONTRACT DOCUMENTS, PERFORMANCE REQUIREMENTS, AND ALL APPLICABLE LOCAL, STATE, AND FEDERAL REGULATIONS.
3. ALL MATERIALS SHALL MEET CODE.
4. THIS DRAWING, AND THE INFORMATION SHOWN OR IMPLIED HEREIN, CONSTITUTE THE ORIGINAL AND UNPUBLISHED WORK OF STUDIO K DESIGN COMPANY, AND MAY NOT BE USED OR DISCLOSED WITHOUT PRIOR WRITTEN CONSENT OF STUDIO K DESIGN COMPANY.
5. DO NOT SCALE DRAWINGS.

STUDIO K
DESIGN COMPANY
8853 213 Street
Longley, BC V1M 1Z3
604-619-4119
studiokdesign@outlook.com

WALL FINISH PLAN KEY

- WC-2000
WALLCOVERING AT PENTHOUSE / 6TH FLOOR
EYKON DESIGN RESOURCES
VERSA, RAVELLE TEXTURE A163-87 SEA SALT
- WC-2001
ACCENT WALLCOVERING AT PENTHOUSE / 6TH FLOOR
ODYSSEY WALLCOVERINGS
TEXTILE AFFECTS, AMBIANCE TEXT1159 GLASS
- WC-2002
WALLCOVERING AT PENTHOUSE / 6TH FLOOR / OFFICES 2 & 3
ODYSSEY WALLCOVERINGS
TEXTILE AFFECTS, AMBIANCE TEXT1155 SILVER
- WC-2003
WALLCOVERING AT PENTHOUSE / 6TH FLOOR / OFFICES 2 & 3
ODYSSEY WALLCOVERINGS
LEH TEX, AURA 7050-AR PURITY
- CT-2002
WALL TILE
DAL TIE
PZAZ P261 WHITE RTZ 12" x 24"
- CT-2002
MOSAIC GLASS WALL TILE
DAL TIE
AMITY AM50 WHITE - RANDOM LINEAR MOSAIC - 11-7/16" x 13-7/8" MESH MOUNT
- SF-2000
INTERLOCKING ROCK TILE
MODULAR ARTS
DUNE 16" x 16" / PAINTED SW7103 WHITE/TAIL
- PT-2002
PAINTED WALL FINISH
SCUFFMASTER SCRUB-TOUGH OR SIMILAR
TO MATCH SW7103 WHITE/TAIL