


Richard Molenaar
ARCHITECT

FIRE PROTECTION SYSTEMS

- THE FIRE PROTECTION CONTRACTOR SHALL PROVIDE THE FOLLOWING:
- SUBMIT SHOP DRAWINGS TO AND OBTAIN APPROVALS FROM EXISTING AUTHORITIES REGARDING THE FIRE PROTECTION SYSTEMS TO BE PROVIDED.
 - PROVIDE WATER PROTECTION FOR THE BUILDING AREA IN ACCORDANCE WITH IRC 903.3.11.11 NFPA 13.
 - PROVIDE A CLASS 1 STAMPING SYSTEM IN ACCORDANCE WITH IRC 903.3.1, EXCEPTION 1.
 - COORDINATE INSTALLATION WITH G.C.

LEGEND

- FFC TYPE 2A FIRE EXTINGUISHERS & APPROPRIATE SEMI-RECESSED CABINET MAX PROJECTION SEE DET 3/4609.
- EE TYPE 2A FIRE EXTINGUISHER BRACKETED TO WALL
- REV DRAIN IN REVERSE
- DEVICES 1 HR FIRE RATING
- DEVICES 2 HR FIRE RATING
- GUEST ROOM WITH ACCESSIBILITY ROUTE TO CORR. 1 WITH AD-24
- GUEST ROOM WITH VISUAL ALARMS NOTIFICATION DEVICES & TELEPHONES TO CORR. 1 WITH AD-24

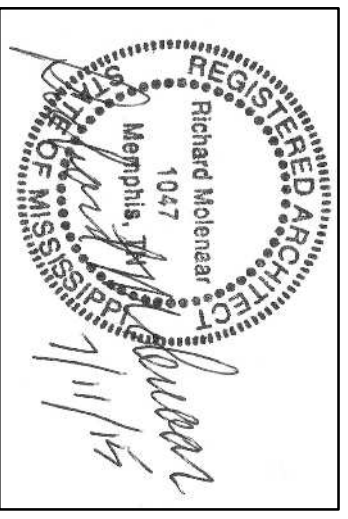

PROJECT NAME:

HOMER2
SUITES BY HILTON

Old Fannin Road Flowood, Mississippi

SHEET TITLE:


PROJECT NO. LATEST REVISION:

DRAWN BY: CHECKED BY: SHEET NUMBER:


DATE: July 11, 2015

A103

REVISION: SEPT. 16, 2016

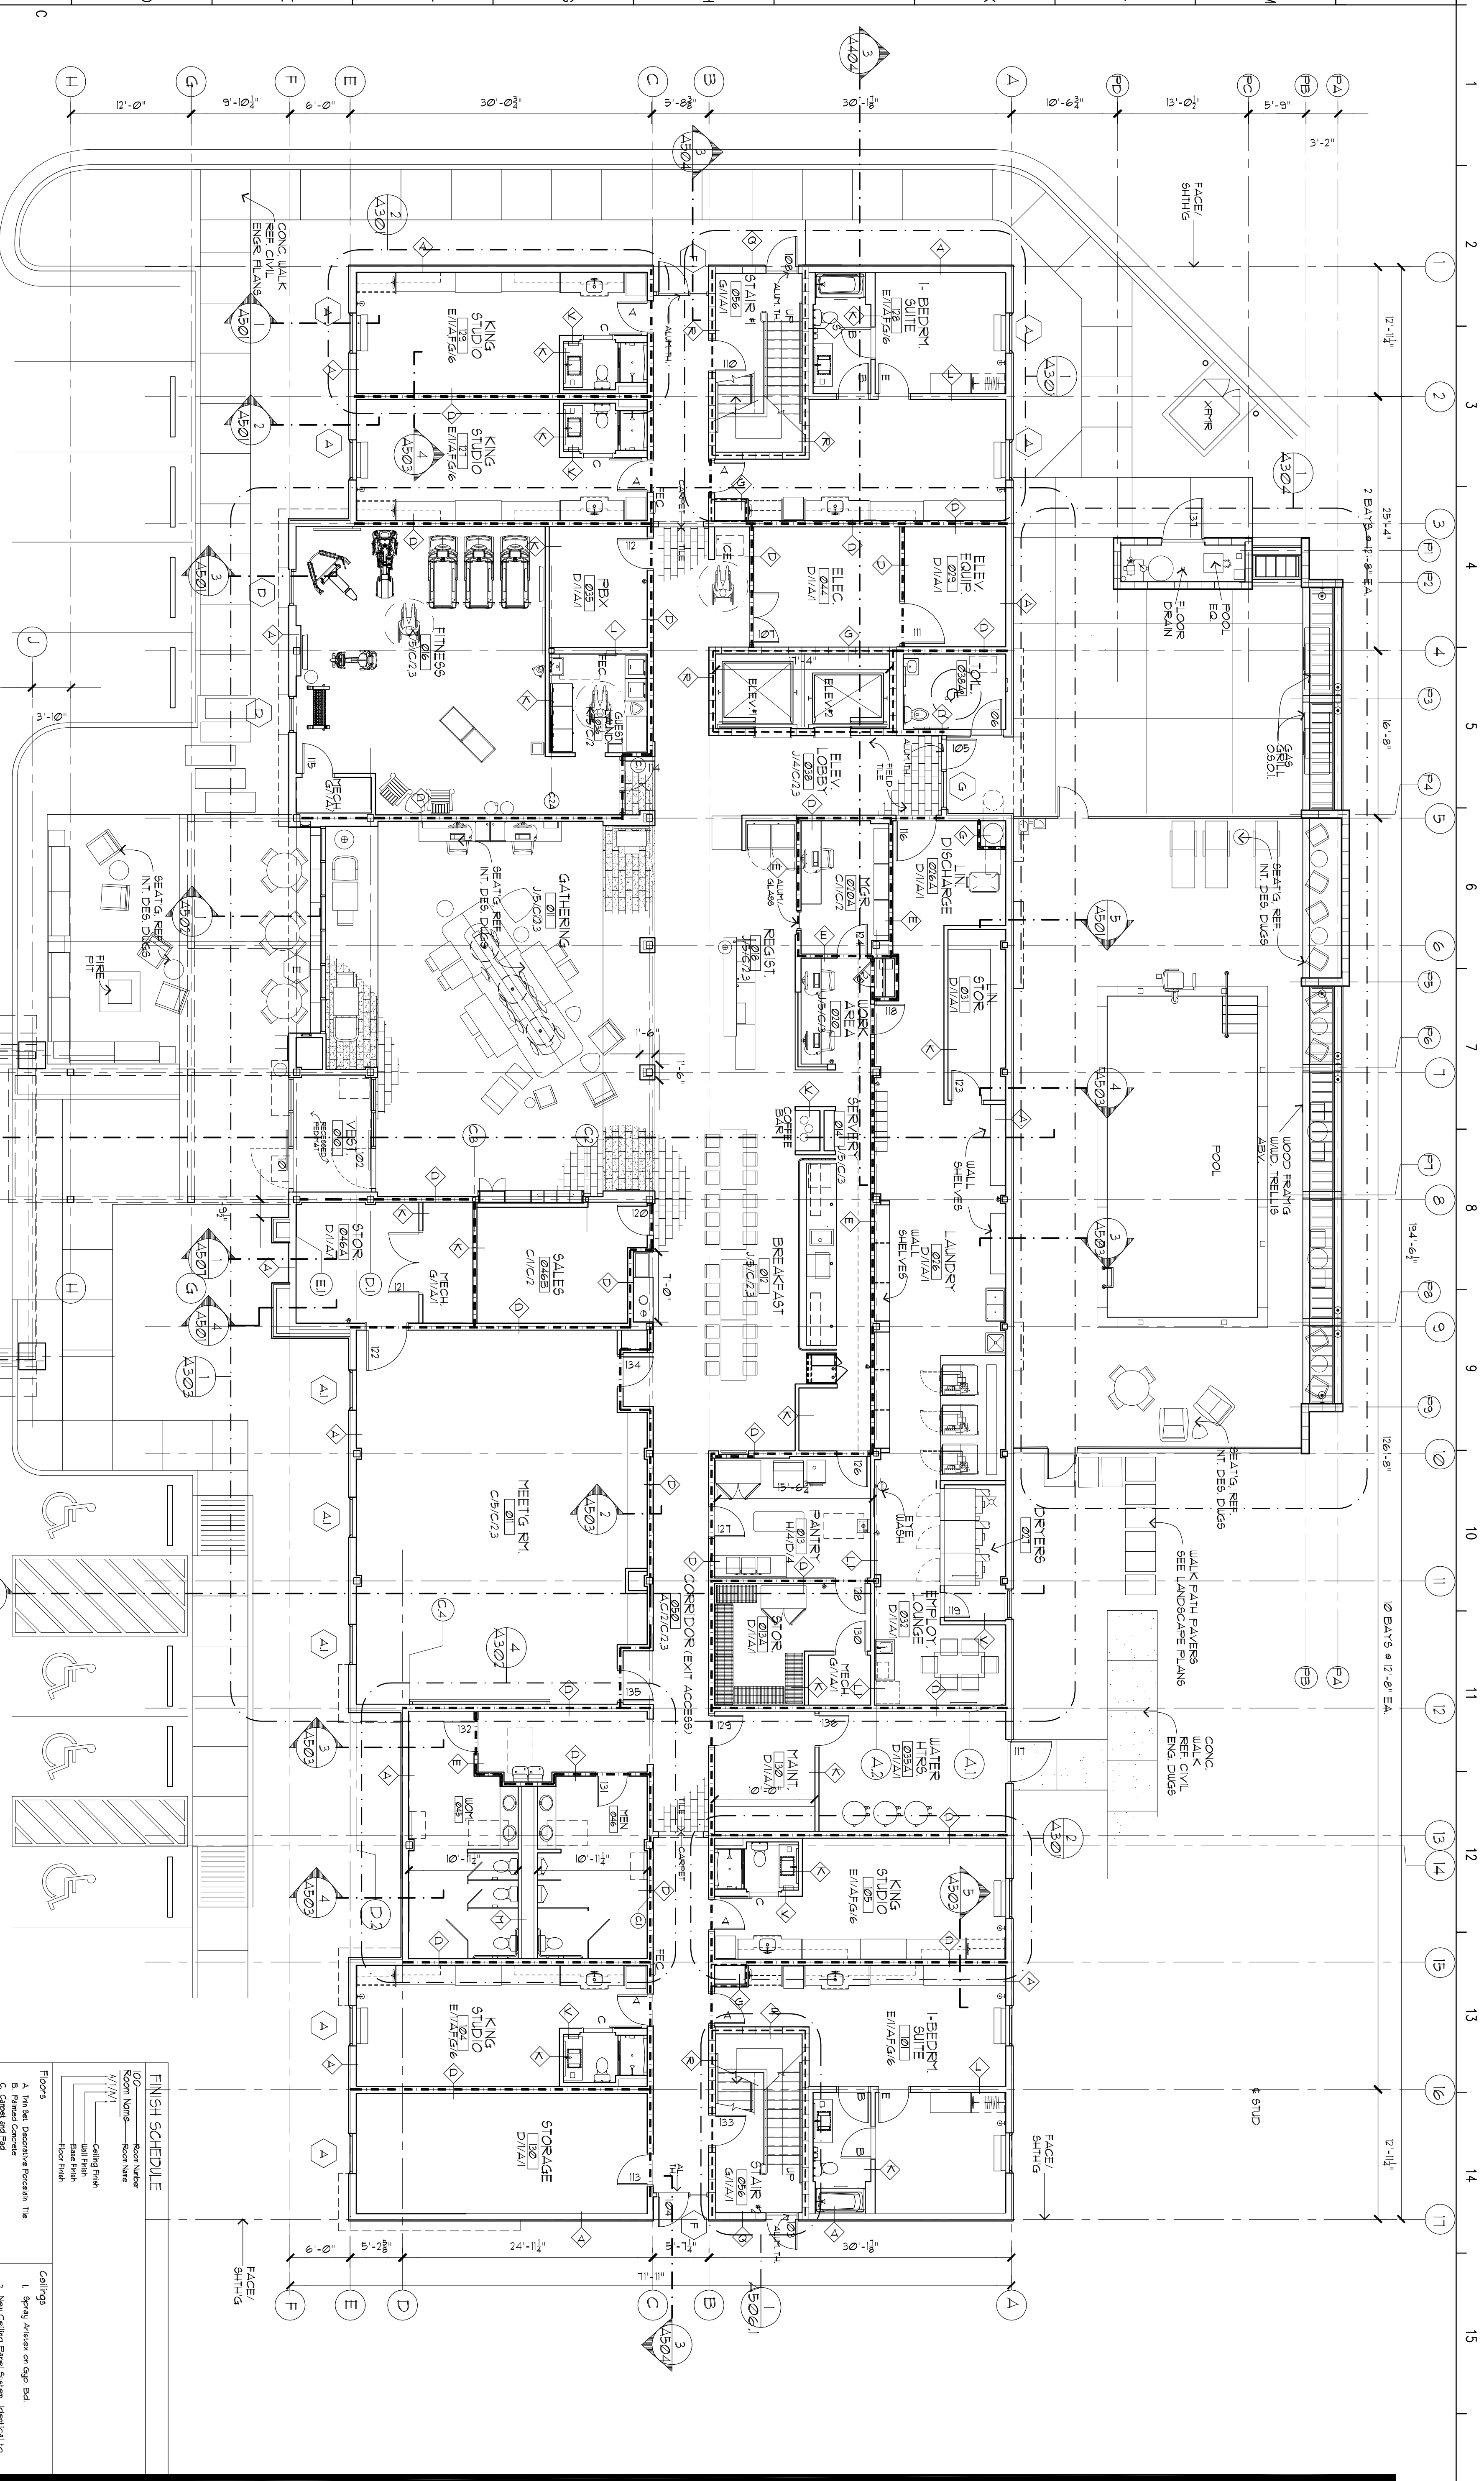

1 GROUND FLOOR PLAN
14,783 SQ. FT.

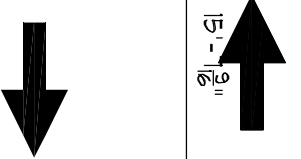

ROOM MIX RECAP					
ROOM TYPE	GR.	2nd	3rd	4th	5th
KING STUDIO	4	16	16	16	16
DBL. QUEEN STUDIO		5	5	5	5
ACCESS. DBL. QN. STUDIO SHWR.		1	1	1	1
ACCESS. DBL. QUEEN STUDIO					3
KING 1+ BEDROOM	2	2	2	2	10
KING 1+ BEDROOM TYPE III					1
ACC. KING 1+ BEDROOM		1	1	1	2
ACC. KING 1+ BEDROOM SHWR.		1	1	1	1
FLOOR TOTAL	6	25	25	25	106
AREA	12,850	sqft	12,986	sqft	12,986
sqft	64,794	sqft			