


POOL EQUIPMENT:


ELECTRICAL CONTRACTOR SHALL VERIFY EXACT LOCATIONS & ELECTRICAL REQUIREMENTS OF ALL POOL EQUIPMENT INCLUDING, BUT NOT LIMITED TO: POOL PUMP, OR PUMPS, SPA PUMP, OR PUMPS, UNDERWATER POOL LIGHTS, TRANSFORMERS, DEHUMIDIFIERS, CONDENSING UNITS, ETC. PRIOR TO THE ROUGH-IN OF ANY ELECTRICAL EQUIPMENT. ELECTRICAL CONTRACTOR SHALL NOTIFY THE OWNER & ARCHITECT OF ANY CONFLICTS WITH THE ELECTRICAL DESIGN DRAWINGS AND THE EQUIPMENT FURNISHED BY THE OWNER AND THE POOL CONTRACTOR ALL POOL AREA LIGHTING, EQUIPMENT, AND RECEPTACLE CIRCUITS SHALL HAVE GFC PROTECTION.

LAUNDRY EQUIPMENT:

ELECTRICAL CONTRACTOR SHALL VERIFY EXACT LOCATIONS & ELECTRICAL REQUIREMENTS OF ALL LAUNDRY EQUIPMENT INCLUDING, BUT NOT LIMITED TO: COMMERCIAL WASHERS & DRYERS, GUEST WASHERS & DRYERS, WATER SOFTENERS, MOTORIZED LOUVERS, SOAP DISPENSERS, ETC. PRIOR TO THE ROUGH-IN OF ANY ELECTRICAL EQUIPMENT. ELECTRICAL CONTRACTOR SHALL NOTIFY THE OWNER & ARCHITECT OF ANY CONFLICTS WITH THE ELECTRICAL DESIGN DRAWINGS AND OWNER SUPPLIED EQUIPMENT.

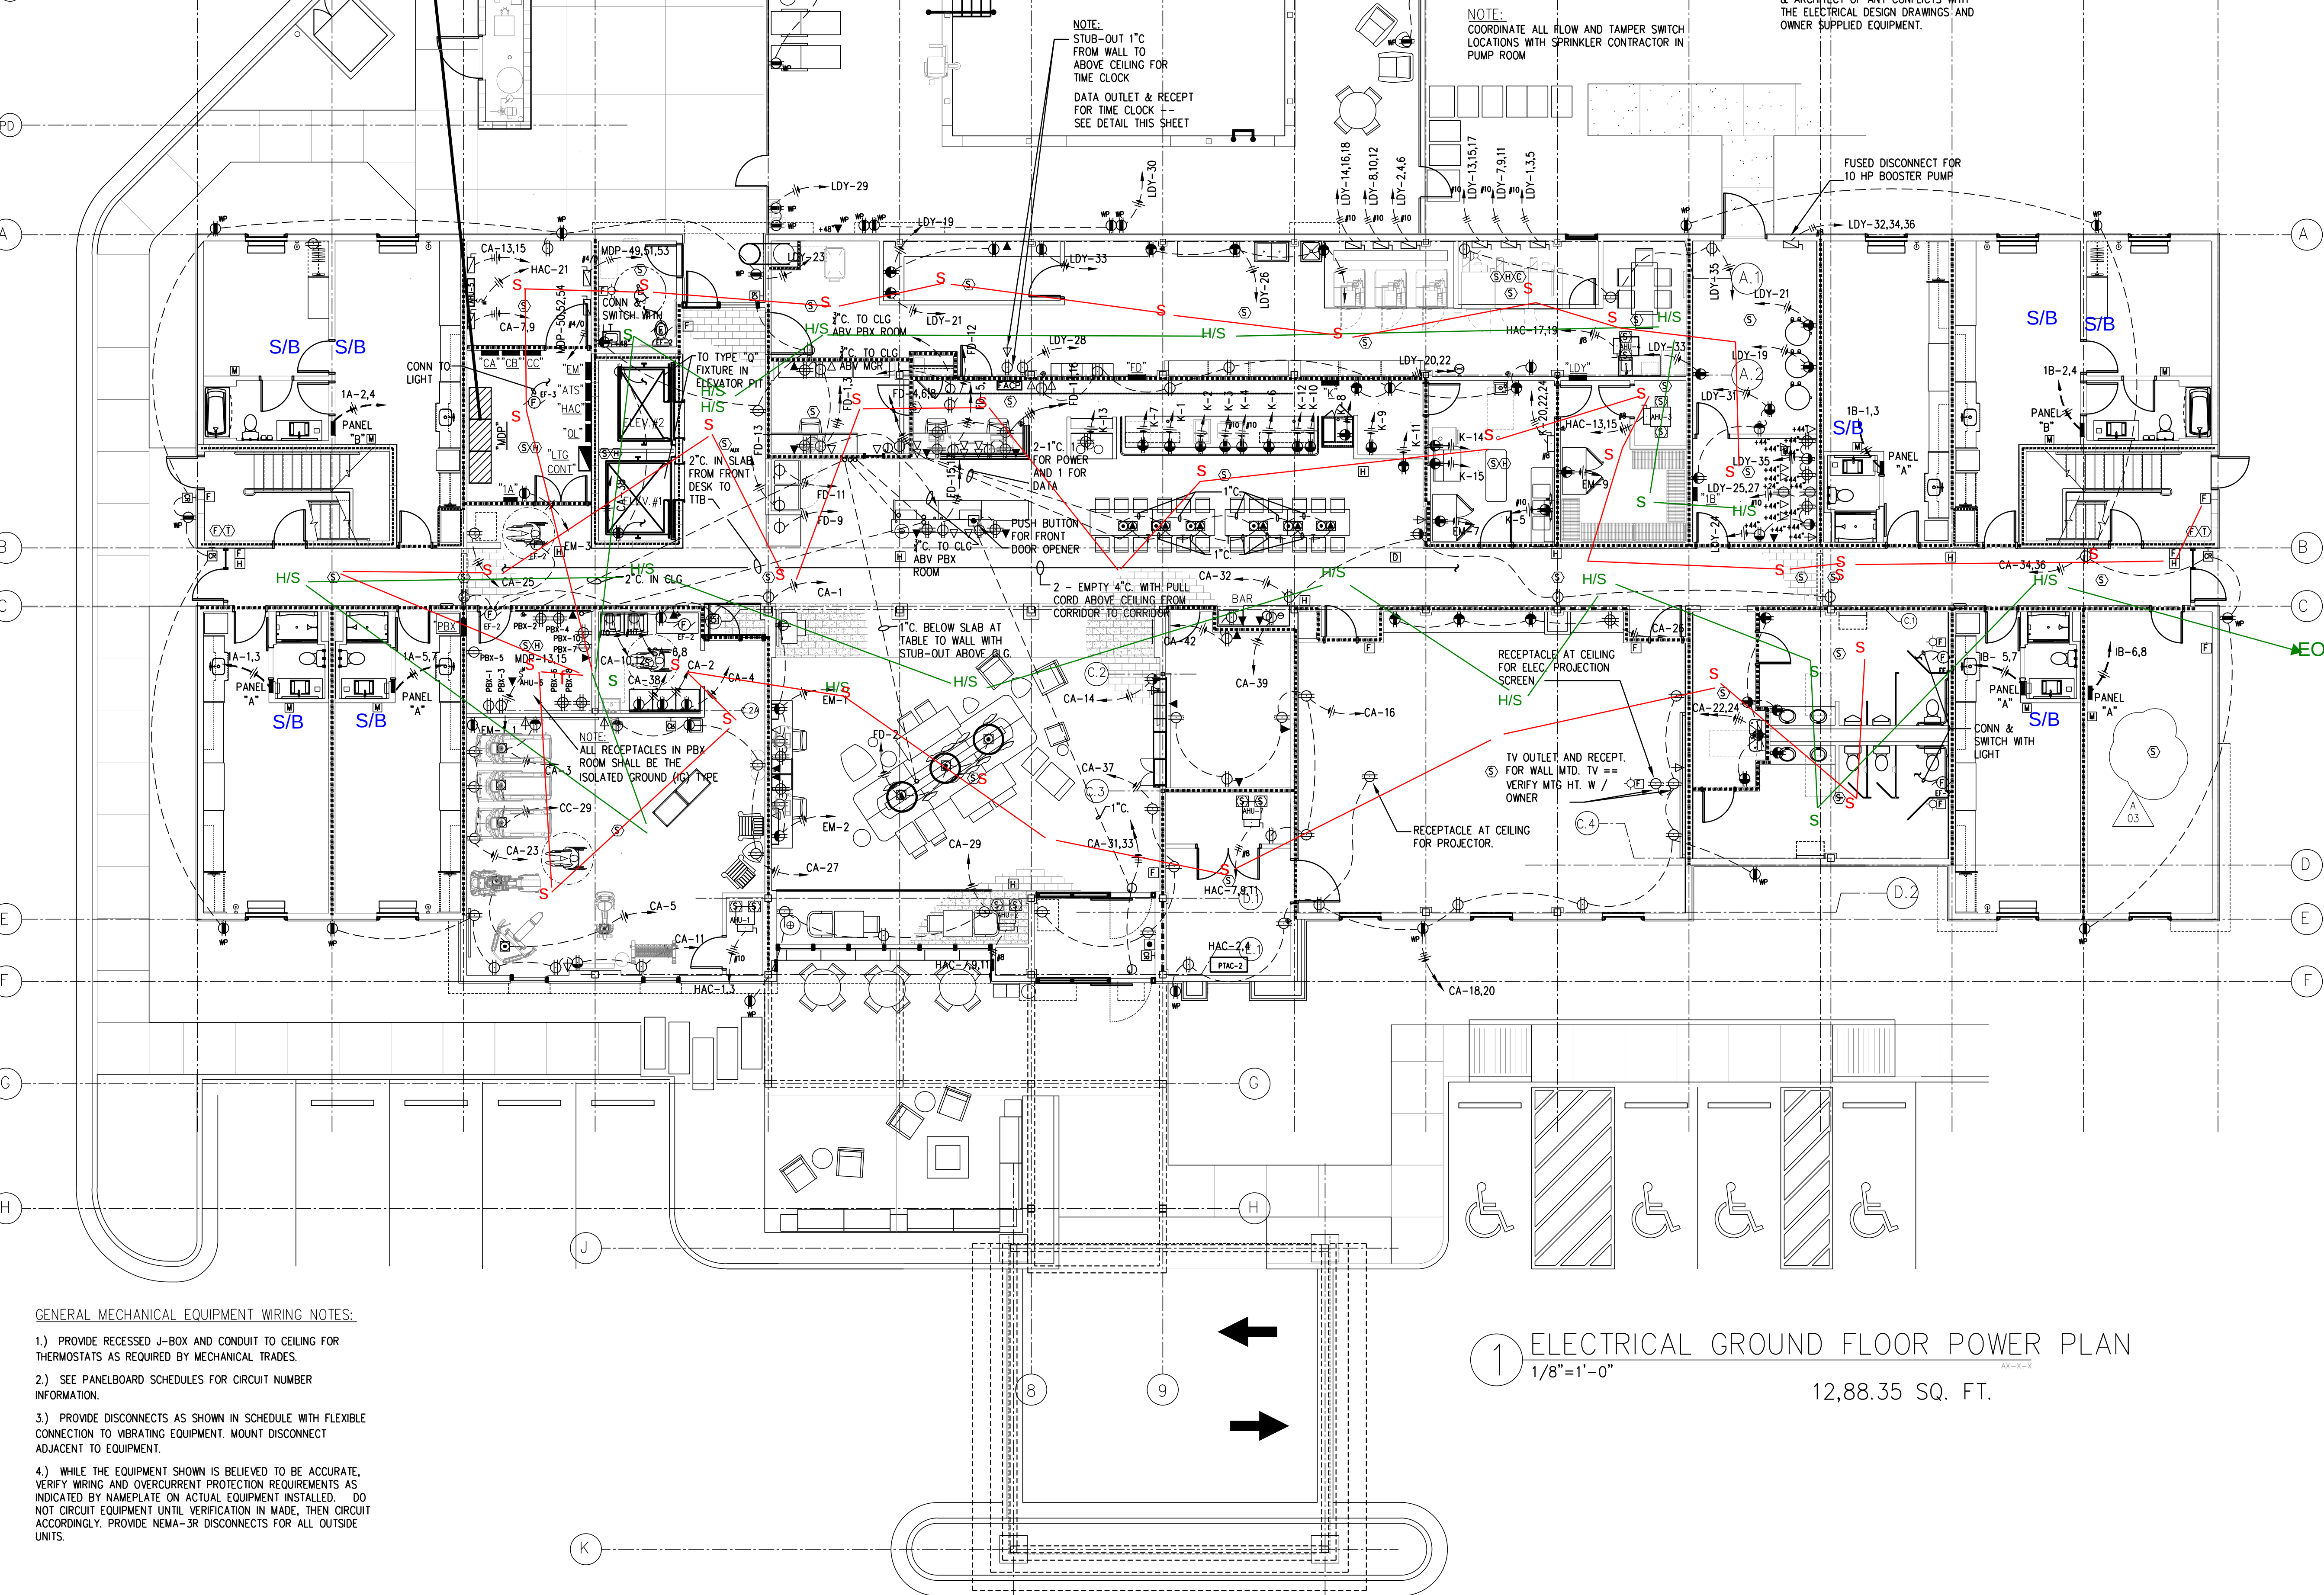

1 ELECTRICAL GROUND FLOOR POWER PLAN
1/8"=1'-0" 12,88.35 SQ. FT.

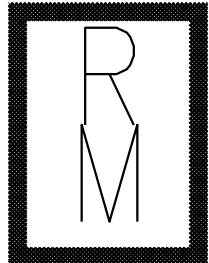

Richard Molenaar
ARCHITECT



INNOVATIVE • ENGINEERING
SERVICES, LLC
2787 Stage Center Dr.
Suite 101
Bartlett, Tennessee 38134
901-379-0500
www.innovativees-llc.com



PROJECT NAME:

HOME2
SUITES BY HILTON

Old Fannin Road Flowood, Mississippi

SHEET TITLE:
ELECTRICAL
GROUND FLOOR POWER PLAN

PROJECT NO. 13010	LATEST REVISION: 6/8/16	3
DRAWN BY: SA	CHECKED BY: RJH	SHEET NUMBER: E201
DATE: 06/08/16		