


16/4-SOUNDER
BASE

16/2-HORN/STROBES

SMOKES-18/2


RUN 1-16/4 & 1-18/2 FROM 2ND TO 3RD FROM 2ND
TO 1ST FLR

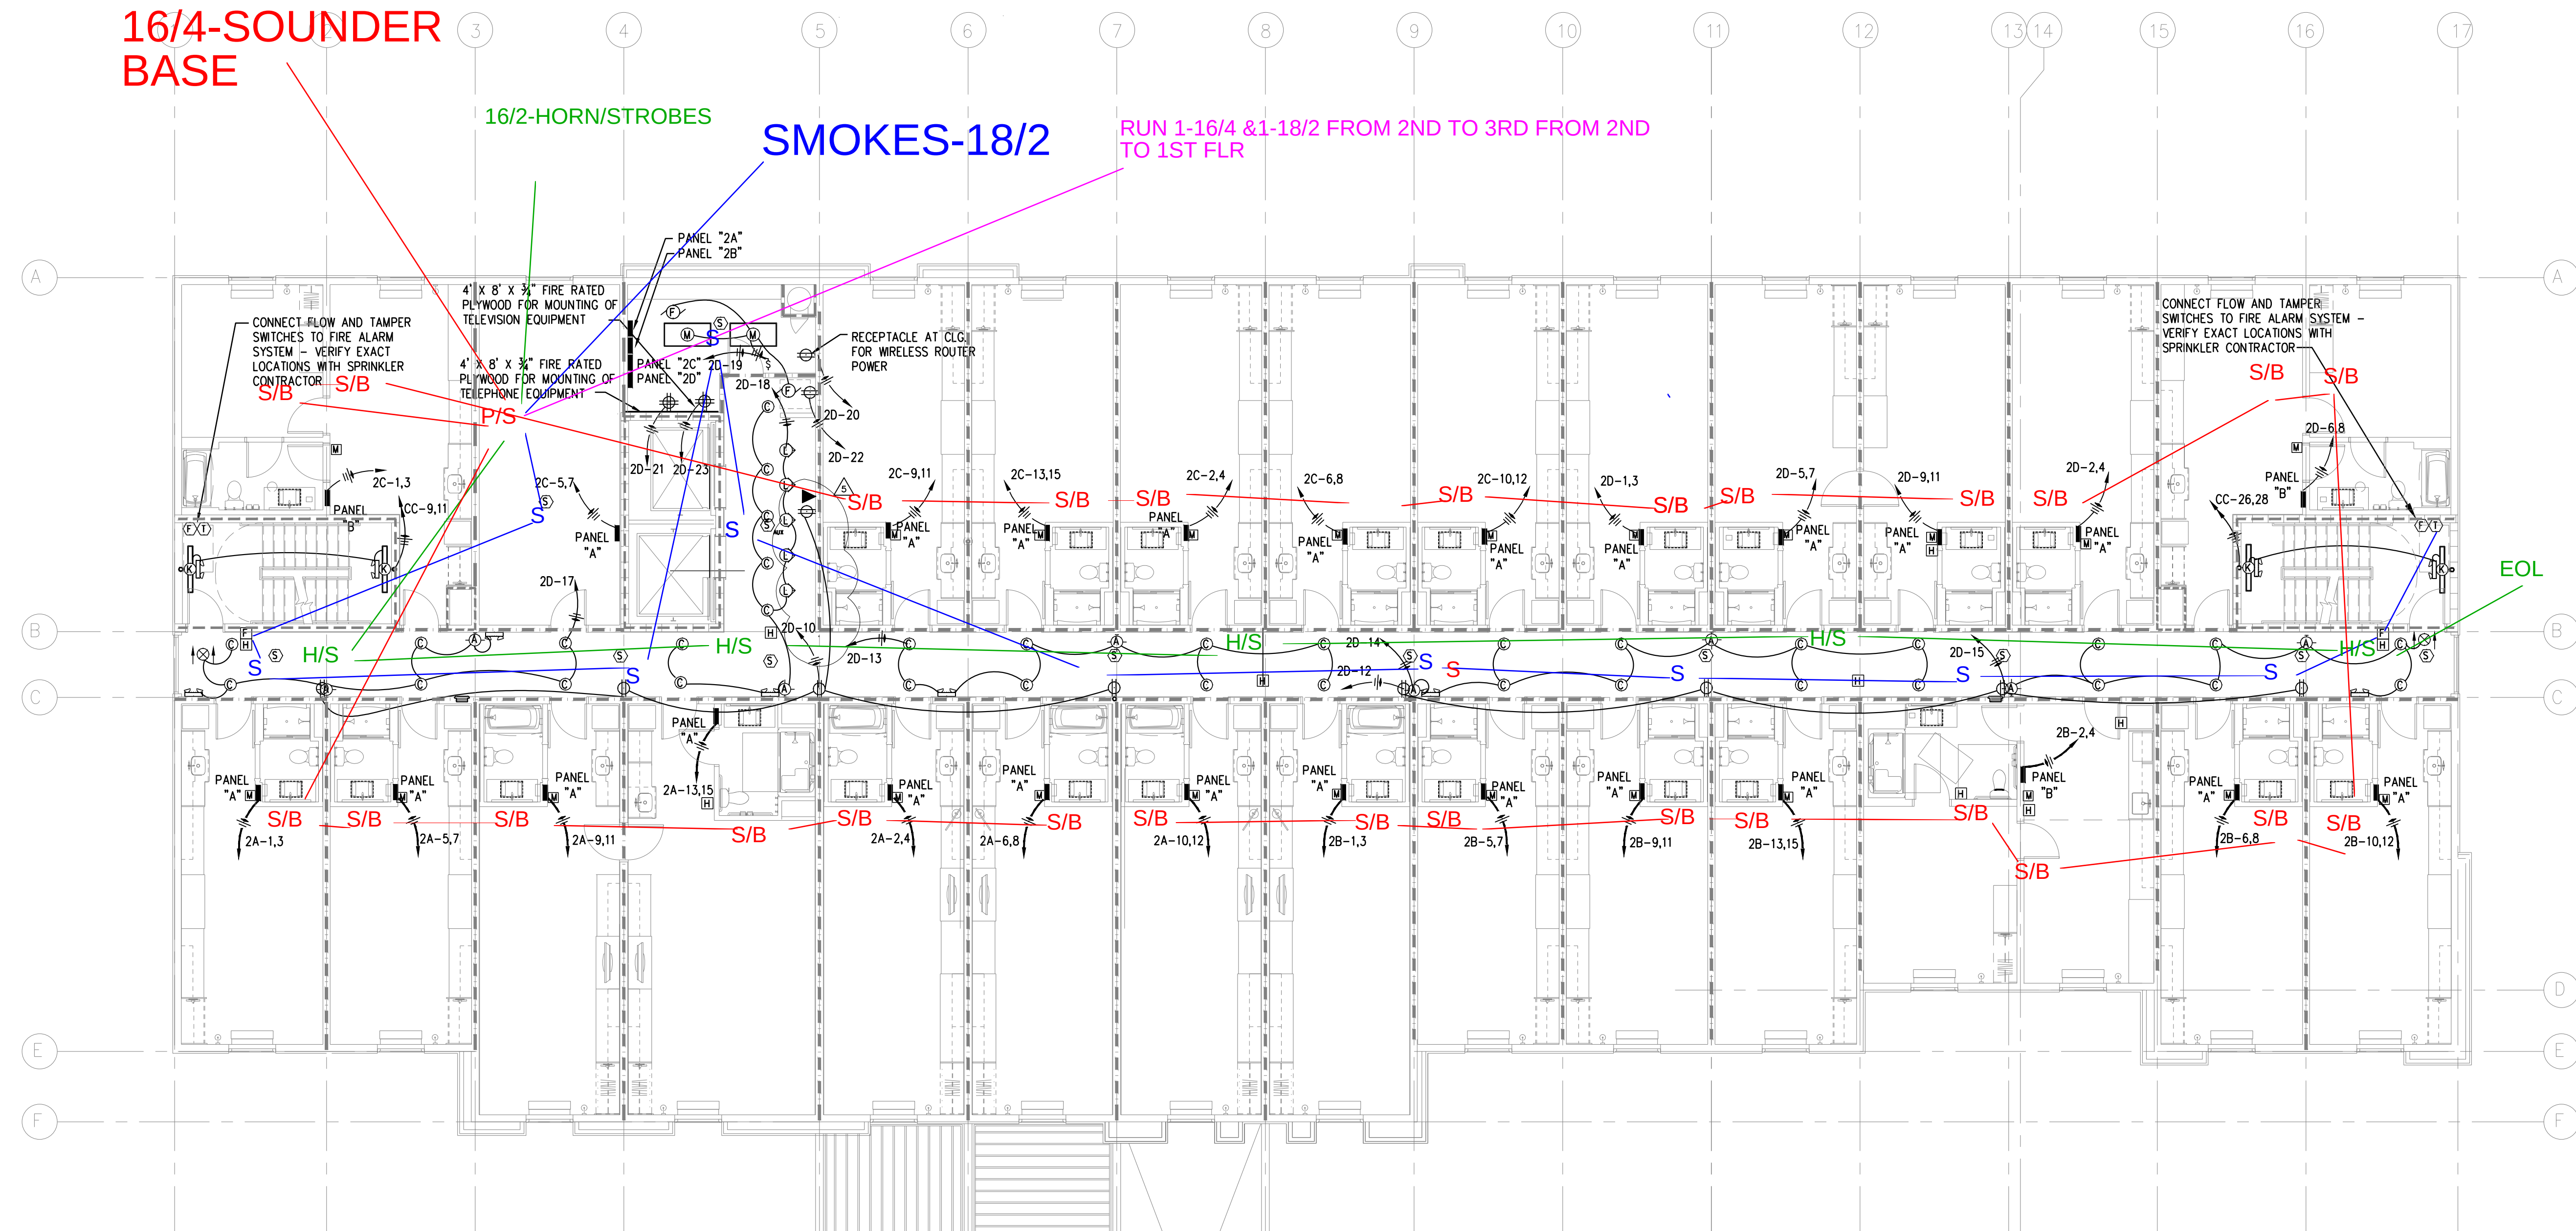

GENERAL NOTES THIS SHEET:

1.) INCREASE THE WIRE SIZE A MINIMUM OF ONE SIZE ON ALL 120V. HOME-RUNS OVER 100 FEET IN LENGTH. INCREASE THE WIRE SIZE A MINIMUM OF ONE SIZE FOR ALL 208V. HOME-RUNS OVER 150 FEET IN LENGTH.

2.) VERIFY THE ELECTRICAL REQUIREMENTS OF ALL MECHANICAL EQUIPMENT WITH THE MECHANICAL CONTRACTOR AND HIS SUPPLIER PRIOR TO ROUGH-IN.

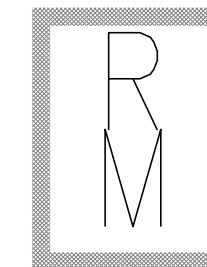

Richard Molenaar
ARCHITECT



INNOVATIVE • ENGINEERING
SERVICES, LLC

2787 Stage Center Dr.
Suite 101
Bartlett, Tennessee 38134
901-379-0500
www.innovativees-llc.com



PROJECT NAME:

HOME2
SUITES BY HILTON

Old Fannin Road Flowood, Mississippi

SHEET TITLE:
ELECTRICAL
SECOND FLOOR PLAN

PROJECT NO.
13010

LATEST REVISION:
08/23/16

DRAWN BY: SA
CHECKED BY: RJH

SHEET NUMBER:

DATE:
08/23/16

E203