


NEVELS ELECTRIC
FIRE ALARM


SMOKES/18/2

H/S-16/2

16/4-SOUNDER BASE

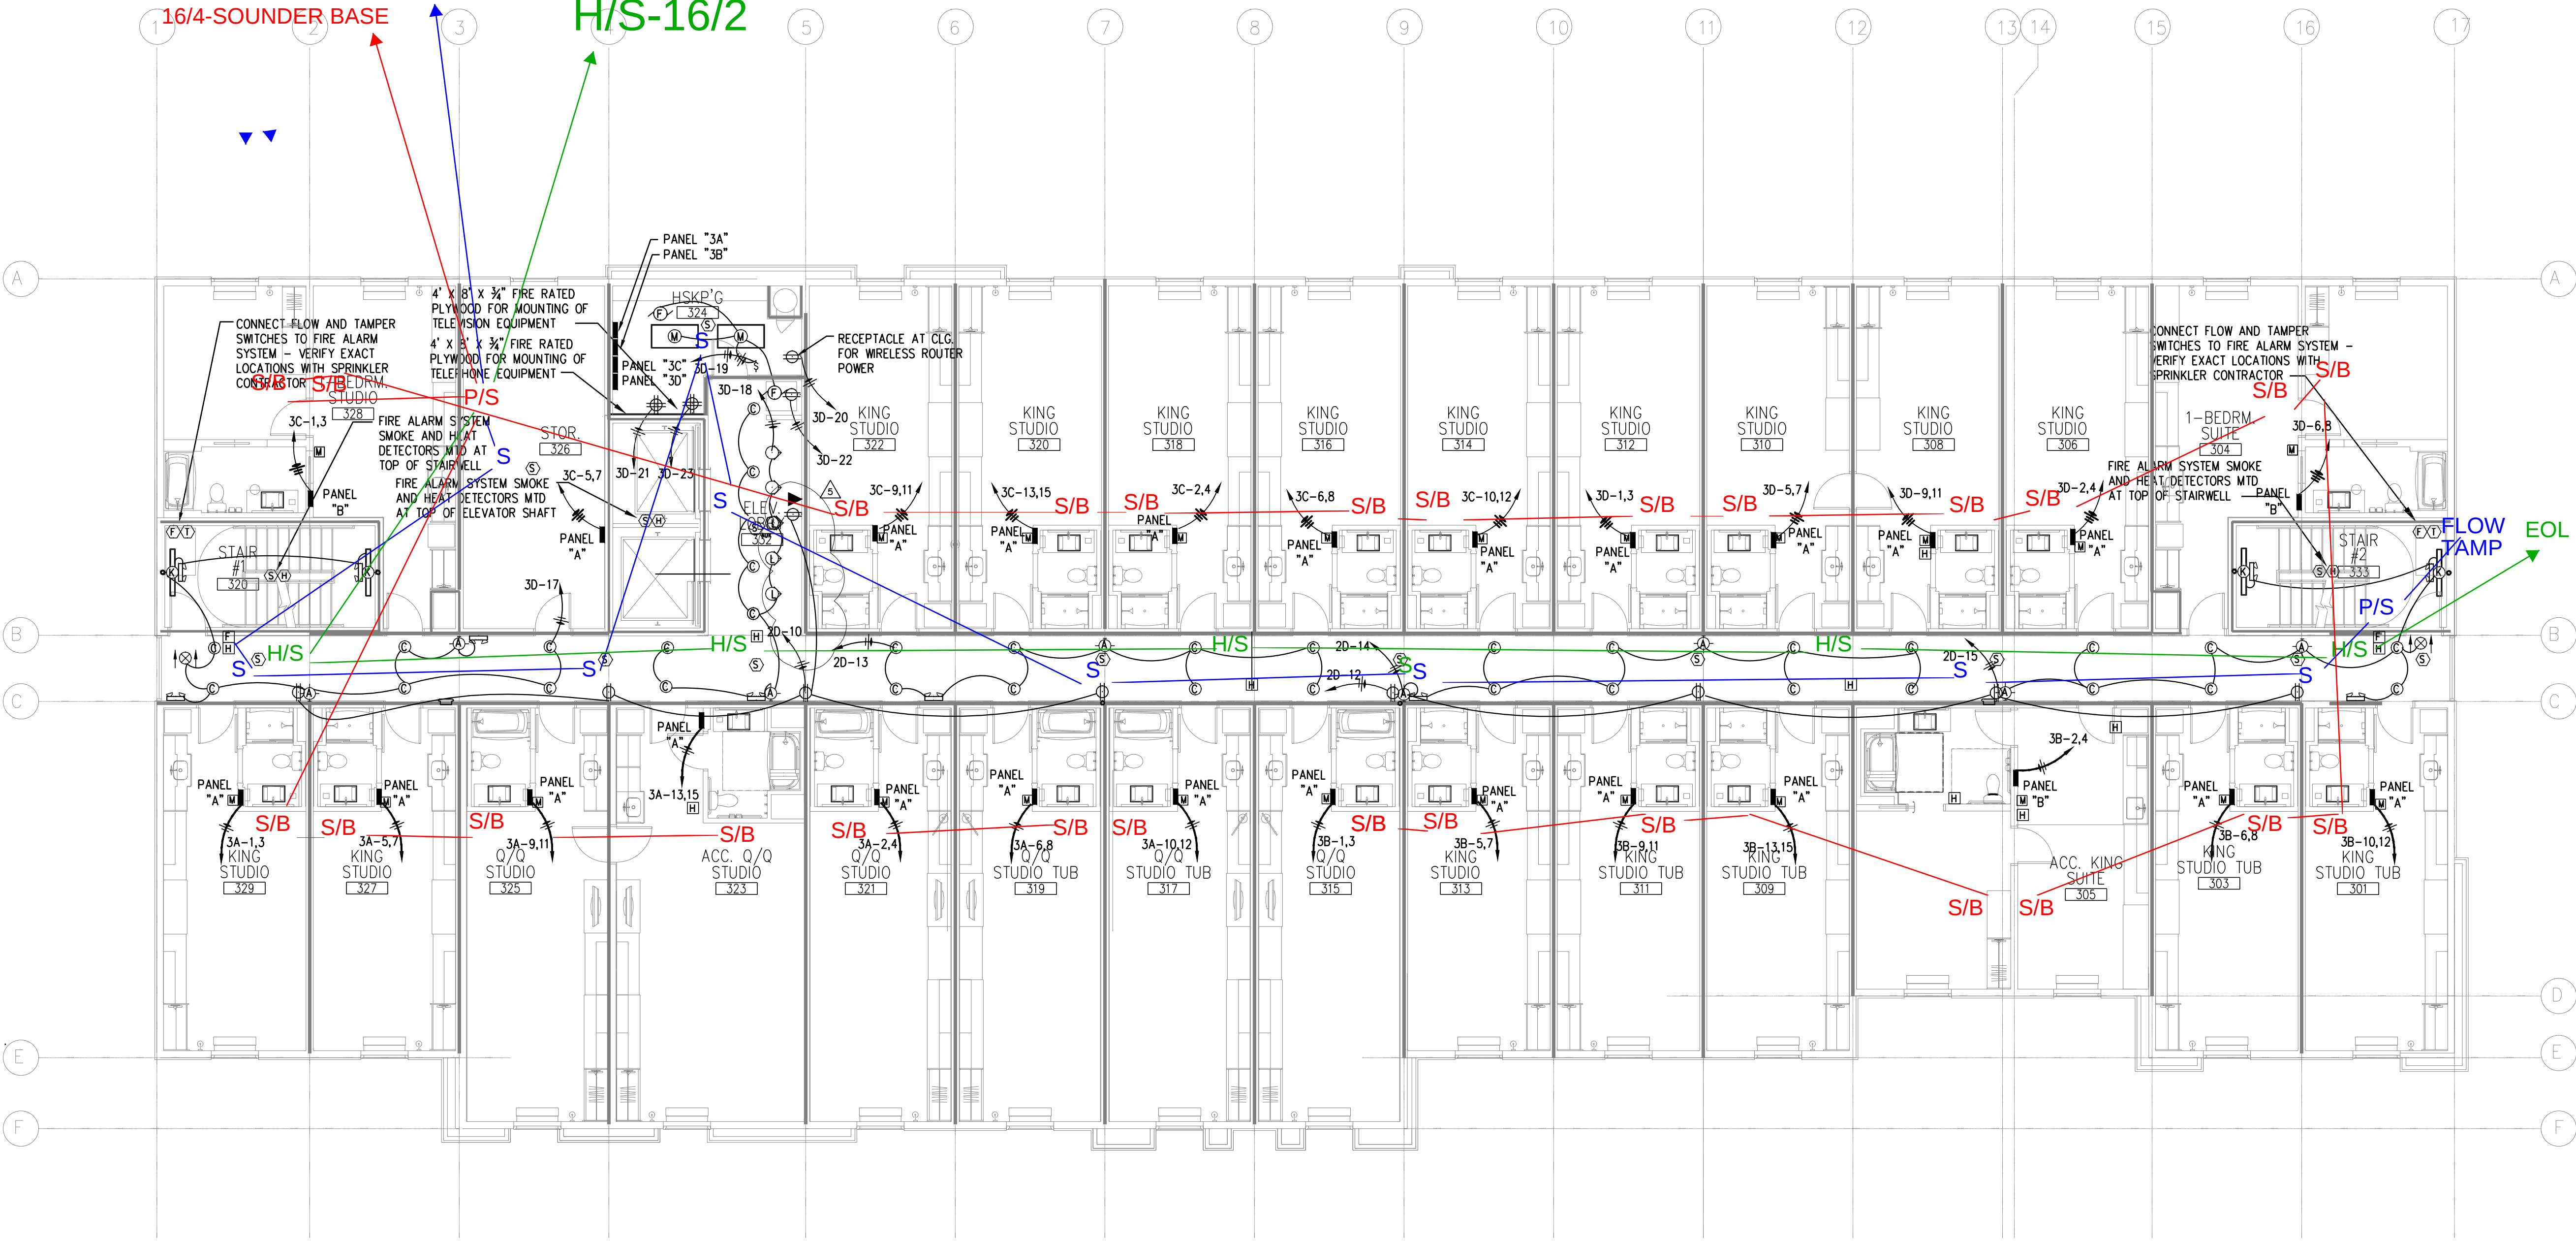

1 ELECTRICAL THIRD FLOOR PLAN
1/8"=1'-0"

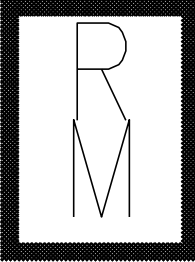

Richard Molenaar
ARCHITECT



INNOVATIVE • ENGINEERING
SERVICES, LLC

2787 Stage Center Dr.
Suite 101
Bartlett, Tennessee 38134
901-379-0500
www.innovativees-llc.com



PROJECT NAME:



Old Fannin Road Flowood, Mississippi

SHEET TITLE:
ELECTRICAL
THIRD FLOOR PALN

PROJECT NO.
13010

LATEST REVISION:
08/23/16

DRAWN BY: PTH
CHECKED BY: RJH

SHEET NUMBER:

DATE:
08/23/16

E204