



NEVEL ELECTRIC FIRE ALARM

SB-SOUNDER BASE (16/4)
S-SMOKE DETECTOR (18/2)
H/S-HORN STOBES (16/2)
1-16/4 @1-18/2 FROM 4TH
TO 5TH AND 4TH DOWN
TO 3RD

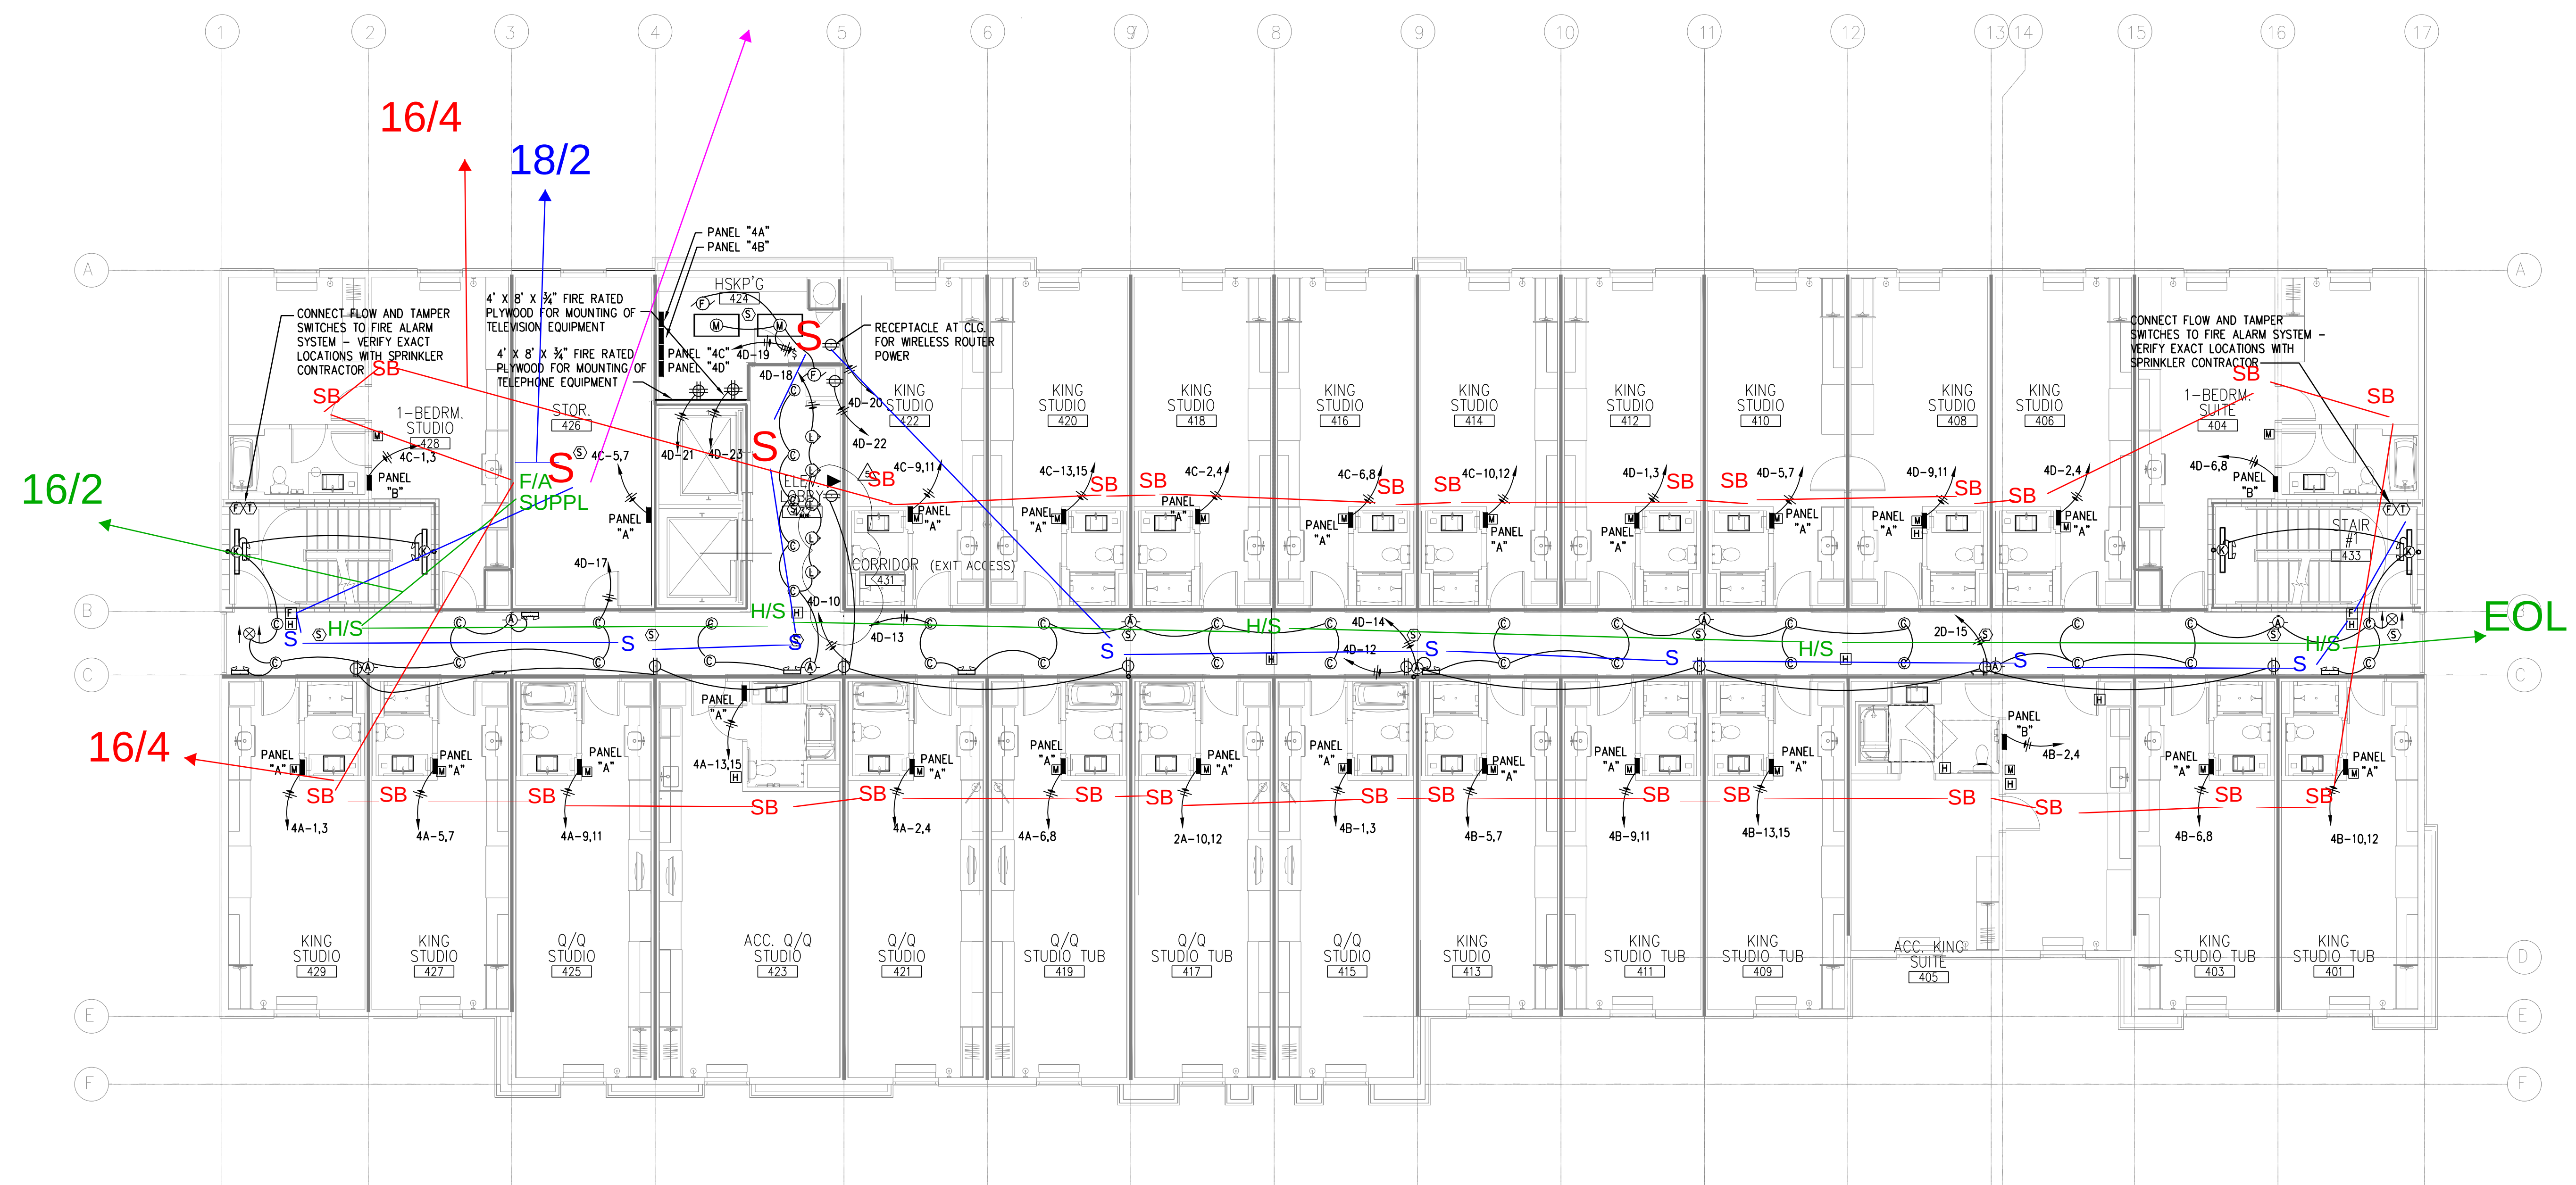

GENERAL NOTES THIS SHEET:
1.) INCREASE THE WIRE SIZE A MINIMUM OF ONE SIZE ON ALL 120V. HOME-RUNS OVER 100 FEET IN LENGTH. INCREASE THE WIRE SIZE A MINIMUM OF ONE SIZE FOR ALL 208V. HOME-RUNS OVER 150 FEET IN LENGTH.
2.) VERIFY THE ELECTRICAL REQUIREMENTS OF ALL MECHANICAL EQUIPMENT WITH THE MECHANICAL CONTRACTOR AND HIS SUPPLIER PRIOR TO ROUGH-IN.

① ELECTRICAL FOURTH FLOOR PLAN
1/8"=1'-0"

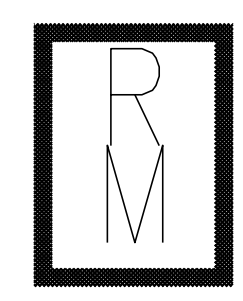

Richard Molenaar
ARCHITECT



2787 Stage Center Dr.
Suite 101
Bartlett, Tennessee 38134
901-379-0500
www.innovativees-llc.com



PROJECT NAME:



Old Fannin Road Flowood, Mississippi

SHEET TITLE:

ELECTRICAL
FOURTH FLOOR PLAN

PROJECT NO.

13010

LATEST REVISION:

08/23/16



DRAWN BY:

PTH

CHECKED BY:

RJH

SHEET NUMBER:

DATE:

08/23/16

E205