


Richard Molenaar
ARCHITECT



PROJECT NAME:
HOMER2
SUITES BY HILTON
W Maine Street West Monroe, Louisiana

PROJECT NO. 13010
DRAWN BY: CJ
CHECKED BY: [Signature]
SHEET NUMBER: A106
DATE: Sept 5, 2014

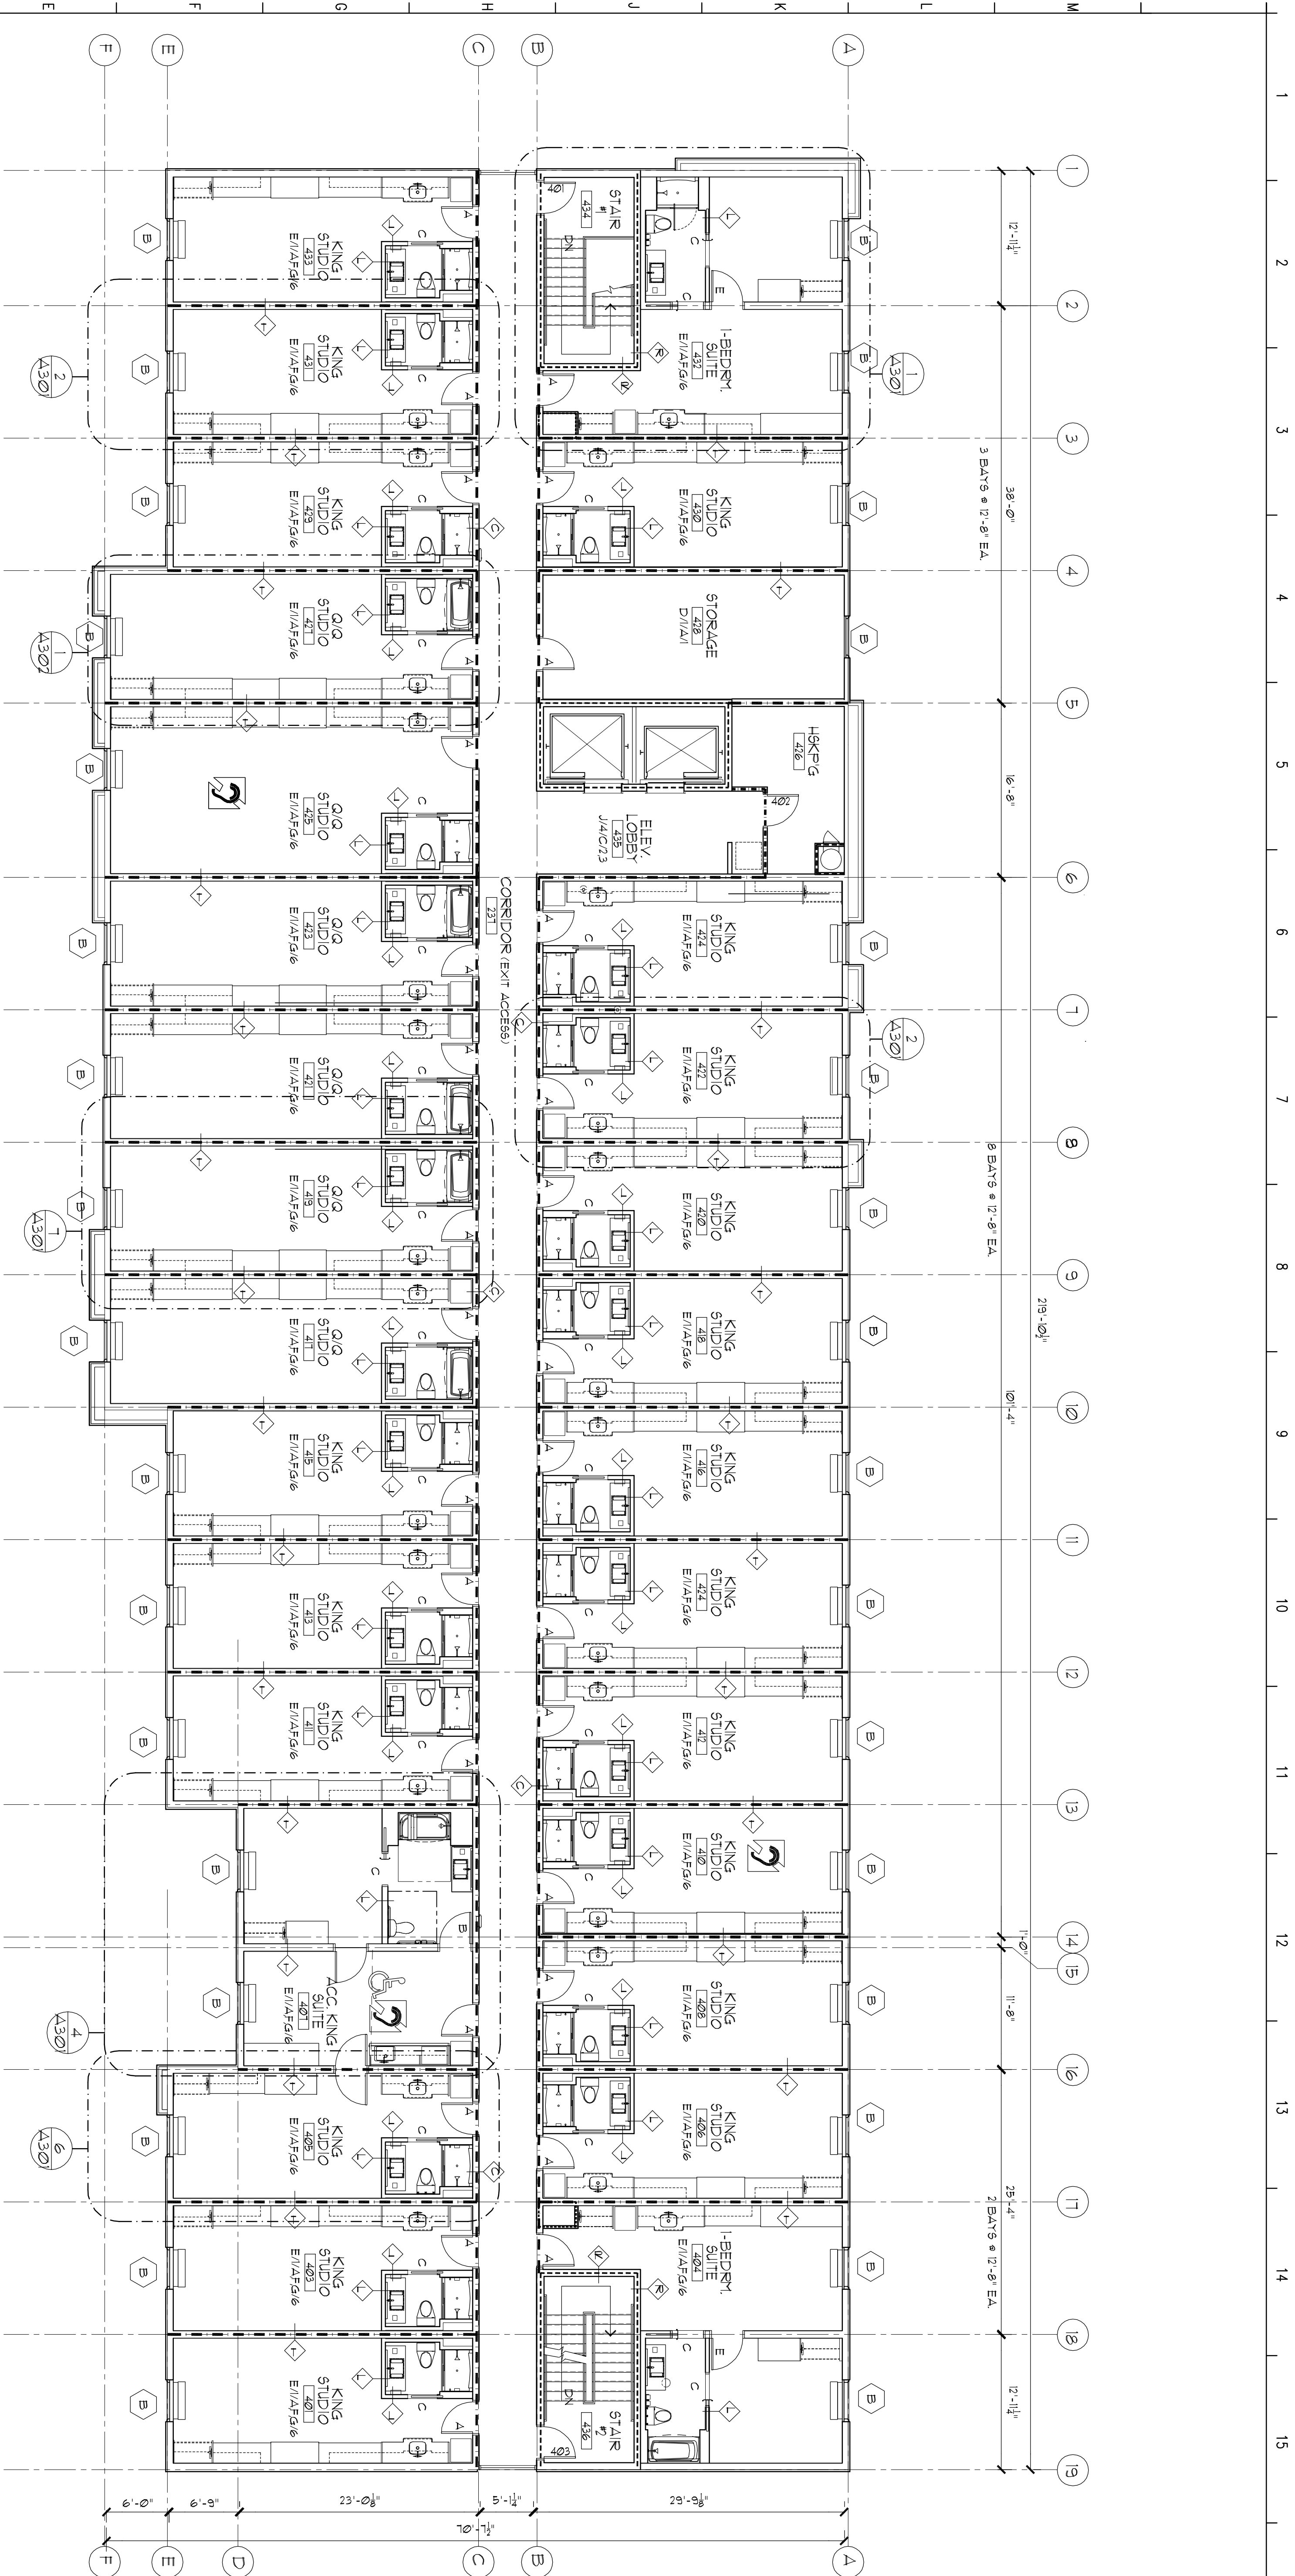

1 4th FLOOR PLAN
1/8" = 1'-0"

FINISH SCHEDULE		
Room Number	Room Name	Room Name
437	Corridor	Corridor
438	Elevator Lobby	Elevator Lobby
439	King Studio	King Studio
440	Queen Studio	Queen Studio
441	1-Bedroom Suite	1-Bedroom Suite
442	Storage	Storage
443	H&P G	H&P G
444	Stair	Stair

- LEGEND
- TYPE 2A FIRE EXTINGUISHER & APPROPRIATE
SEMI-RECESSED CABINET (MAX. PROJECTION: 4")
SEE 2/1602.
- TYPE 2A FIRE EXTINGUISHER BRACKETED
TO WALL
- SELV DRAIN IN REVERSE
- DENOTES 1 HR. FIRE RATING
- DENOTES 2 HR. FIRE RATING
- GUEST ROOM WITH ACCESSIBILITY
ROUTE TO COMPLY WITH ADAAG
- GUEST ROOM WITH VISUAL ALARMS
NOTIFICATION DEVICES & TELEPHONES
TO COMPLY WITH ADAAG

FIRE PROTECTION SYSTEMS

- THE FIRE PROTECTION CONTRACTOR SHALL PROVIDE
THE FOLLOWING:
- SUBMIT SHOP DRAWINGS TO AND OBTAIN
APPROVALS FROM GOVERNING AUTHORITIES
REGARDING THE FIRE PROTECTION SYSTEMS
TO BE PROVIDED.
 - PROVIDE WATER PROTECTION FOR THE BUILDING
AREA IN ACCORDANCE WITH IBC 903.3.1.1.1
(MFR 13)
 - PROVIDE A CLASS 1 STANDPIPE SYSTEM IN
ACCORDANCE WITH IBC 903.3.1, EXCEPTION 1.
 - COORDINATE INSTALLATION WITH G.C.

REISSUED: OCT17/2014