


Richard Molenaar

ARCHITECT

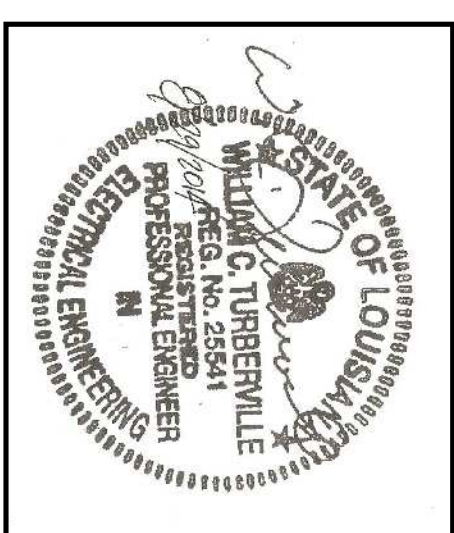


HOME2
SUITES BY HILTON

W Mane Street West Monroe, Louisiana

SHEET TITLE

ELECTRICAL SITE PLAN

PROJECT NO.	LATEST REVISION:
PROJ.#	11-12-2014
DRAWN BY:	CHECKED BY:
SMU	SMU
DATE:	SHEET NUMBER:
DATE	E101

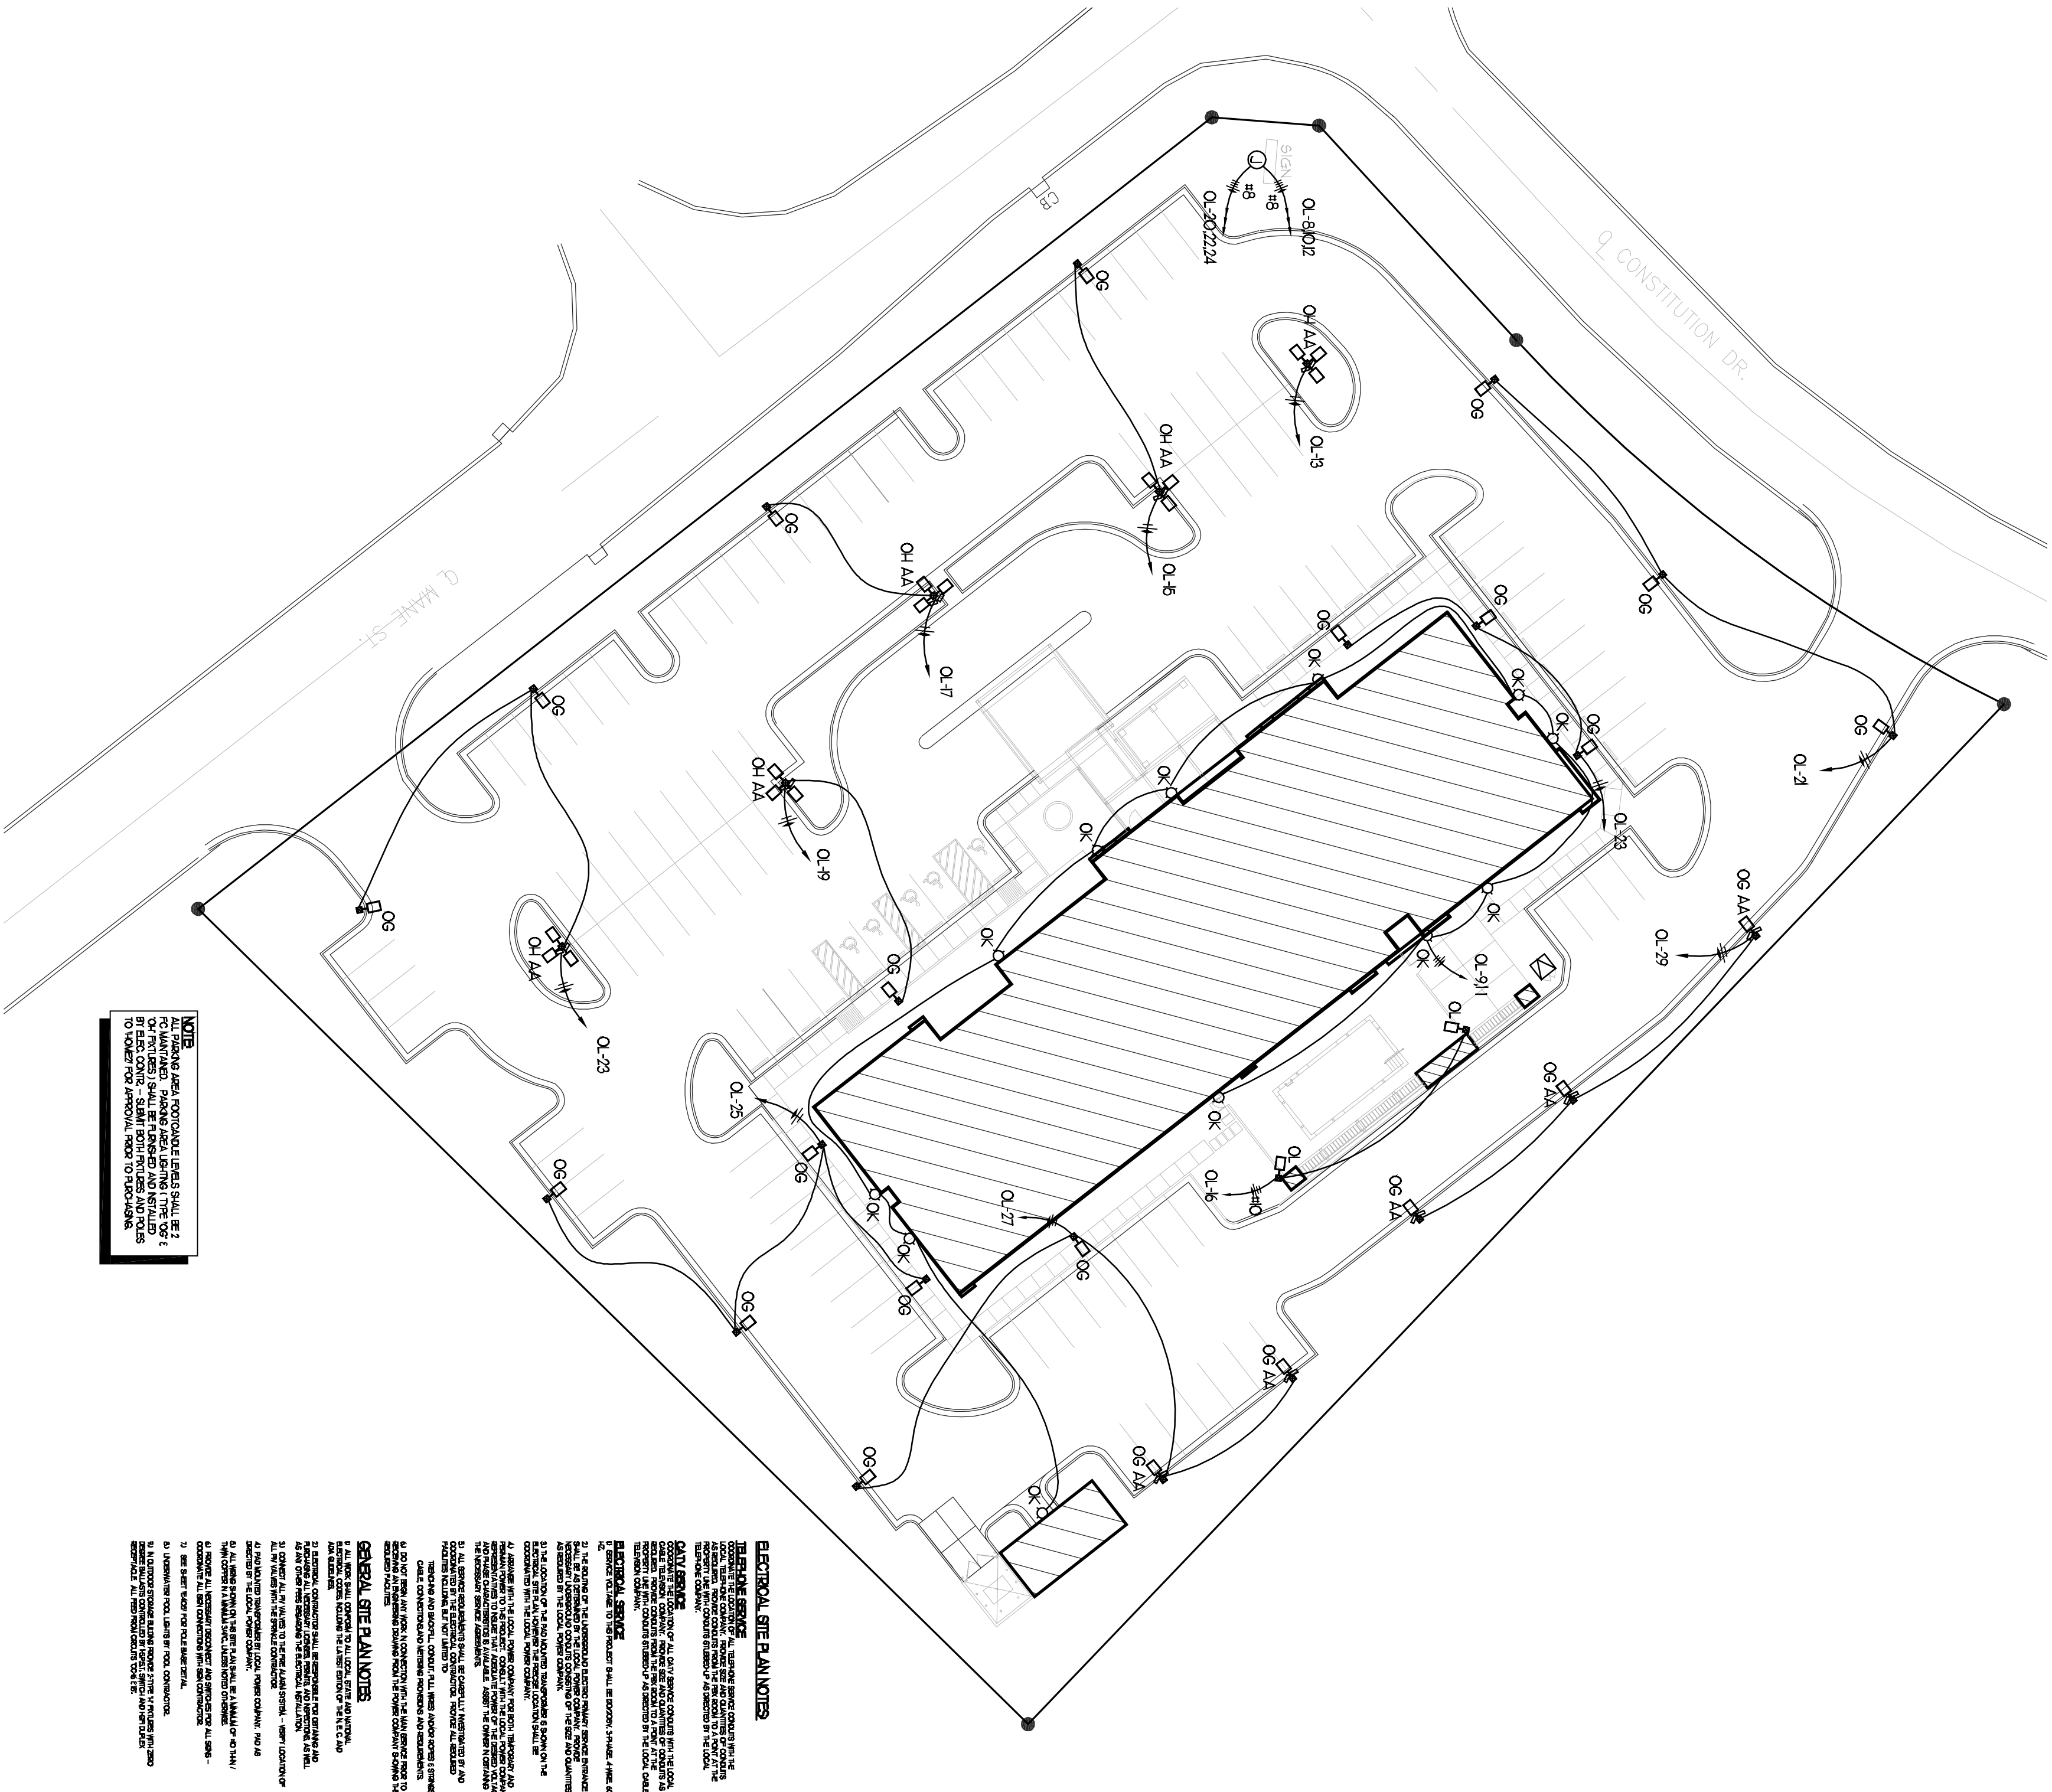

LIGHTING FIXTURE SCHEDULE

LIGHTING FIXTURE SCHEDULE									
MARK	WFS	CATALOG NUMBER	QTY.	LUMENS W/ M.F.T.E	VO13	NOTING	REMARKS		
A	OVERHEAD CONVENTOR RETIRED	OVERHEAD CONVENTOR RETIRED	RETIRED	100W MAX	20V	WALL LTD.	FLOOREST WALL BRACKET FLOOR CONVENTOR - BERRY MOUNTING FROM THE CHECK		
B	PORTHOLE CONVENTOR	CLAMP HUNG	1	40WATT CFL	20V	RECESS	FLOOREST DOWNLIGHT WITH WALL - PROVIDE EGRESS BATTERY BACKUP BATTERY SHIELD		
C	PORTHOLE CONVENTOR	CLAMP HUNG RECESSED	2	30W CDT	20V	RECESS	FLOOREST DOWNLIGHT FLOOREST ENTRY		
D	OVERHEAD CONVENTOR RETIRED	OVERHEAD CONVENTOR RETIRED	2	30W TR	20V	WALL MT ABOVE	4" WALL MOUNTED FLOOREST TRIMMER - 1/2" WALL MOUNT BRACKET BATTERY BACKUP		
D1	OVERHEAD CONVENTOR RETIRED	OVERHEAD CONVENTOR RETIRED	TO BE RETIRED	100W MAX	20V	RECUANT	RECUANT RECUANT FLOOREST GLASS		
D2	OVERHEAD CONVENTOR RETIRED	OVERHEAD CONVENTOR RETIRED	TO BE RETIRED	500W MAX	20V	RECUANT	RECUANT RECUANT FLOOREST CENTER		
D3	OVERHEAD CONVENTOR RETIRED	OVERHEAD CONVENTOR RETIRED	TO BE RETIRED	100W MAX	20V	RECUANT	RECUANT RECUANT FLOOREST CENTER		
D4	OVERHEAD CONVENTOR RETIRED	OVERHEAD CONVENTOR RETIRED	TO BE RETIRED	170W TR	20V	WALL MT ABOVE	4" WALL MOUNTED FLOOREST TRIMMER - 1/2" WALL MOUNT BRACKET BATTERY BACKUP		
E	NOT USED	NOT USED	NOT USED	NOT USED	NOT USED	NOT USED	NOT USED		
F	NOT USED	NOT USED	NOT USED	NOT USED	NOT USED	NOT USED	NOT USED		
G	RECESS (CONVENTOR)	CLAMP HUNG TR	1	30W TR	20V	CORE	RECESSED CORE LIGHT		
H	RETIRED CONVENTOR	CLAMP HUNG TR	3	30W TR	20V	RECESS	2 1/2" WALL MOUNTED FLOOREST TRIMMER - 1/2" WALL MOUNT BRACKET WHERE NECESSARY		
I	RETIRED CONVENTOR	CLAMP HUNG TR	2	30W TR	20V	WALL LTD.	WALL MOUNTED FLOOREST TRIMMER IN PANEL		
J	RETIRED CONVENTOR	CLAMP HUNG TR	2	30W TR	20V	RECESS	WALL MOUNTED FLOOREST TRIMMER IN PANEL		
K	RETIRED CONVENTOR	CLAMP HUNG TR	2	30W TR	20V	RECESS	WALL MOUNTED FLOOREST TRIMMER IN PANEL		
L	RETIRED CONVENTOR	CLAMP HUNG TR	2	30W TR	20V	RECESS	WALL MOUNTED FLOOREST TRIMMER IN PANEL		
M	RETIRED CONVENTOR	CLAMP HUNG TR	3	30W TR	20V	RECESS	2 1/2" WALL MOUNTED FLOOREST TRIMMER - 1/2" WALL MOUNT BRACKET WHERE NECESSARY		
N	RECESS (CONVENTOR)	CLAMP HUNG TR	1	30W TR	20V	RECESS	RECESSED LOW CLEARANCE DOWN - SUBMITTIVE FOR C/O UPPER FLOOR ELEVATOR SHIELD WITH LOW CLEARANCE		
P	WALL CONVENTOR	CLAMP HUNG TR	1	100W	20V	RECESS	WALL MOUNTED FLOOREST TRIMMER IN PANEL		
Q	RETIRED CONVENTOR	CLAMP HUNG TR	1	100W	20V	RECESS	WALL MOUNTED FLOOREST TRIMMER IN PANEL		
R	RECESS (CONVENTOR)	CLAMP HUNG TR	1	30W TR	20V	RECESS	RECESSED LOW CLEARANCE DOWN - SUBMITTIVE FOR C/O UPPER FLOOR ELEVATOR SHIELD WITH LOW CLEARANCE		
S	STONCO	WALL HUNG	1	100W	20V	WALL LTD.	WALL MOUNTED FLOOREST TRIMMER IN PANEL		
T	HUNG	WALL HUNG	2	30W TR	20V	WALL LTD.	WALL MOUNTED FLOOREST TRIMMER IN PANEL		
U	NOT USED	NOT USED	NOT USED	NOT USED	NOT USED	NOT USED	NOT USED		
V	NOT USED	NOT USED	NOT USED	NOT USED	NOT USED	NOT USED	NOT USED		
W	WALL HUNG	WALL HUNG	2	100W	20V	WALL LTD.	WALL MOUNTED FLOOREST TRIMMER IN PANEL		
X	SEE SYMBOLS LEGEND	SEE SYMBOLS LEGEND	NA	SEE SYMBOLS LEGEND	20V	SEE SYMBOLS LEGEND	SEE SYMBOLS LEGEND		
Y	WALL HUNG	WALL HUNG	1	100W	20V	WALL LTD.	WALL MOUNTED FLOOREST TRIMMER IN PANEL		
ZA	WALL HUNG	WALL HUNG	1	100W	20V	WALL LTD.	WALL MOUNTED FLOOREST TRIMMER IN PANEL		
ZB	WALL HUNG	WALL HUNG	1	100W	20V	WALL LTD.	WALL MOUNTED FLOOREST TRIMMER IN PANEL		
ZC	WALL HUNG	WALL HUNG	1	100W	20V	WALL LTD.	WALL MOUNTED FLOOREST TRIMMER IN PANEL		
ZD	WALL HUNG	WALL HUNG	1	100W	20V	WALL LTD.	WALL MOUNTED FLOOREST TRIMMER IN PANEL		
ZE	WALL HUNG	WALL HUNG	1	100W	20V	WALL LTD.	WALL MOUNTED FLOOREST TRIMMER IN PANEL		
ZF	WALL HUNG	WALL HUNG	1	100W	20V	WALL LTD.	WALL MOUNTED FLOOREST TRIMMER IN PANEL		
ZG	WALL HUNG	WALL HUNG	1	100W	20V	WALL LTD.	WALL MOUNTED FLOOREST TRIMMER IN PANEL		
ZH	WALL HUNG	WALL HUNG	1	100W	20V	WALL LTD.	WALL MOUNTED FLOOREST TRIMMER IN PANEL		
ZI	WALL HUNG	WALL HUNG	1	100W	20V	WALL LTD.	WALL MOUNTED FLOOREST TRIMMER IN PANEL		
ZJ	WALL HUNG	WALL HUNG	1	100W	20V	WALL LTD.	WALL MOUNTED FLOOREST TRIMMER IN PANEL		
ZK	WALL HUNG	WALL HUNG	1	100W	20V	WALL LTD.	WALL MOUNTED FLOOREST TRIMMER IN PANEL		
ZL	WALL HUNG	WALL HUNG	1	100W	20V	WALL LTD.	WALL MOUNTED FLOOREST TRIMMER IN PANEL		
ZM	WALL HUNG	WALL HUNG	1	100W	20V	WALL LTD.	WALL MOUNTED FLOOREST TRIMMER IN PANEL		
ZN	WALL HUNG	WALL HUNG	1	100W	20V	WALL LTD.	WALL MOUNTED FLOOREST TRIMMER IN PANEL		
ZO	WALL HUNG	WALL HUNG	1	100W	20V	WALL LTD.	WALL MOUNTED FLOOREST TRIMMER IN PANEL		
ZP	WALL HUNG	WALL HUNG	1	100W	20V	WALL LTD.	WALL MOUNTED FLOOREST TRIMMER IN PANEL		
ZQ	WALL HUNG	WALL HUNG	1	100W	20V	WALL LTD.	WALL MOUNTED FLOOREST TRIMMER IN PANEL		
ZR	WALL HUNG	WALL HUNG	1	100W	20V	WALL LTD.	WALL MOUNTED FLOOREST TRIMMER IN PANEL		
ZS	WALL HUNG	WALL HUNG	1	100W	20V	WALL LTD.	WALL MOUNTED FLOOREST TRIMMER IN PANEL		
ZT	WALL HUNG	WALL HUNG	1	100W	20V	WALL LTD.	WALL MOUNTED FLOOREST TRIMMER IN PANEL		
ZU	WALL HUNG	WALL HUNG	1	100W	20V	WALL LTD.	WALL MOUNTED FLOOREST TRIMMER IN PANEL		
ZV	WALL HUNG	WALL HUNG	1	100W	20V	WALL LTD.	WALL MOUNTED FLOOREST TRIMMER IN PANEL		
ZW	WALL HUNG	WALL HUNG	1	100W	20V	WALL LTD.	WALL MOUNTED FLOOREST TRIMMER IN PANEL		
ZX	WALL HUNG	WALL HUNG	1	100W	20V	WALL LTD.	WALL MOUNTED FLOOREST TRIMMER IN PANEL		
ZY	WALL HUNG	WALL HUNG	1	100W	20V	WALL LTD.	WALL MOUNTED FLOOREST TRIMMER IN PANEL		
ZZ	WALL HUNG	WALL HUNG	1	100W	20V	WALL LTD.	WALL MOUNTED FLOOREST TRIMMER IN PANEL		

- 1.) ALL FLUORESCENT LAMPS SHALL BE WARM WHITE.
- 2.) ALL EXTERIOR FIXTURES SHALL BE LABELED W/ET OR DAMP LOCATIONS AS DETERMINED BY THEIR LOCATIONS
- 3.) ALL POOL AREA FIXTURES SHALL BE EQUIPPED WITH GFC PROTECTION.
- 4.) VERIFY ALL MOUNTING HEIGHTS WITH ARCHITECT PRIOR TO ROUGH-IN.

ELECTRICAL SITE PLAN NOTES

TELEPHONE SERVICE
COORDINATE THE LOCATION OF ALL TELEPHONE SERVICE COUNCILS WITH THE LOCAL TELEPHONE COMPANY. PROVIDE SIZE AND QUANTITIES OF COUNCILS AS REQUESTED. PROVIDE COUNCILS FROM THE PER ROOM TO A POINT AT THE PROPERTY LINE. (FURNITURE COUNCILS) AS DIRECTED BY THE LOCAL TELEPHONE COMPANY.

CABLE SERVICE: COORDINATE THE LOCATION OF ALL CABLE SERVICE CONSULTS WITH THE LOCAL CABLE TELEVISION COMPANY. PROVIDE SIZE AND QUANTITIES OF CONSULTS AS REQUESTED. PROVIDE CONSULTS FROM THE PERIOD TO A POINT AT THE FUTURE DATE WITH CONSULTS STAGED-UP AS DIRECTED BY THE LOCAL CABLE TELEVISION COMPANY.

ELECTRICAL SERVICE
2) SERVICE VOLTAGE TO THE PROJECT SHALL BE 20,000V, 3-PHASE, 4-WIRE, 60 HZ.

AS REQUESTED BY THE LOCAL POWER COMPANY.

3) ALL SERVICE REQUIREMENTS SHALL BE CATERALLY MAINTAINED BY AND COORDINATED BY THE ELECTRICAL CONTRACTOR. PROVIDE ALL REQUIRED MATERIALS INCLUDING, BUT NOT LIMITED TO:

TEMPERATURE AND HUMIDITY, CORRUPT, ROLL, PRESS, AND/OR BONDING & STRENGTH. CONTRACTORS AND VENDORS PROVIDING AND REQUIREMENTS. IS DO NOT BEGIN ANY WORK IN CONNECTION WITH THE MAIN SERVICE PRIOR TO RECEIVING AN APPROVED DRAWING FROM THE POWER COMPANY & OBTAINING THE REQUIRED PERMITS.

GENERAL SITE PLAN NOTES

25. I HAVE NO COMMENTS TO MAKE REGARDING THE ELECTRICAL INSTALLATION.

- 3. ALL WIRING BORN OF THE BITE SHALL BE A MINIMUM OF 18 AWG / 17 AWG COPPER IN A MINIMUM SIZE, LISTED FOR THE SERVICE.
- 4. REMOVE ALL NECESSARY DISCONNECT AND SWITCHES FOR ALL SERVICE COORDINATE ALL WITH CONTRACTOR.

7) SEE SECT 5409 FOR FOLE BAGE DESIAL.

GENERAL SITE PLAN NOTES

21. ELECTRIC CONDUCTOR SHALL BE SPECIFIED BY RUC OFFERING AND PROVIDING ALL NECESSARY LOADS, PHASES, AND VOLTAGES, AS WELL AS ALL OTHER DATA REGARDING THE ELECTRIC INSTALLATION.

[illegible]

1) REMOVE ALL NECESSARY DISCONNECT AND SPORES FOR ALL SPSB -
COORDINATE ALL BEN CONNECTORS WITH BEN CONNECTOR.

IN AN OUTDOOR STORAGE BUILDING PROVIDE 2-TIME 1/2" MILLING WITH 2500 GRADE BALLASTS CONTROLLED AT 4% PLUS, 5% MINUS AND 1/4" MAXIMUM SIEVE PASSAGE. ALL TESTS FROM CIRCLES 100-6 ETC.