


Richard Molenaar
ARCHITECT

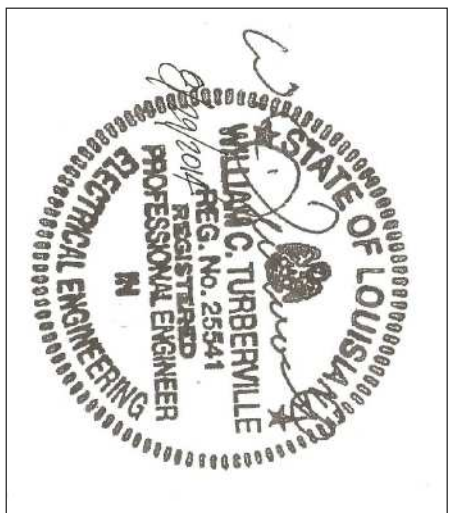

PROJECT NAME:

HOME2
SUITES BY HILTON

W Maine Street West Monroe, Louisiana

SHEET TITLE:

GROUND FLOOR
LIGHTING PLAN

PROJECT NO.:

PROJECT NO. 11-12-14




PROJ#

DRAWN BY: SWJ

SHEET NUMBER:

DATE:

E202

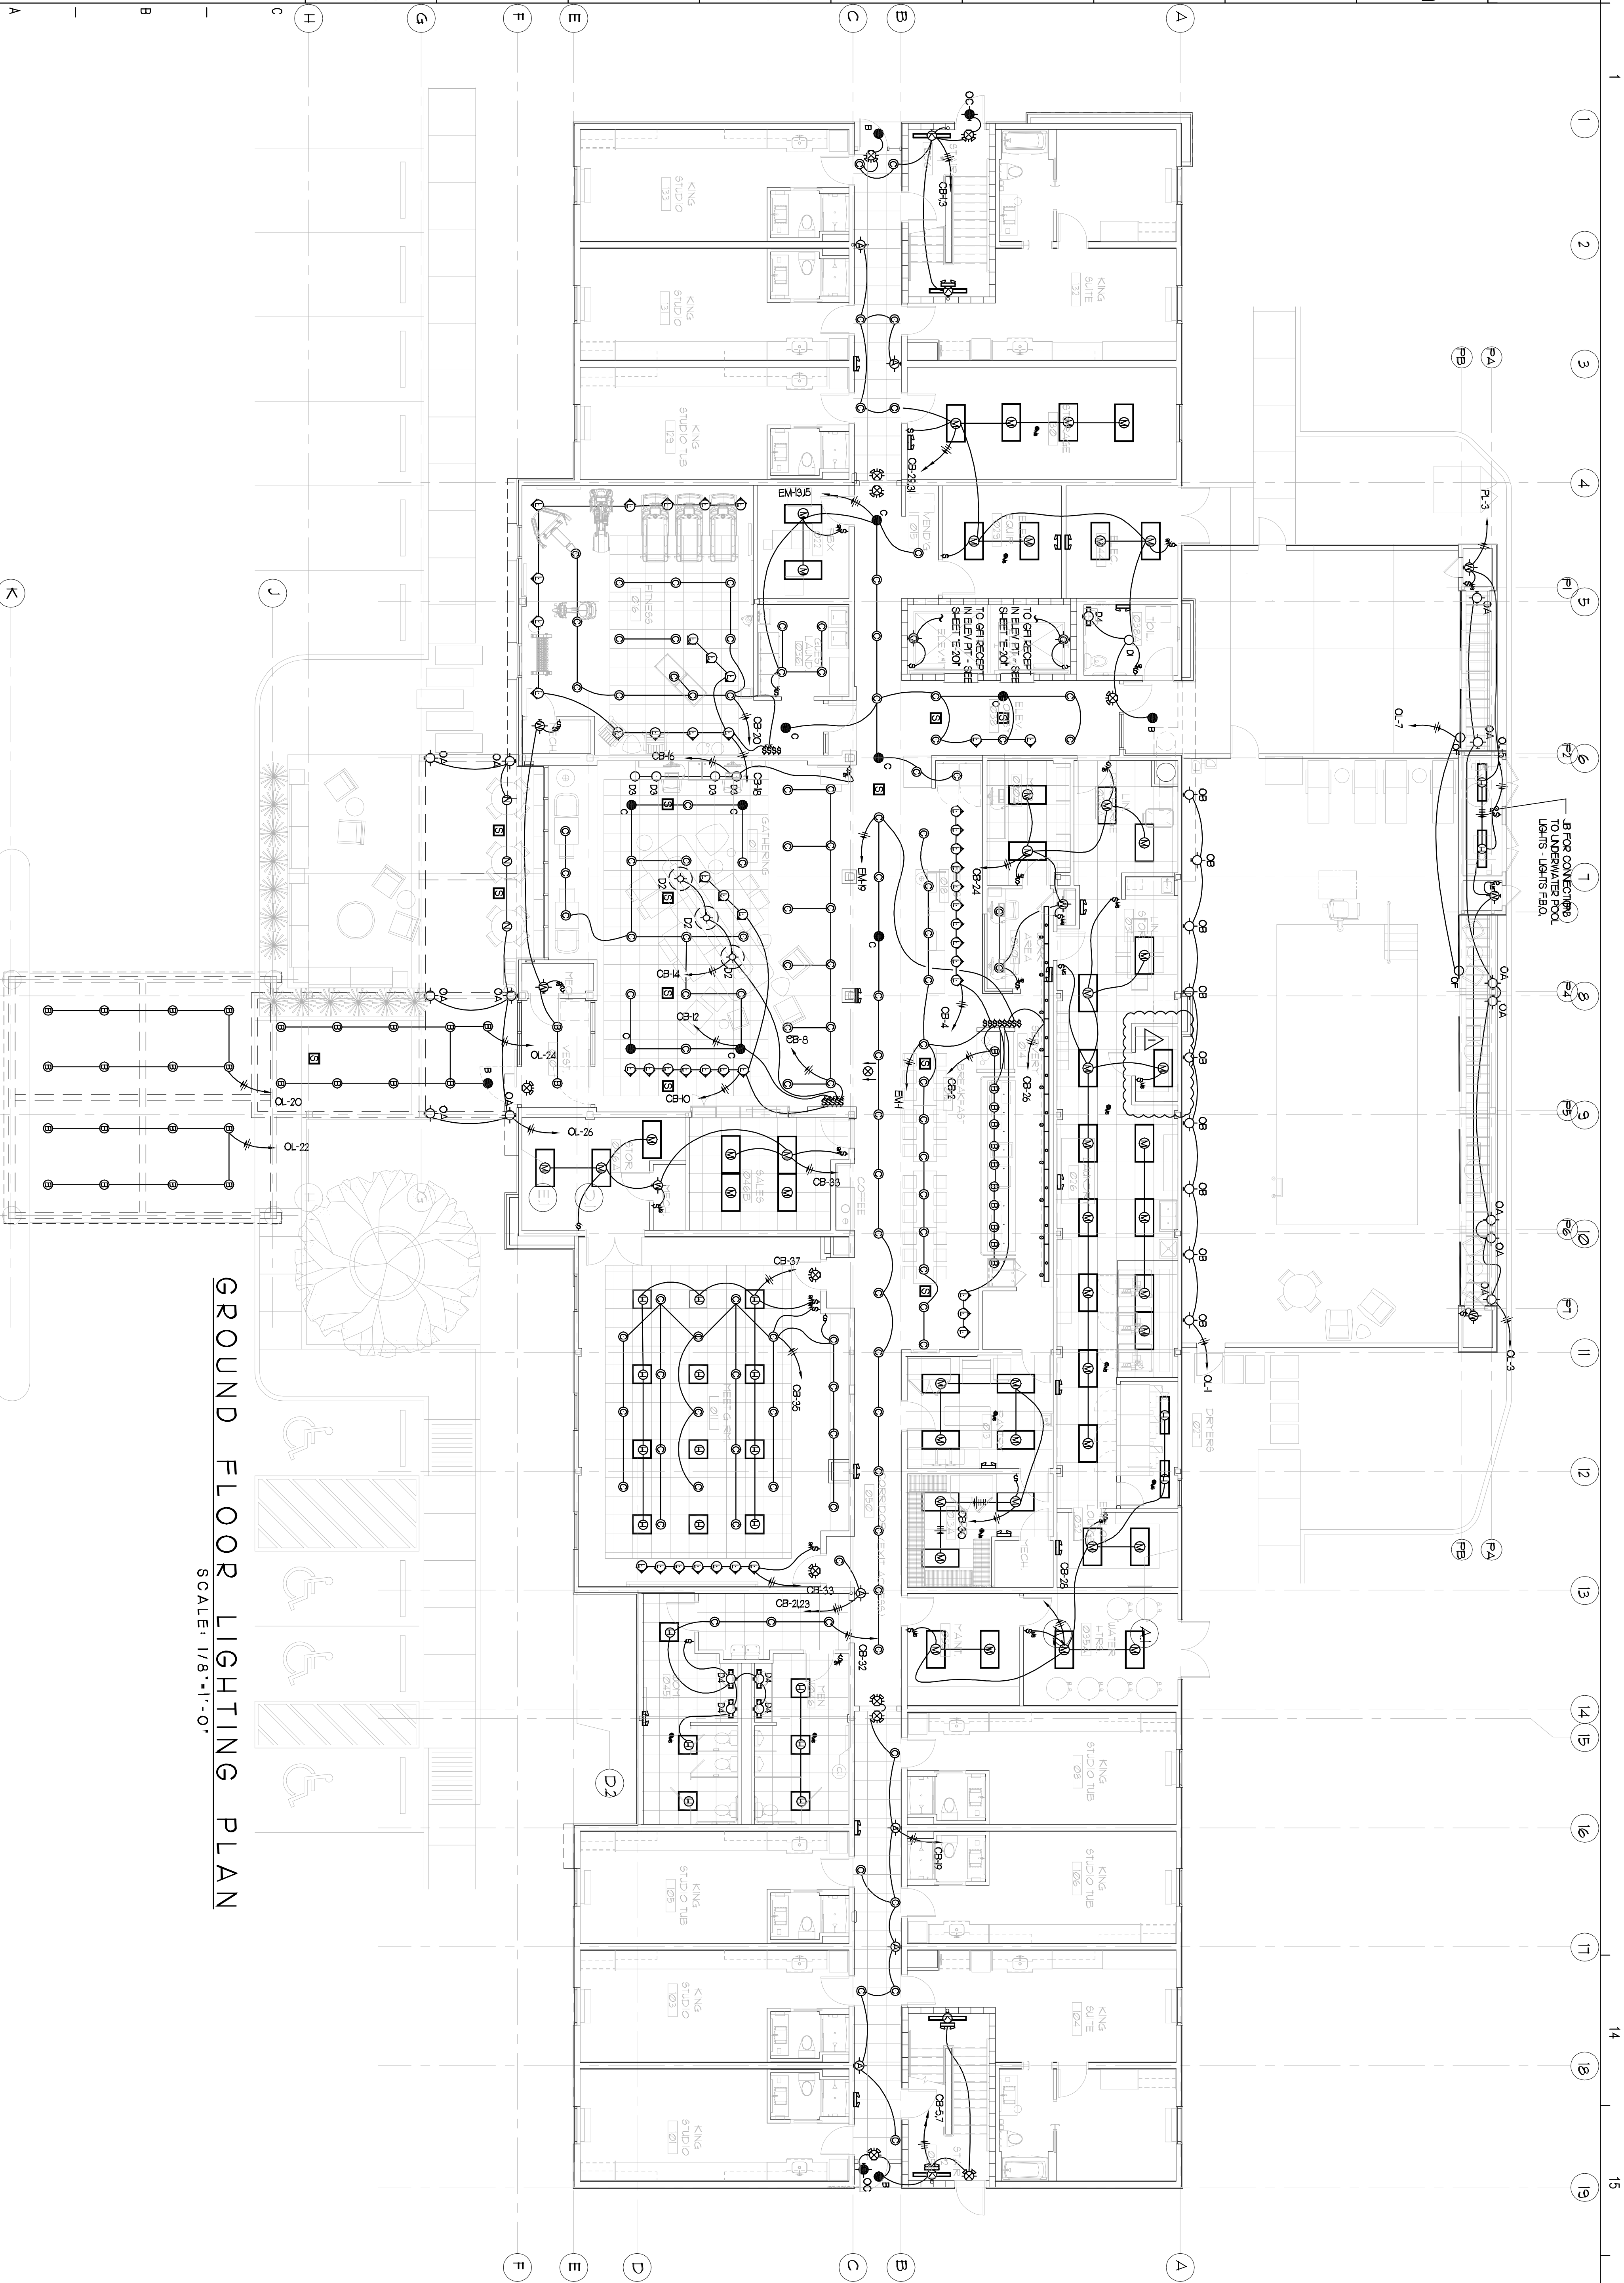

GROUND FLOOR LIGHTING PLAN

SCALE: 1/8"=1'-0"