


Richard Molenaar
ARCHITECT

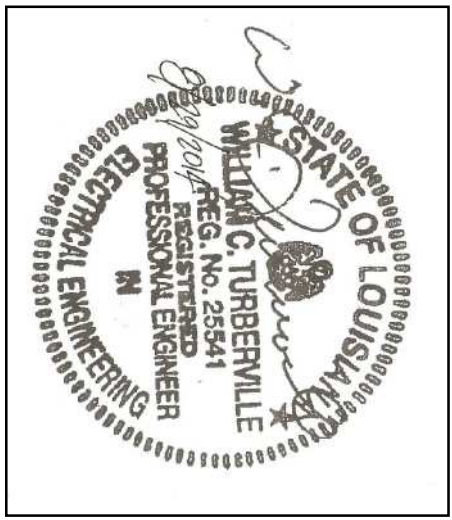

PROJECT NAME:

HOME2
SUITES BY HILTON

W Maine Street West Monroe, Louisiana

SHEET TITLE:

SECOND FLOOR
ELECTRICAL PLAN


PRODUCT NO. LATEST REVISION:

PROJ# 11-12-2014

DRAWN BY: CHECKED BY: SHEET NUMBER:

SMJ SMJ

DATE: **E203**

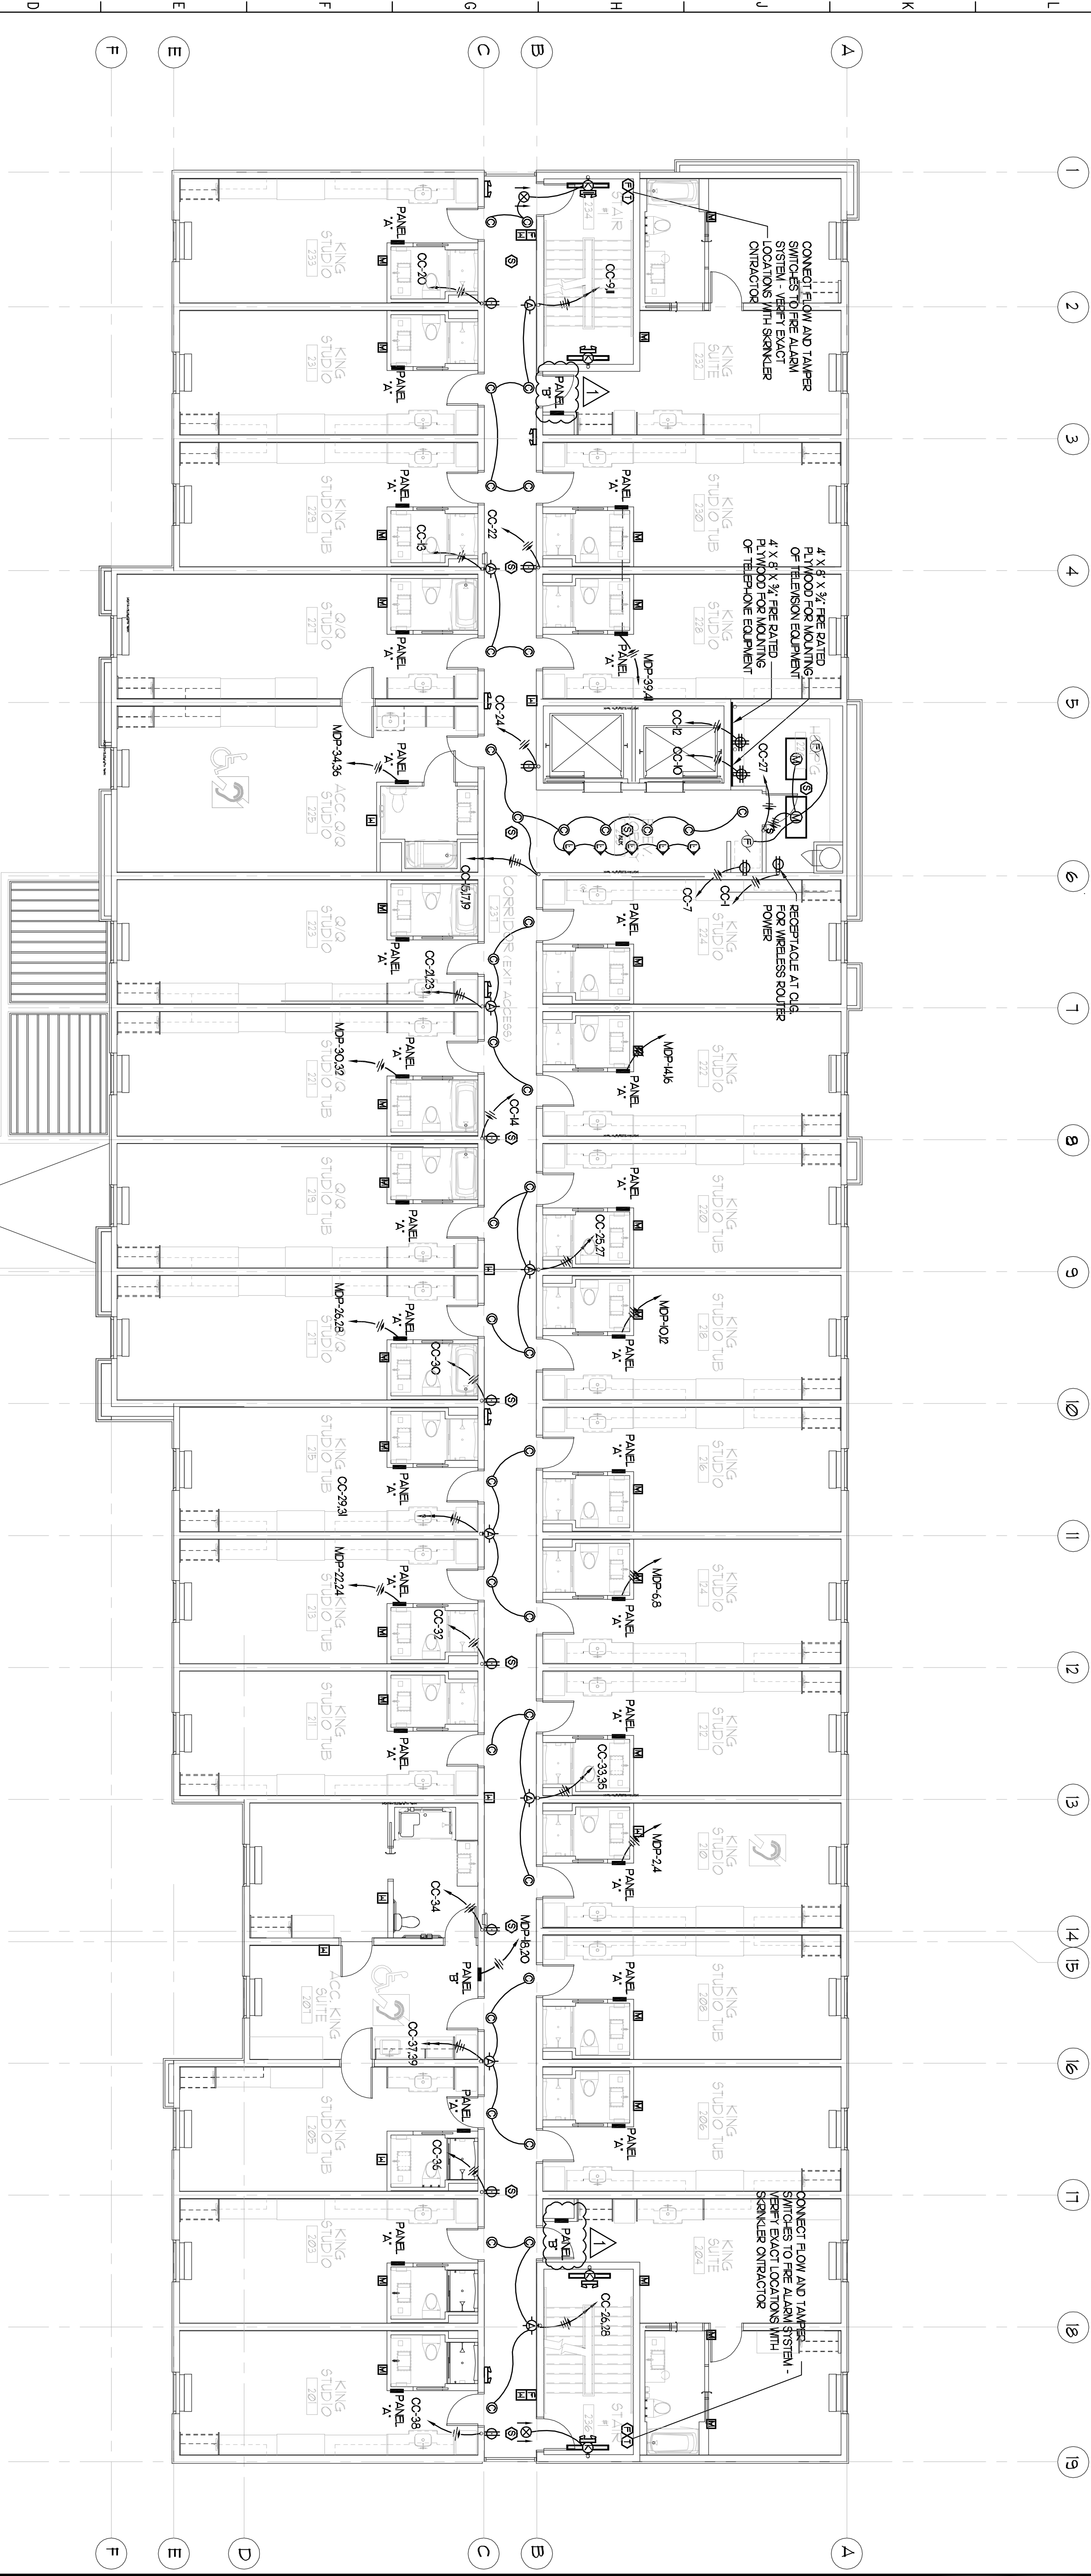

SECOND FLOOR ELECTRICAL PLAN
SCALE: 1/8"=1'-0"

GENERAL NOTES THIS SHEET:
1) INCREASE THE WIRE SIZE A MINIMUM OF ONE SIZE ON ALL ROY HOVER-RUNS OVER 100 FEET IN LENGTH.
INCREASE THE WIRE SIZE A MINIMUM OF ONE SIZE FOR ALL 208V HOVER-RUNS OVER 60 FEET IN LENGTH.

2) VERIFY THE ELECTRICAL REQUIREMENTS OF ALL MECHANICAL EQUIPMENT WITH THE MECHANICAL CONTRACTOR AND HIS SUPPLIER PRIOR TO ROUGH-IN.