


Richard Molenaar
ARCHITECT

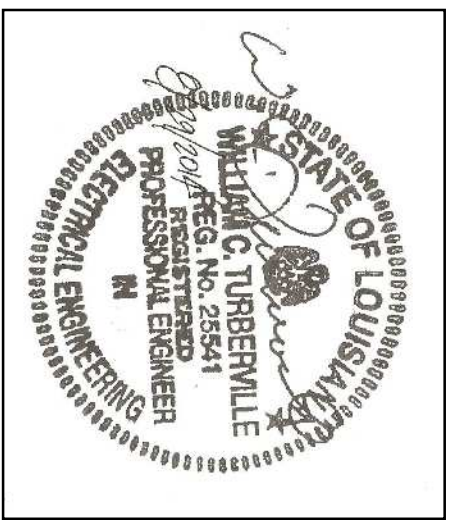

PROJECT NAME:

HOMER2
SUITES BY HILTON

W Maine Street West Monroe, Louisiana


SHEET TITLE:

FOURTH FLOOR
ELECTRICAL PLAN

PROJECT NO. LATEST REVISION:
PROJ# 11-12-2014

DRAWN BY: CHECKED BY: SHEET NUMBER:
SMJ SMJ

DATE: **E205**
DATE:

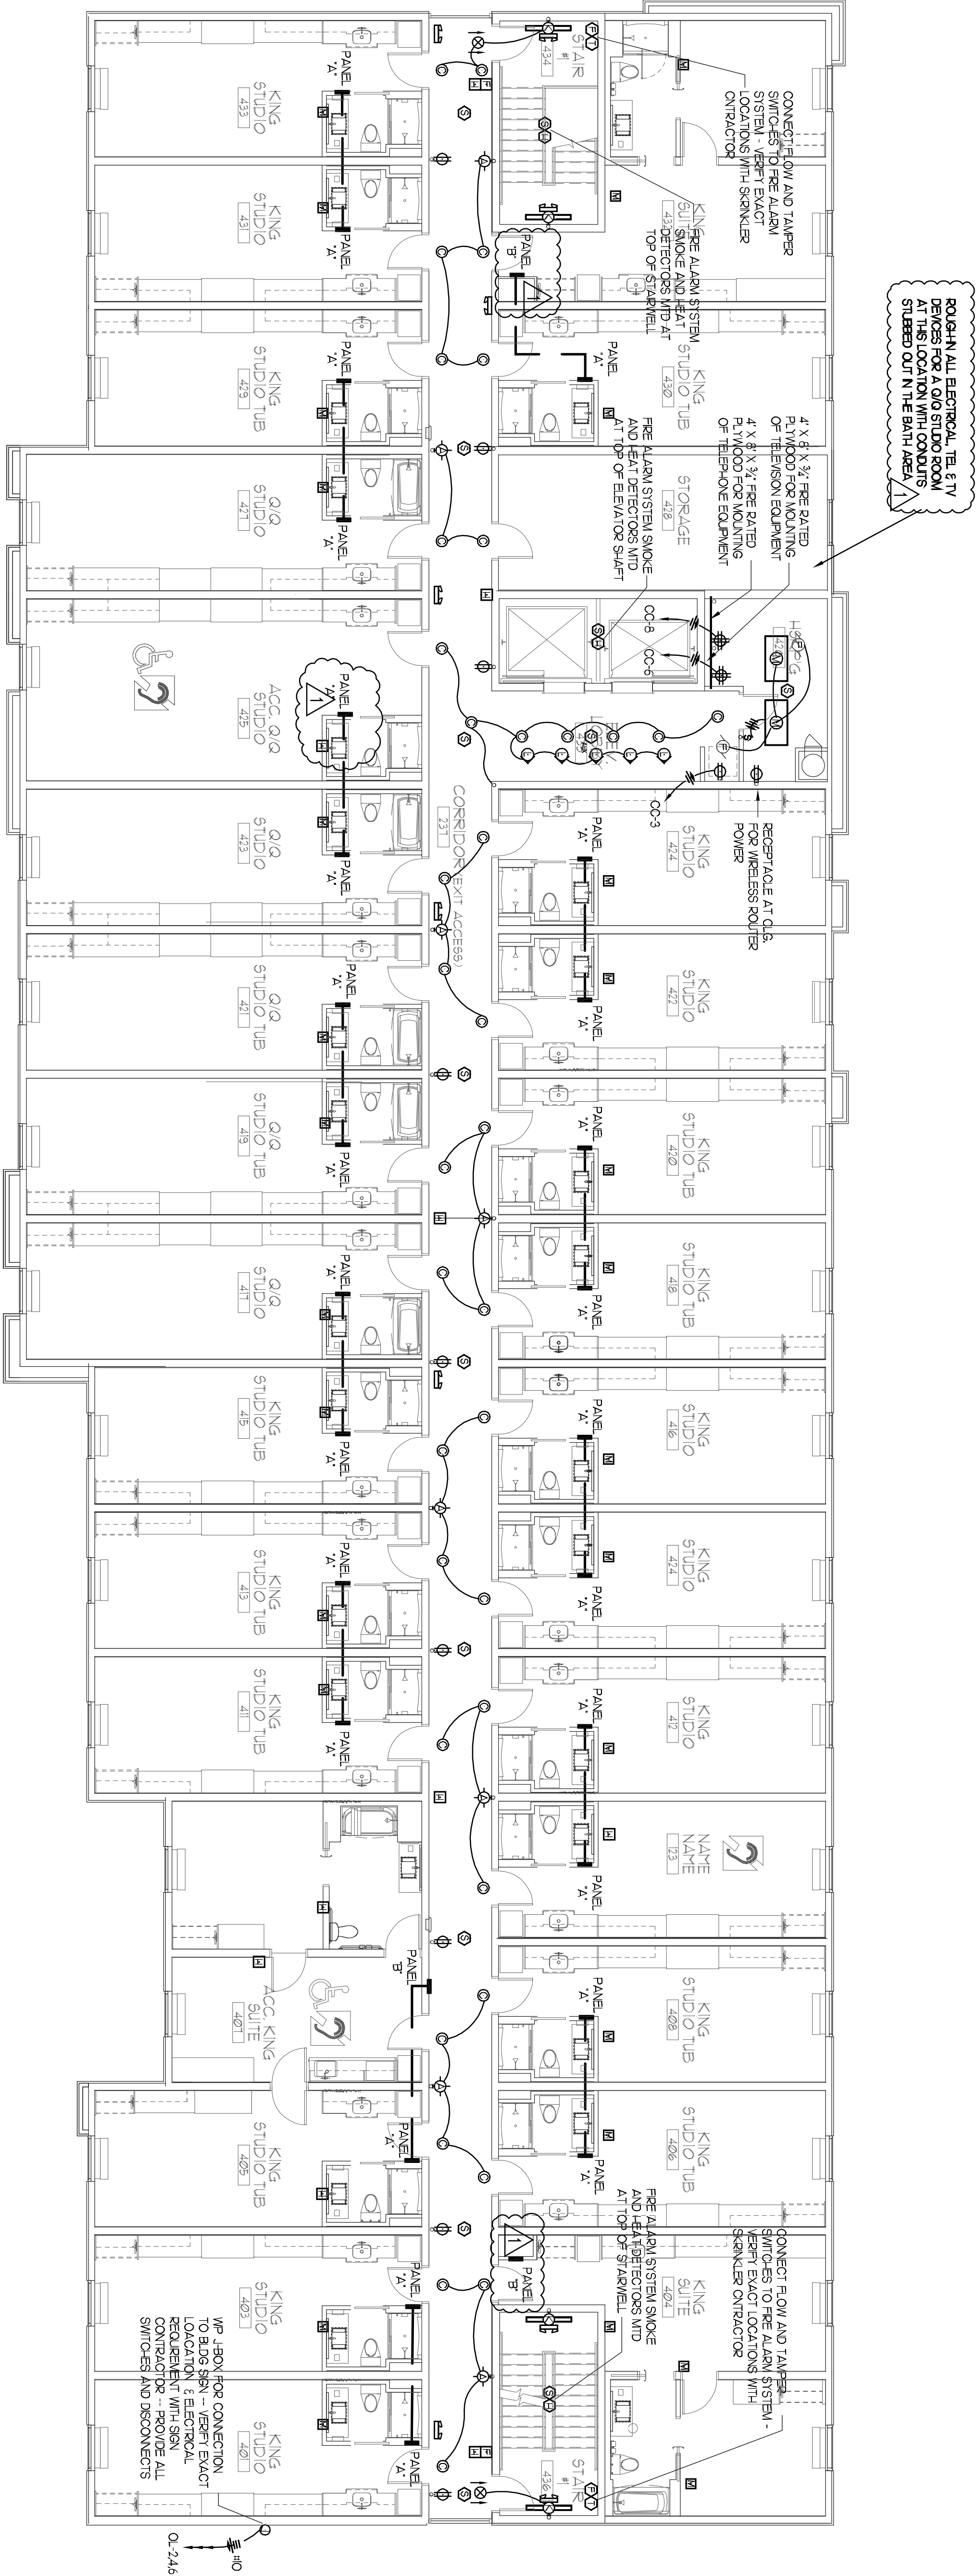

GENERAL NOTES THIS SHEET:
1) INCREASE THE WIRE SIZE A MINIMUM OF ONE SIZE ON ALL 120V, HOWER-RUNS OVER 100 FEET IN LENGTH. INCREASE THE WIRE SIZE A MINIMUM OF ONE SIZE FOR ALL 208V, HOWER-RUNS OVER 150 FEET IN LENGTH.
2) VERIFY THE ELECTRICAL REQUIREMENTS OF ALL MECHANICAL EQUIPMENT WITH THE MECHANICAL CONTRACTOR AND HIS SUPPLIER PRIOR TO ROUGH-IN.

FOURTH FLOOR ELECTRICAL PLAN
SCALE: 1/8"=1'-0"