




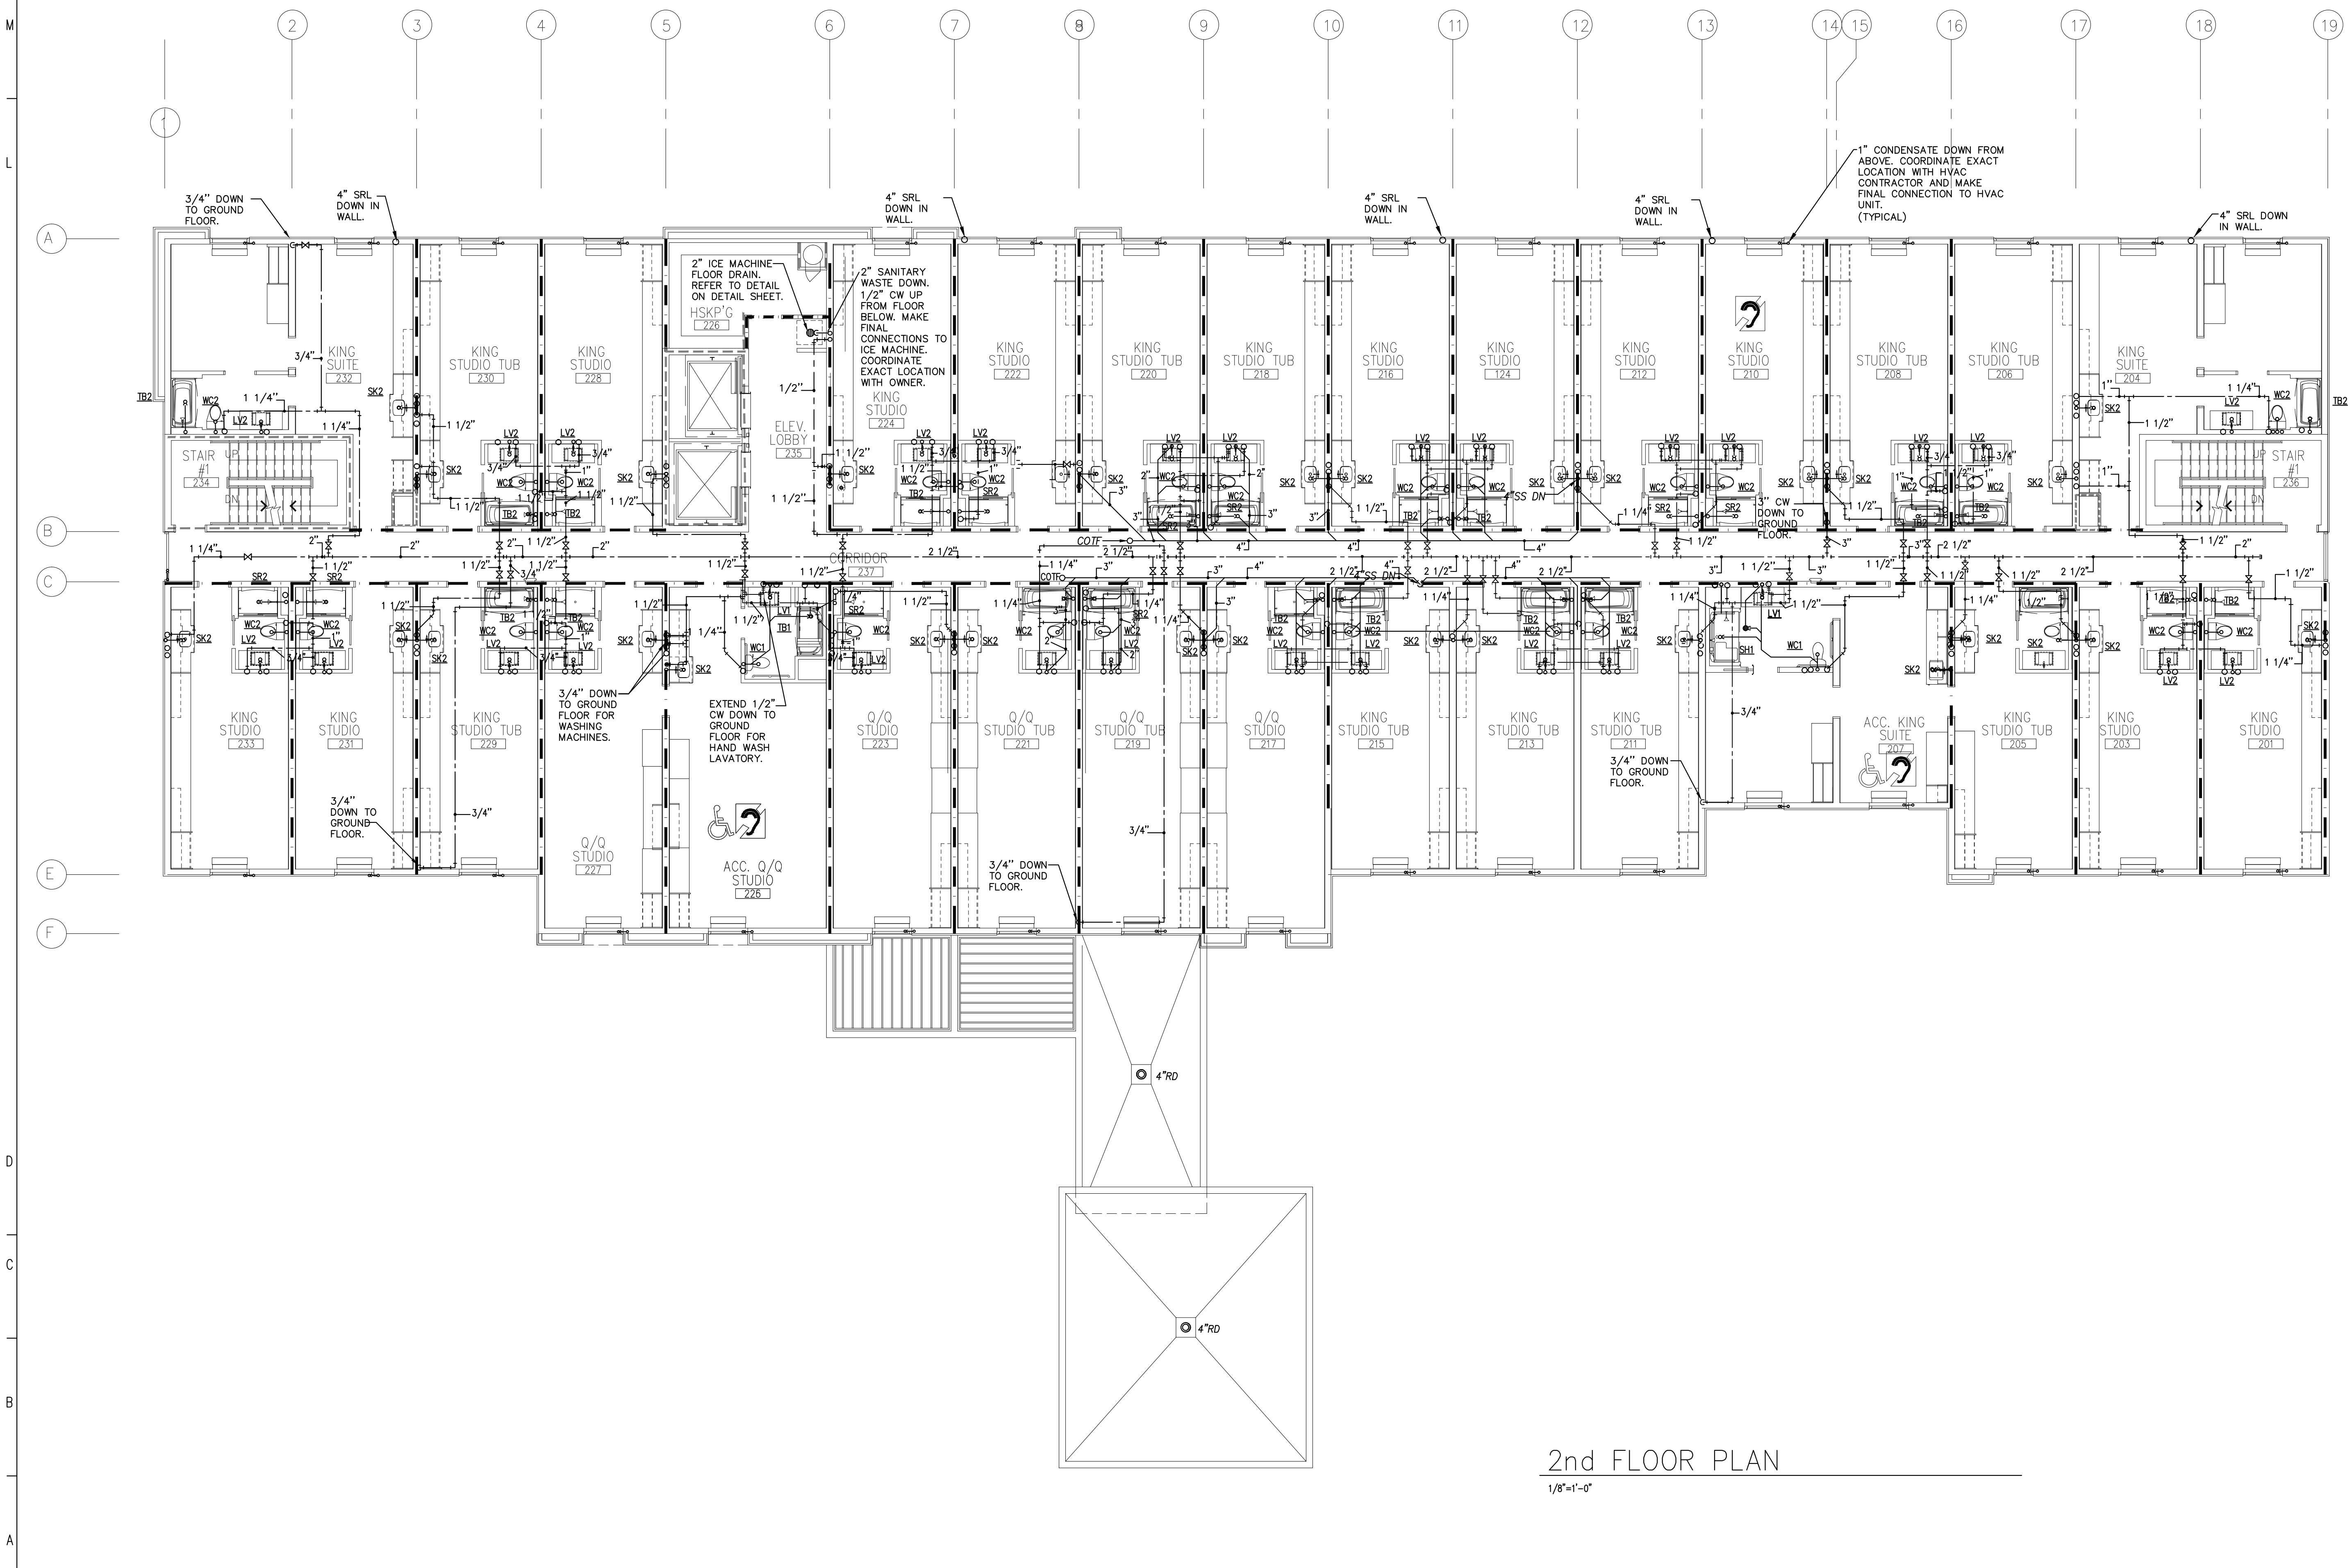

2nd FLOOR PLAN
1/8"=1'-0"

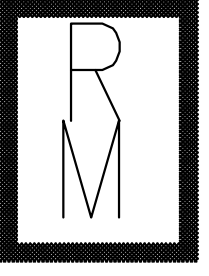

Richard Molenaar
ARCHITECT

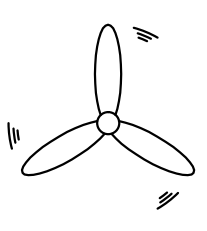

Hertter Mechanical Services

Ryan J. Hertter, P.E., LEED AP
4700 WILD FERN DR
Bartlett, TN 38135
(662) 890-4220



PROJECT NAME:
HOME2
SUITES BY HILTON

W Mane Street West Monroe, Louisiana

SHEET TITLE:
2nd FLOOR PLUMBING

PROJECT NO.	LATEST REVISION: 10-06-14	1
DRAWN BY: AO	CHECKED BY: RH	SHEET NUMBER: P102
DATE: NOV. 12, 2014		