

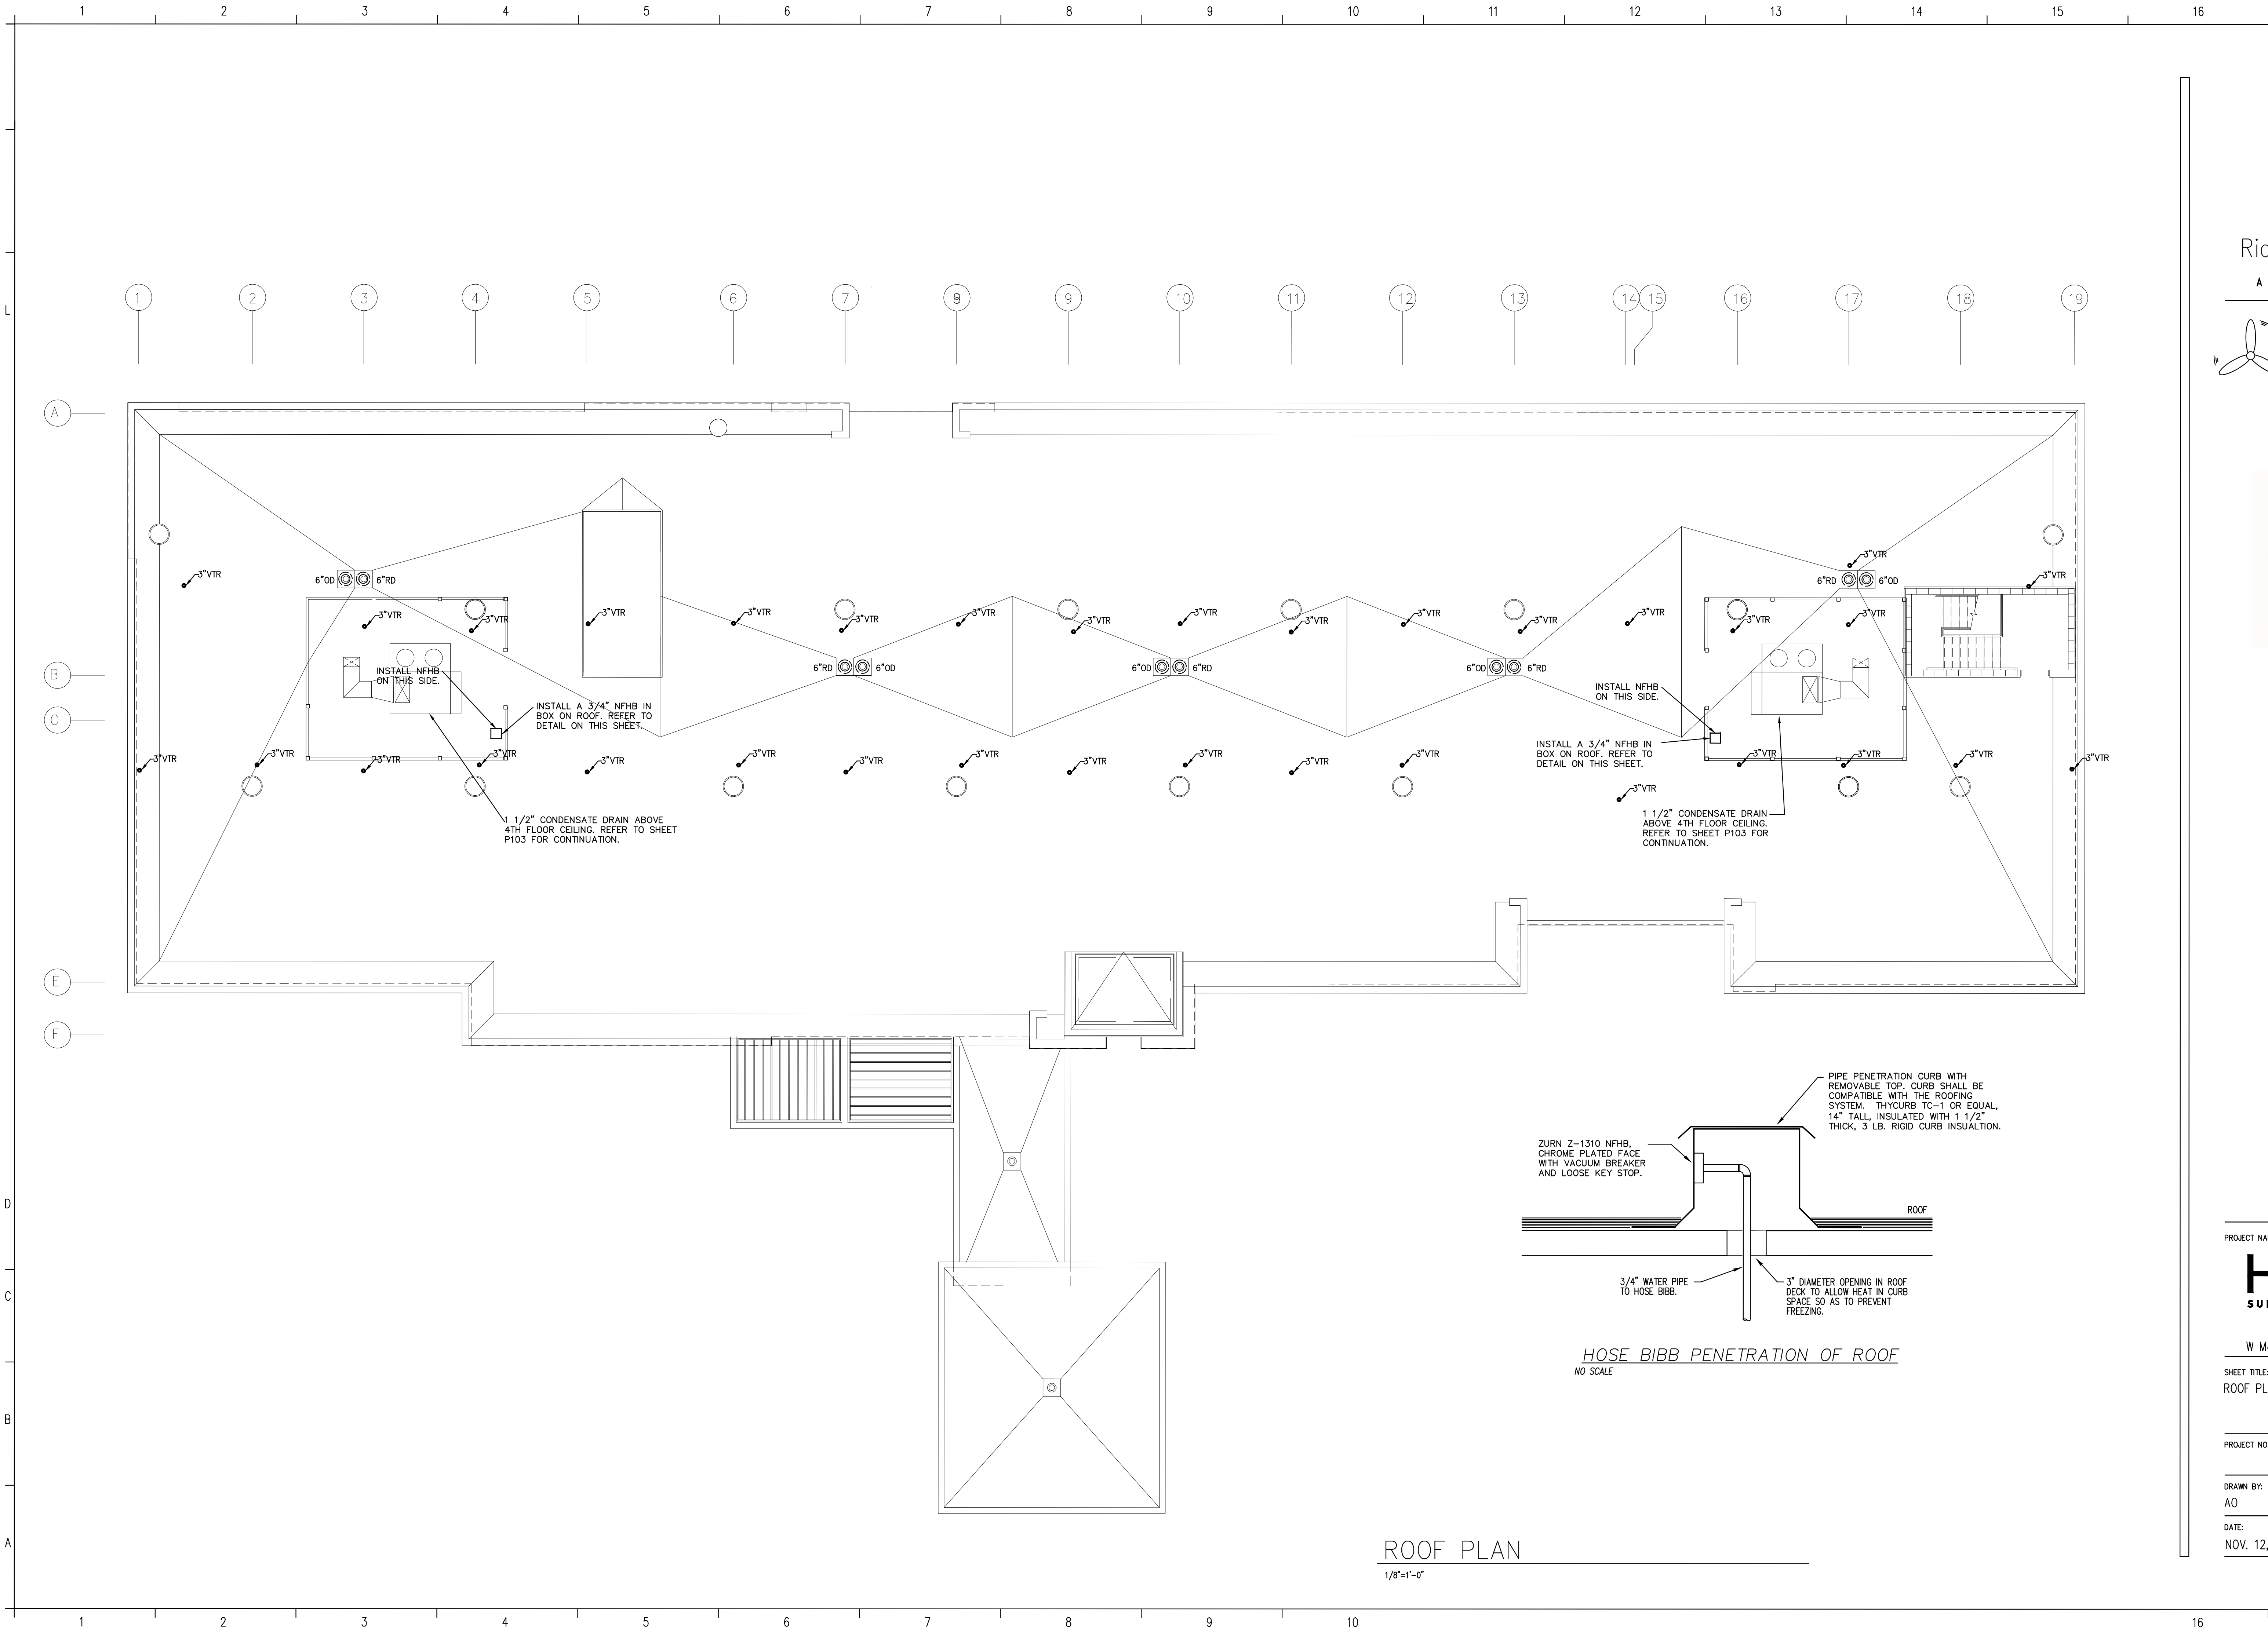


Richard Molenaar
ARCHITECT

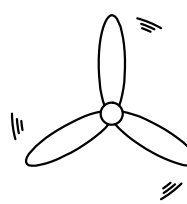

Hertter Mechanical Services

Ryan J. Hertter, P.E., LEED AP
4700 WILD FERN DR
Bartlett, TN 38135
(662) 890-4220

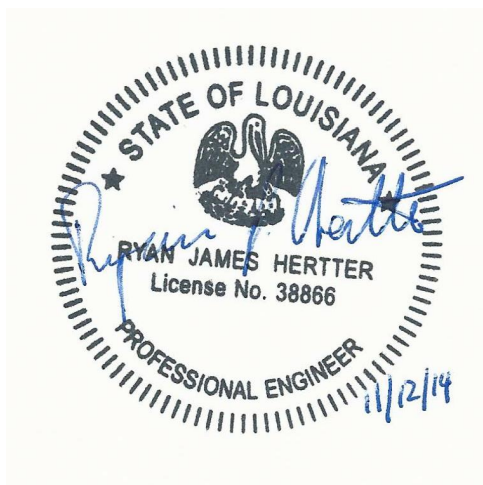

PROJECT NAME:



W Mane Street West Monroe, Louisiana

SHEET TITLE:

ROOF PLAN PLUMBING

PROJECT NO.

LATEST REVISION:
10-06-14



DRAWN BY:

CHECKED BY:

SHEET NUMBER:

DATE:

NOV. 12, 2014

P104