


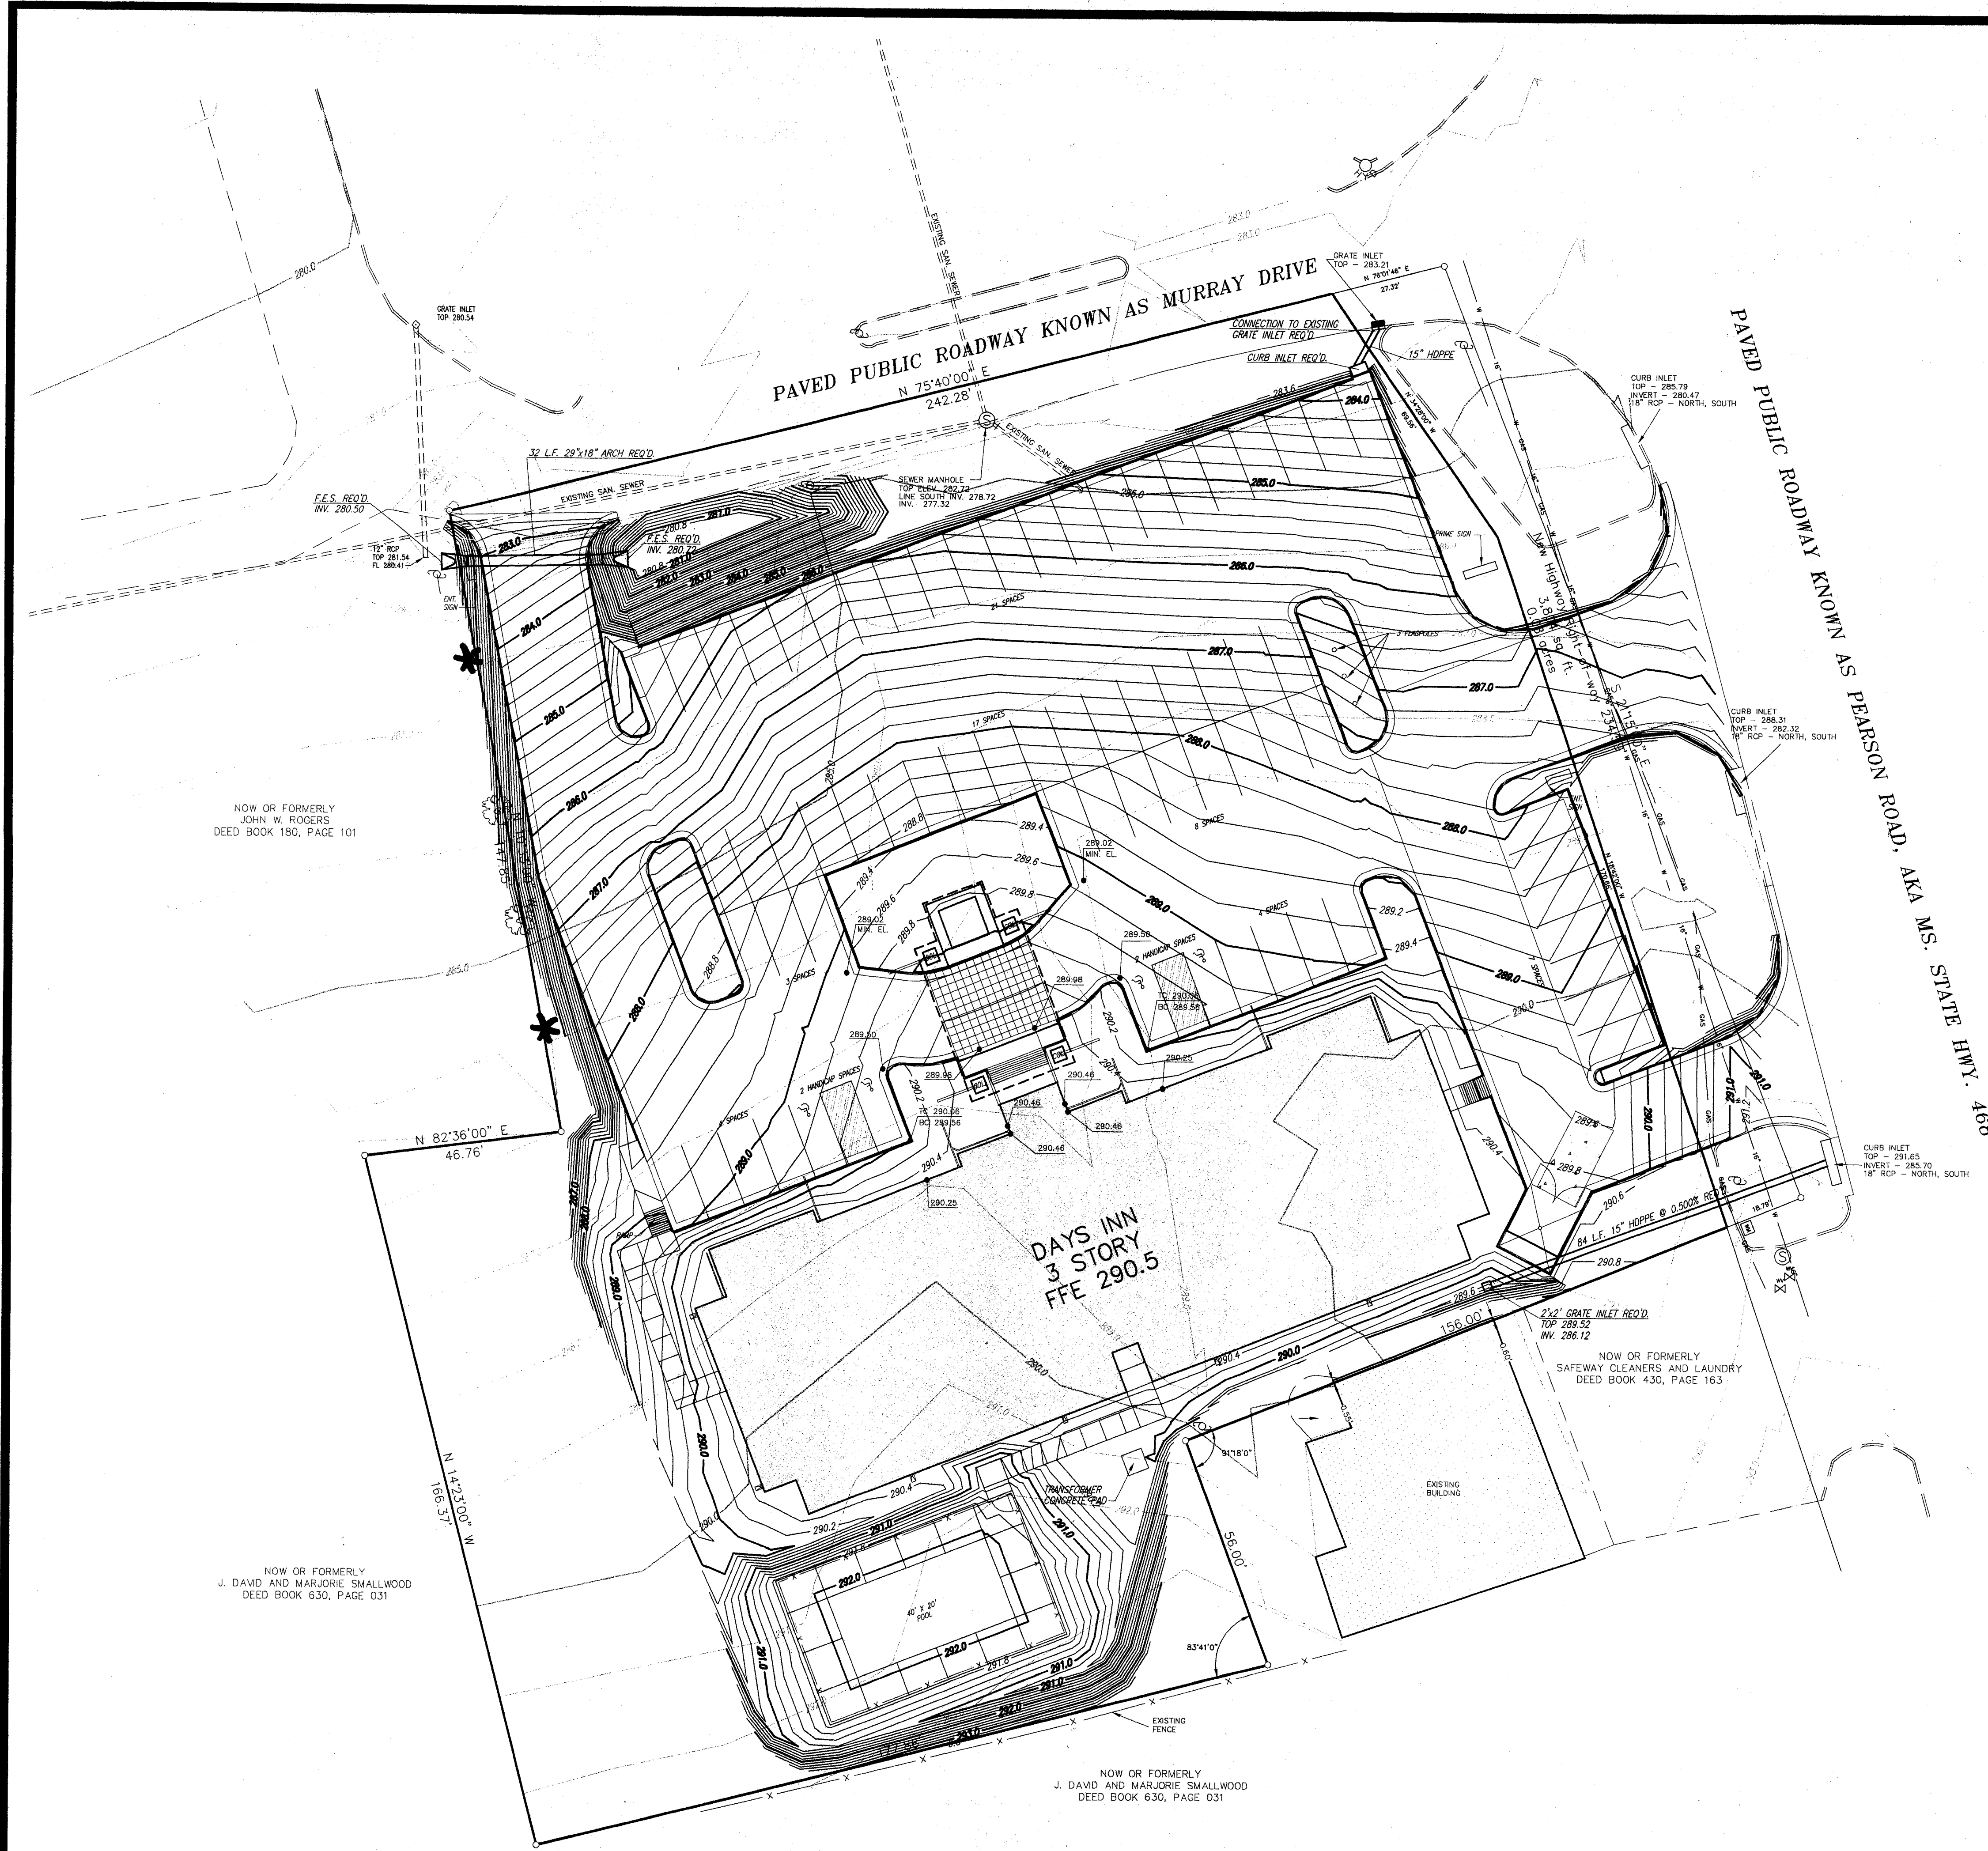

- NOTES:
1. GENERAL CONTRACTOR SHALL NOTIFY THE CITY OF PEARL PUBLIC WORKS DEPARTMENT AT LEAST 24 HOURS PRIOR TO ANY CONNECTION INTO CITY UTILITIES AND STREET.
 2. GENERAL CONTRACTOR SHALL CONTACT MISSISSIPPI ONE CALL SYSTEM (601 362-4374) TO LOCATE AND MARK ALL UNDERGROUND UTILITIES BEFORE ANY EXCAVATION IS PERFORMED ON SITE.



GRAPHIC SCALE



(IN FEET)
1 inch = 20 ft.

**DAYS INN
PEARSON ROAD
PEARL, MISSISSIPPI**

GRADING AND DRAINAGE PLAN

**CITY OF PEARL
RANKIN COUNTY, MISSISSIPPI**

DSGN: RGV	DATE: 3/11/99		DRAWING NO. C2 OF 4
DRWN: GDB	DATE: 3/11/99		
CHKD: RGV	DATE: 3/11/99		
SCALE: 1"=20'			

\\drawings\daysinn\days-001.dwg Fr1 Mar 19 10:39:22 1999 R. David Bates - Sterling Consultants, Inc.