


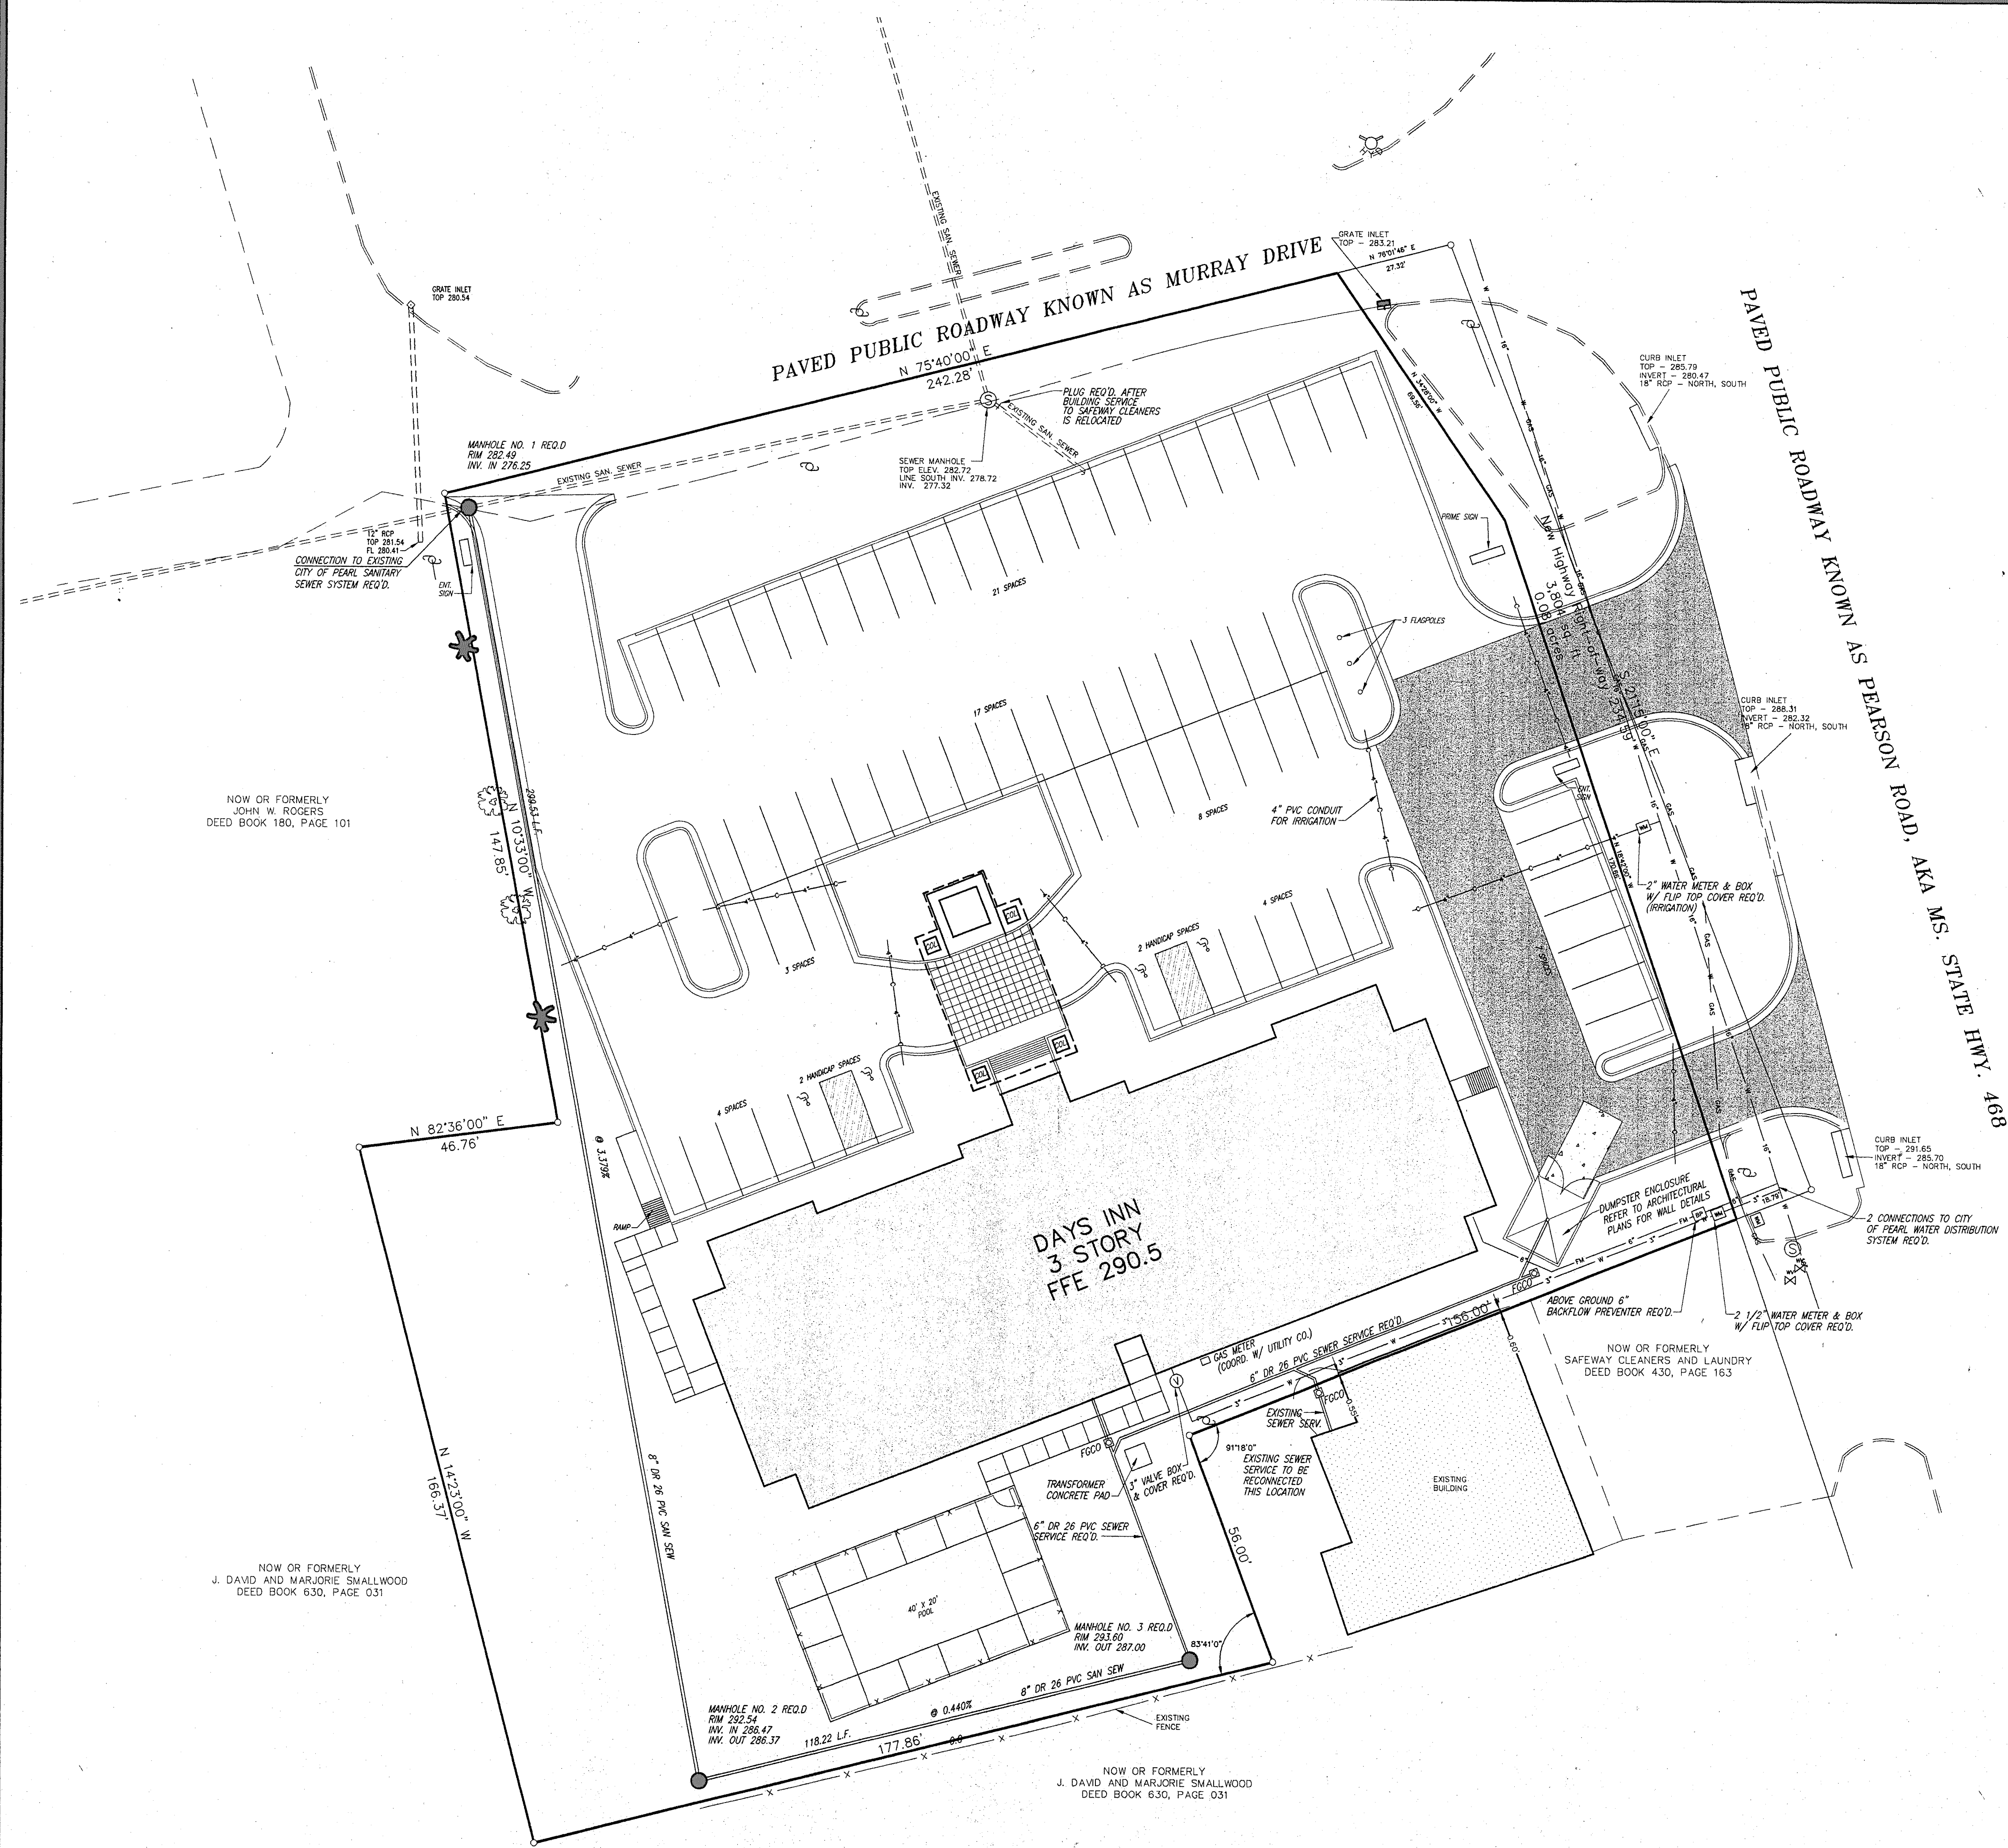

- NOTES:
1. GENERAL CONTRACTOR SHALL NOTIFY THE CITY OF PEARL PUBLIC WORKS DEPARTMENT AT LEAST 24 HOURS PRIOR TO ANY CONNECTION INTO CITY UTILITIES AND STREET.
 2. GENERAL CONTRACTOR SHALL CONTACT MISSISSIPPI ONE CALL SYSTEM (601 362-4374) TO LOCATE AND MARK ALL UNDERGROUND UTILITIES BEFORE ANY EXCAVATION IS PERFORMED ON SITE.
 3. CONTRACTOR SHALL INSTALL THE SANITARY SEWER SERVICE AND RECONNECT BUILDING SERVICE FROM SAFEWAY CLEANERS PRIOR TO SITE GRADING ACTIVITIES.
 4. CONTRACTOR SHALL INSTALL CONDUIT UNDER PAVEMENT AREAS FOR IRRIGATION SYSTEM AS SHOWN. MINIMUM DEPTH OF COVER SHALL BE 42". CONTRACTOR SHALL COORDINATE INSTALLATION OF CONDUIT FOR OTHER UTILITIES AS SHOWN ON OTHER SITE PLANS.
 5. REFER TO PLUMBING AND ELECTRICAL PLANS FOR EXACT LOCATION OF TIE-INS FOR BUILDING SERVICES.

LEGEND

— W —	WATER LINE
— F —	FIRE MAIN
— C —	CONDUIT FOR IRRIGATION
⊞	WATER METER
⊞	BACKFLOW PREVENTER
⊞	WATER VALVE
⊞	FINISH GRADE CLEANOUT

GRAPHIC SCALE

0 10 20 30 40 50 60 70 80

(IN FEET)

1 inch = 20 ft.

SEAL: J. DAVID AND MARJORIE SMALLWOOD, MISSISSIPPI, 110744, 1/19/99

**DAYS INN
PEARSON ROAD
PEARL, MISSISSIPPI**

SITE UTILITY LAYOUT

**CITY OF PEARL
RANKIN COUNTY, MISSISSIPPI**

DSGN: RCV	DATE: 3/11/99		DRAWING NO. C3 of 4
DRWN: GDB	DATE: 3/11/99		
CHKD: RCV	DATE: 3/11/99		
SCALE: 1"=20'			

\\aradings\days\days-001.dwg Fri Mar 19 10:39:44 1999 R. David Bates - Sterling Consultants, Inc.